

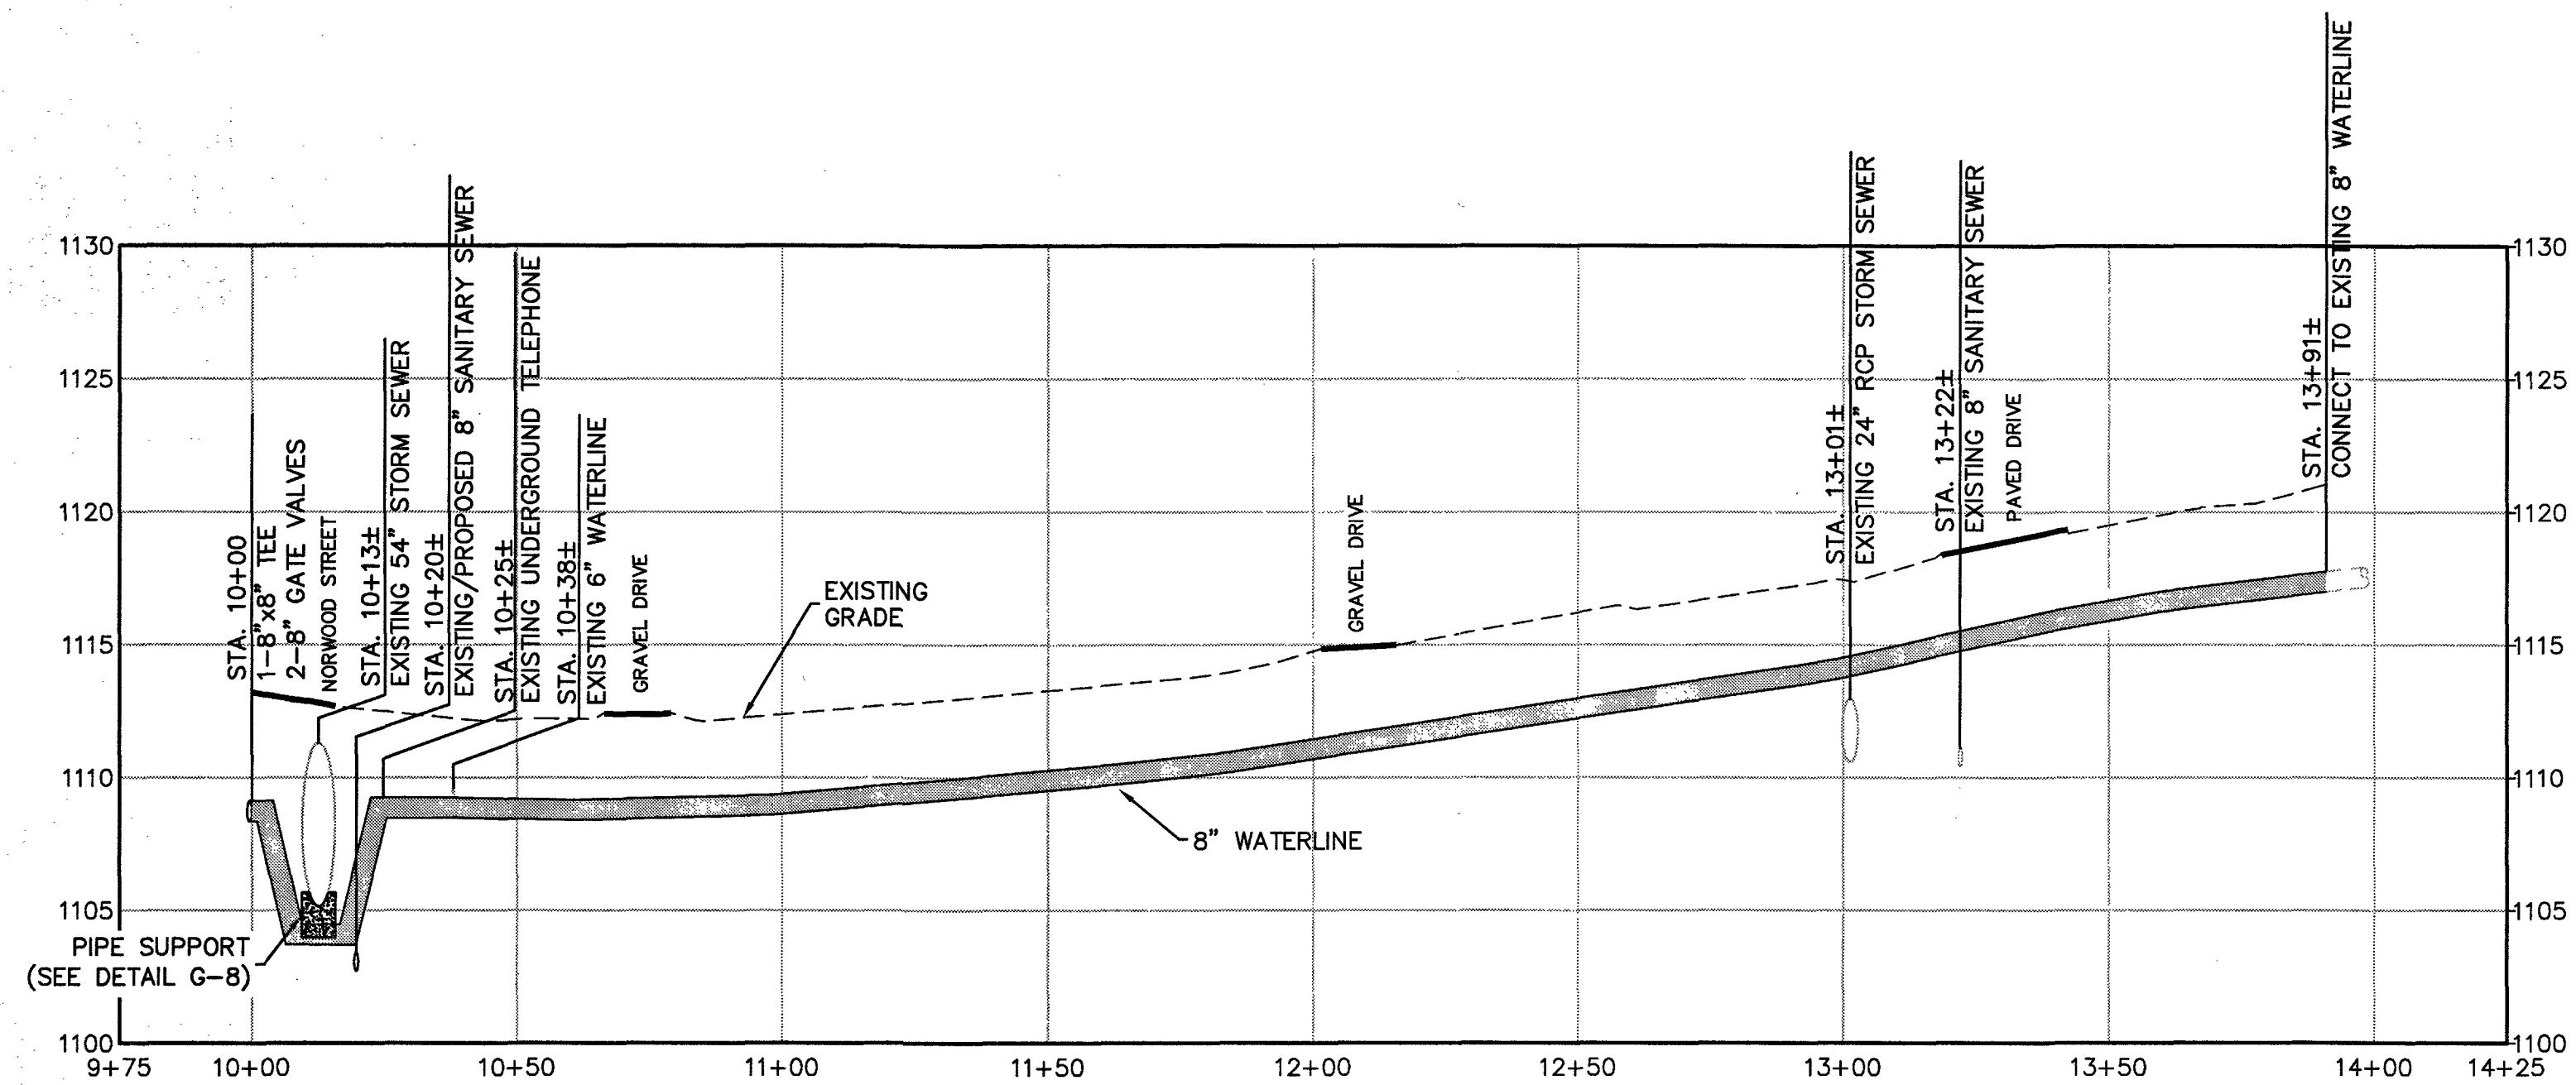


P:\11132B\11132B-04B\11132B-04B.dwg 11/13/2011 11:28:05 AM 11132B-04B.dwg 11/13/2011 11:28:05 AM

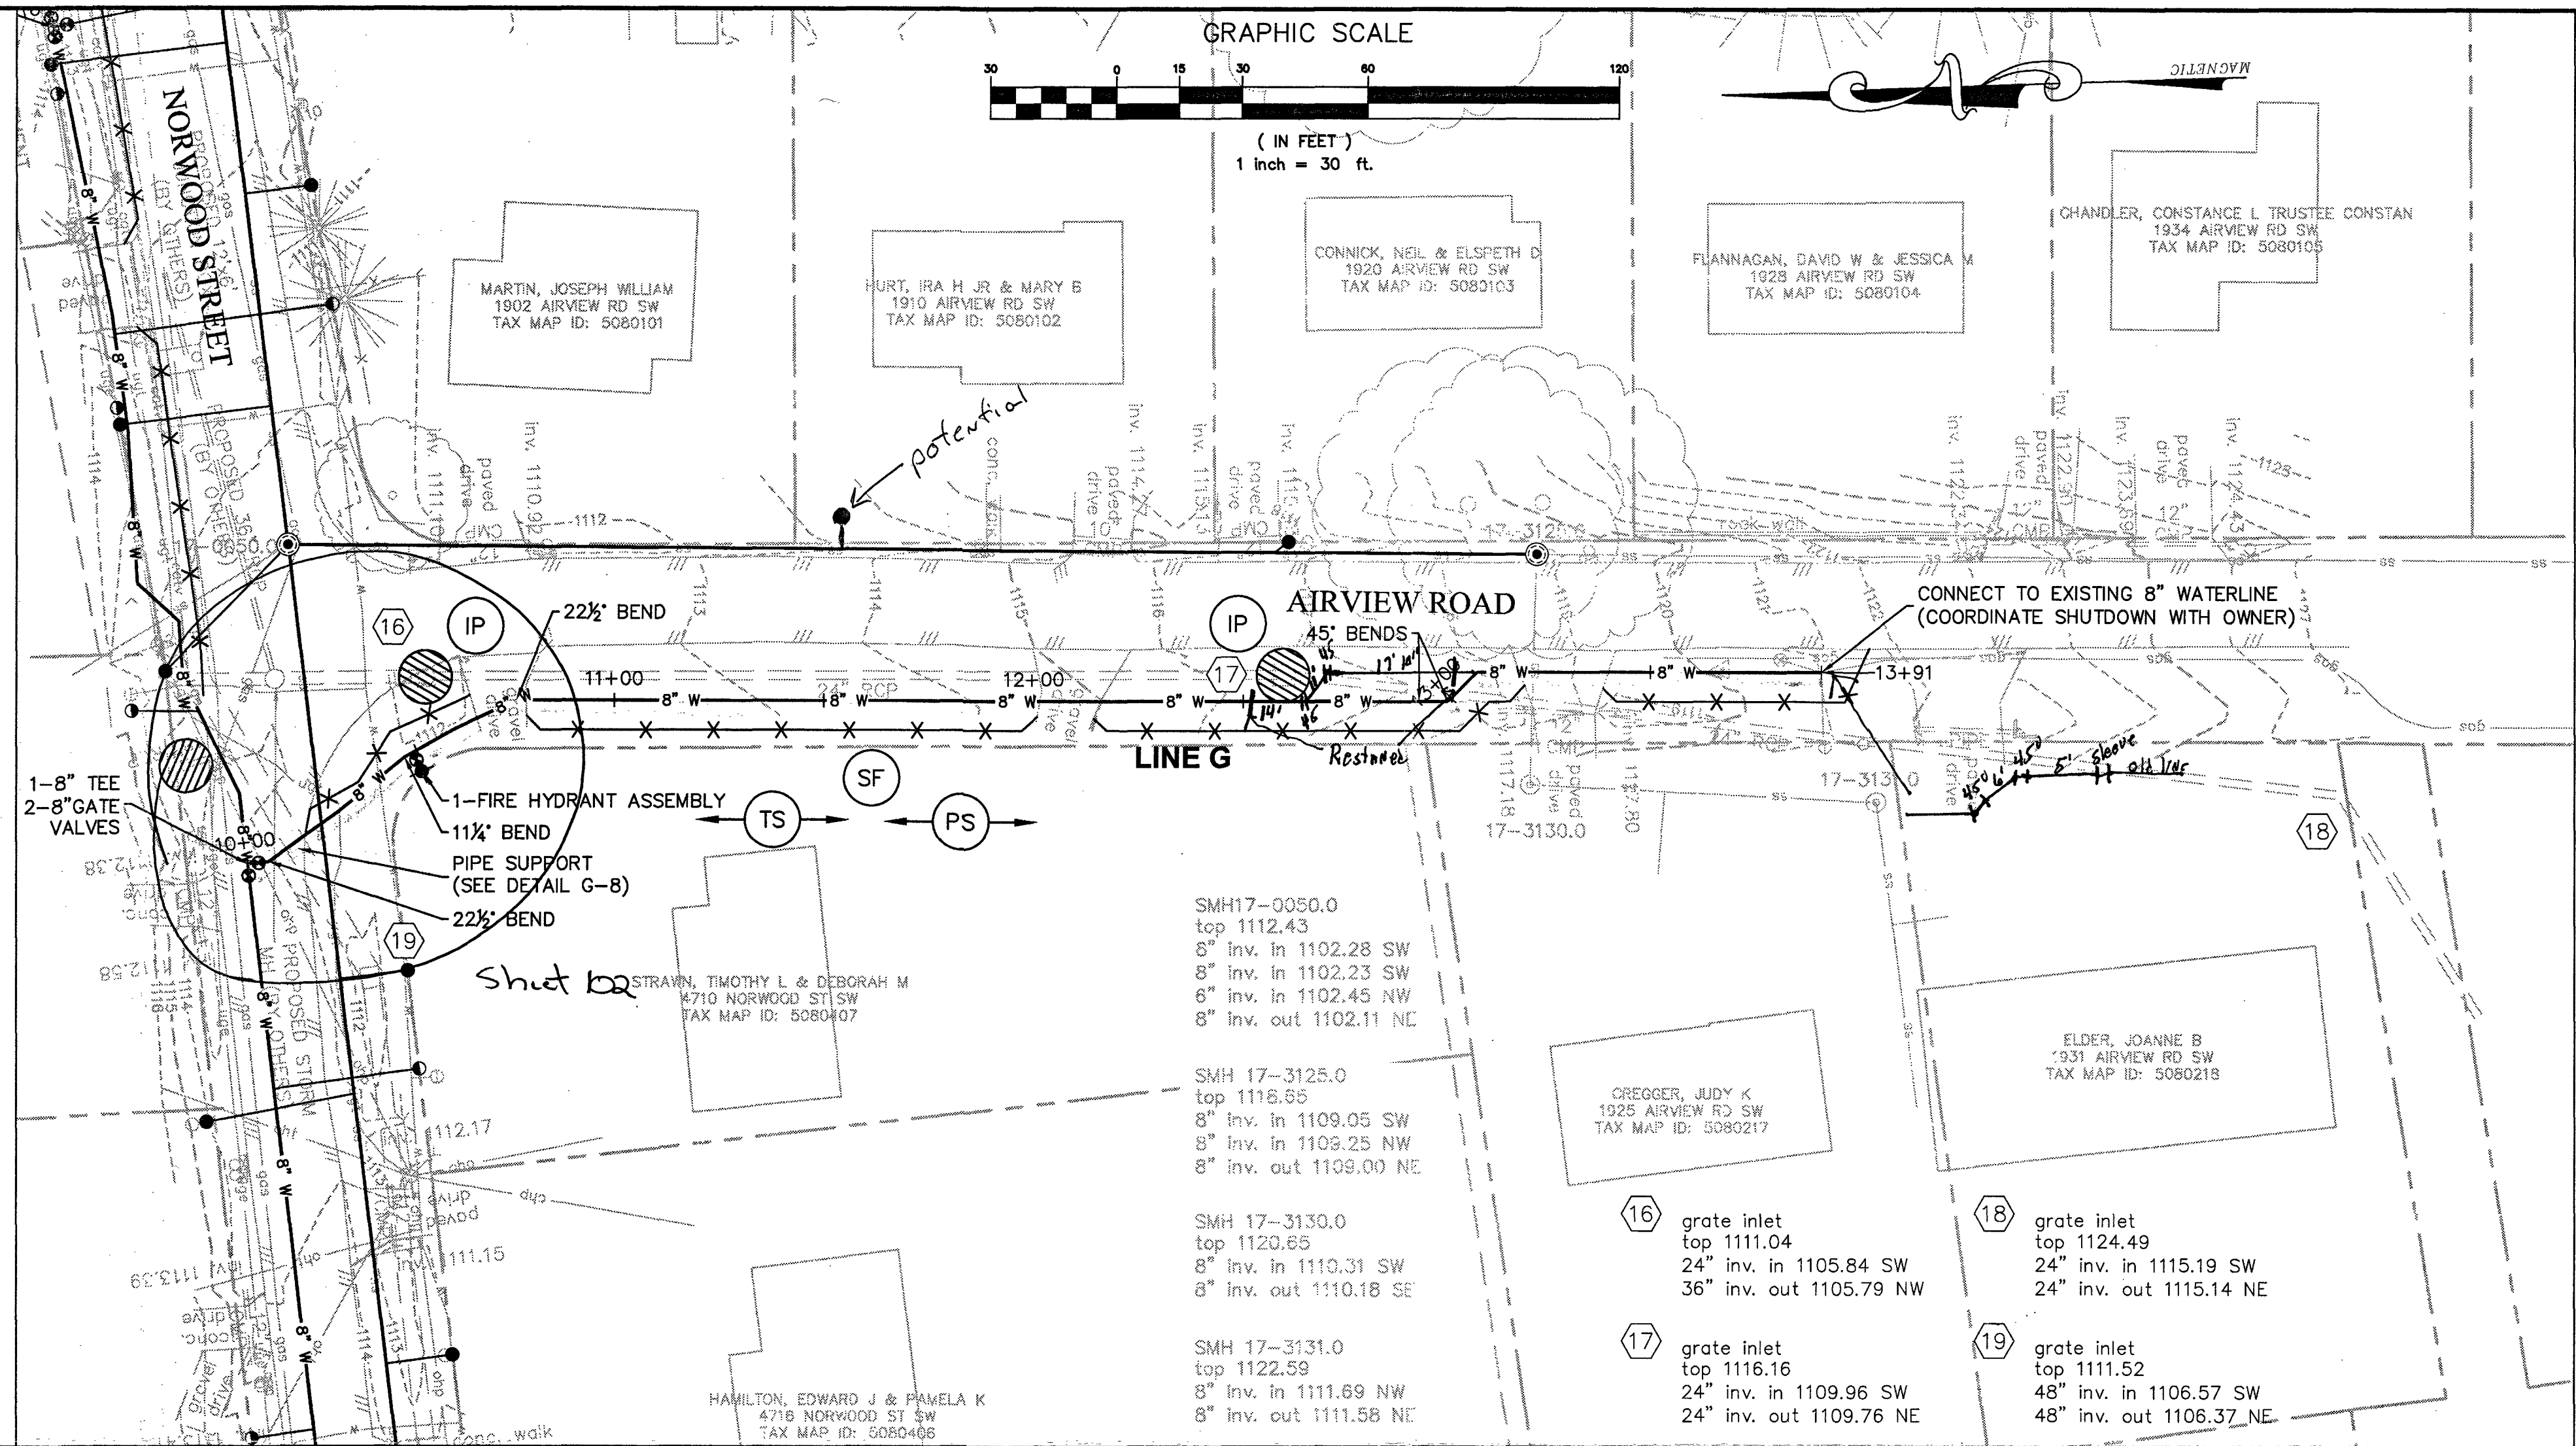


LINE G PROFILE
SCALE: H: 1"=30' V: 1"=6'

NOTE: CONTRACTOR SHALL LOCATE AND VERIFY EXISTING METER LOCATION PRIOR TO INSTALLING NEW METER BOX. SOME NEW METER LOCATIONS SHOWN ON THE PLANS ARE APPROXIMATE.

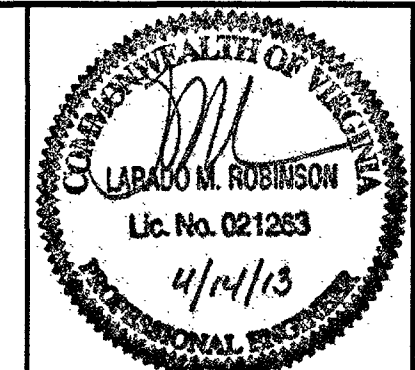

Draper Aden Associates
Engineering • Surveying • Environmental Services
2206 South Main Street
Blacksburg, VA 24060
540-552-0444 Fax: 540-552-0291

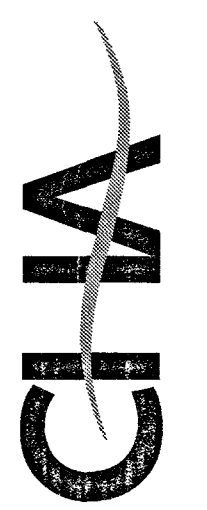

WATER PLAN AND PROFILE - LINE G
WESTERN VIRGINIA WATER AUTHORITY FY2011
VCWRLF COLLECTION SYSTEM PROJECTS
MURDOCK CREEK WATER AND SEWER REPLACEMENT
ROANOKE, VIRGINIA

REVISIONS	
DESIGNED BY:	JSL
DRAWN BY:	BMC
CHECKED BY:	LMR
SCALE:	H: 1"=30' V: 1"=6'
DATE:	04/14/13
PROJECT NUMBER:	B11132B-04B/05
C-111	