






Draper Aden Associates
Engineering • Surveying • Environmental Services
2206 South Main Street
Blacksburg, VA 24060
540-552-0444 Fax: 540-552-0291

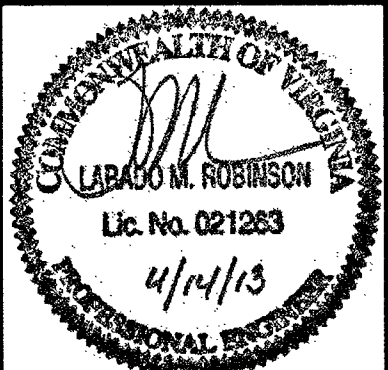

SEWER PLAN AND PROFILE
WESTERN VIRGINIA WATER AUTHORITY FY2011
VCWRLF COLLECTION SYSTEM PROJECTS
MURDOCK CREEK
ROANOKE, VIRGINIA

REVISIONS	
DESIGNED BY:	LMR
DRAWN BY:	BMC
CHECKED BY:	LMR
SCALE:	H: 1"=30' V: 1"=6'
DATE:	04/14/13
PROJECT NUMBER:	B11132B-04B/05
C-116	

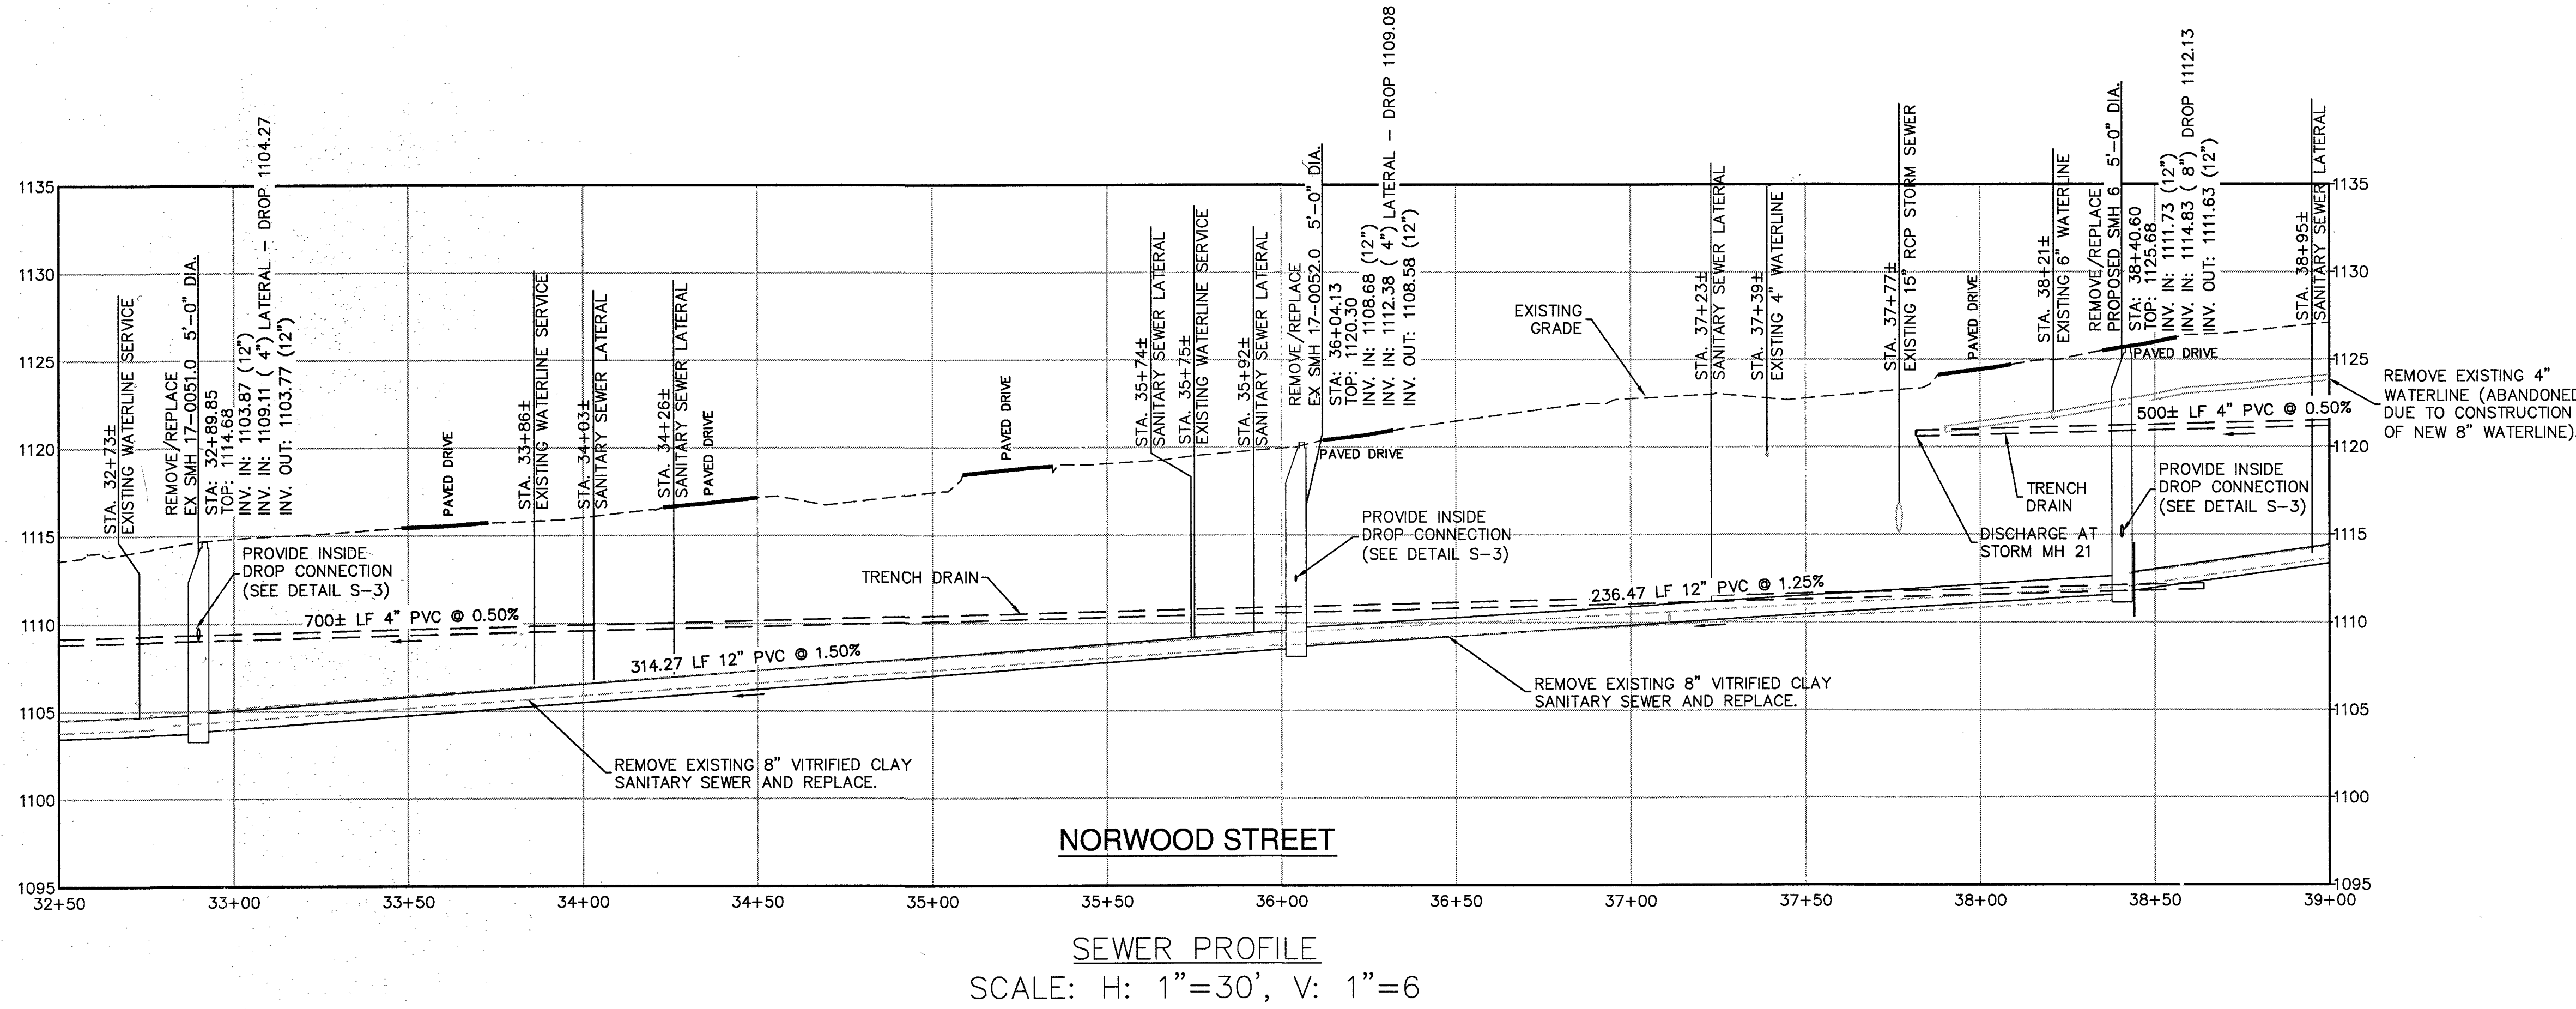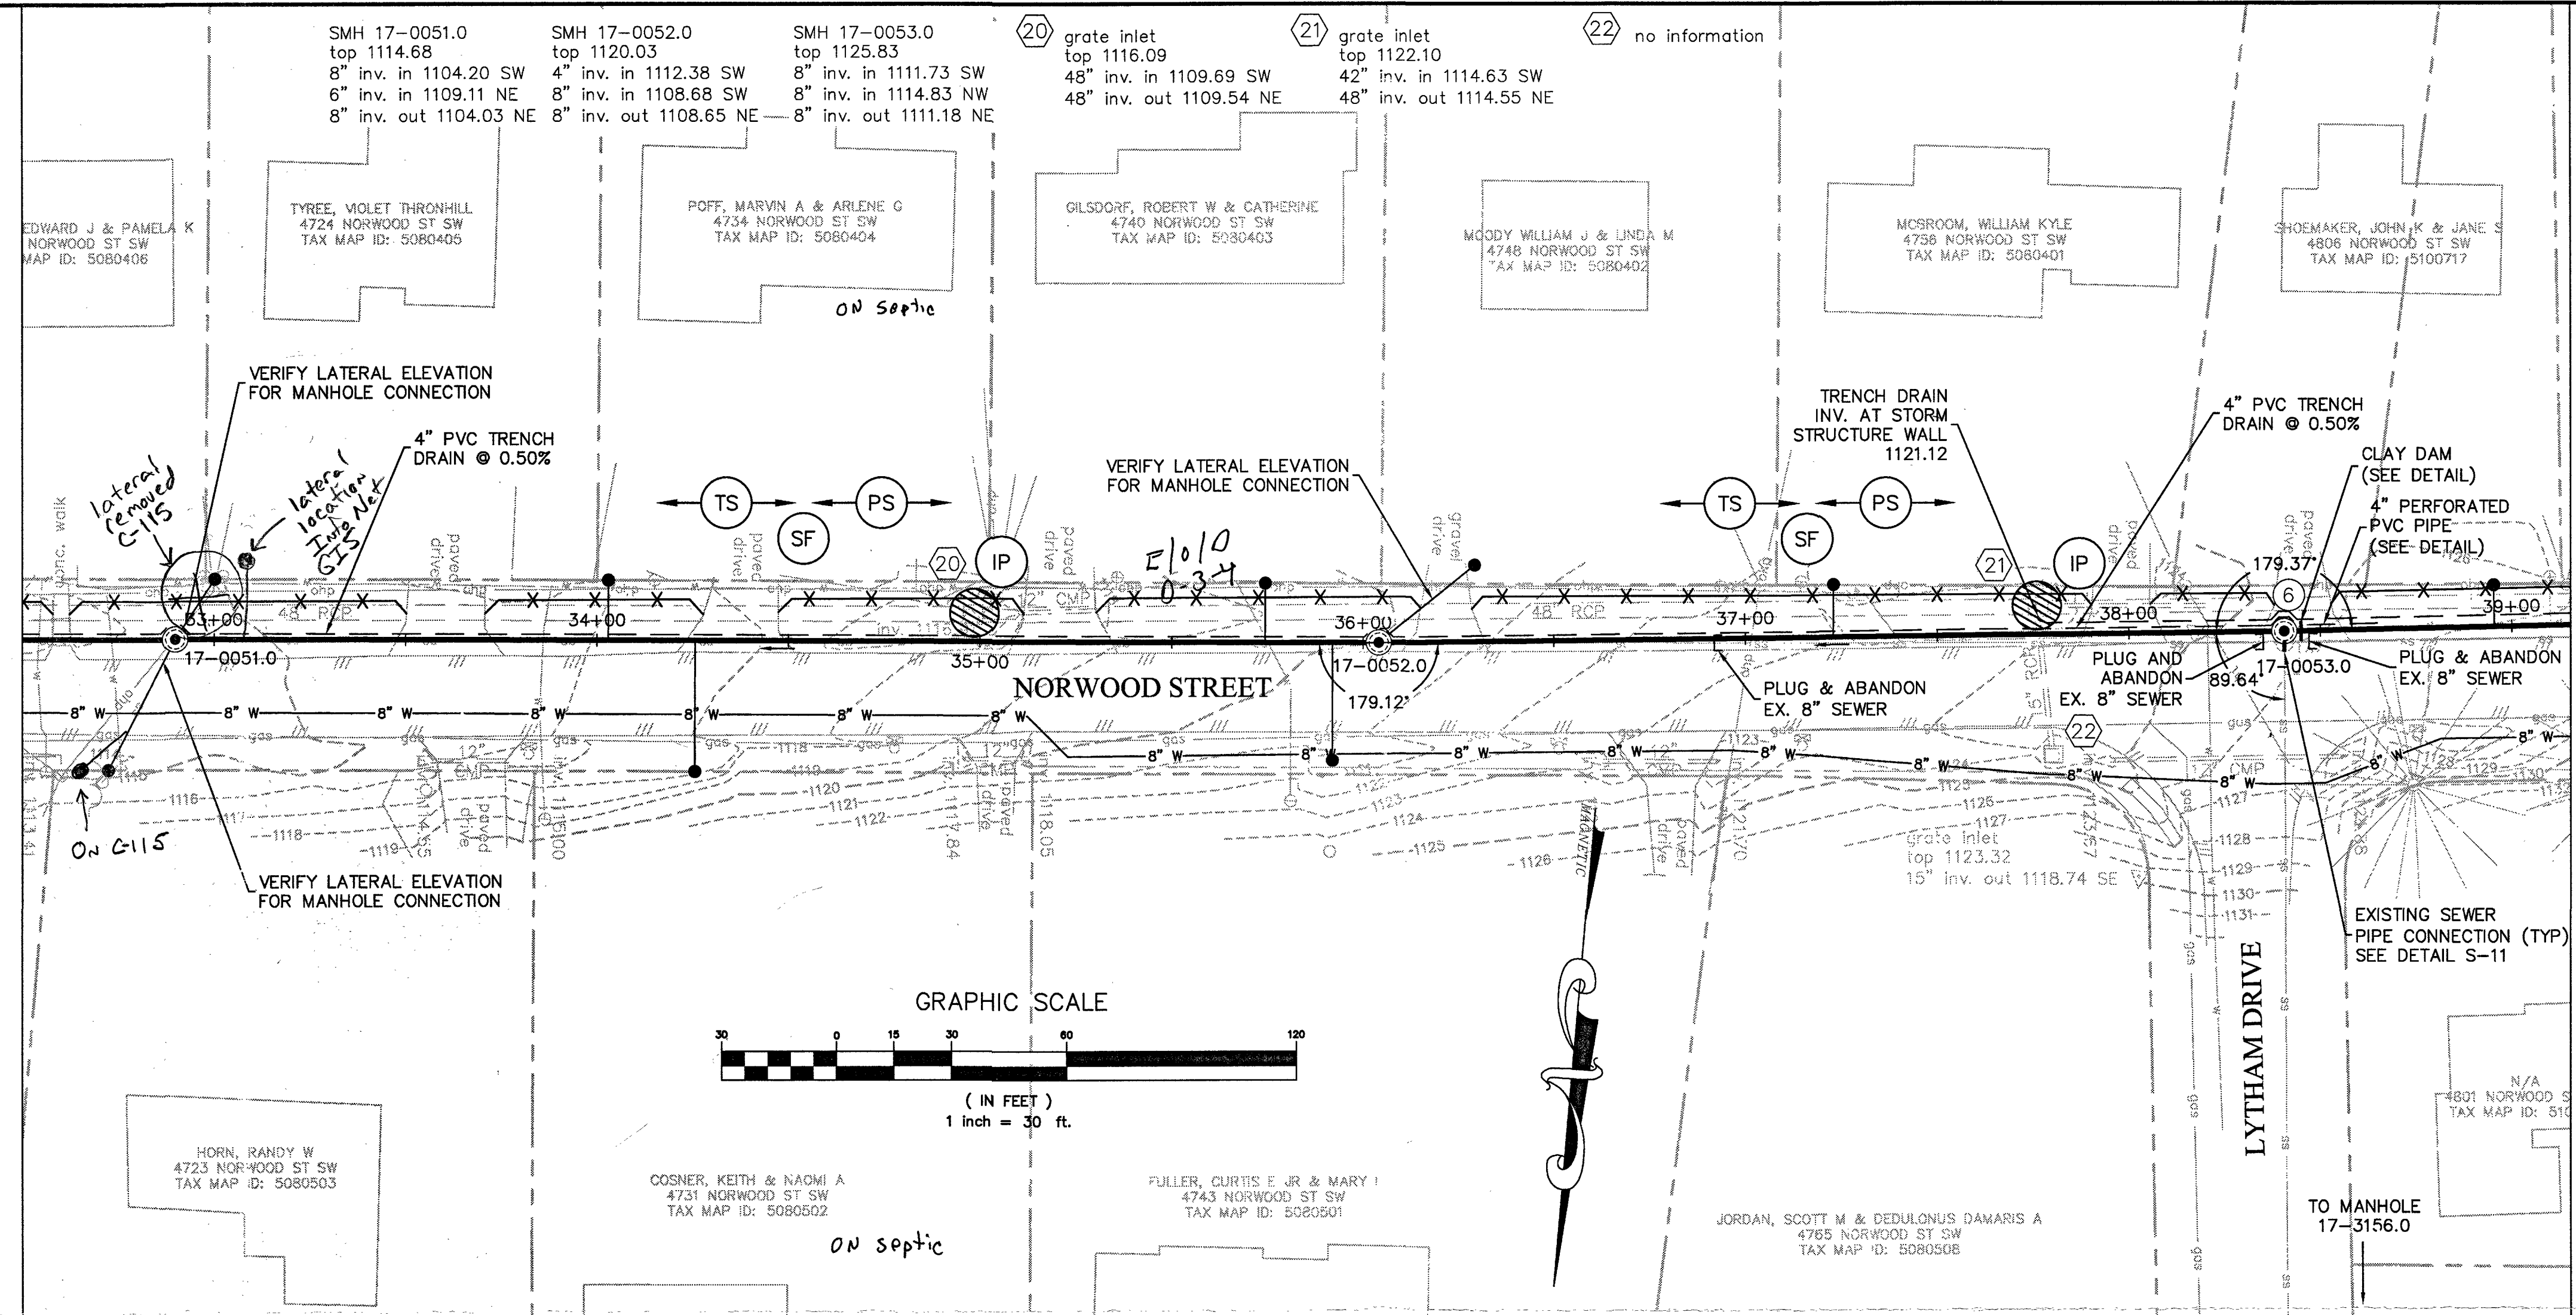

P:\B11132B\B11132B-04B\B11132B-04B_MURDOCK_SWF.DWG: OPTIMIZED April 15, 2013 2:45:00 PM