

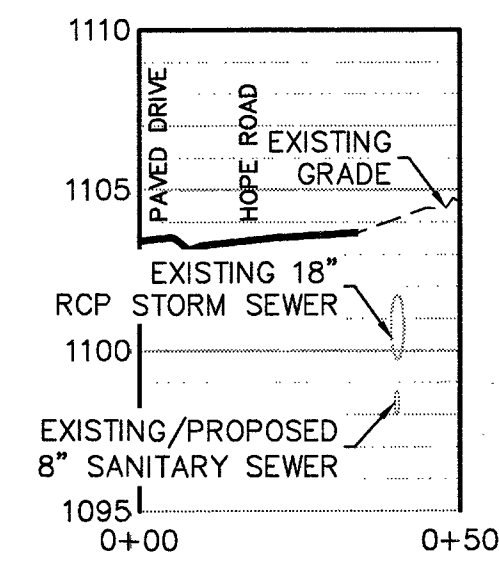
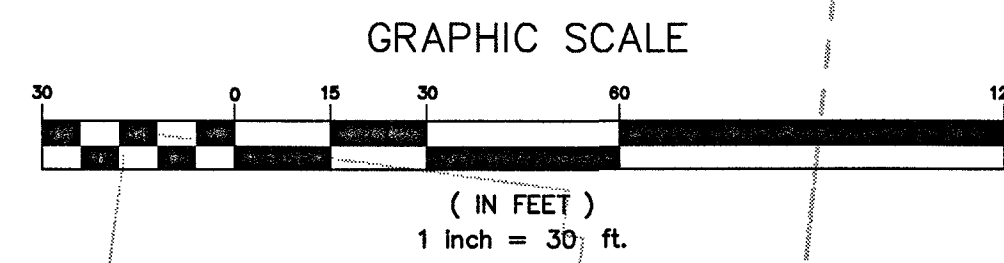


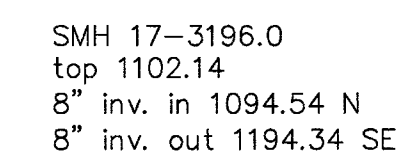

STA. 10+59±
SECTION C-C
SCALE: H: 1"=30', V: 1"=6'

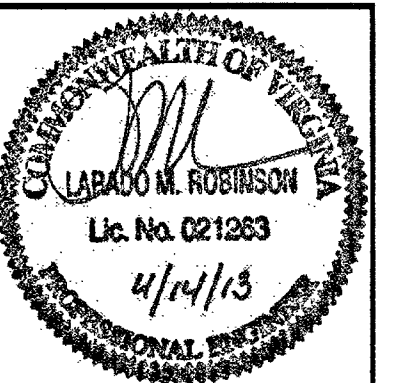

Draper Aden Associates
Engineering • Surveying • Environmental Services

 2206 South Main Street
Blacksburg, VA 24060
540-552-0444 Fax: 540-552-0291

Richmond, VA
Charlottesville, VA
Hampton Roads, VA



1901 Innovation Drive, Suite 2100
Blacksburg, VA 24060

Main: (540) 552-5548 www.chibicompanies.com

SEWER PLAN AND PROFILE
WESTERN VIRGINIA WATER AUTHORITY FY2011
VCWRLF COLLECTION SYSTEM PROJECTS
MURDOCK CREEK
ROANOKE, VIRGINIA

REVISIONS

DESIGNED BY:	LMR
DRAWN BY:	BMC
CHECKED BY:	LMR
SCALE:	H: 1"=30' V: 1" = 6'
DATE:	04/14/13
PROJECT NUMBER:	B11132B-04B/05

C-118