




P:\B11132B\1132B-04B\DWG\B11132B-04B.DWG DESIGNED BY: LMR DATE: 04/14/13 10:08 PM

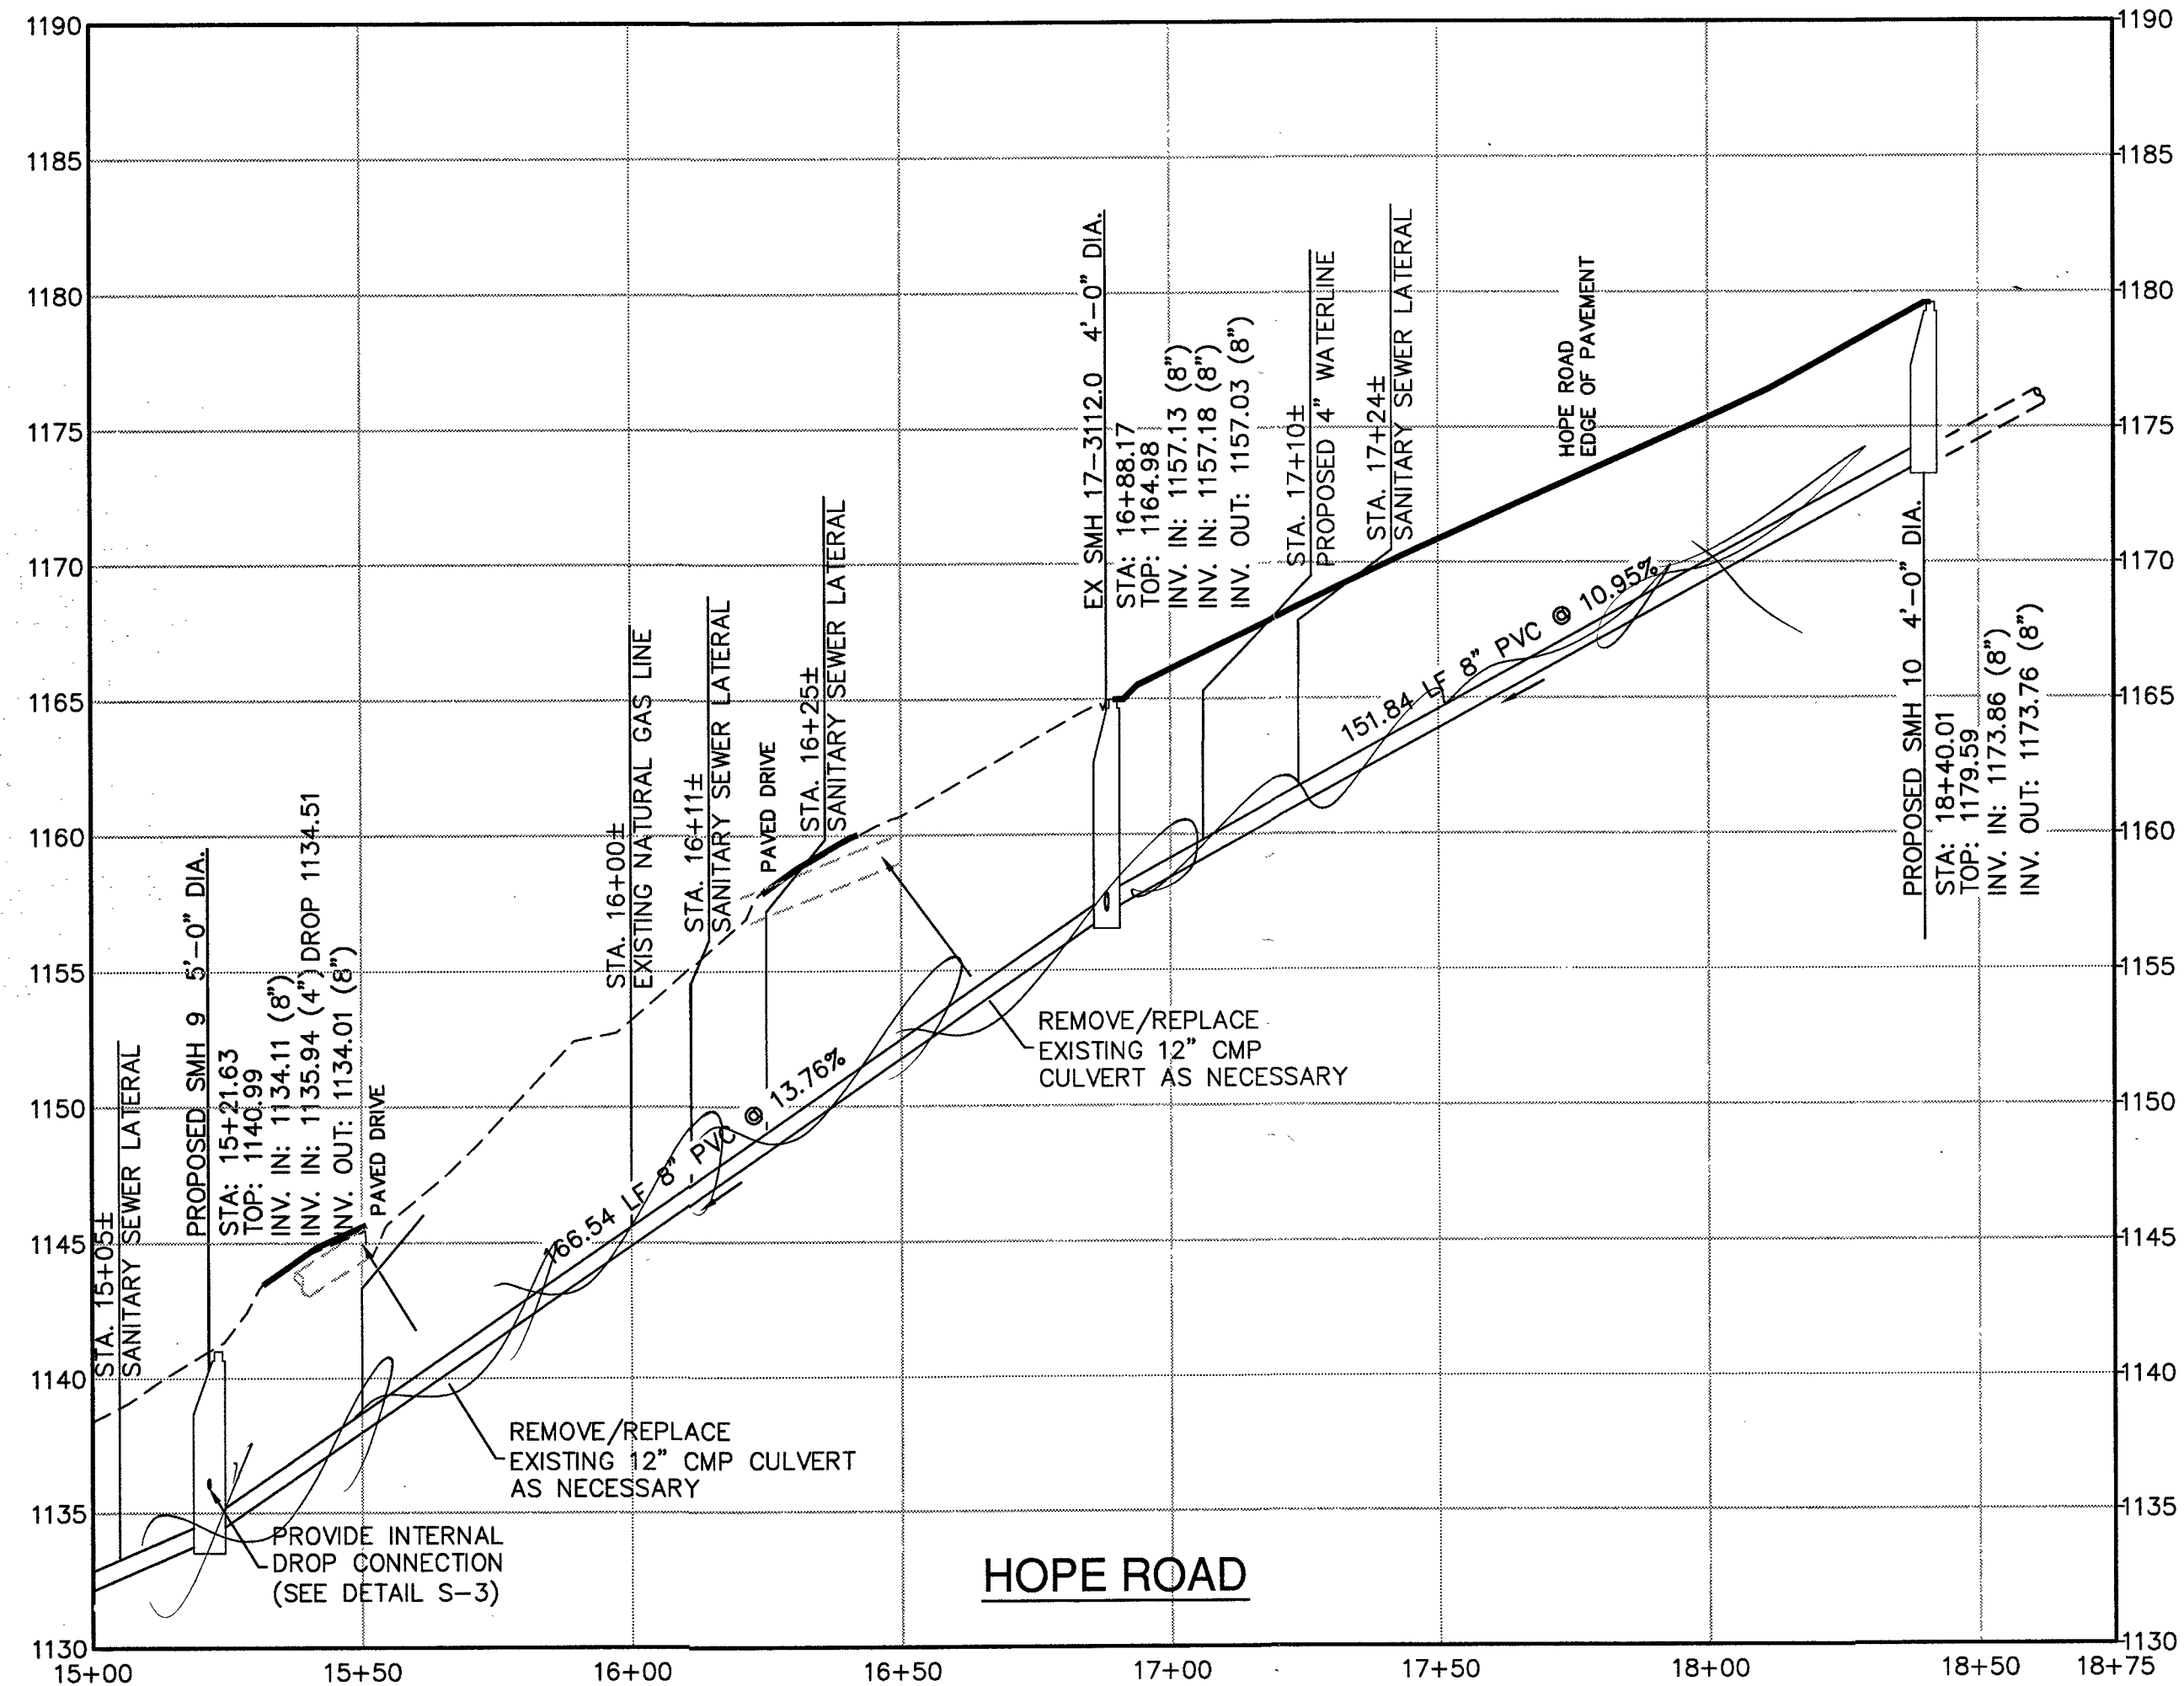

SEWER PROFILE
SCALE: H: 1"=30', V: 1"=6'

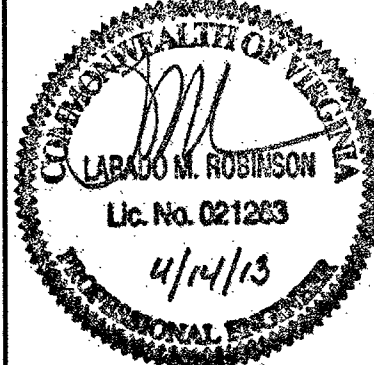

Draper Aden Associates
Engineering • Surveying • Environmental Services
2206 South Main Street
Blacksburg, VA 24060
540-552-0444 Fax: 540-552-0291
Richmond, VA
Charlottesville, VA
Hampton Roads, VA

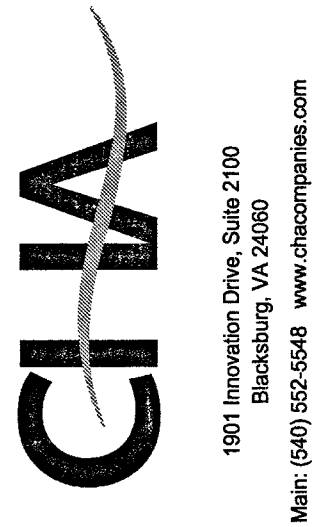

SEWER PLAN AND PROFILE
WESTERN VIRGINIA WATER AUTHORITY FY2011
VCWRLF COLLECTION SYSTEM PROJECTS
MURDOCK CREEK
ROANOKE, VIRGINIA

REVISIONS	
DESIGNED BY:	LMR
DRAWN BY:	BMC
CHECKED BY:	LMR
SCALE:	H: 1"=30' V: 1"=6'
DATE:	04/14/13
PROJECT NUMBER:	B11132B-04B/05

C-119