

CONTRACTOR SHALL RESTORE PAVEMENT PER THE CITY OF
ROANOKE RIGHT-OF-WAY EXCAVATION STANDARDS.

LOGAN LEROY A JR.
TAX ID 6390212
1612 WESTSIDE BLVD NW

SAMUEL JOHN W JR. & KEESHA R
TAX ID 6390211
1618 WESTSIDE BLVD NW

BEVERLY JUDITH PETTIS
TAX ID 6390210
1628 WESTSIDE BLVD NW

f.f. 1105.73
bsmt. 1096.98

f.f. 1103.69
bsmt. 1097.96

SAUNDERS GEORGE E SR. & SAUNDRA W
TAX ID 6390209
1634 WESTSIDE BLVD NW

BOLDEN JACQUELINE - LIFE ESTATE
TAX ID 6390208
3904 HARVEST LN NW

JOURNIETTE EUGENE P & SYLVIA S
TAX ID 6390502
3903 HARVEST LN NW

116.27
psmt. 1108.07

48 in. MH
STA: 10+00.00
TOP: 1103.06
INV. IN: 1090.06 (2,N)

48 in. MH
STA: 12+18.07
TOP: 1107.50
INV. IN: 1090.64 (7,N)
INV. OUT: 1090.54 (1,S)

48 in. MH
STA: 12+55.40
TOP: 1108.91
INV. OUT: 1091.26 (2,S)

REYNA FRANCISCO RAMON SIFUENTES
TAX ID 6390505
3829 HARVEST LN NW

GRAPHIC SCALE

20 0 10 20 40 60

(IN FEET)

1 inch = 20 ft.

BELCHER MELVA HOLLAND
TAX ID 6390404
1619 WESTSIDE BLVD NW

f.f. 1106.02
bsmt. 1097.27

WAY MARGARET SUSAN BARGER
TAX ID 6390405
1629 WESTSIDE BLVD NW

WELCHER CURTIS L & LENA M
TAX ID 6390406
1635 WESTSIDE BLVD NW
f.f. 1105.51
bsmt. 1096.49

JENKINS ROME & AMANDA
TAX ID 6390407

bsmt. 1103.44

48 in. MH
STA: 10+43.51
TOP: 1108.20


INV. IN: 1090.83 (4,E)
INV. OUT: 1090.73 (,W)

f.f. 1112.87
bsmt. 1104.82

MH 07A-3033.0
sanitary manhole
top 1103.06
8" inv. in 1090.04 NE
6" inv. in 1090.08 NE
8" inv. in 1090.11 SW
8" inv. out 1089.96 NW

② sanitary manhole
top 1103.37
8" inv. in 1092.83 SE
8" inv. out 1092.60 NE

(JJ) MH 07A-3034.0
sanitary manhole
top 1108.91
8" inv. in 1096.50 NW
8" inv. in 1091.59 SE
8" inv. out 1091.56 SW

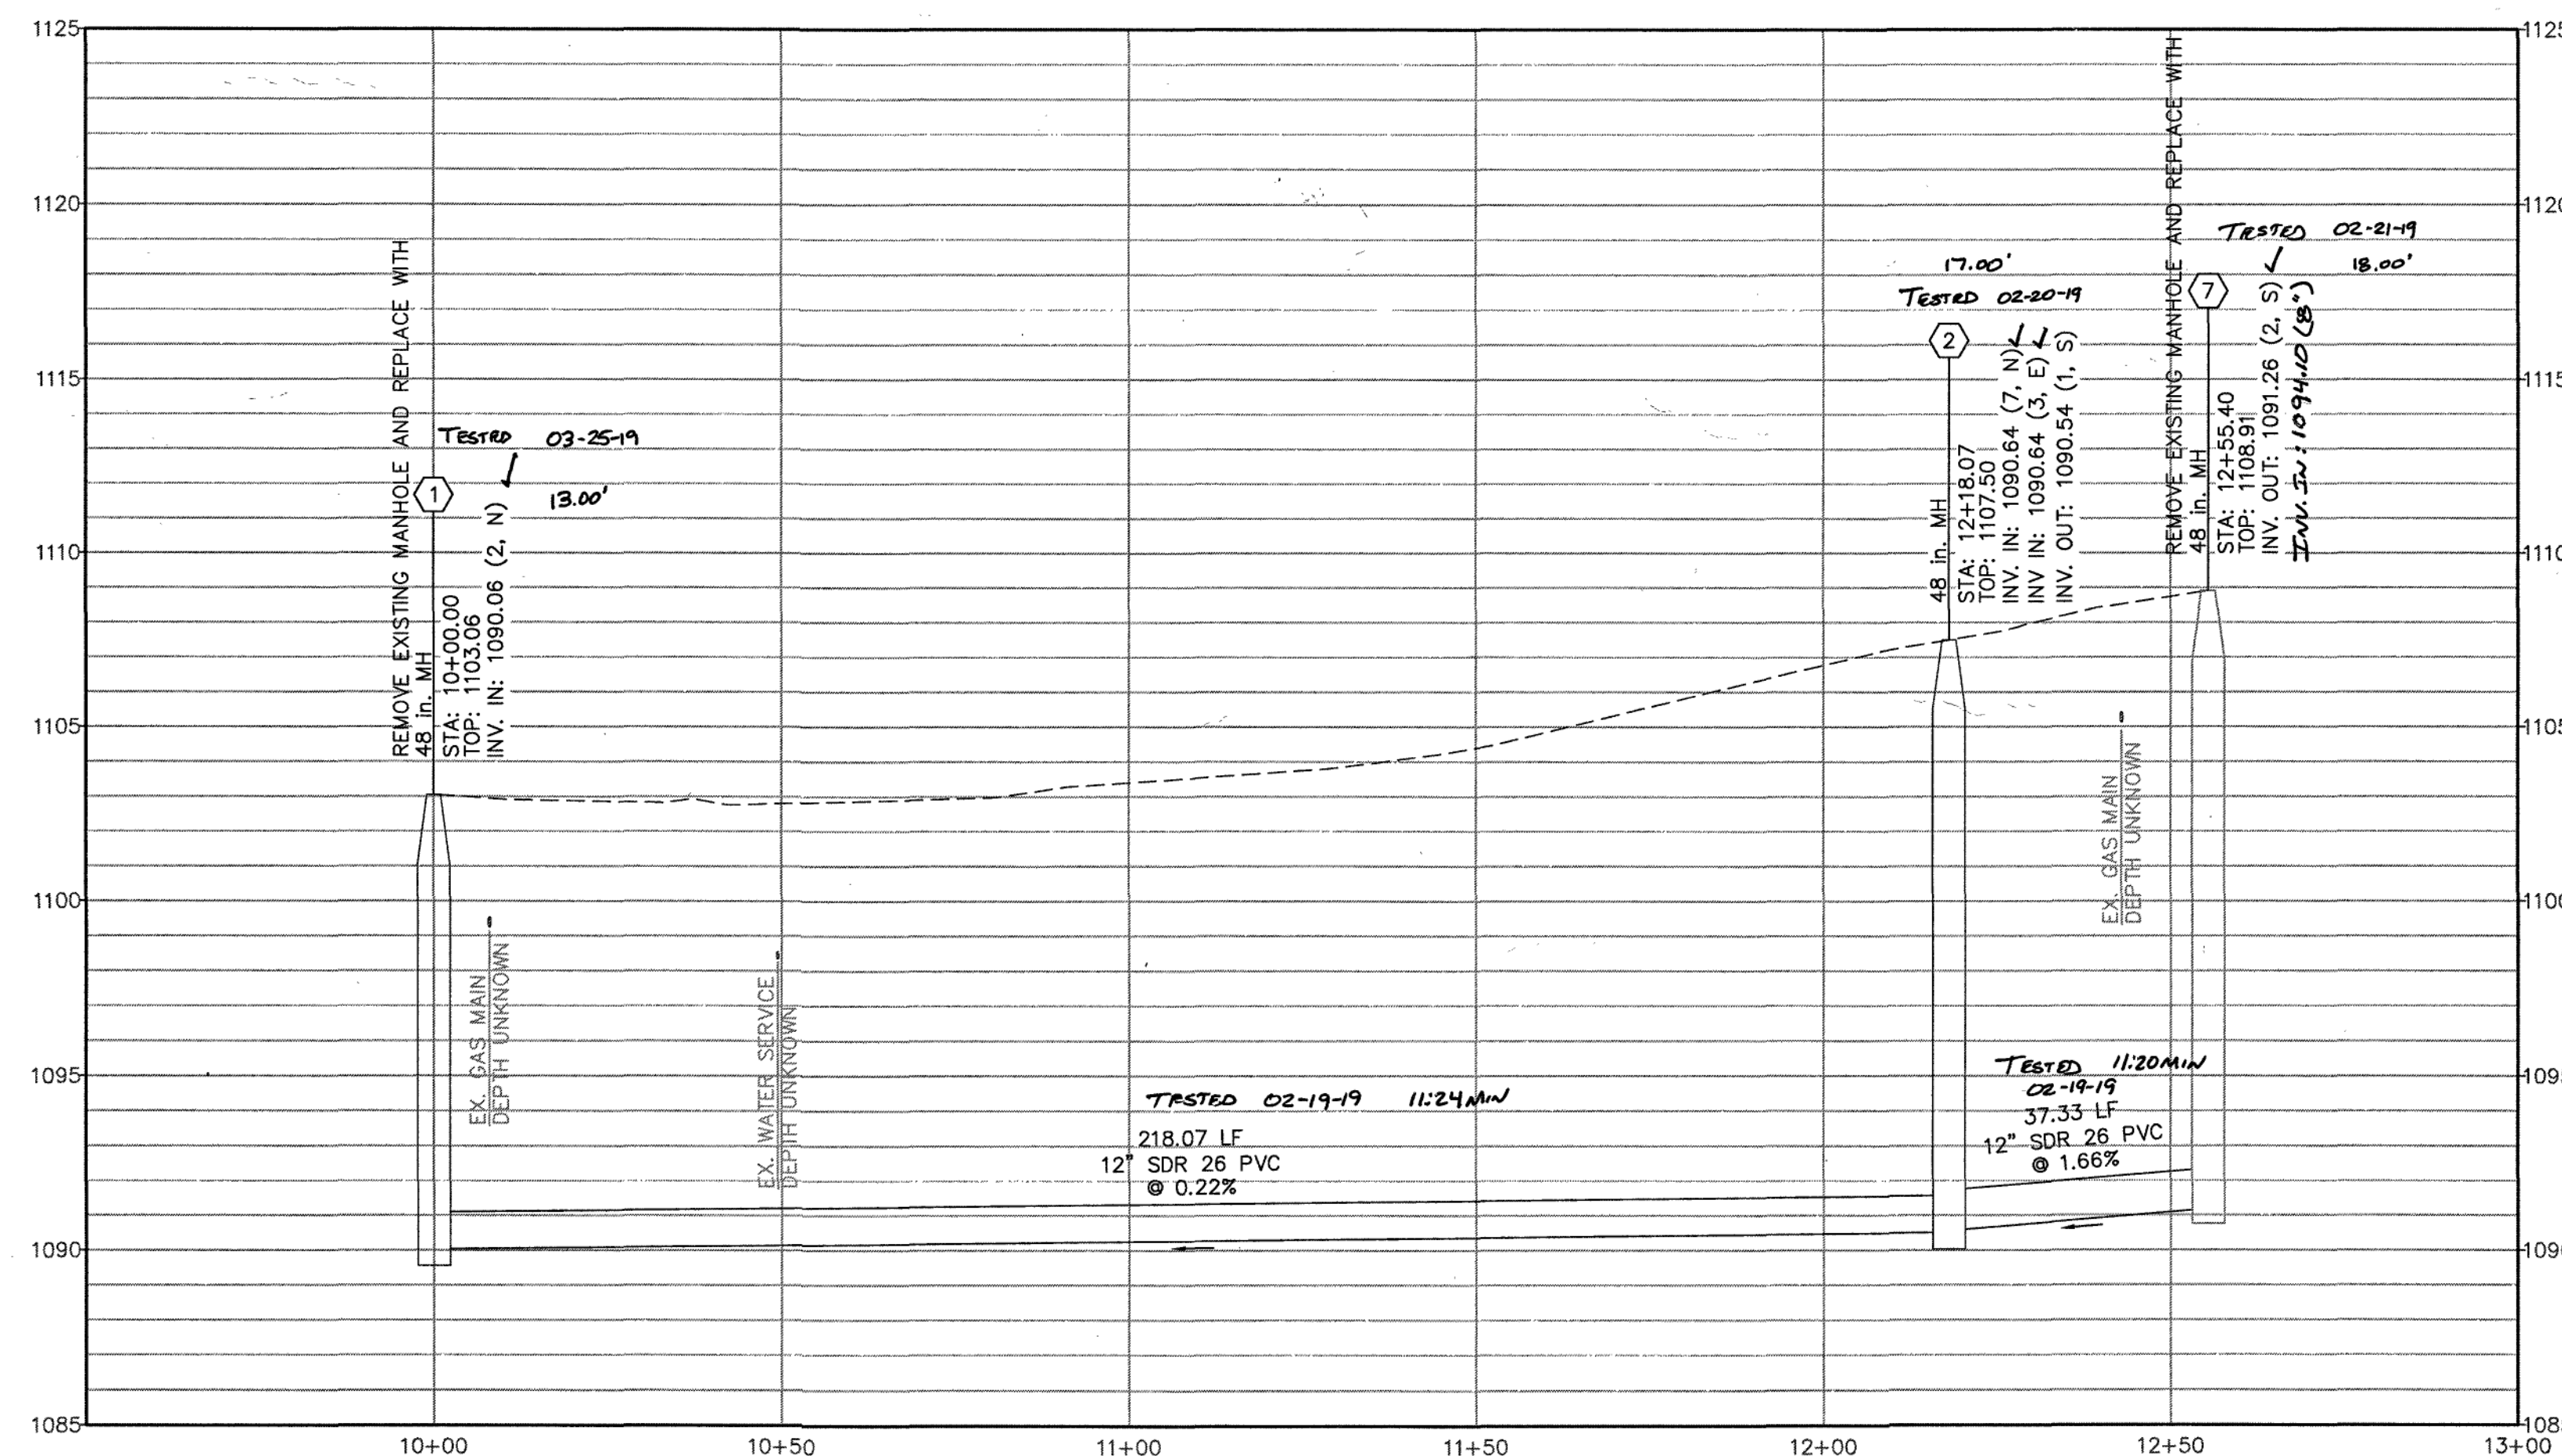

Scale: H: 1"=20', V: 5.00:1

AS-BUILTS
CHARLES CROWN
06-06-19

COMMONWEALTH OF VIRGINIA
JAY S. LESTER
Lic. No. 16854
PROFESSIONAL ENGINEER

Draper Aden Associates

Engineering • Surveying • Environmental Services

2206 South Main Street
Blacksburg, VA 24060
540-552-0444 Fax: 540-552-0291
www.daa.com

- Richmond, VA
- Charlottesville, VA
- Hampton Roads, VA
- Raleigh, NC
- Fayetteville, NC
- Northern Virginia
- Virginia Beach, VA



PLAN AND PROFILE
HARVEST LANE SANITARY SEWER
REPLACEMENT
ROANOKE, VIRGINIA

REVISIONS

DESIGNED BY:	BSC/JSL
DRAWN BY:	BSC/AHS
CHECKED BY:	MSH
SCALE:	AS SHOWN
DATE:	03/30/2018
PROJECT NUMBER:	B11132B-04

C-1