
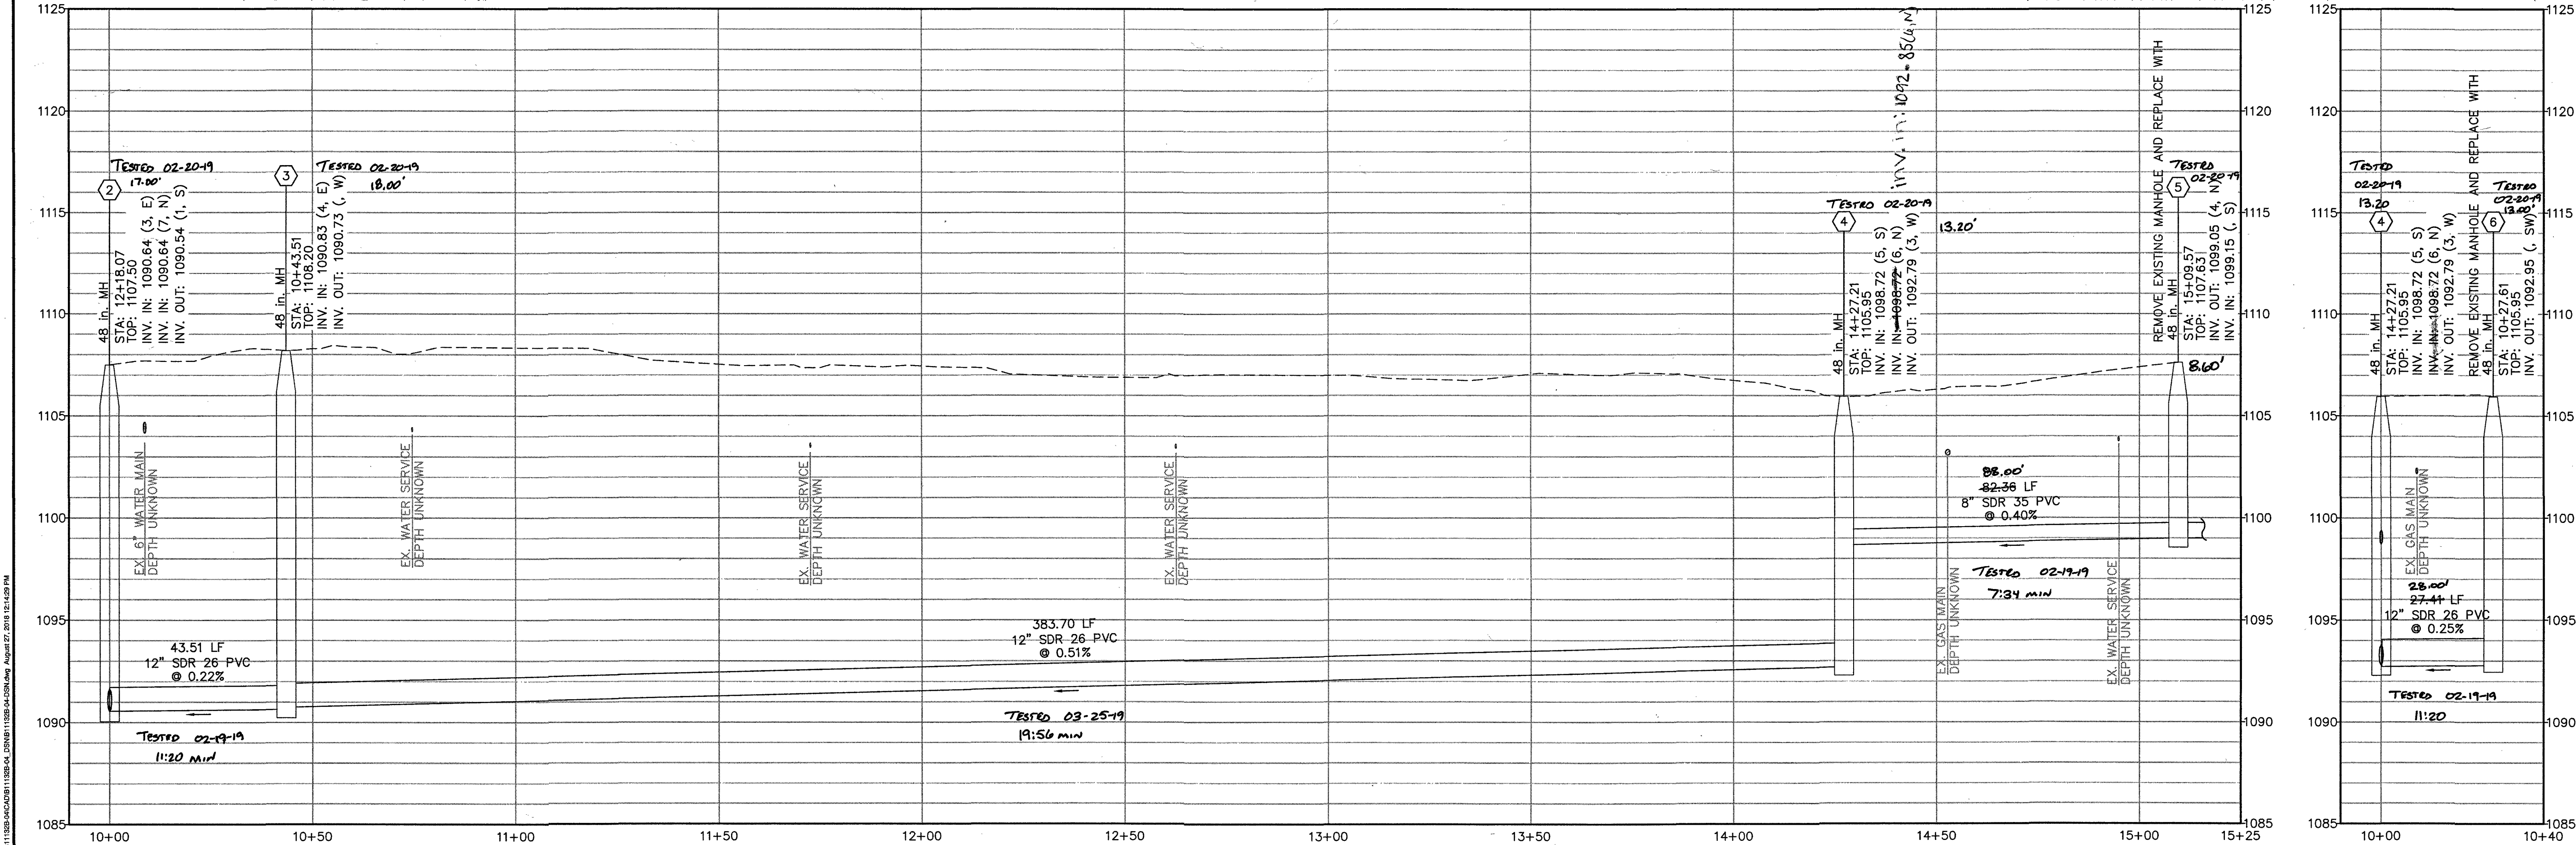


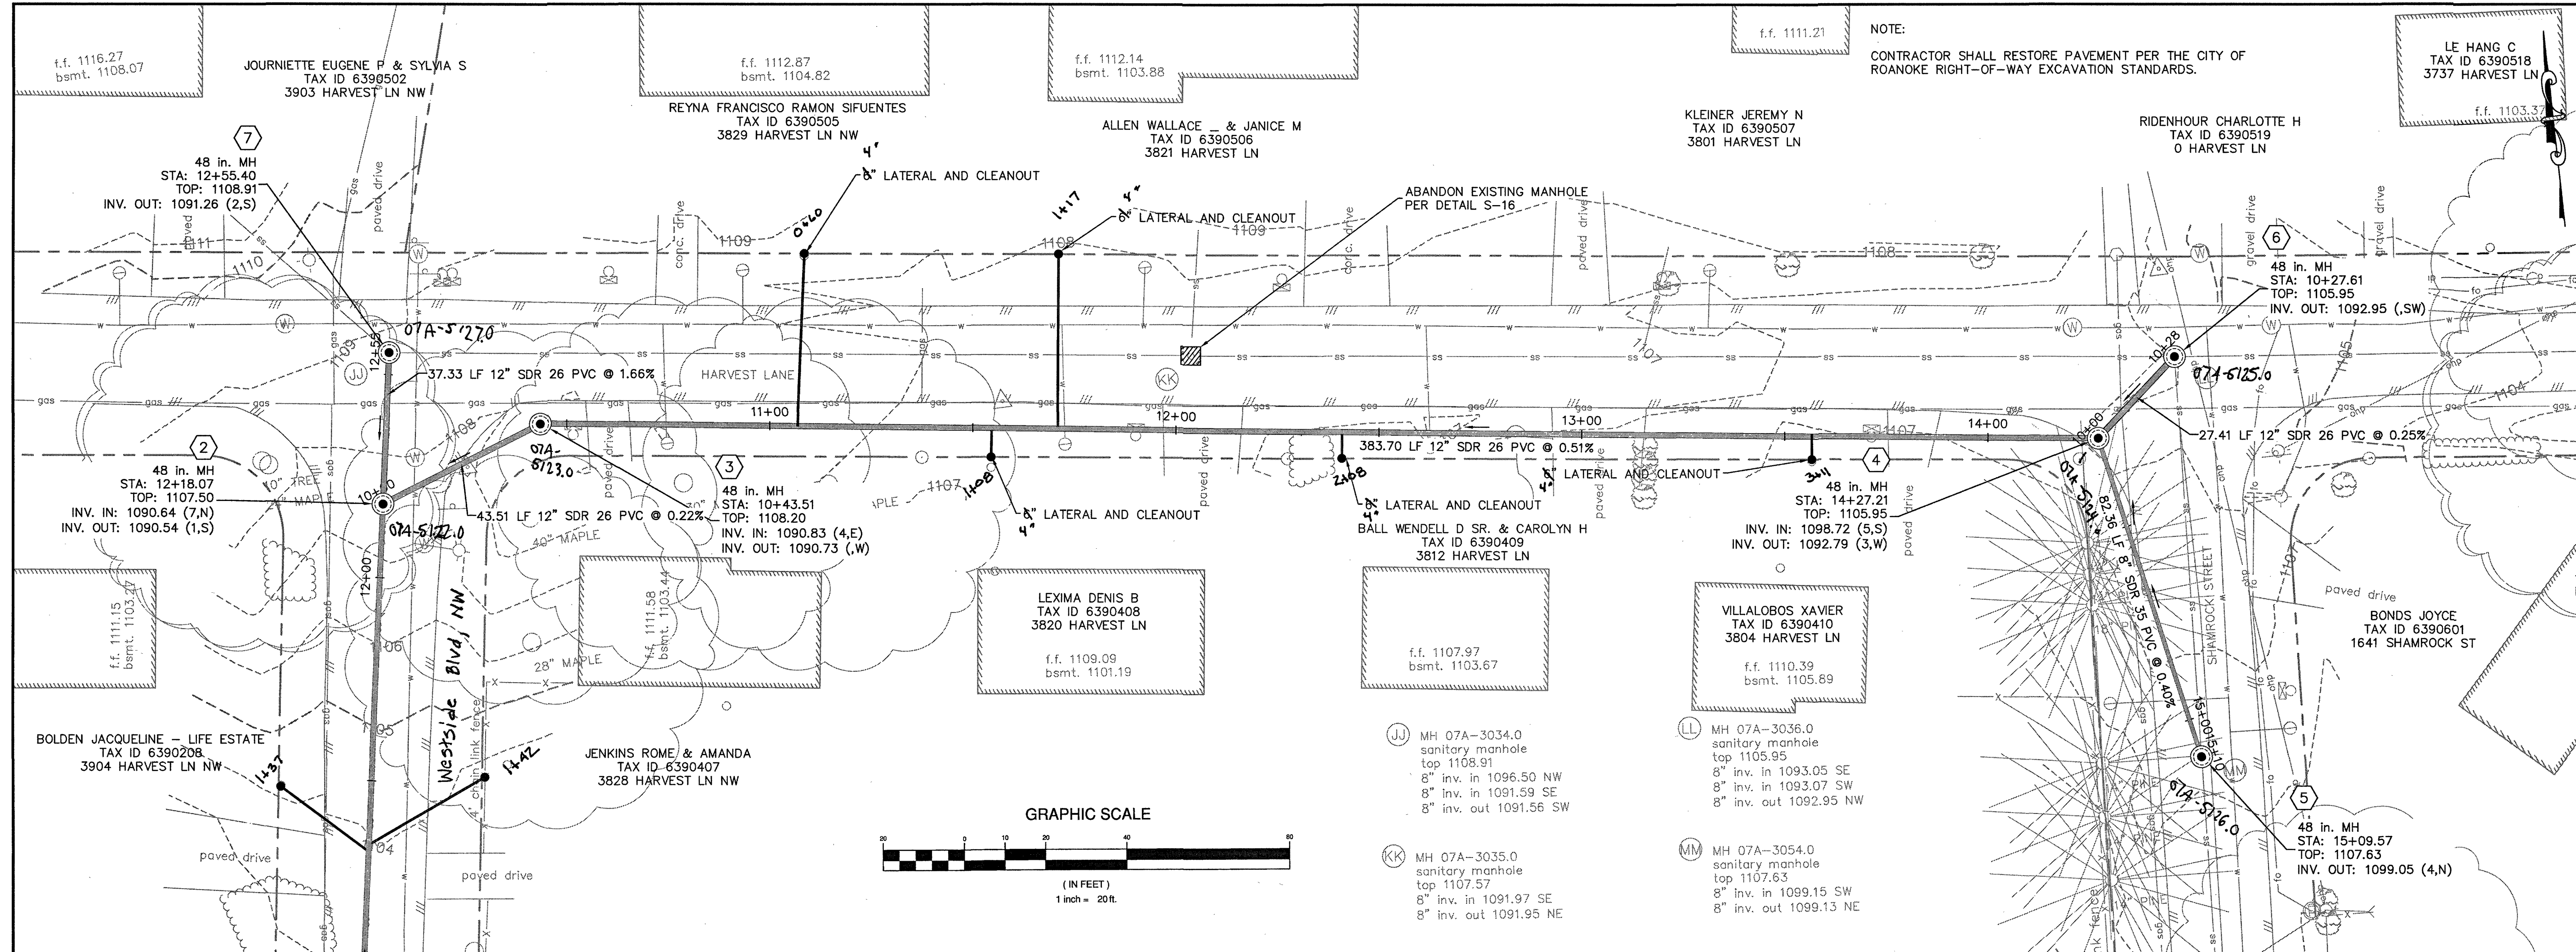

H: 1"=20', V: 5.00:1

Scale: H: 1"=20', V: 5.00:1

COMMONWEALTH OF VIRGINIA

JAY S. LESTER

Lic. No. 16664

PROFESSIONAL ENGINEER

Draper Aden Associates

Engineering • Surveying • Environmental Services

2208 South Main Street

Roanoke, Virginia 24004

540-552-0444 Fax: 540-552-0291

www.dsa.com

Richmond, VA

Charlottesville, VA

Hampton Roads, VA

Virginia Beach, VA

Raleigh, NC

Payetteville, NC

Northern Virginia

PLAN AND PROFILE

HARVEST LANE SANITARY SEWER REPLACEMENT

ROANOKE, VIRGINIA

DESIGNED BY: BSC/JSL

DRAWN BY: BSC/AHS

CHECKED BY: MSH

SCALE: AS SHOWN

DATE: 03/30/2018

PROJECT NUMBER: B11132B-04

C-2