



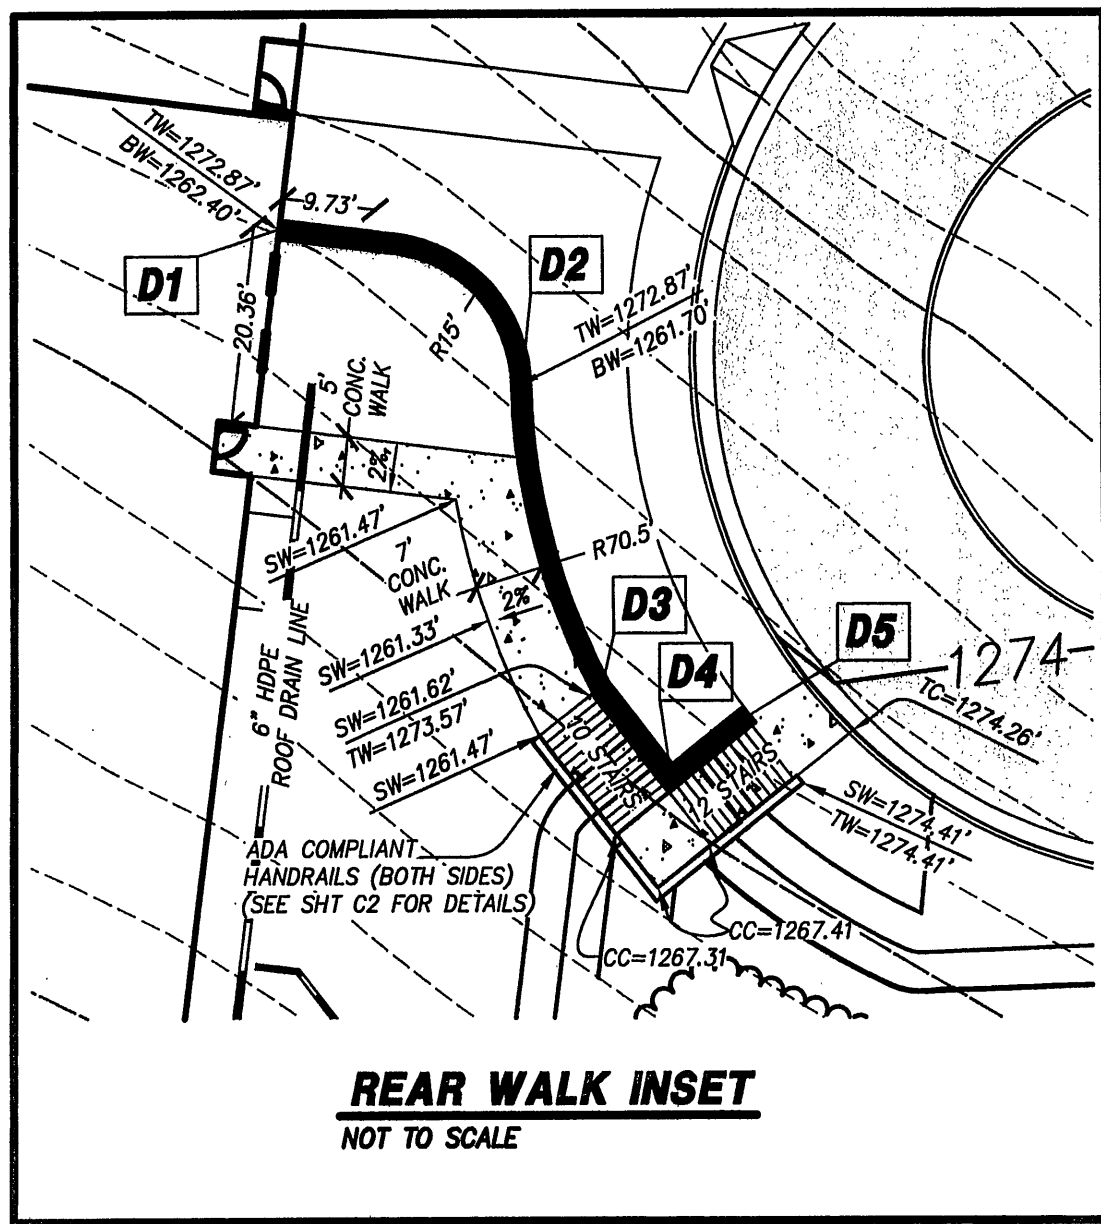

ITEM	EXISTING	PROPOSED
Pavement	---	---
Concrete Curb (CC-2)	---	---
Curb & Gutter (CG-6)	---	---
Sanitary Sewer Manhole	⊙	⊙
Sanitary Sewer Line	---	---
Sanitary Sewer Cleanout	⊙	⊙
Waterline	---	---
Water Line Blow-Off Valve	⊙	⊙
Fire Hydrant Assembly	⊙	⊙
Storm Drain Line	---	---
Storm Drain Drop Inlet	⊙	⊙
Contours	---	---

ABBREVIATIONS	
TG	TOP OF GROUND
TW	TOP OF WALL
BW	BOTTOM OF WALL
SW	TOP OF SIDEWALK
CC	TOP OF CONCRETE
CL	CENTERLINE
TC	TOP OF CURB

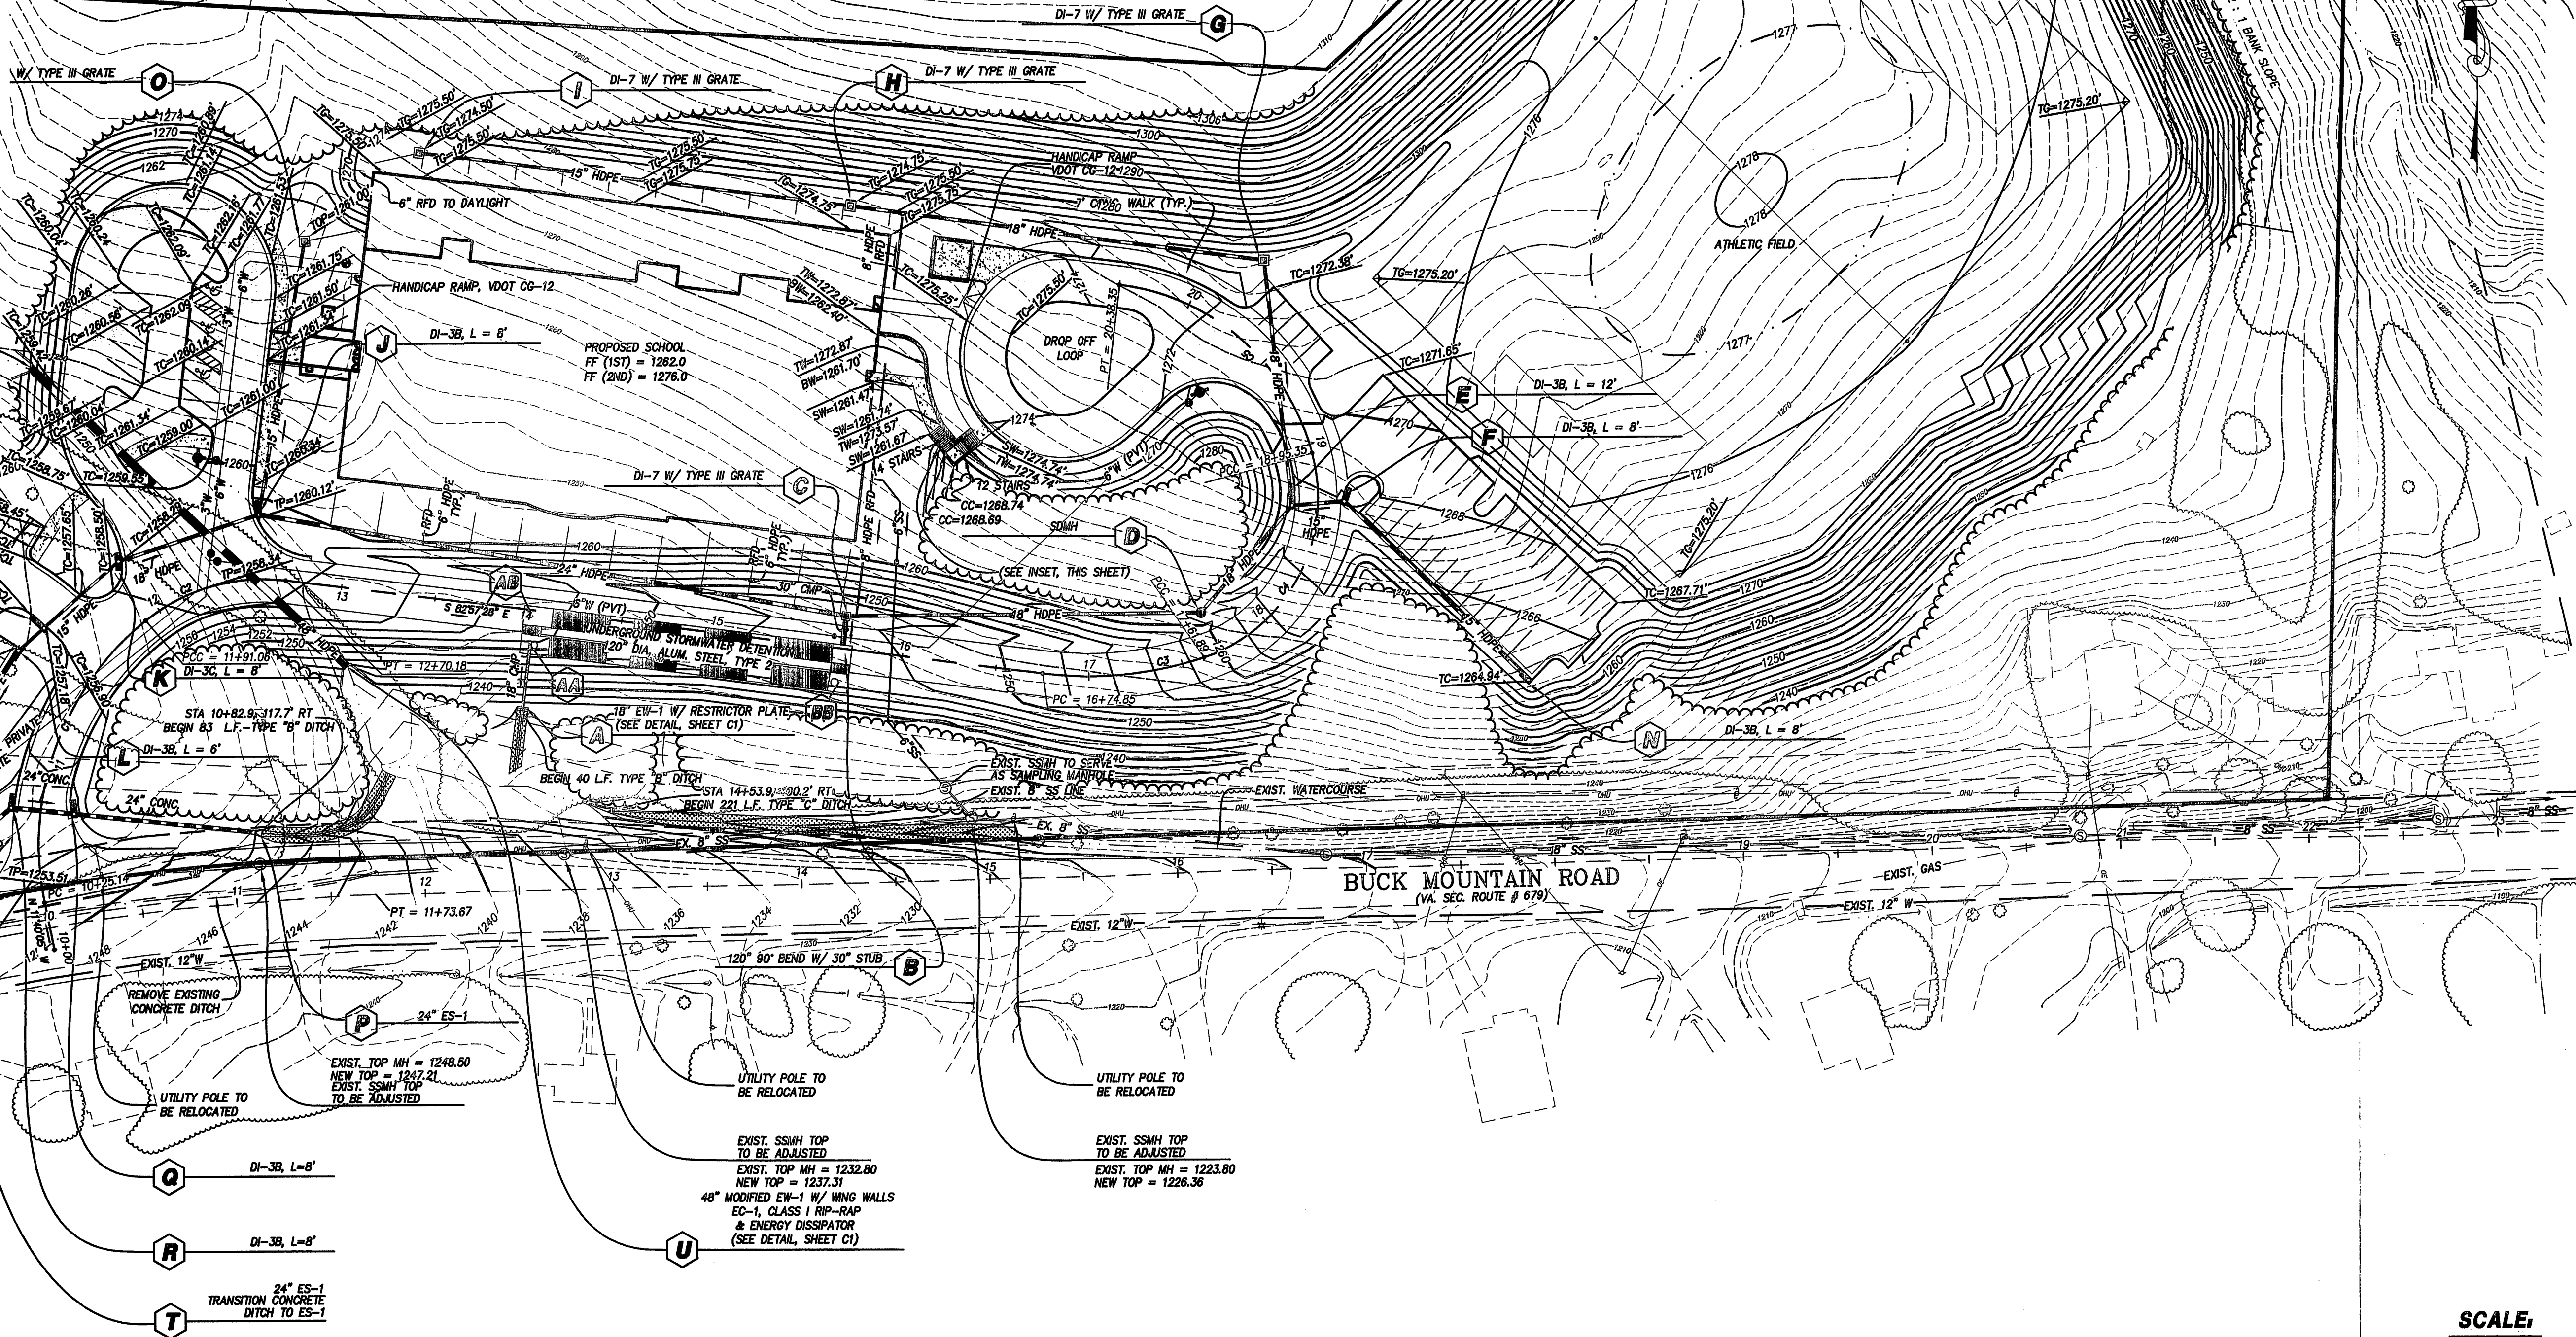

SCALE:
1" = 50' HORIZ.




LUMSDEN ASSOCIATES, P.C.
ENGINEERS-SURVEYORS-PLANNERS
ROANOKE, VIRGINIA

4664 BRAMBLETON AVENUE
P.O. BOX 20669
ROANOKE, VIRGINIA 24018

PHONE: (540) 774-4411
FAX: (540) 772-9445
E-MAIL: MAIL@LUMSDENPC.COM

FAITH CHRISTIAN SCHOOL ROANOKE COUNTY, VIRGINIA

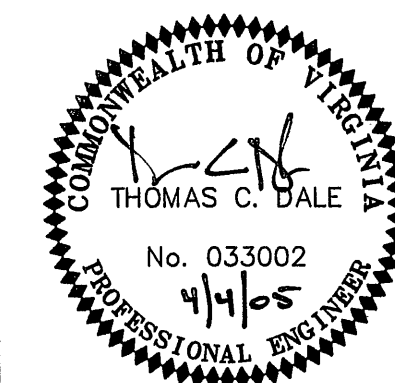

GRADING PLAN

PROJECT ARCHITECT

COMMISSION NUMBER

03-082

REVISIONS

8 MARCH 2005
4 APRIL 2005

DATE

6 JAN. 2005

C5