


ABBREVIATIONS

TO	TOP OF GROUND
TW	TOP OF WALL
BW	BOTTOM OF WALL
SW	TOP OF SIDEWALK
CC	TOP OF CONCRETE
CL	CENTERLINE
TC	TOP OF CURB

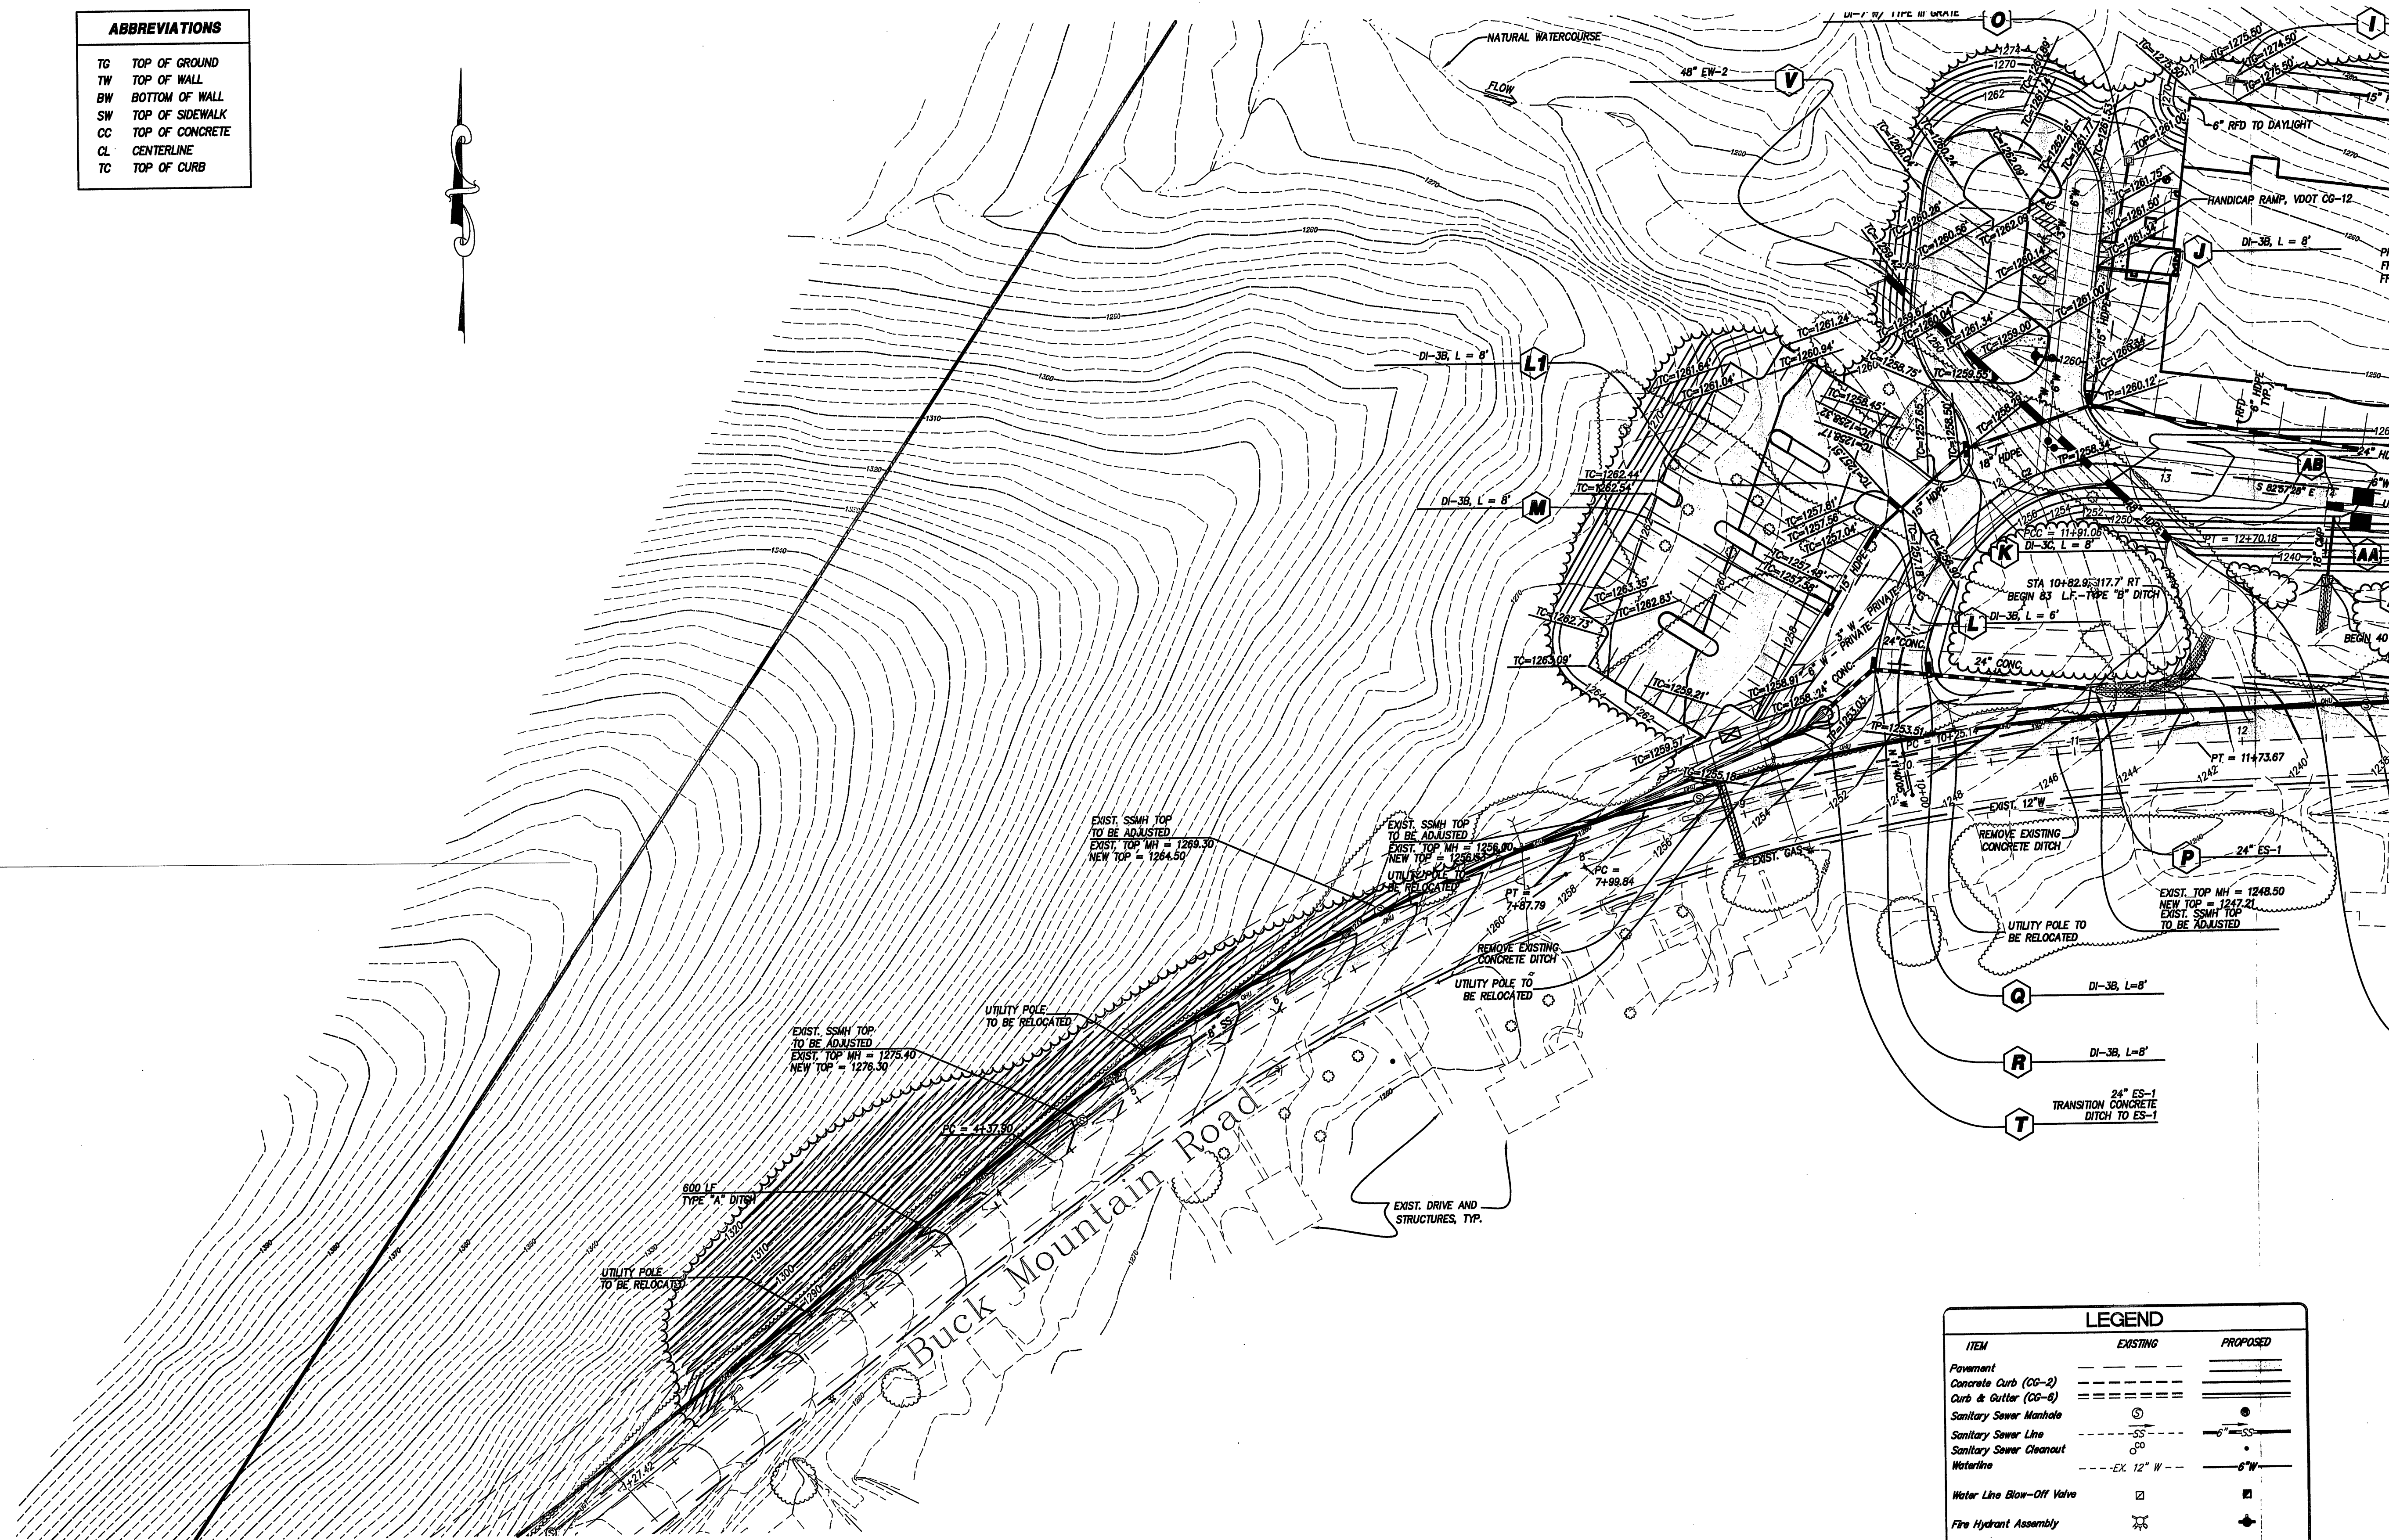

LEGEND

ITEM	EXISTING	PROPOSED
Pavement	---	---
Concrete Curb (CC-2)	---	---
Curb & Gutter (CG-6)	---	---
Sanitary Sewer Manhole	⊙	⊙
Sanitary Sewer Line	---	---
Sanitary Sewer Cleanout	⊙	⊙
Waterline	---	---
Water Line Blow-Off Valve	⊙	⊙
Fire Hydrant Assembly	⊙	⊙
Storm Drain Line	---	---
Storm Drain Drop Inlet	⊙	⊙
Contours	---	---

SCALE:
1" = 50' HORIZ.




LUMSDEN ASSOCIATES, P.C.
ENGINEERS-SURVEYORS-PLANNERS
ROANOKE, VIRGINIA

4664 BRAMBLETON AVENUE
P.O. BOX 20669
ROANOKE, VIRGINIA 24018

PHONE: (540) 774-4411
FAX: (540) 772-9445
E-MAIL: MAIL@LUMSDENPC.COM

FAITH CHRISTIAN SCHOOL ROANOKE COUNTY, VIRGINIA

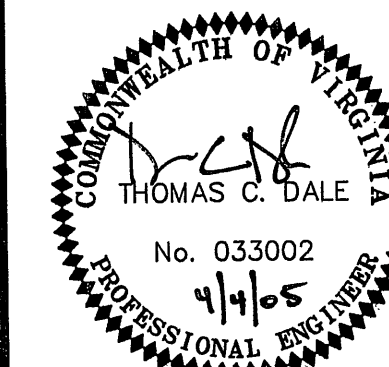

GRADING PLAN

PROJECT ARCHITECT

COMMISSION NUMBER
03-082

REVISED
8 MARCH 2005

DATE
6 JAN. 2005

C6