

DATE: NOV. 8, 2008
 REVISIONS:
 1. DEC. 10, 2009
 2. DEC. 31, 2009

HUGHES ASSOCIATES ARCHITECTS
 Architecture Planning Consulting

656 ELM AVENUE, S.W.
 P.O. BOX 1034
 ROANOKE, VIRGINIA 24005-1034

TEL (540) 342-4002
 FAX (540) 342-2060

**NEW FACILITY FOR
 FELLOWSHIP
 COMMUNITY CHURCH**
 Red Lane Extension Roanoke County, Virginia


**WATER
 SERVICE &
 SANITARY
 SEWER
 PLAN**

PROGRESS PRINT
 12/31/03
 FOR COORDINATION
 NOT FOR CONSTRUCTION

COMMISSION No.
 02005
 SHEET
 SP-7

No. 7 of 10
 COPYRIGHT 2003
 HUGHES ASSOCIATES ARCHITECTS
 A PROFESSIONAL CORPORATION

SCALE: 1"=50'

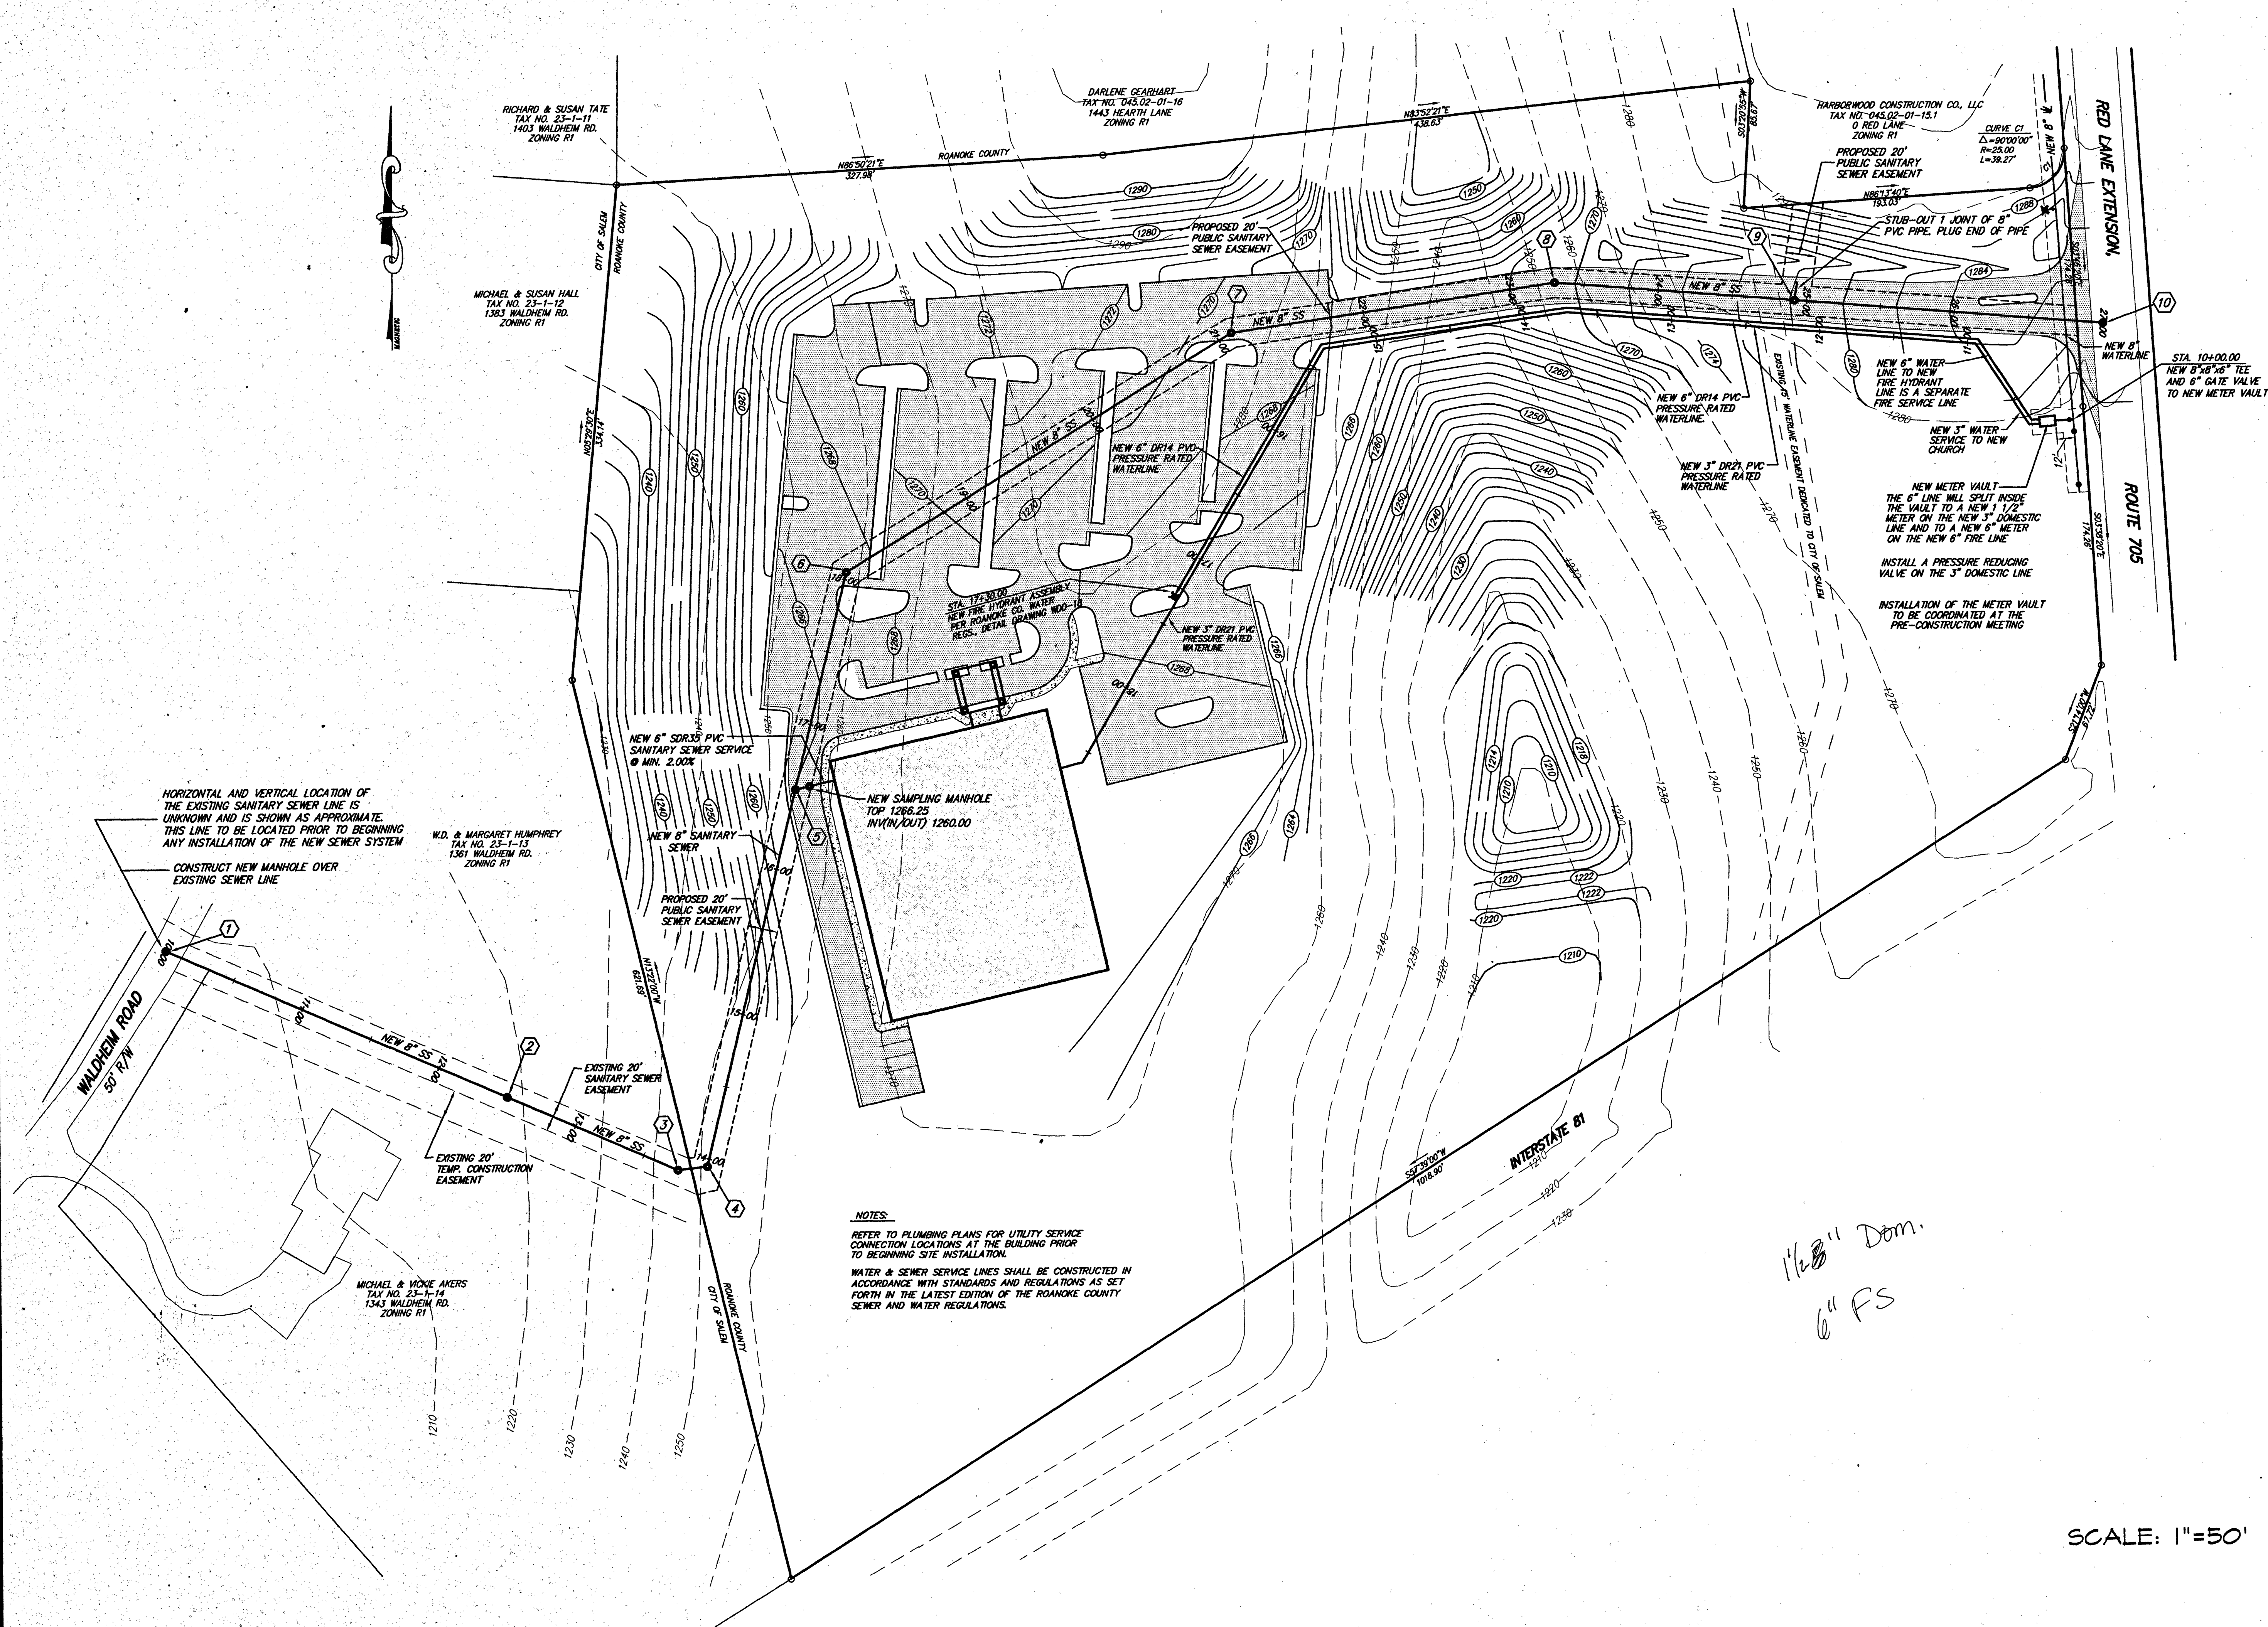

1 1/2" Dom.
 6" FS

NOTES:
 REFER TO PLUMBING PLANS FOR UTILITY SERVICE
 CONNECTION LOCATIONS AT THE BUILDING PRIOR
 TO BEGINNING SITE INSTALLATION.
 WATER & SEWER SERVICE LINES SHALL BE CONSTRUCTED IN
 ACCORDANCE WITH STANDARDS AND REGULATIONS AS SET
 FORTH IN THE LATEST EDITION OF THE ROANOKE COUNTY
 SEWER AND WATER REGULATIONS.