

ALL DOORS ARE METAL - 7'-2" HIGH WITH D.S.B. GLASS WINDOWS

2. PAINT ALL DOORS - EACH SIDE - SEE SPECS.

ALL PAINTED SURFACES TO HAVE 2 COATS- SEE SPECS.

2. WINDOW SILLS IN LABORATORY & TOILET TO BE 1" GREENSTONE WITH 1" OVERHANG 1" TJK. BY 6" WIDE. OTHER SILLS TO BE PAINTED CONCRETE.

ALL WINDOWS TO BE ALUMINUM MFG. STOCK SIZES - ANDERSON OR APPROVED EQUAL
CONTRACTOR MAY VARY WINDOW SIZES SHOWN BY 2" ON HEIGHT OR 2" ON WIDTH.

ALL CABINET WORK & SINK IN LABORATORY: FISHER - HATFIELD UNIT NO. 2 MODIFIED CAT. NO. 100 APPROVED EQUAL.

ALL PLUMBING FIXTURES TO BE AMERICAN STANDARD OR APPROVED EQUAL

A WATER CLOSET - "CADET COMBINATION" F-2122-11 AS ILLUSTRATED IN MFG. CATALOG

LABORATORY - "NAFLEDGER" - F 506-40 - COMPLETE AS ILLUSTRATED
 C. BROWNE - NIND - COMPLETE AS ILLUSTRATED IN MFG. CATALOG


2. LIGHT FIXTURES - IN LABORATORY: 'SYLVANIA' 4 LAMP WIDE W4408 A 200 WATTS PER UNIT
1 OUTSIDE LAMP TO ONE SWITCH & ONE INSIDE LAMP TO A SEPARATE SWITCH OR APPVD. EQUAL.

2 LAMPS IN CHLORINE RM. & STORAGE RM. - WESTINGHOUSE BPDV - 200 OR APPROX EQUAL


W. HEATERS

A IN LABORATORY MARKED 4341507 SUSPENSION ELECTRIC HEATER WITH HANGING BRACKET


3. IN CHLORINE ROOM. MARKEL-HINGOOS SURFACE MOUNTED WALL HEATER WITH THERMOSTAT
\$ THERMOSTAT - 7.5 KW 26,000 BTU OR APPROX. EQUAL CTR. 7'-0" UP.
3 KW 10,245 BTU W5A 30 OR APPROVED EQUAL.

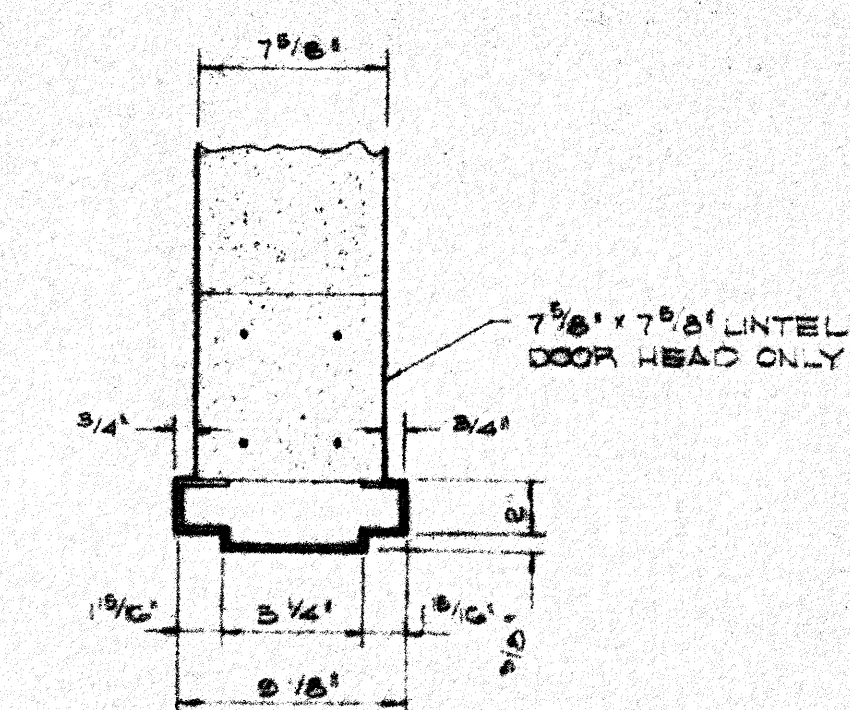


SCALE: 1/2" = 1'-0"

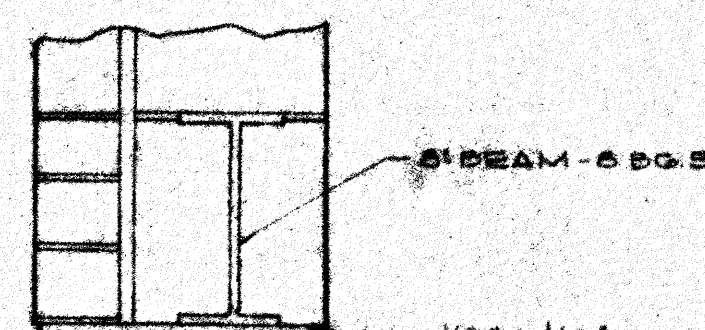

SCALE: 1/2" = 1'

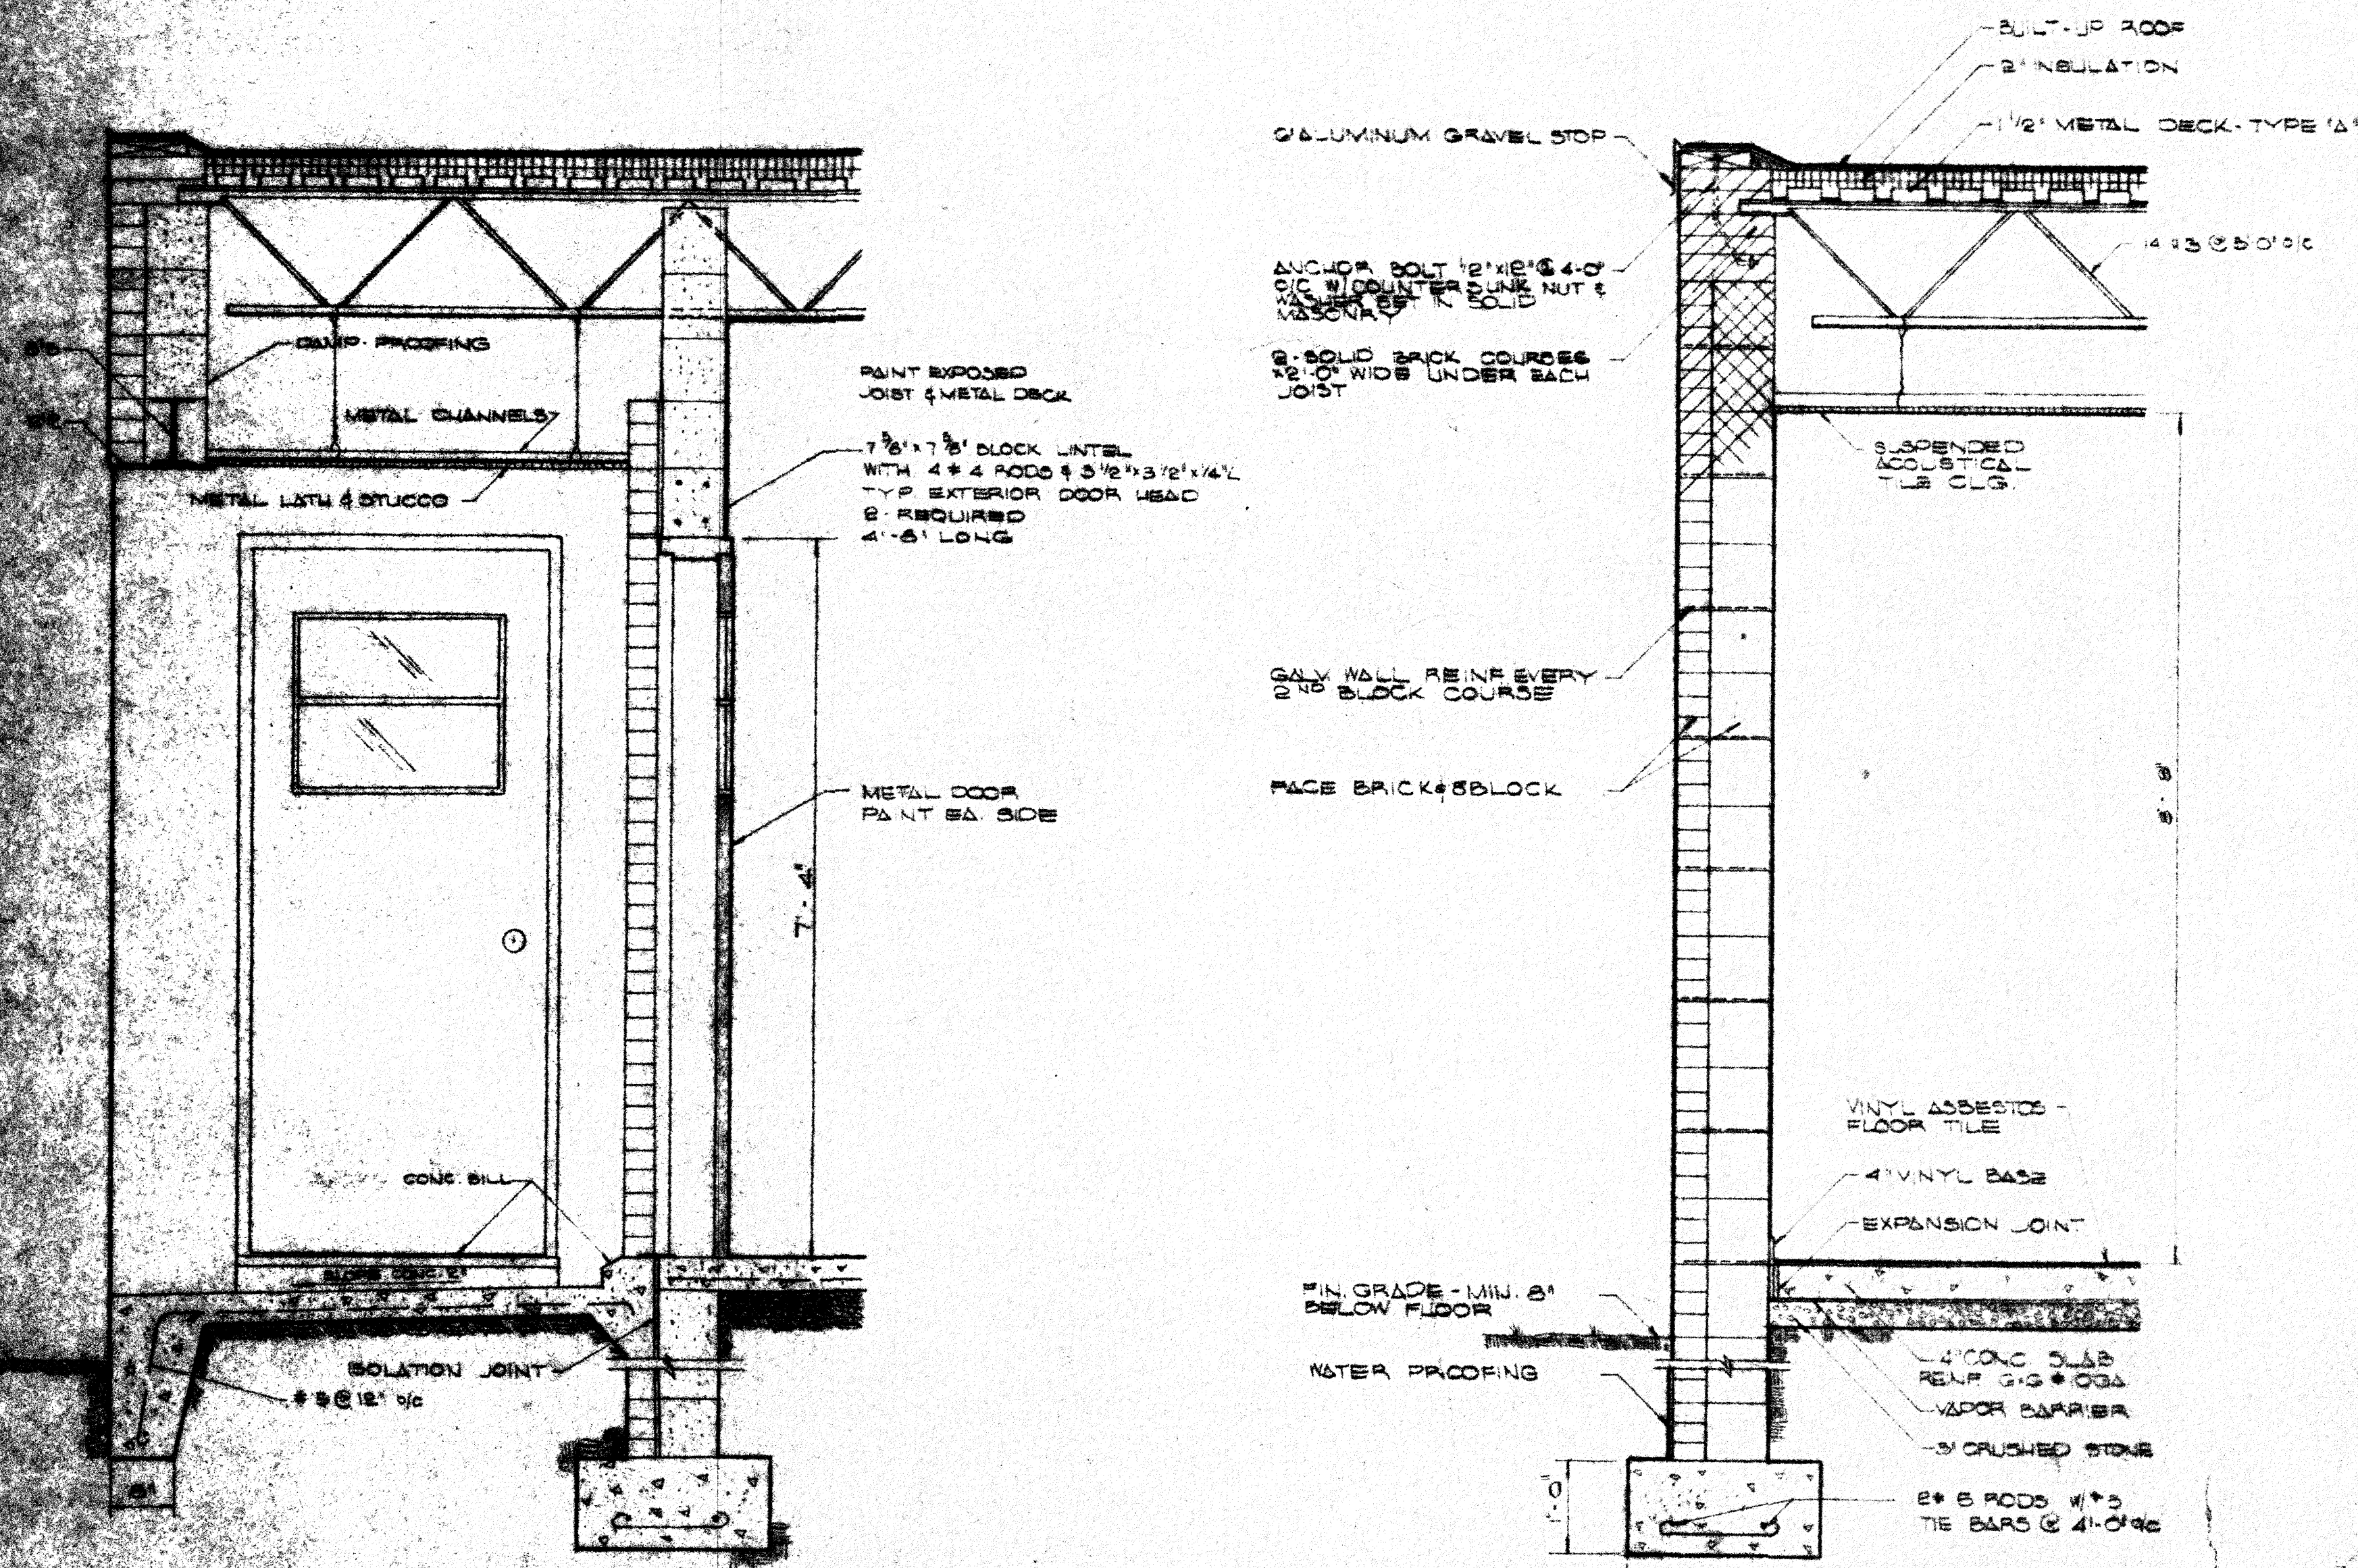


TYP. WALL SECTION
SCALE: 3/4" = 1'-0"

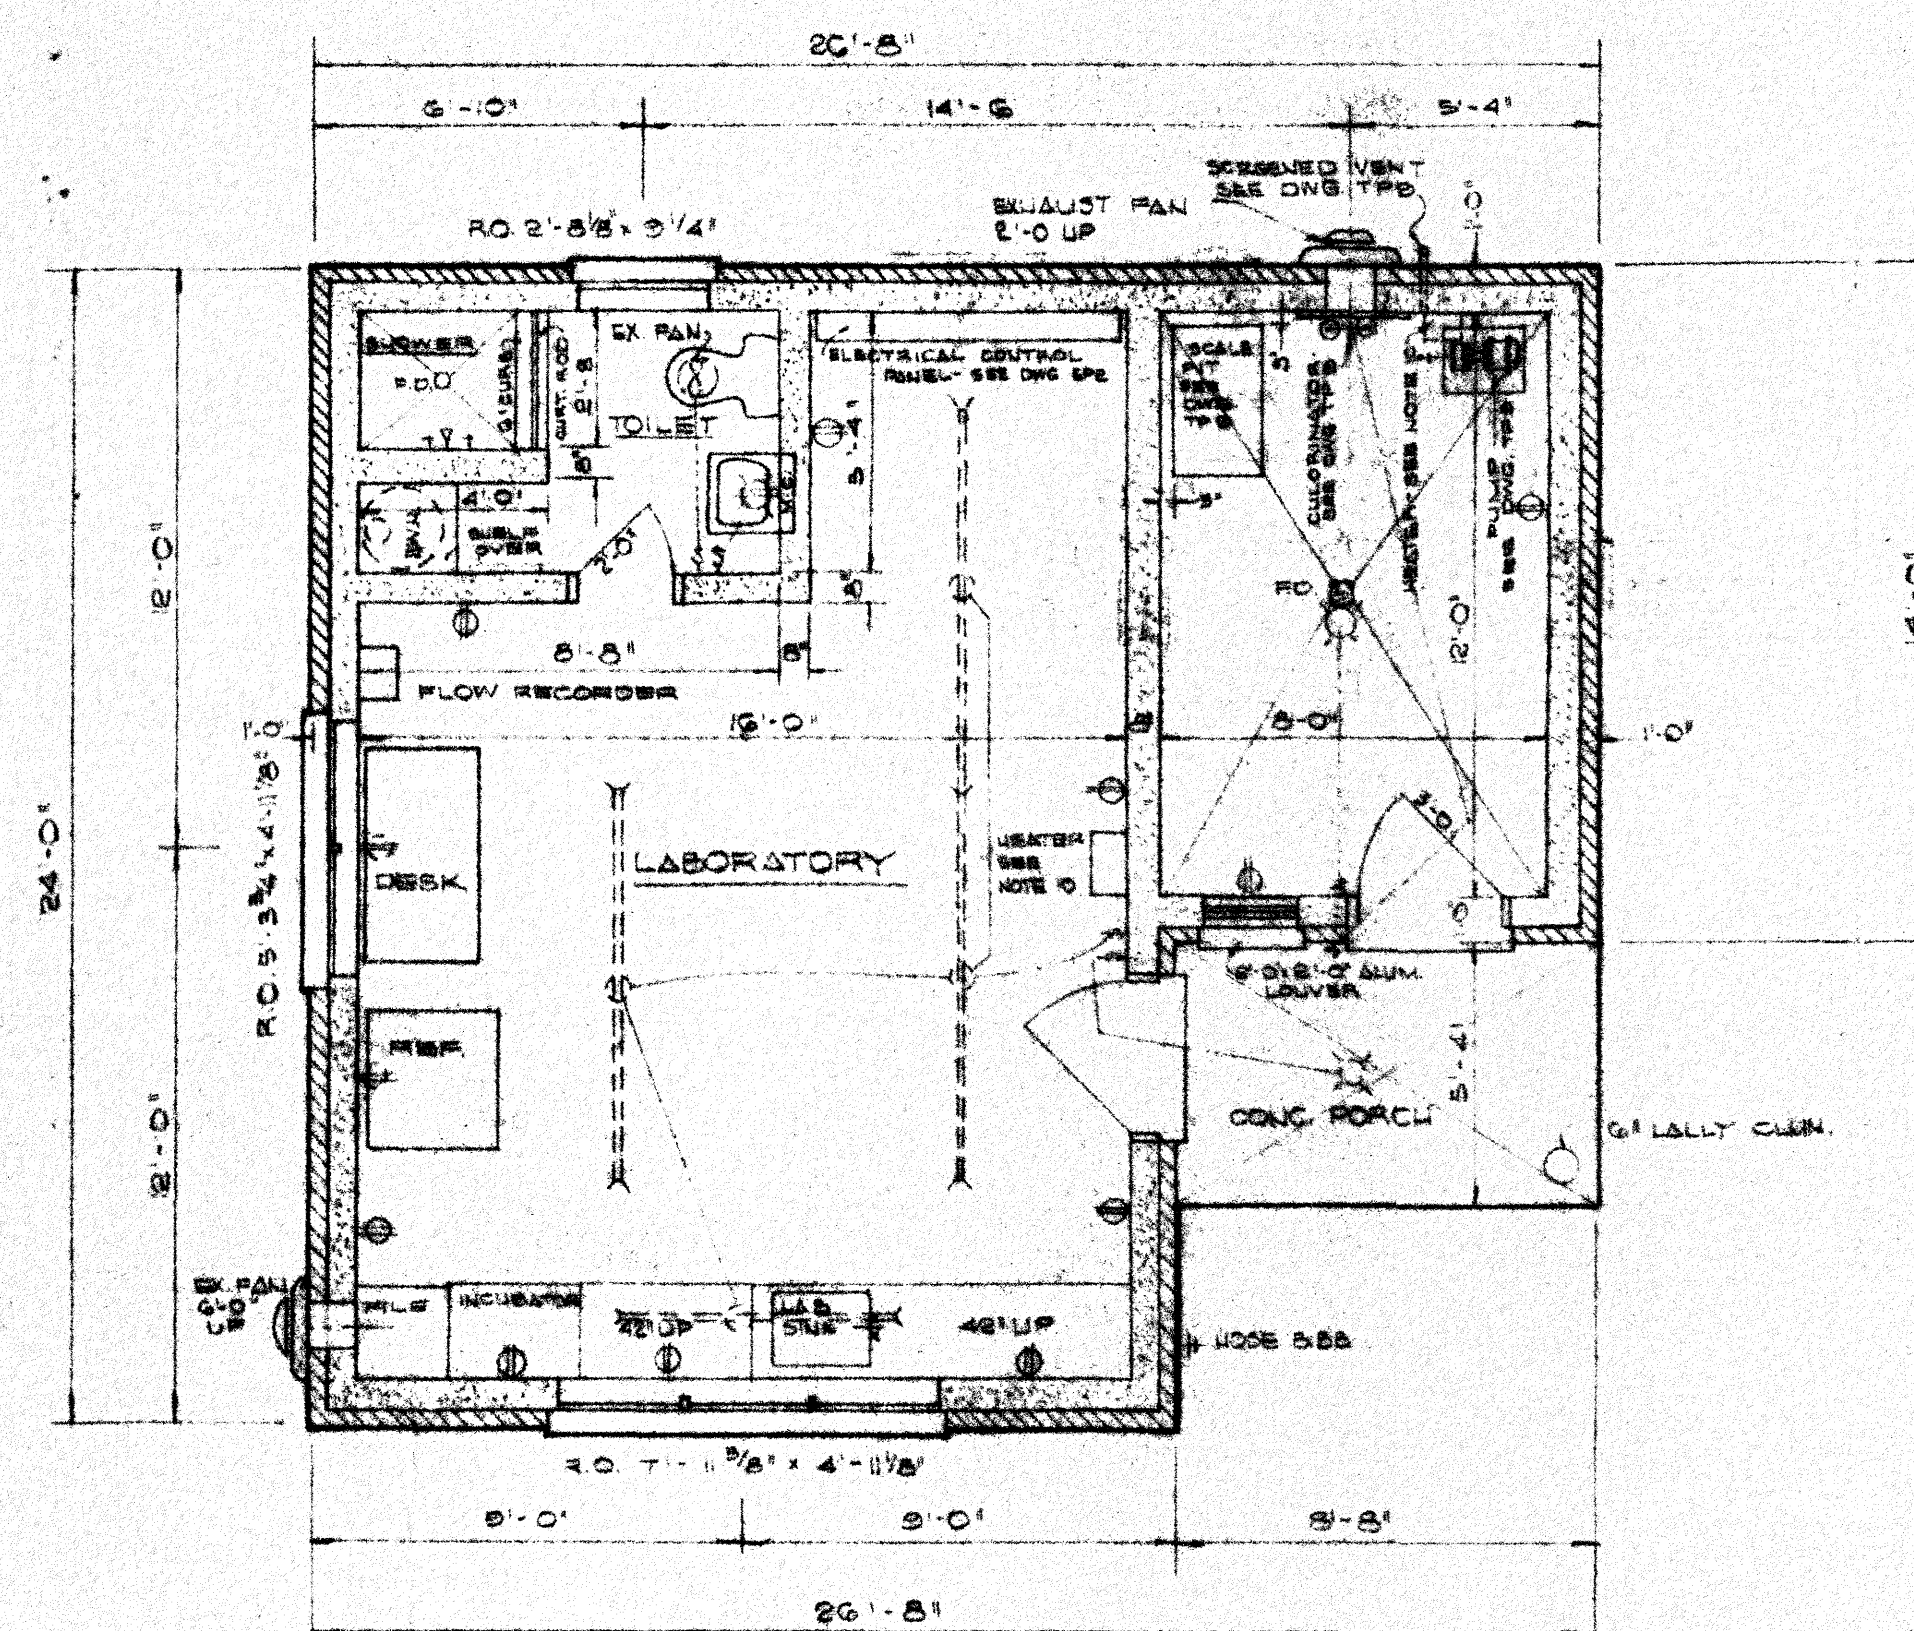

FLOOR PLAN
SCALE: 1/4" = 1'-0"

FINISH			SCHEDULE		
SPACE	FLOOR	BASE	WALLS	CEILINGS	REMARKS
LABORATORY	VINYL ASBESTOS TILE	4" VINYL COVE	PAINTED BLOCK	SUSP. ACoust. GAL. TILE	
TOILET	VINYL ASBESTOS TILE	4" VINYL COVE	PAINTED BLOCK	CERAMIC ACoust. GAL. TILE	
SHOWER	CERAMIC TILE	CERAMIC TILE	CERAMIC TILE 3" x 6" x 1/4"	CERAMIC ACoust. GAL. TILE	CERAMIC TILE 3" x 6" x 1/4"
COLORNE ROOM	TROWEL CONCRETE	NONE	PAINTED BLOCK	PANT EXPOSED STEEL	PAINTED BLOCK OVER
COND. PORCH	TROWEL CONCRETE	NONE	EXPOSED BRICK	METAL LATH & STUCCO	

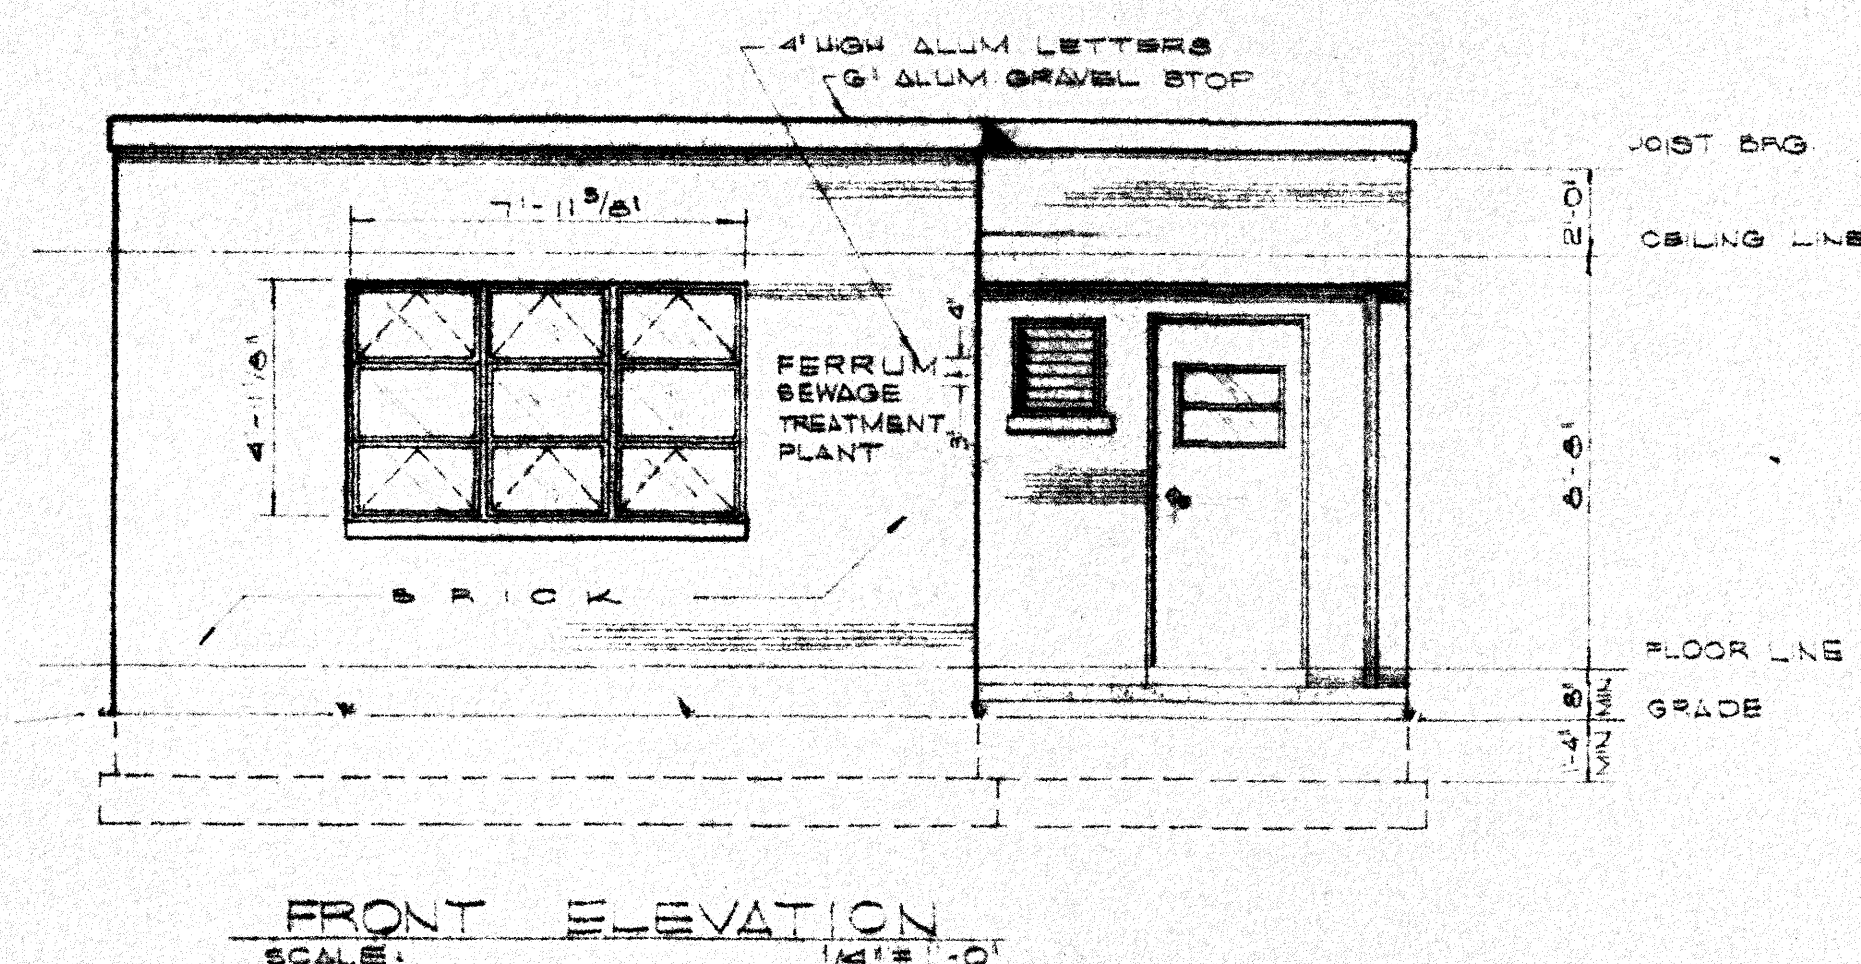

FRONT ELEVATION

	4
	3
	2
1-8-70	1
DATE	REVISIONS

PREPARED BY
J. A. GUSTIN & ASSOCIATES
CONSULTING ENGINEERS
MARTINSVILLE, VIRGINIA

FERRUM WATER AND SEWERAGE AUTHORITY

SERVICE BUILDING

WASTE TREATMENT FACILITY - PROPOSAL

DATE	APPROVED BY	FOR AGENCY USE ONLY