




BALZER & ASSOCIATES
PLANNERS / ARCHITECTS
ENGINEERS / SURVEYORS

Roanoke / Richmond
New River Valley / Staunton
Harrisonburg / Lynchburg
www.balzer.cc

1208 Corporate Circle
Roanoke, VA 24018
540.772.9580

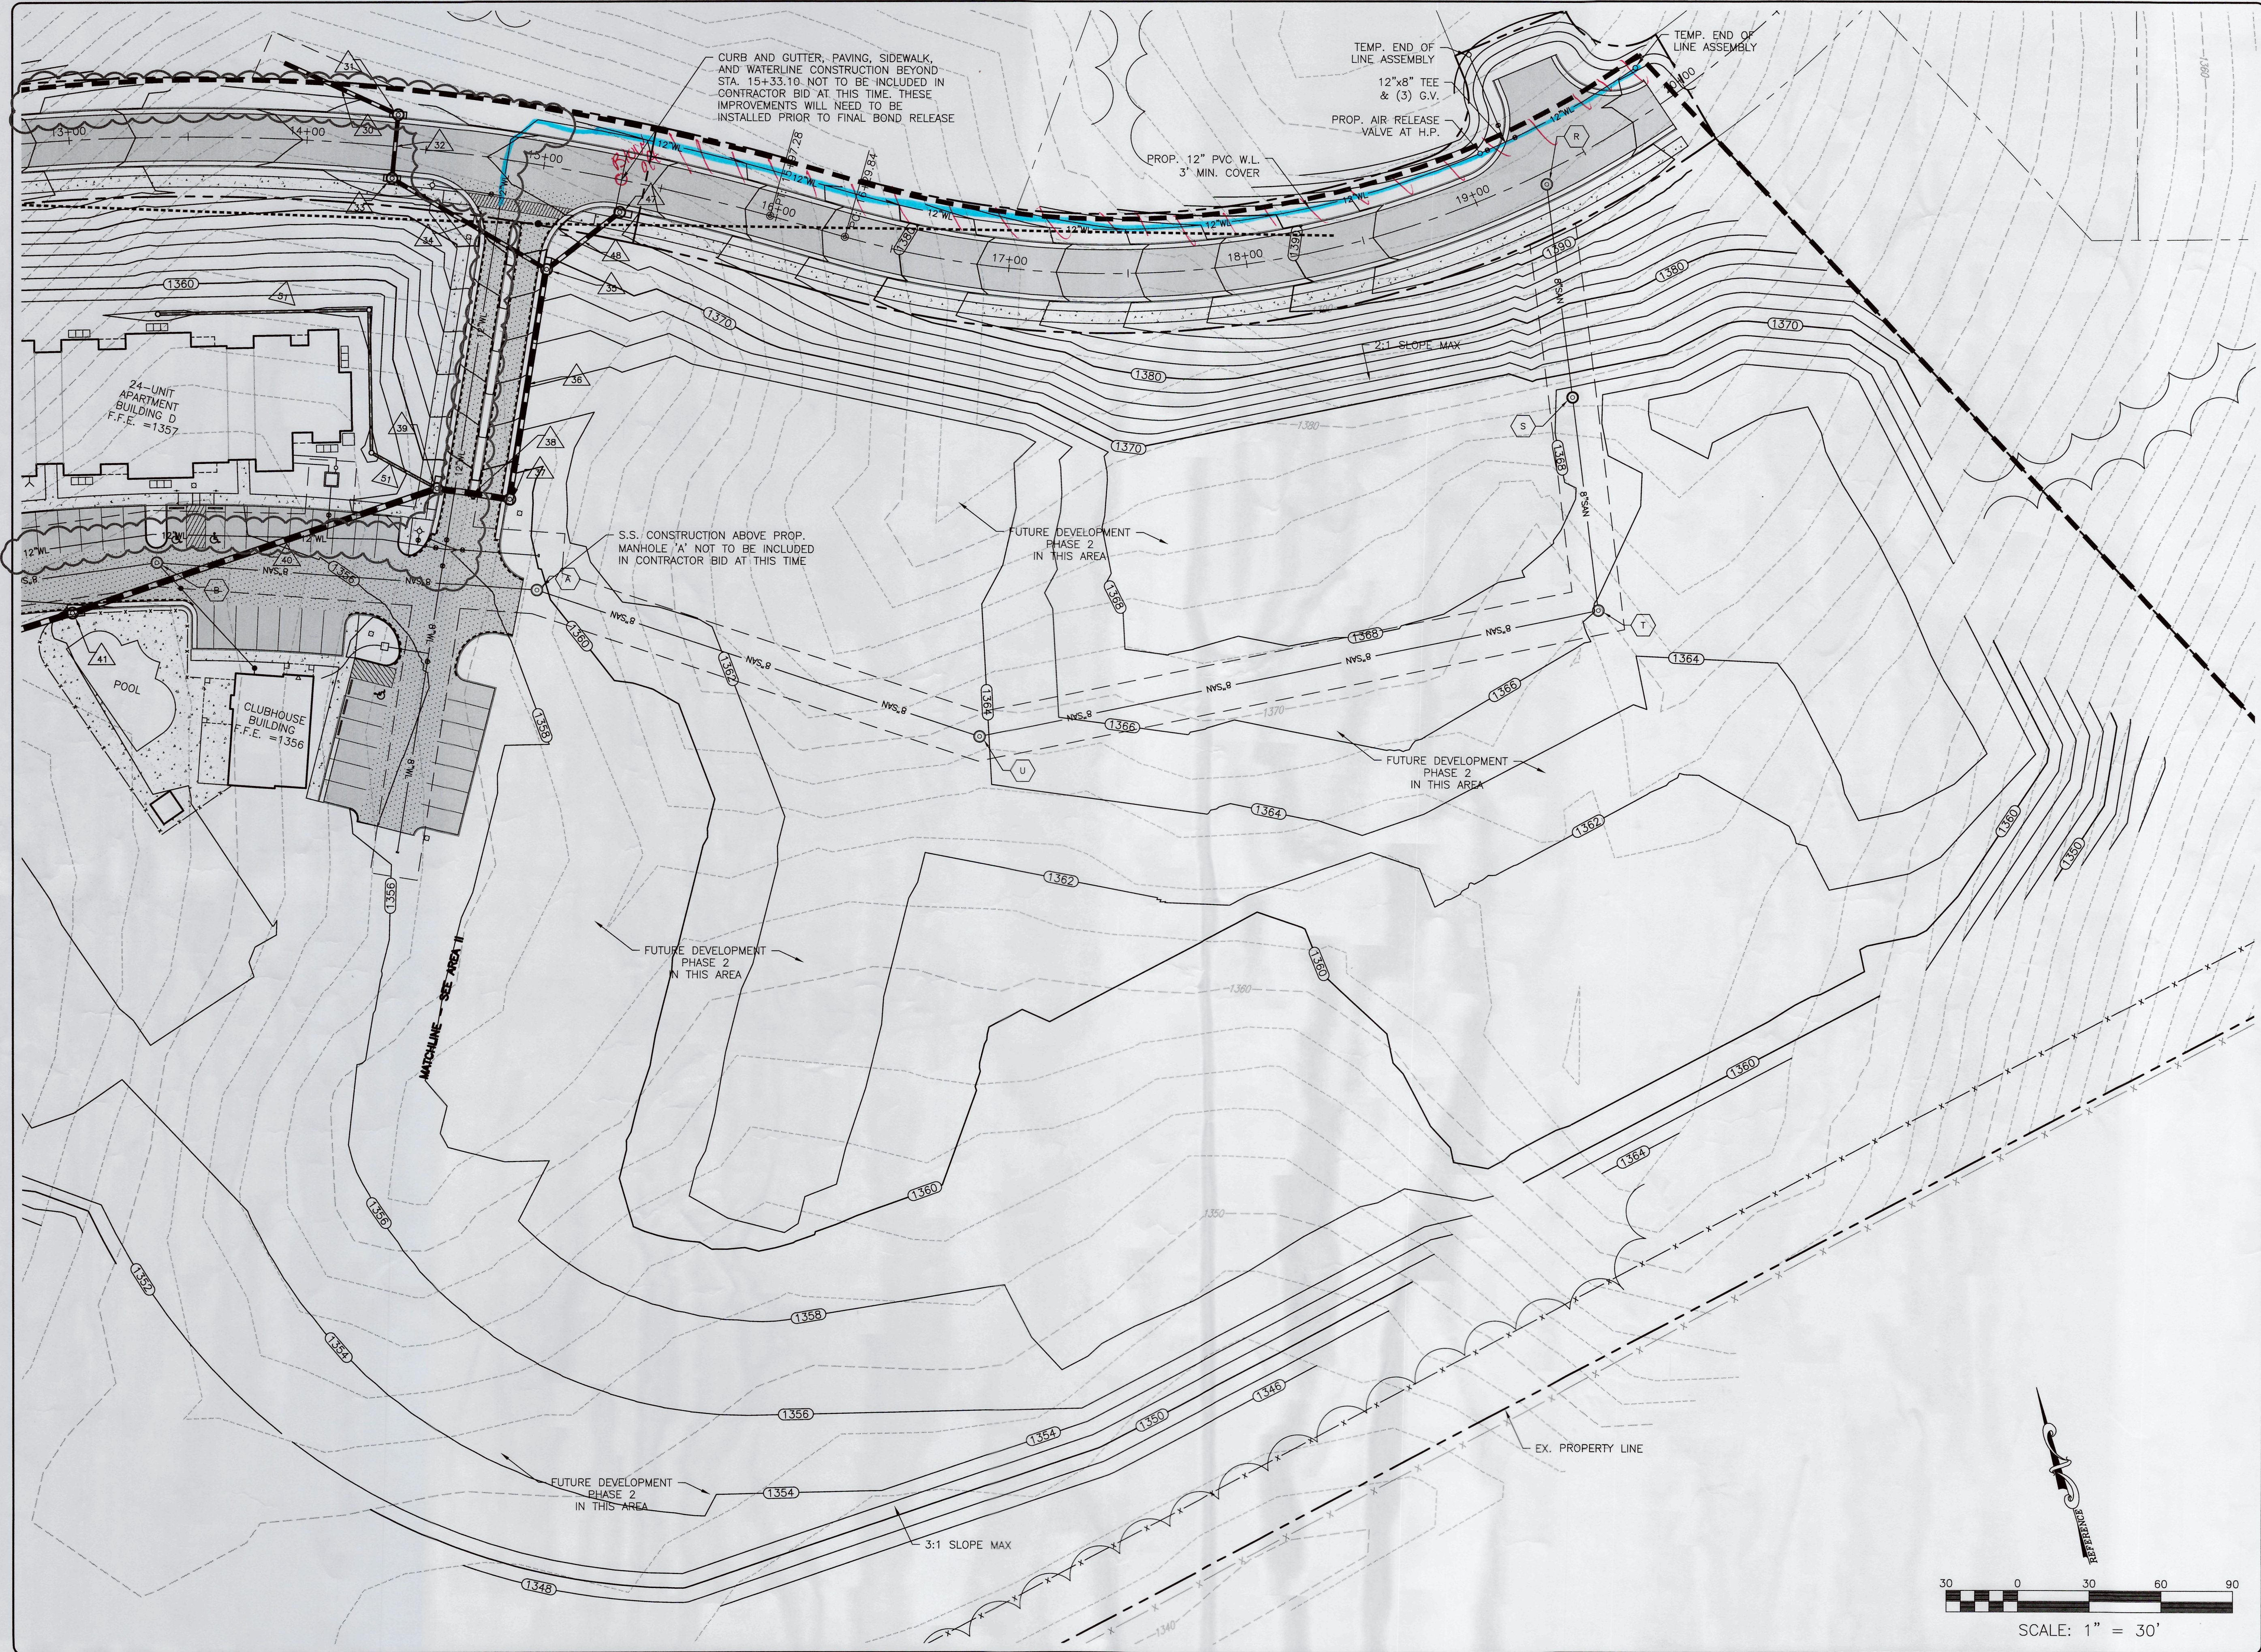

FIELDSTONE PHASE I

ROUGH GRADING PLAN - AREA III

AMSTERDAM DISTRICT
BOTETOWN COUNTY, VIRGINIA

DRAWN BY	CLL
DESIGNED BY	CPB
CHECKED BY	CPB
DATE	1/25/2019
SCALE	1" = 30'
REVISIONS	
	4/30/2019
	10/8/2019
	12/5/2019
	10/14/2020
	2/11/2021
	3/8/2023

C8
PROJECT NO. 04170078.01