


REGIONAL TRAINING CENTER

ROANOKE COUNTY, VIRGINIA

ARCHITECT'S PROJECT No. 9826

MAY 3, 1999

LOCATION MAP

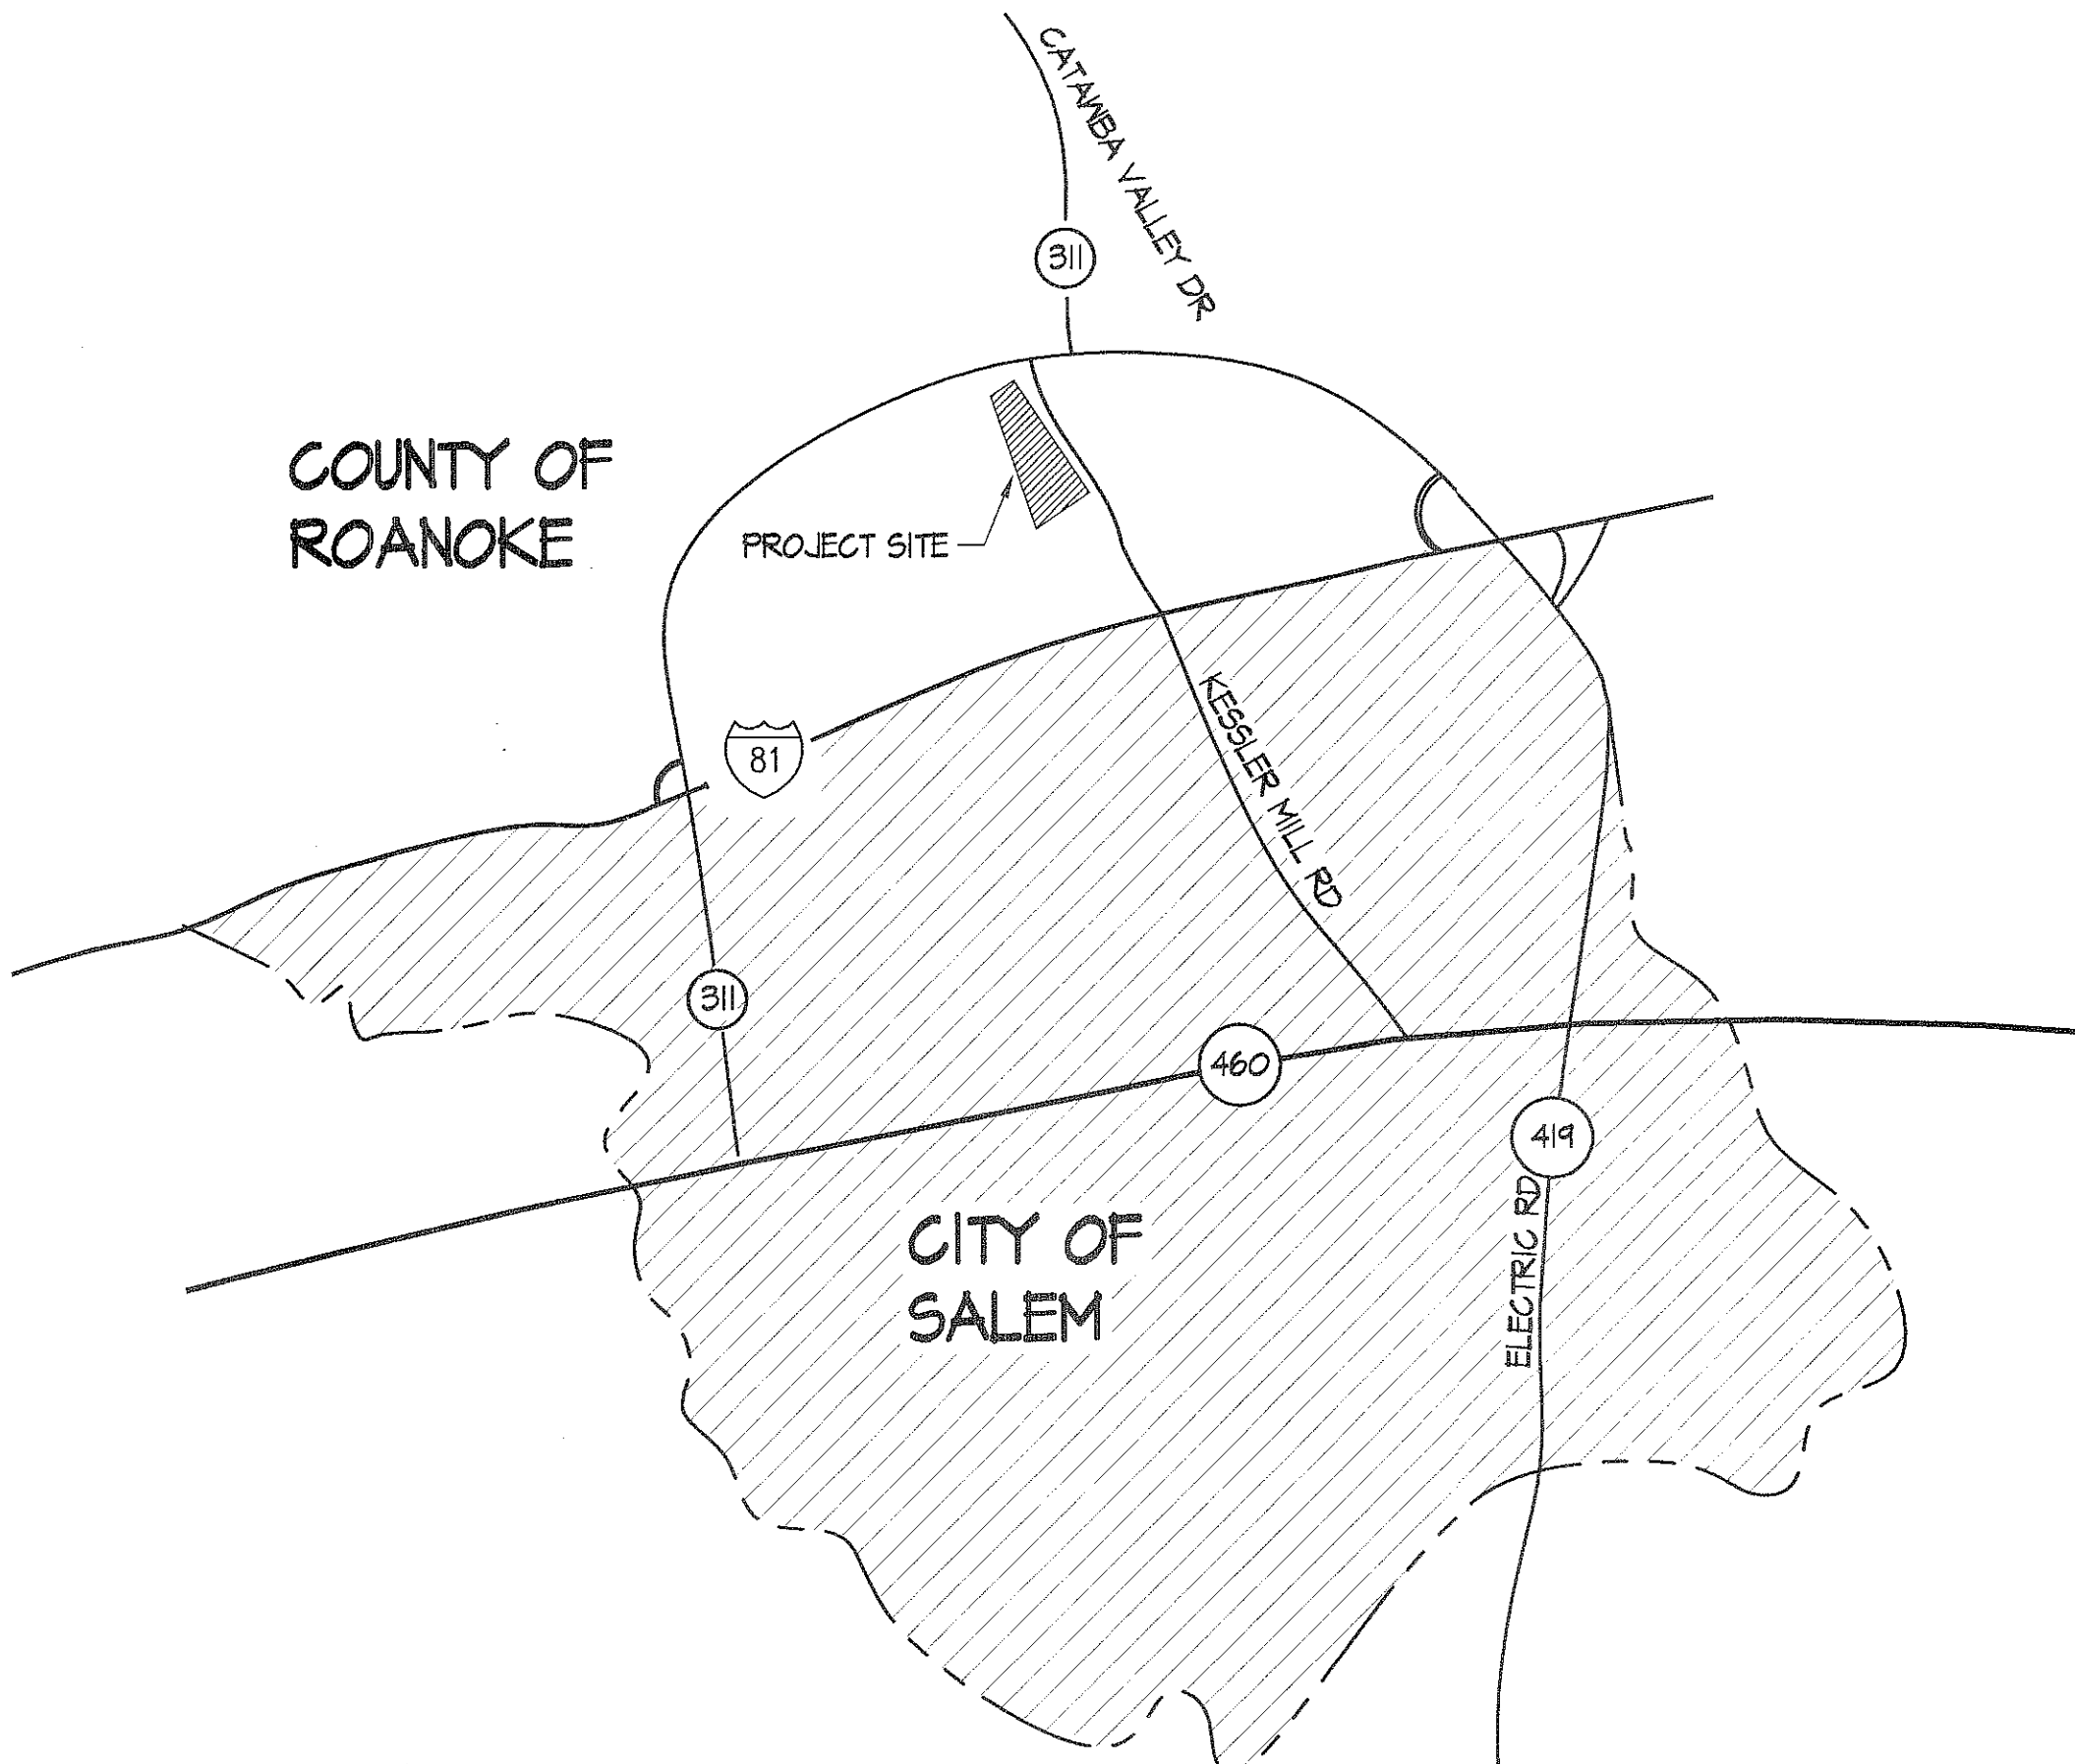

AS BUILT DRAWING INDEX

GENERAL	1	6-001	TITLE SHEET	PLUMBING	40	P-101	FLOOR PLAN - PLUMBING
	2	6-002	GRAPHIC STANDARDS		41	P-501	PART PLANS, DETAILS, SCHEDULES, AND NOTES
					42	P-502	WATER PIPING DIAGRAM
					43	--	NOT USED (DRAWING 43 OF 55)
CIVIL	4	C-001	ROANOKE COUNTY COVER SHEET				
	5	C-101	SITE DEMOLITION PLAN	SPRINKLER	44	SP-101	FLOOR PLAN - FIRE SPRINKLER
	6	C-102	SITE PLAN		45	SP-102	ATTIC PLAN - FIRE SPRINKLER
	7	C-104	ROANOKE COUNTY EROSION AND SEDIMENT CONTROL DETAILS				
	8	C-105	ROANOKE COUNTY SEWER DETAILS	HVAC	46	H-101	FLOOR PLAN - HVAC
	9	C-106	ROANOKE COUNTY WATER DETAILS		47	H-501	PART PLANS, DETAILS, SCHEDULES, AND NOTES
	10	C-601	SITE DETAILS		48	H-502	DETAILS, SCHEDULES, AND NOTES
					49	H-503	DETAILS, SCHEDULES, AND NOTES
LANDSCAPING	11	L-101	LANDSCAPING PLAN AND DETAILS		50	H-504	ELECTRICAL CONTROL SEQUENCE DIAGRAMS
STRUCTURAL	12	S-101	FOUNDATION PLAN	ELECTRICAL	51	E-101	ELECTRICAL SITE PLAN AND LEGEND
	13	S-102	ROOF FRAMING PLAN		52	E-102	ELECTRICAL POWER PLAN
	14	S-601	GENERAL STRUCTURAL NOTES, SCHEDULES, AND DETAILS		53	E-103	ELECTRICAL LIGHTING PLAN
	15	S-602	SECTIONS		54	E-104	ELECTRICAL COMMUNICATIONS SYSTEM PLAN
					55	E-201	ELECTRICAL LIGHTING FIXTURE AND PANELBOARD SCHEDULE
ARCHITECTURAL	16	A-101	FLOOR PLAN				
	17	A-102	REFLECTED CEILING PLAN				
	18	A-103	ROOF PLAN				
	19	A-104	BUILDING CODE COMPLIANCE PLAN				
	20	A-201	DOOR SCHEDULE, FRAME TYPES, DOOR TYPES				
	21	A-202	DOOR FRAME DETAILS, WALL SCHEDULE				
	22	A-203	FINISH SCHEDULE, TOILET ACCESSORY SCHEDULE				
	23	A-301	EXTERIOR ELEVATIONS				
	24	A-302	EXTERIOR ELEVATIONS				
	25	A-303	EXTERIOR ELEVATIONS				
	26	A-304	CASEWORK ELEVATIONS				
	27	A-401	BUILDING SECTIONS				
	28	A-501	FLOOR PLAN DETAILS				
	29	A-502	FLOOR PLAN DETAILS				
	30	A-503	FLOOR PLAN DETAILS				
	31	A-504	FLOOR PLAN DETAILS				
	32	A-505	WALL SECTIONS				
	33	A-506	WALL SECTIONS				
	34	A-507	VESTIBULE, IOI SECTION				
	35	A-508	WALL SECTIONS AND DETAILS				
	36	A-601	DETAILS				
	37	A-602	DETAILS				
	38	A-603	DETAILS				
	39	A-604	DETAILS				

AS-BUILT

THESE AS-BUILT OR RECORD DRAWINGS
(OR CORRECTED SPECIFICATIONS) HAVE BEEN
PREPARED, IN PART, ON THE BASIS OF
INFORMATION COMPILED AND FURNISHED BY
OTHERS. THE ARCHITECT WILL NOT BE
RESPONSIBLE FOR ANY ERRORS OR OMISSIONS
WHICH HAVE BEEN INCORPORATED INTO THESE
DOCUMENTS AS A RESULT.


AS-BUILT

THESE AS-BUILT OR RECORD DRAWINGS
(OR CORRECTED SPECIFICATIONS) HAVE BEEN
PREPARED, IN PART, ON THE BASIS OF
INFORMATION COMPILED AND FURNISHED BY
OTHERS. THE ARCHITECT WILL NOT BE
RESPONSIBLE FOR ANY ERRORS OR OMISSIONS
WHICH HAVE BEEN INCORPORATED INTO THESE
DOCUMENTS AS A RESULT.

MarshWitt

MarshWitt Associates, P.C.
Architecture
Planning
Value Analysis
315 King George Ave. S.
Roanoke, VA 24011
Phone: 540 982 1444
Fax: 540 982 8300
email: marshwit@ver.net

CONSULTANTS

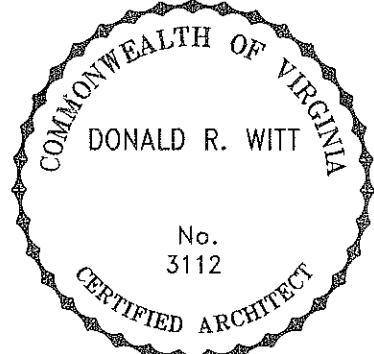

ROANOKE VALLEY
FIRE / EMS
REGIONAL
TRAINING
CENTER

ROANOKE COUNTY
VIRGINIA
AS BUILTS

COMM. NO: 982

DESIGNED BY: J

DRAWN BY: S

CHECKED BY: D

PLOT SCALE: 1 =

COPYRIGHT
MARSHWITT ASSOCIATES P.C. 199

[illegible][illegible]

--	--	--

on	100	100	100	100
----	-----	-----	-----	-----

MY	DATE	DESCRIPTION
----	------	-------------

COVER SHEET

AS BUILT

1. 本表由填表人填写，填写时请参照《填报说明》。

0001

11-11-11

SHEET 1 OF 3

0	1	2
---	---	---