


PLOT DATE
6/18/2019
9:22:13 AM



1 FIRST FLOOR PLAN

A1.1 1/8" = 1'-0"

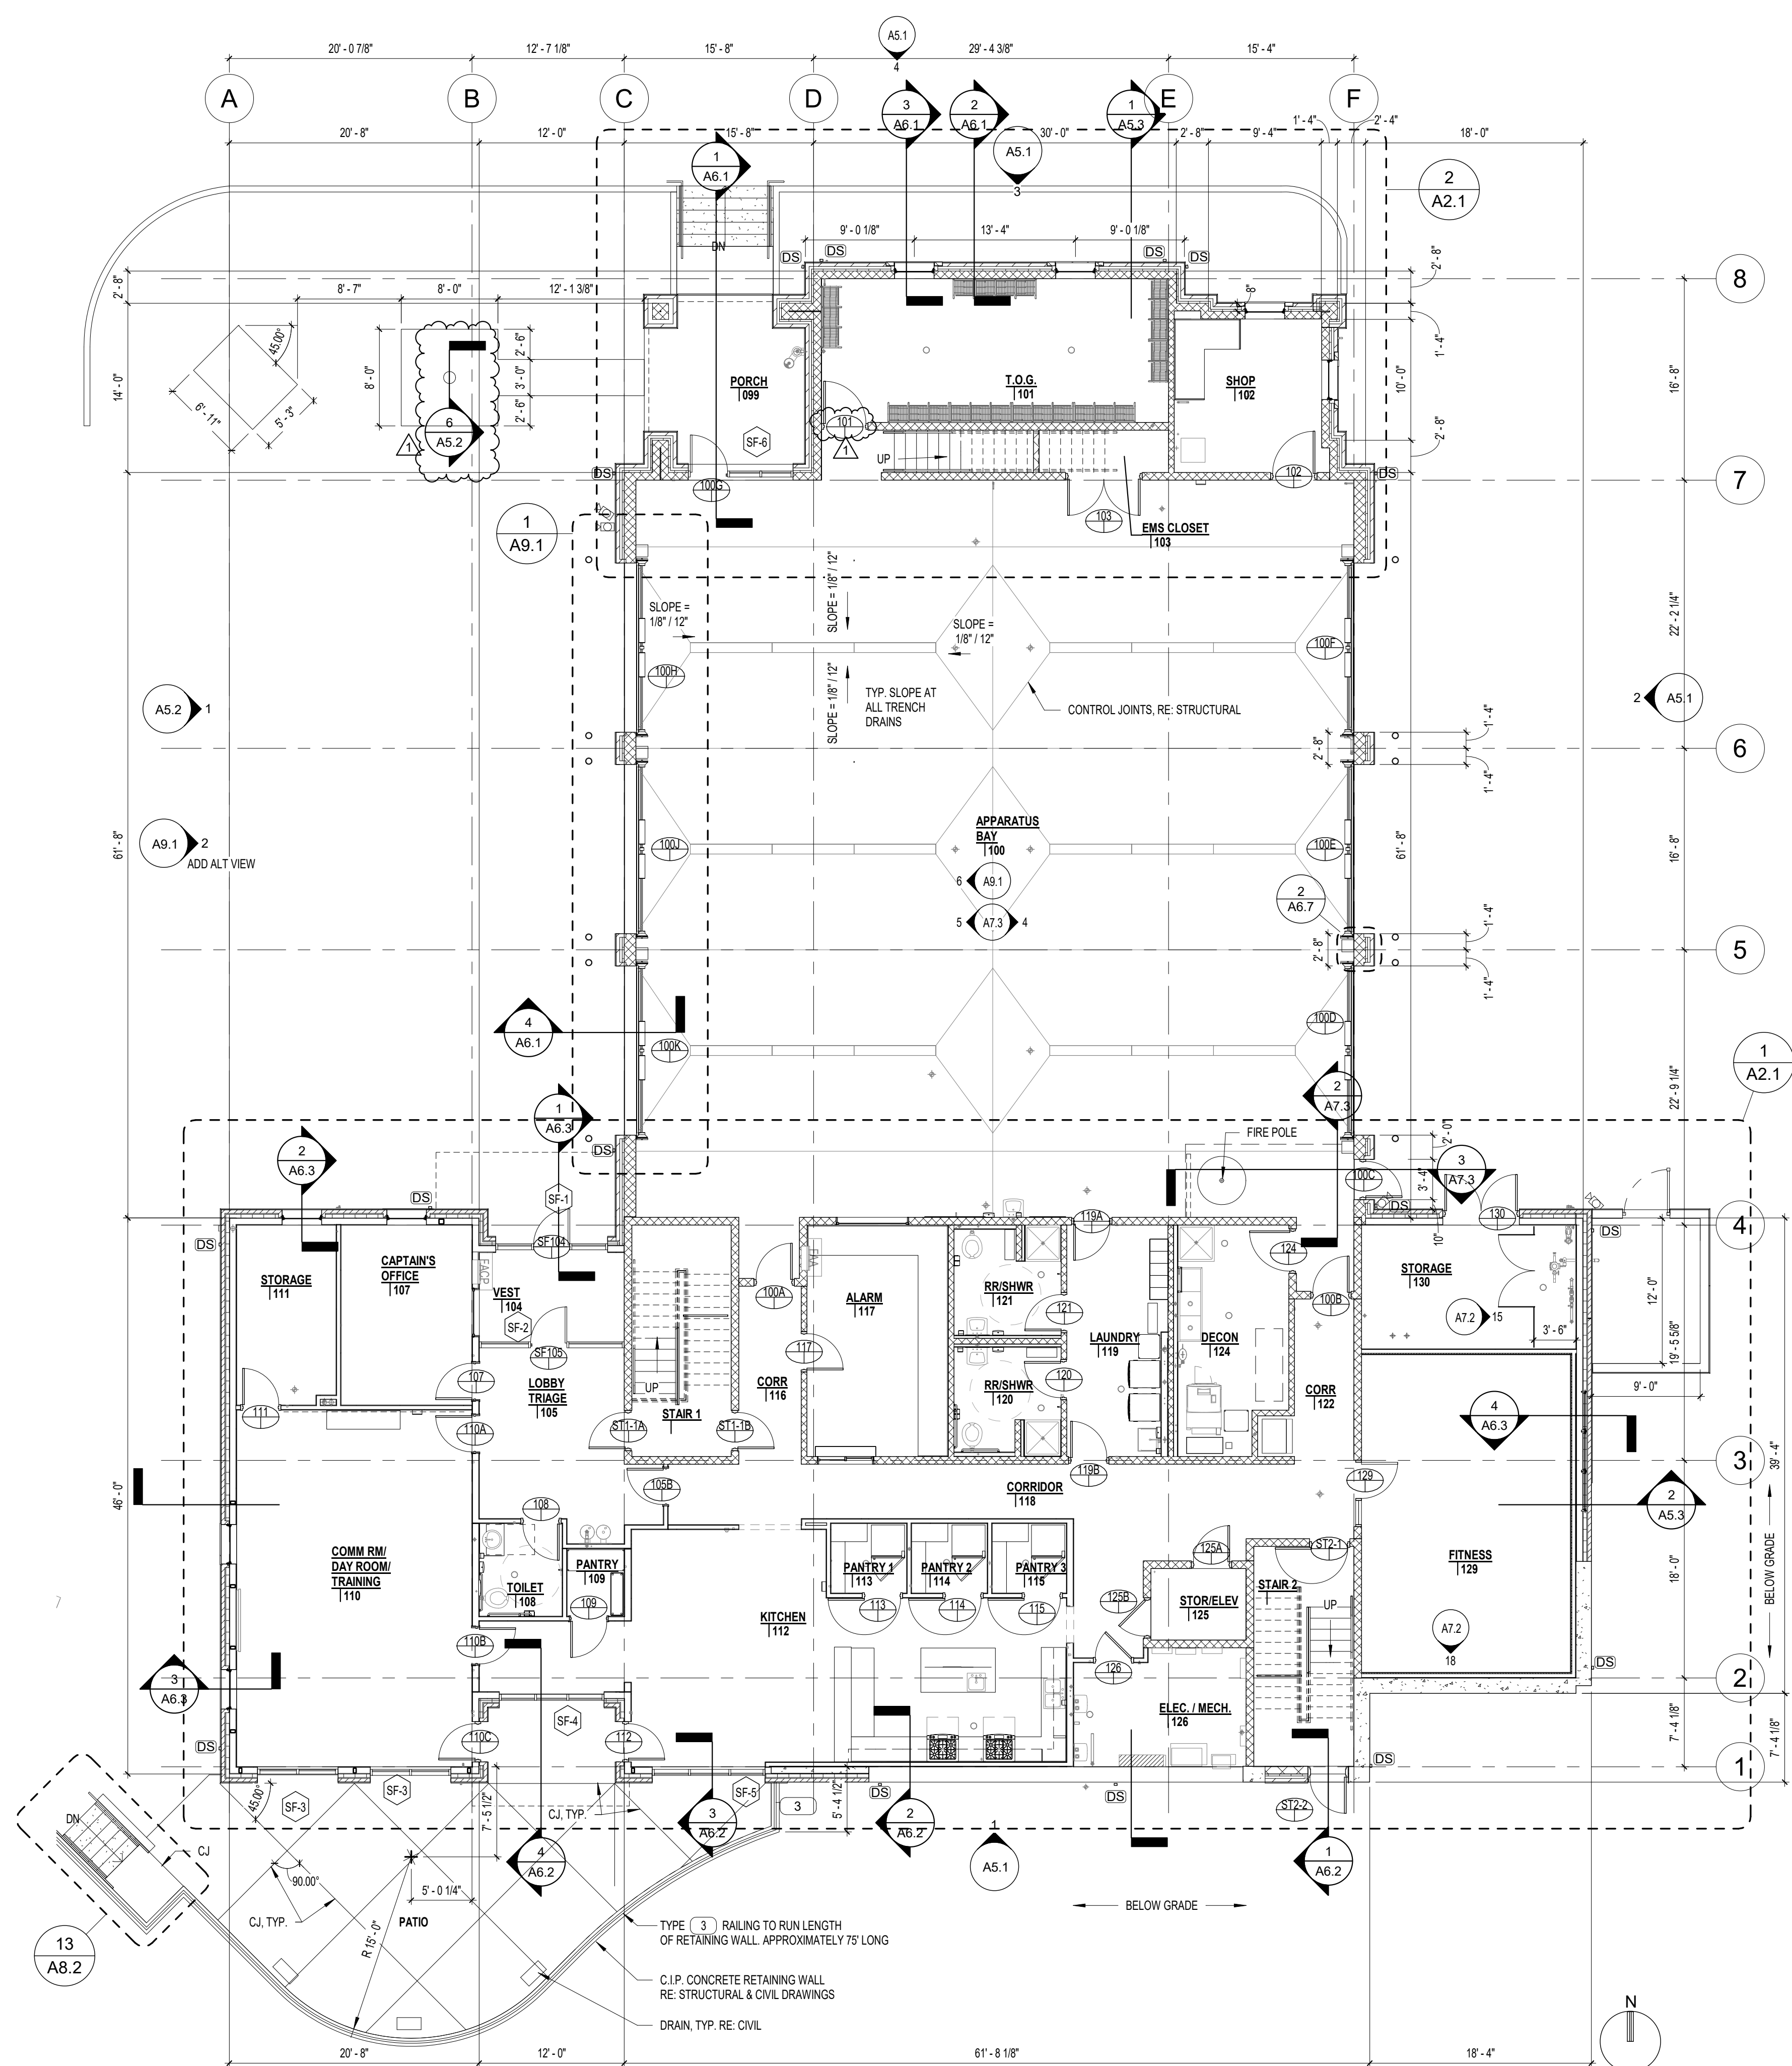

2 ARCH SITE PLAN

A1.1 1/16" = 1'-0"

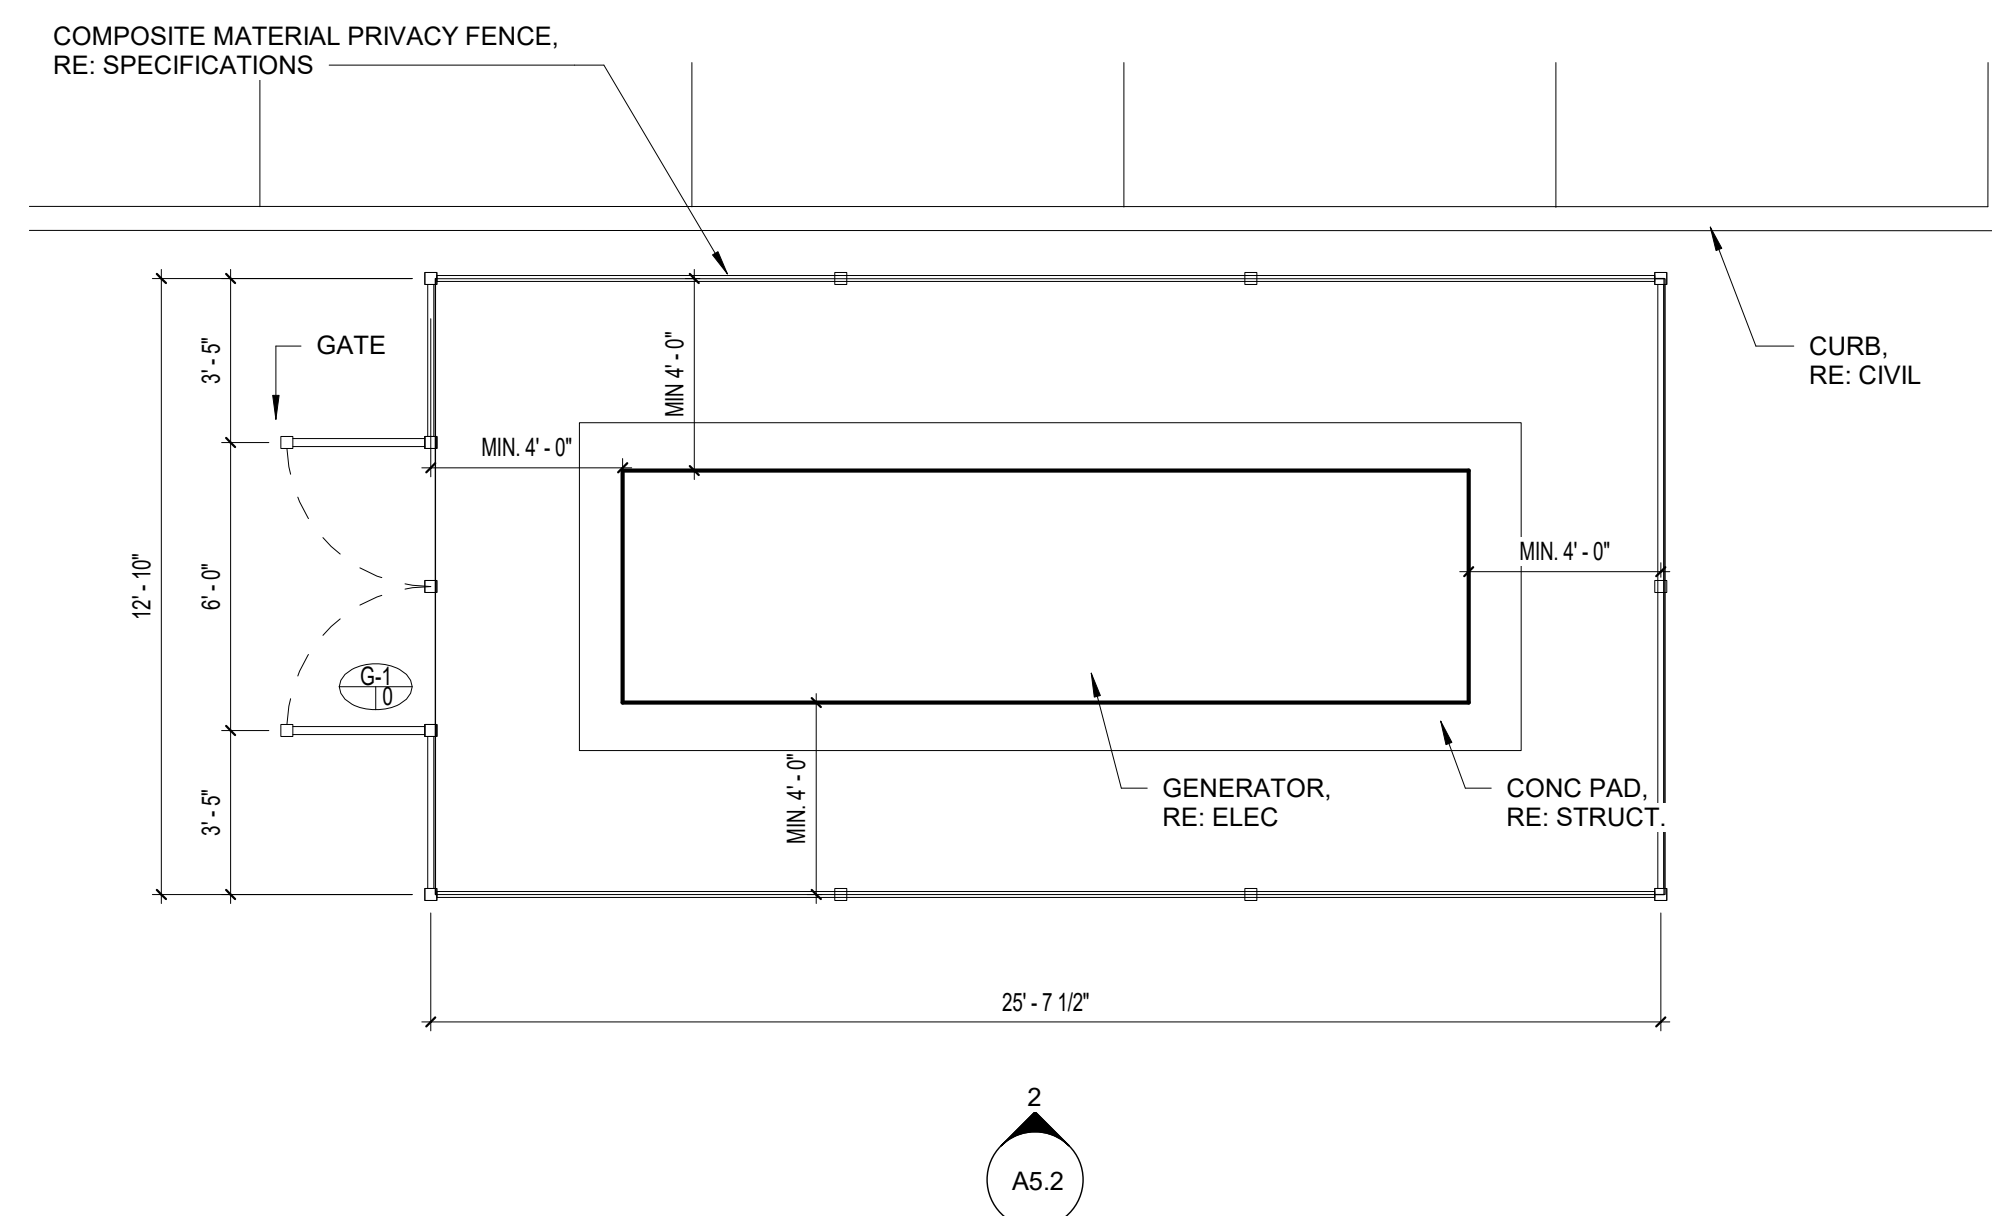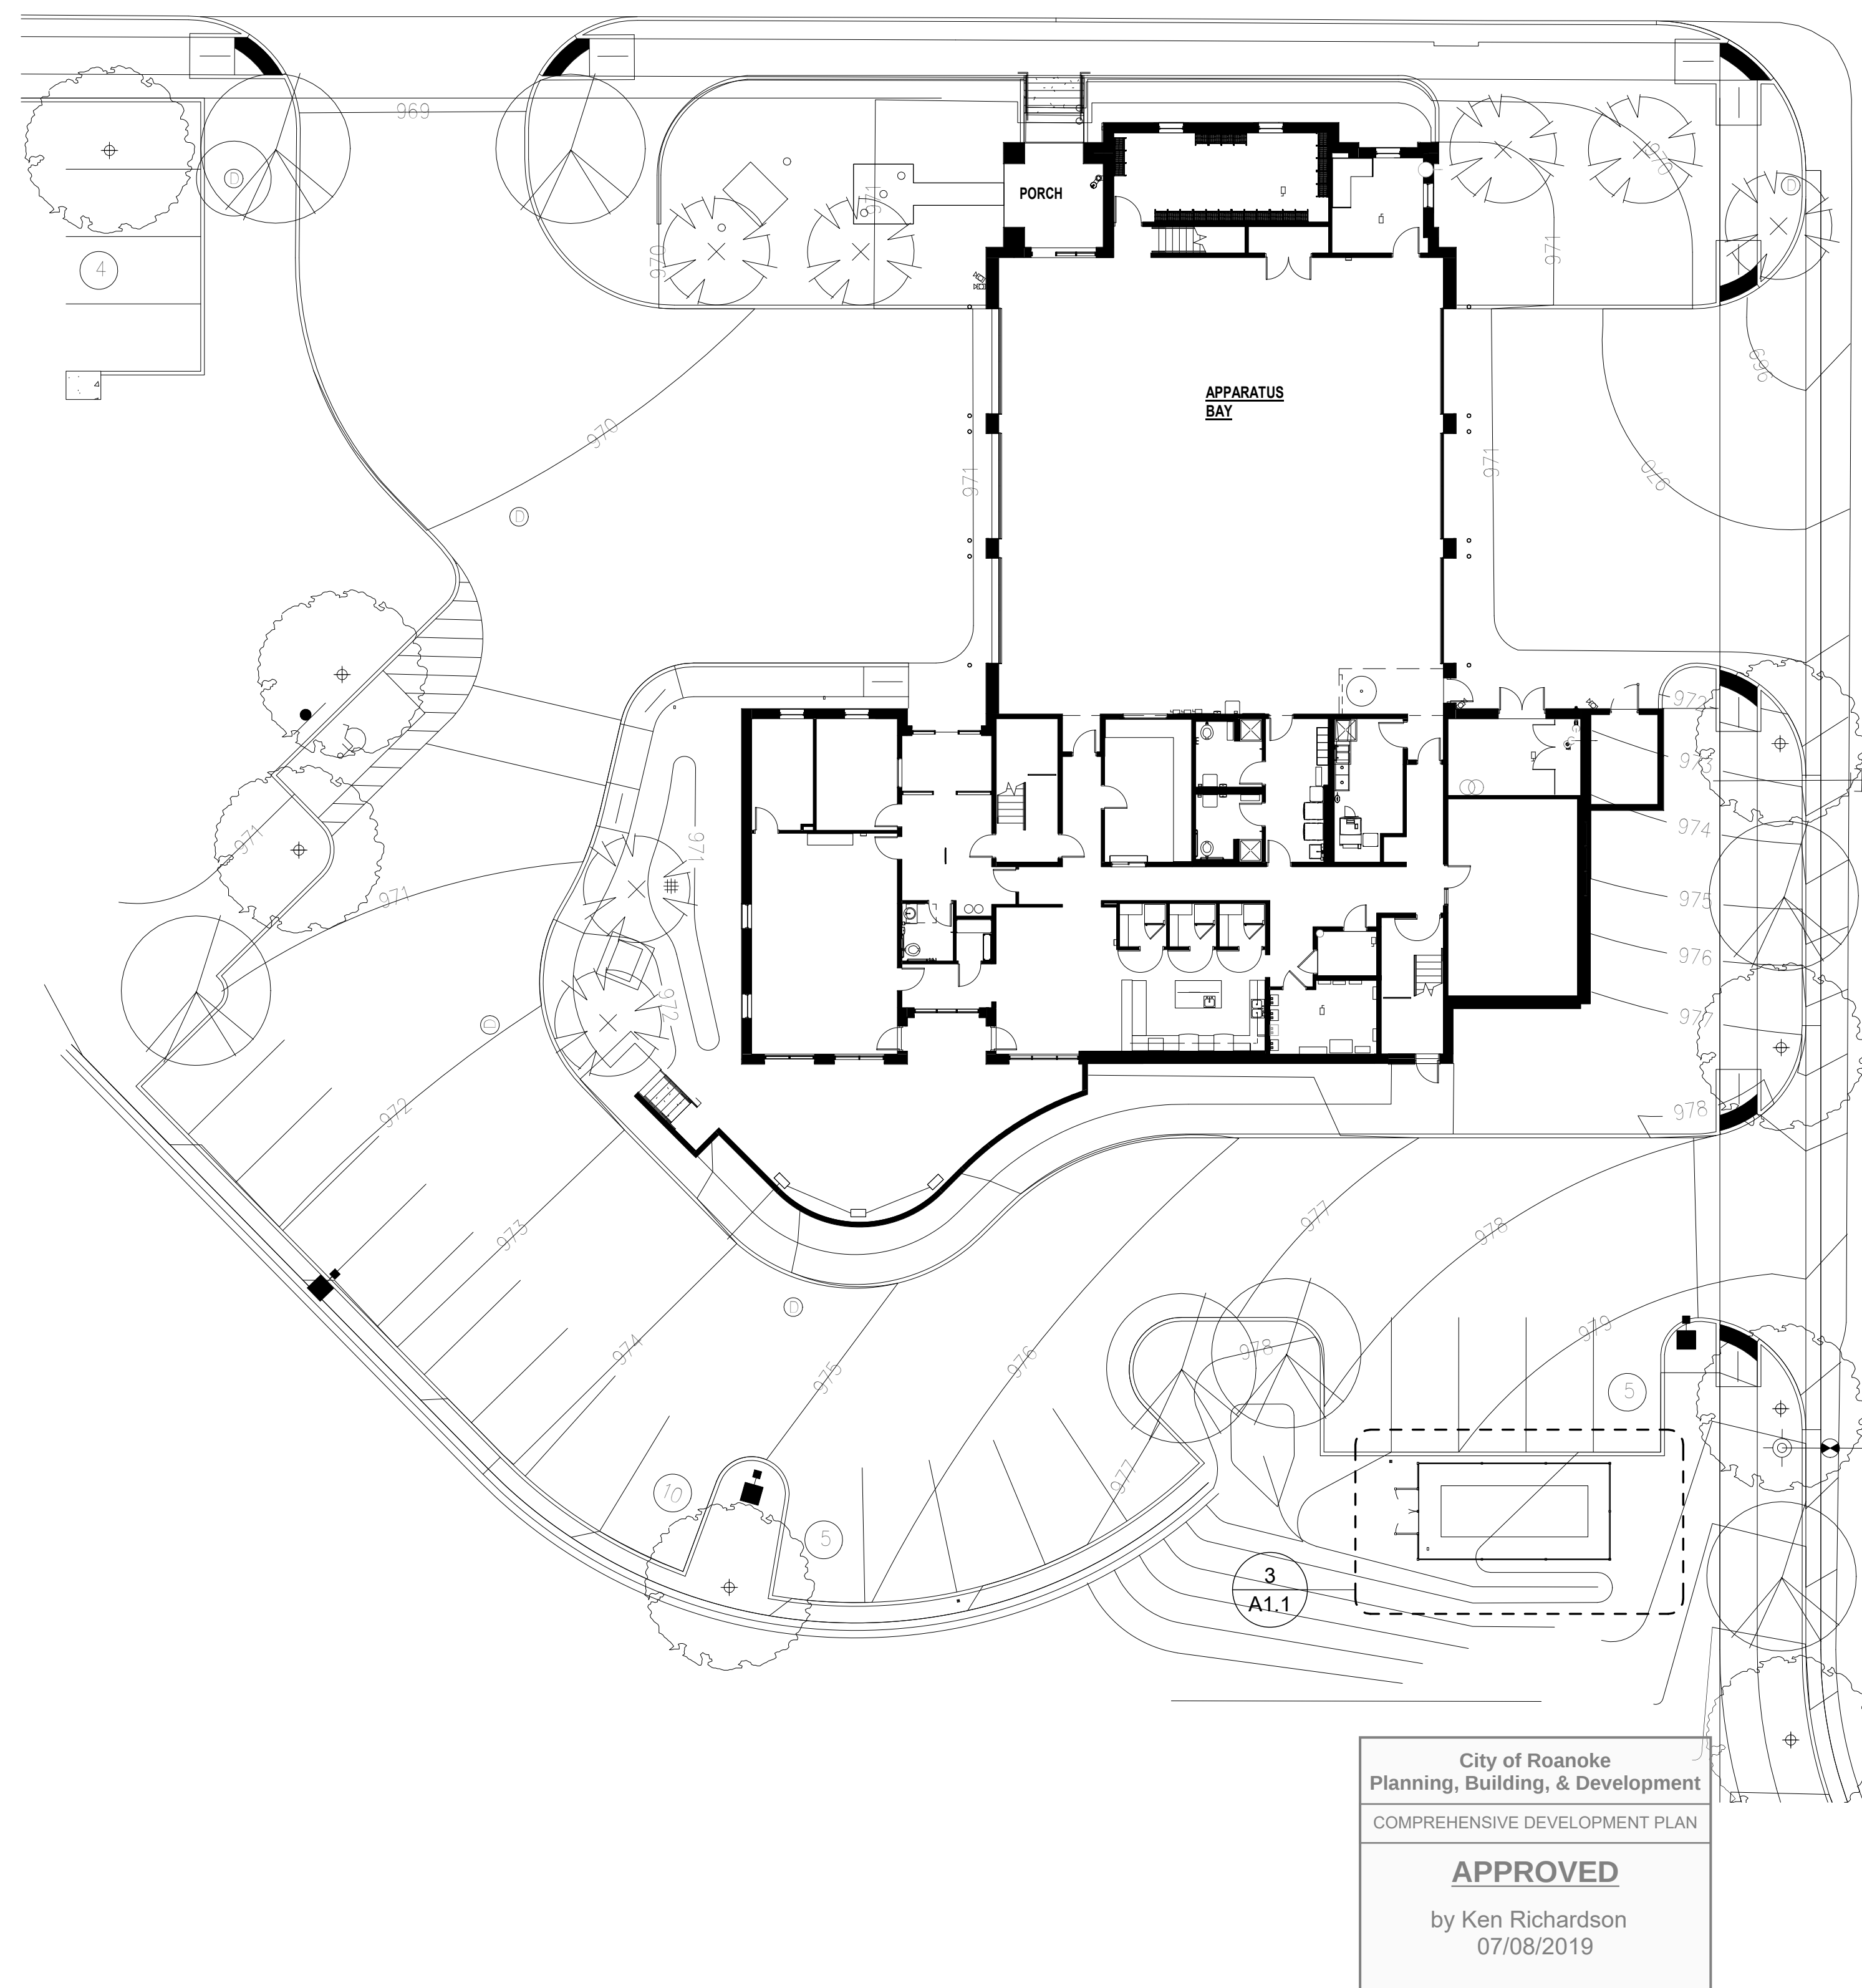


3 ENLARGED GENERATOR PLAN

A1.1 1/4" = 1'-0"

GENERAL NOTES

1. PROVIDE BLOCKING IN WALLS FOR GRAB BARS, ROOF LADDER & OTHER WALL MOUNTED DEVICES THAT REQUIRE FIRM ATTACHMENT.
2. ALL EXISTING EXTERIOR WALLS SHALL RECEIVE TYPE H FURNISHING UNLESS NOTED OTHERWISE.

PLAN NOTES

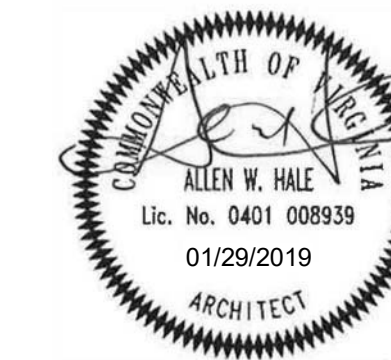

PROJECT TITLE

ROANOKE FIRE-EMS
STATION NO. 7

BID SET

SFCs Architecture
Engineering
Planning
Interiors
SFCs Inc. • 305 South Jefferson Street
Roanoke, Virginia 24011.2003
540.344.6664 • Fax 540.343.6925
www.sfcsc.com

PROJECT DESIGNER	: KZF DESIGN	
PROJECT ARCHITECT	: BLB	
PROJECT ENGINEER	: KZF DESIGN	
DRAWN BY	: BLBLAS	
CHECKED BY	: DDP	
APPROVED BY	: LAS	
NO.	REVISION DESCRIPTION	DATE
1	Addendum No. 4	3/22/19

DRAWING TITLE

FIRST FLOOR PLAN, SITE
PLAN, AND ENLARGED
PLAN

COMM. NO.
17503.00

DATE
FEBRUARY 20, 2019

DRAWING

A1.1