


SITE PHOTOMETRIC LUMINAIRE SCHEDULE												
LUMINAIRE TYPE	DESCRIPTION			LAMPS					TOTAL		MOUNTING	FINISH
	MANUFACTURER	CATALOG NUMBER	QTY	TYPE	NOM WATTS	INITIAL LUMENS	TEMP COLOR (KELVINS)	VOLTS	CONNECTED WATTS	RATED WATTS		
8	BASIS OF DESIGN: HE WILLIAMS	WWM-H-L20740-082-SDGL-DIM-47-1W	1	LED	25	2000	4000	UNV	25	25	SURFACE WALL	WHITE
9	BASIS OF DESIGN: HE WILLIAMS	40R-TL-L20840-DIM-UNV-L-W-OF-WH-WET-CC-47-1W	1	LED	20	2000	4000	UNV	20	20	RECESSED CEILING	WHITE
13	BASIS OF DESIGN: INSIGHT INDUSTRIES	CYNE-10-40K-15-WMD-120-AO-TB1	1	LED	10	1150	4000	UNV	10	10	SURFACE WALL	BLACK
S1	BASIS OF DESIGN: LSI INDUSTRIES	IRMA-LED-4L-SL-3-UNV-DIM-40-70-08-SP-CL	1	LED	69	7071	4000	UNV	69	69	POLE	BRONZE
S4	BASIS OF DESIGN: HE WILLIAMS	S10-GL3840-OPAL-082-DIM-120	1	LED	14	300	4000	120	14	14	RECESSED WALL	DARK BRONZE

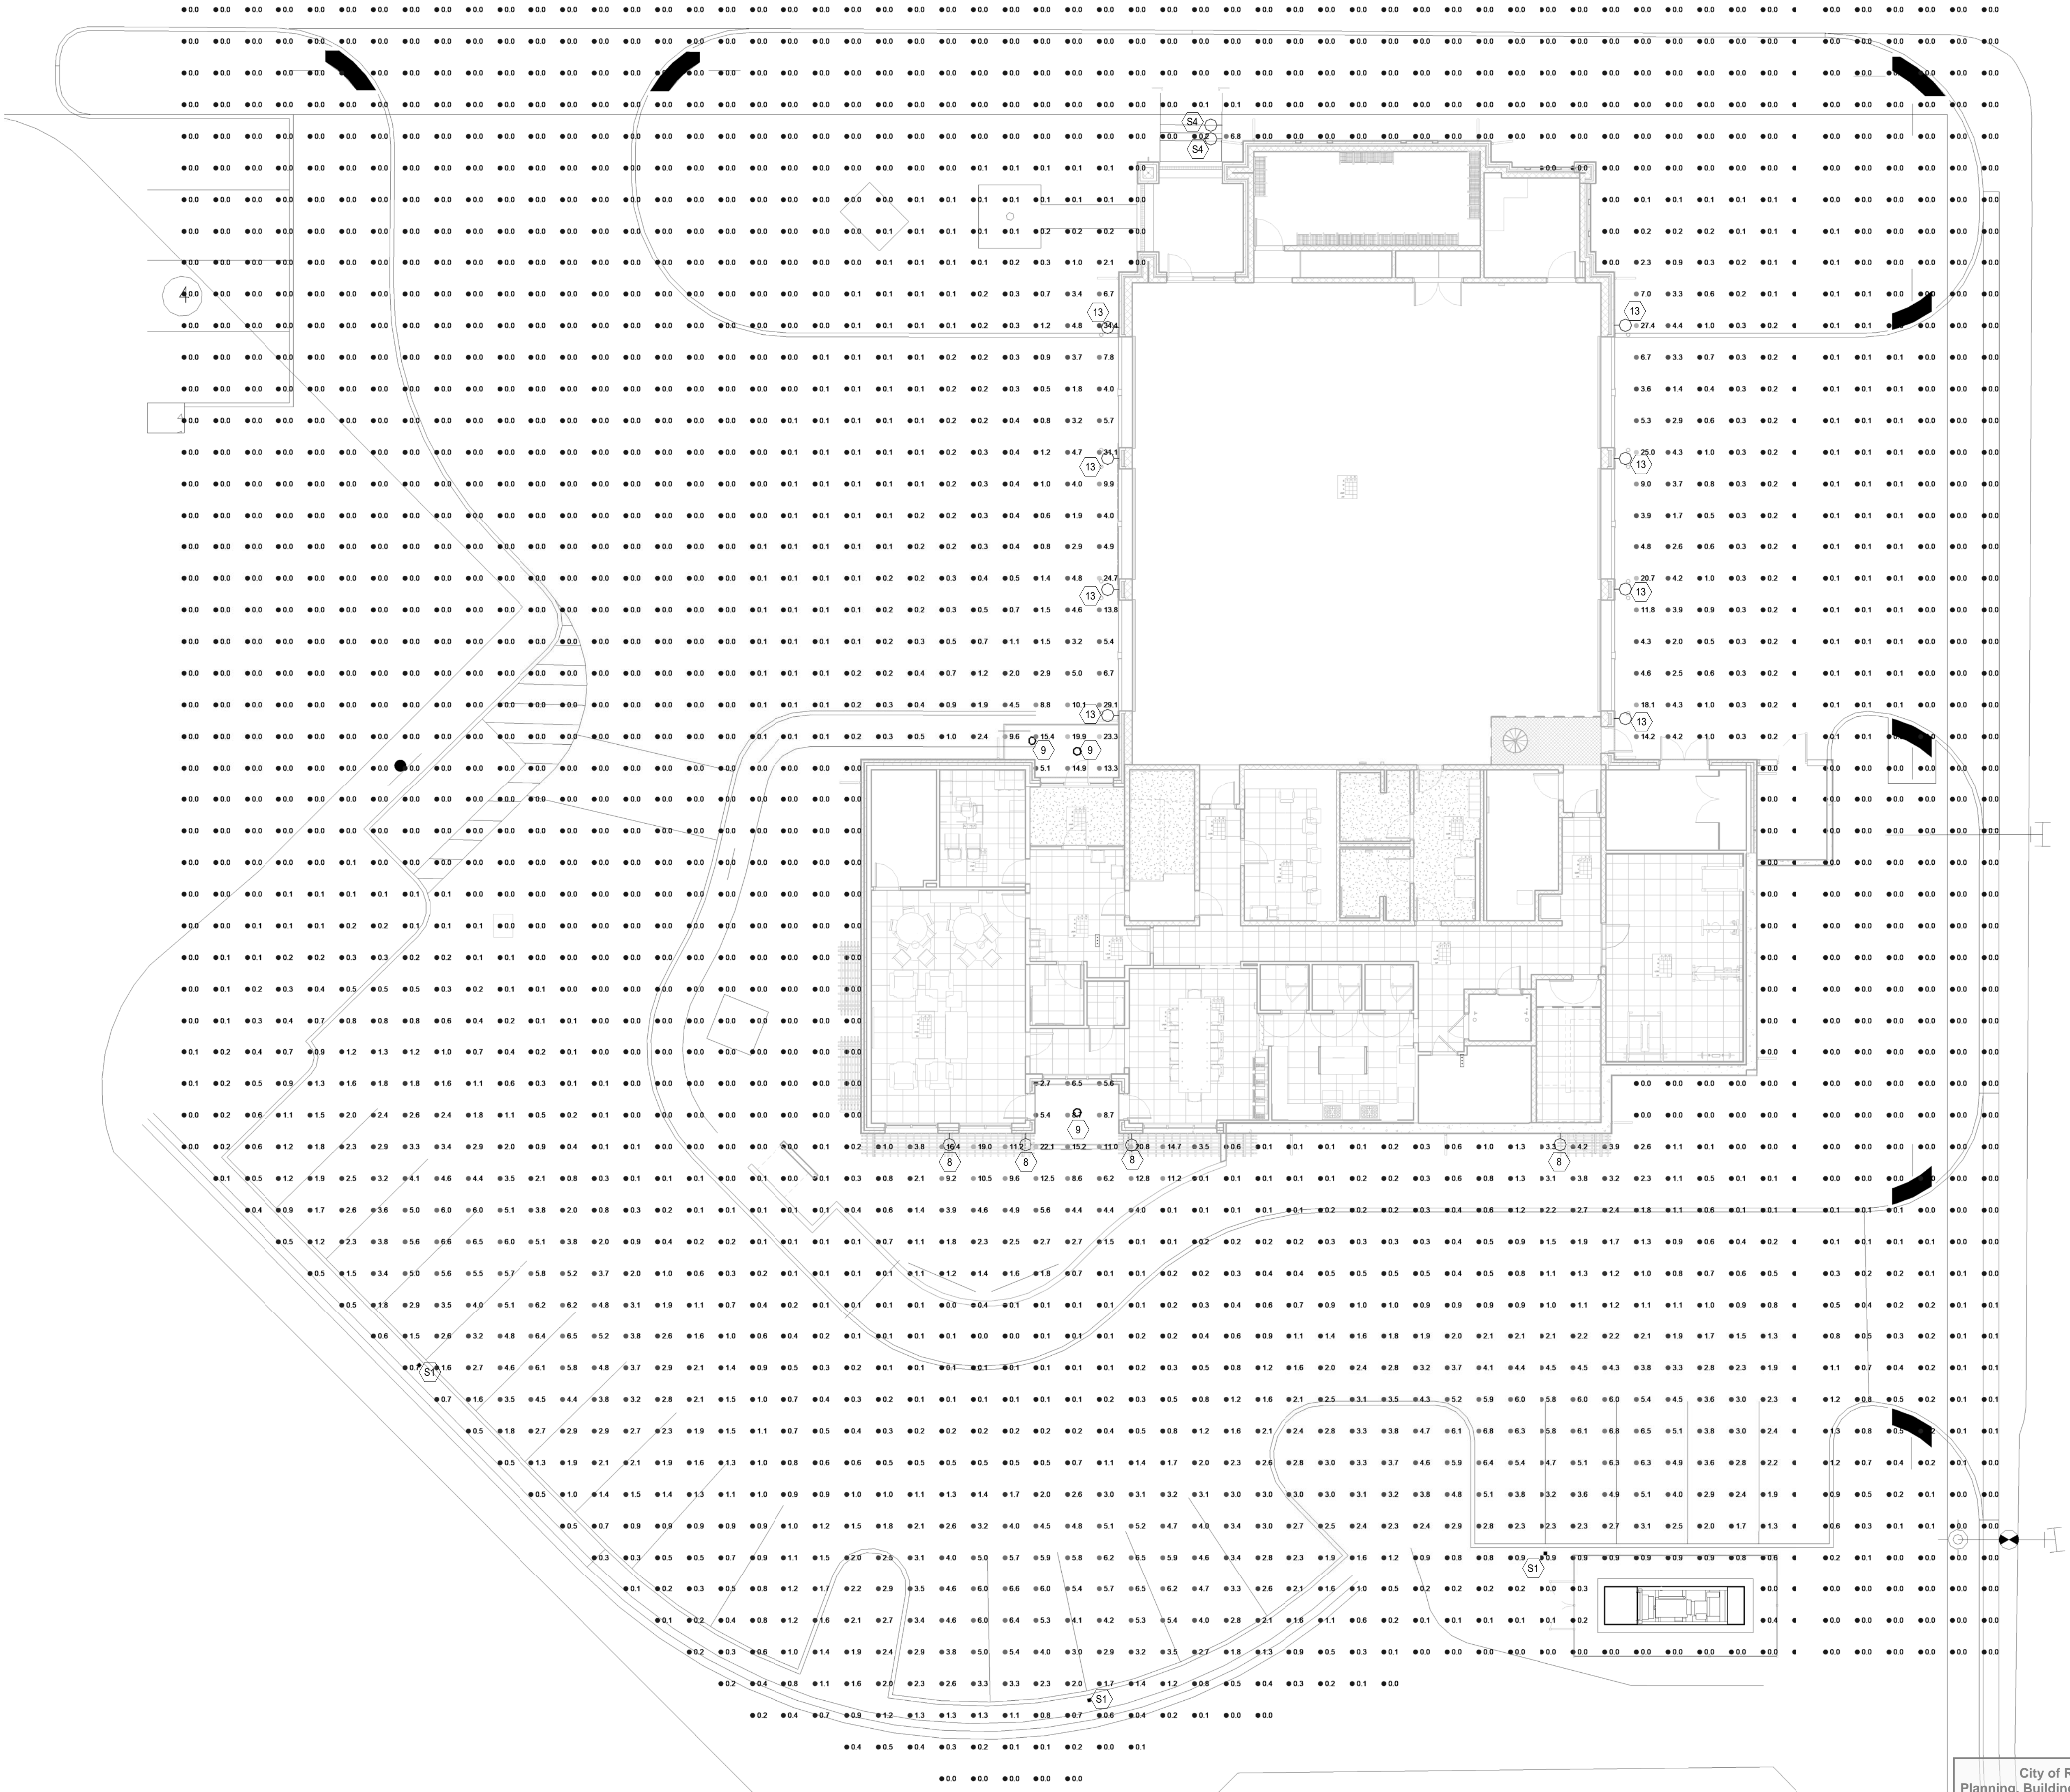

City of Roanoke
Planning, Building, & Development
COMPREHENSIVE DEVELOPMENT PLAN
APPROVED
by Ken Richardson
07/08/2019

1 FIRST FLOOR - PHOTOMETRICS Elum Tools
PH1 1" = 10'-0"

PROJECT TITLE
**ROANOKE FIRE-EMS
STATION NO. 7**
BID SET

SFCs Architecture
Engineering
Planning
Interiors
SFCs Inc. • 305 South Jefferson Street
Roanoke, Virginia 24011.2003
540.344.6664 • Fax 540.343.6925
www.sfcsc.com

PROJECT DESIGNER	: KZF DESIGN	
PROJECT ARCHITECT	: BLB	
PROJECT ENGINEER	: CWV	
DRAWN BY	: MAR	
CHECKED BY	: Checker	
APPROVED BY	: Approver	
NO.	REVISION DESCRIPTION	DATE

DRAWING TITLE
**SITE PHOTOMETRICS
PLAN**

COMM. NO.
17503.00
DATE
FEBRUARY 20, 2019

DRAWING
PH1