



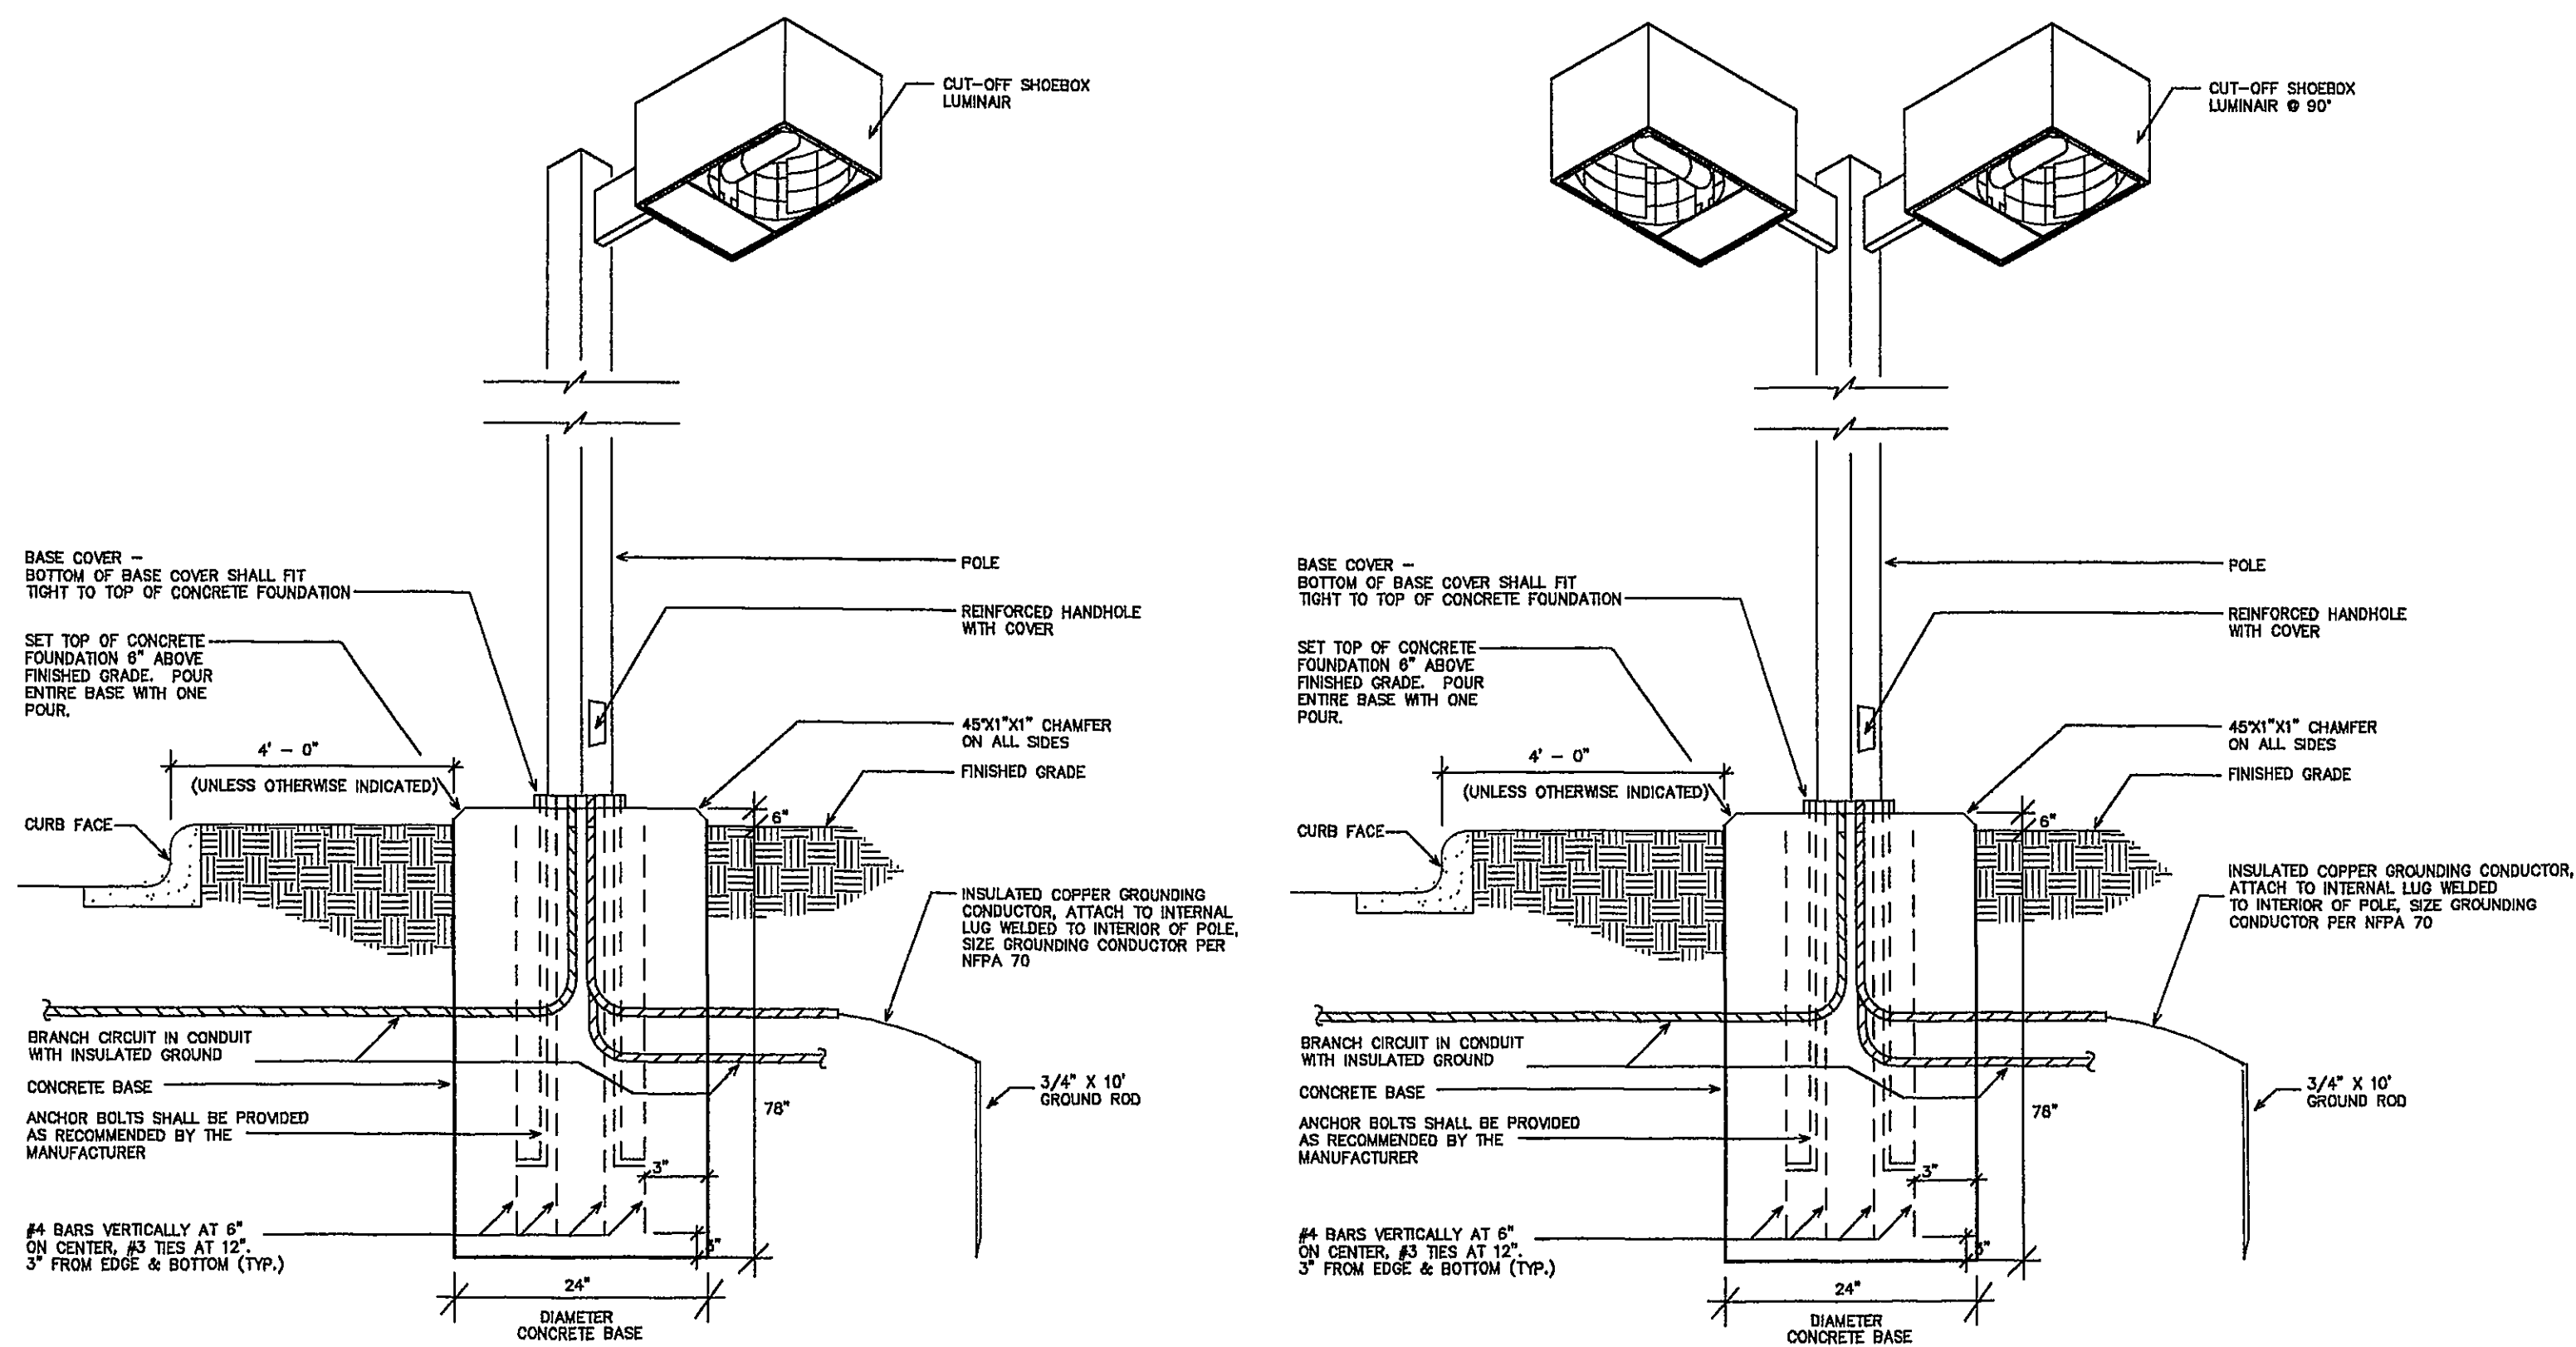

2 FIXTURE TYPE "SA" BASE DETAIL
SL1 N.T.S.

3 FIXTURE TYPE "SB" BASE DETAIL
SL1 N.T.S.

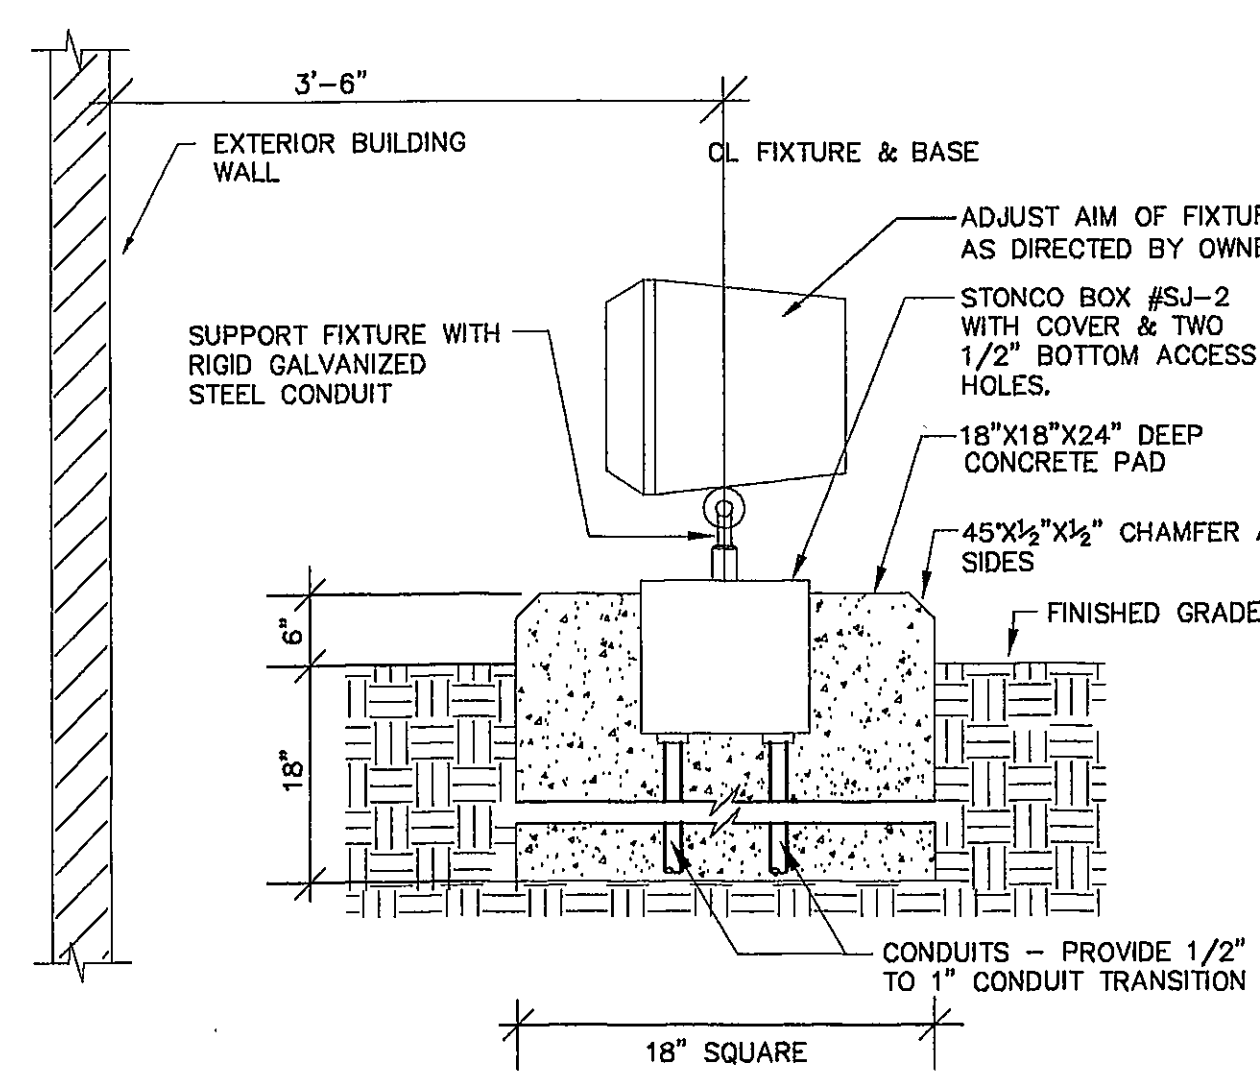

5 FIXTURE TYPE "SD" MOUNTING DETAIL
N.T.S.

ELECTRICAL KEYNOTES SHEET SL1


- (E1) PROVIDE 1 1/2" PVC CONDUIT SLEEVE WITH PULL STRING UNDER PAVED AREA 24" BELOW FINISHED GRADE FOR FUTURE USE. STUB OUT 24" BEYOND EACH SIDE OF PAVED AREA. CAP EACH END WATER TIGHT. MARK ENDS WITH WOOD STAKES.
- (E2) PROVIDE WEATHERPROOF 30 AMP, 120V. SWITCH AND CONNECT TO SIGN LIGHT WITH SEALTIGHT. FIELD VERIFY EXACT LOCATION WITH OWNER & ARCHITECT.

GENERAL NOTES:


- ALL WORK SHALL COMPLY WITH THE N.E.C. & ALL LOCAL CODES.
- ALL CONDUCTORS SHALL BE COPPER. RUN EQUIPMENT GROUNDING CONDUCTOR IN EACH RUN OF CONDUIT & BOND TO EQUIPMENT.
- WHERE CONDUCTORS ARE TOO LARGE TO FIT UNDER DEVICE OR BREAKER TERMINALS, PROVIDE J.BOX EXTERNAL TO DEVICE OR PANELBOARD & SPLICE DOWN TO NEXT CONDUCTOR SIZE THAT WILL FIT.

ELECTRICAL LEGEND - SHEET SL1


- TWO 400 WATT METAL HALIDE FIXTURES ON 25' POLE WITH FIXTURES MOUNTED AT 90 DEG. TO EACH OTHER.
- TWO 400 WATT METAL HALIDE FIXTURES ON 25' POLE WITH FIXTURES MOUNTED AT 180 DEG. TO EACH OTHER.
- SINGLE 400 WATT METAL HALIDE FIXTURE ON 25' POLE
- BLDG. FACADE FLOOD LIGHT
- WEATHERPROOF SWITCH
- EQUIPMENT CONNECTION
- UNDERGROUND BRANCH CIRCUIT IN PVC CONDUIT
- UNDERGROUND HOMERUN CIRCUIT IN PVC CONDUIT ("I" INDICATES PHASE CONDUCTOR, "N" INDICATES NEUTRAL CONDUCTOR, "G" INDICATES GROUND CONDUCTOR)
- UNDERGROUND PVC CONDUIT SLEEVE
- GROUND
- LC-1 LIGHTING CONTACTOR LC-1
- KEYNOTE
- PHOTOCELL - MOUNT PHOTOCELL ON DRIVE THROUGH CEILING. ORIENT EYE IN DIRECTION OF ARROW.

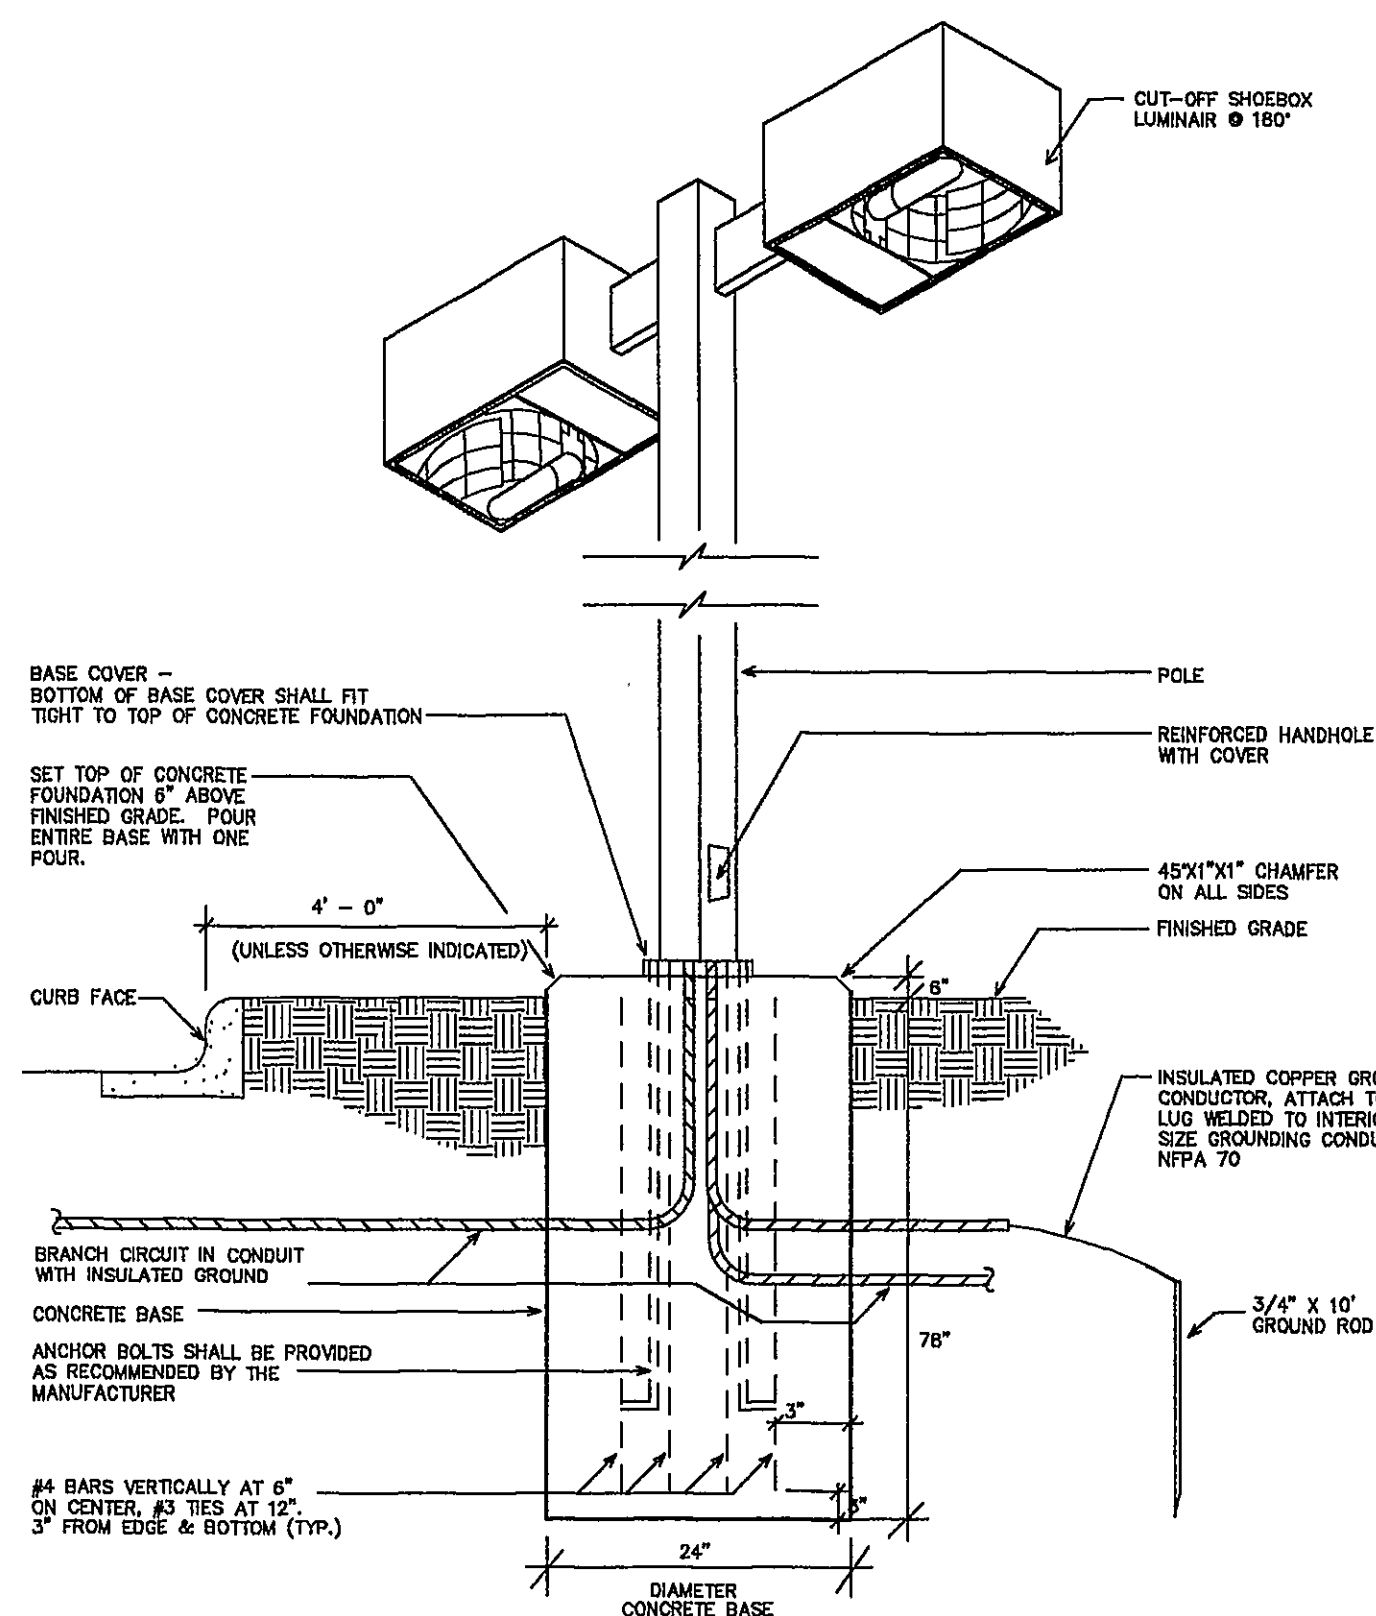

4 FIXTURE TYPE "SC" BASE DETAIL
SL1 N.T.S.

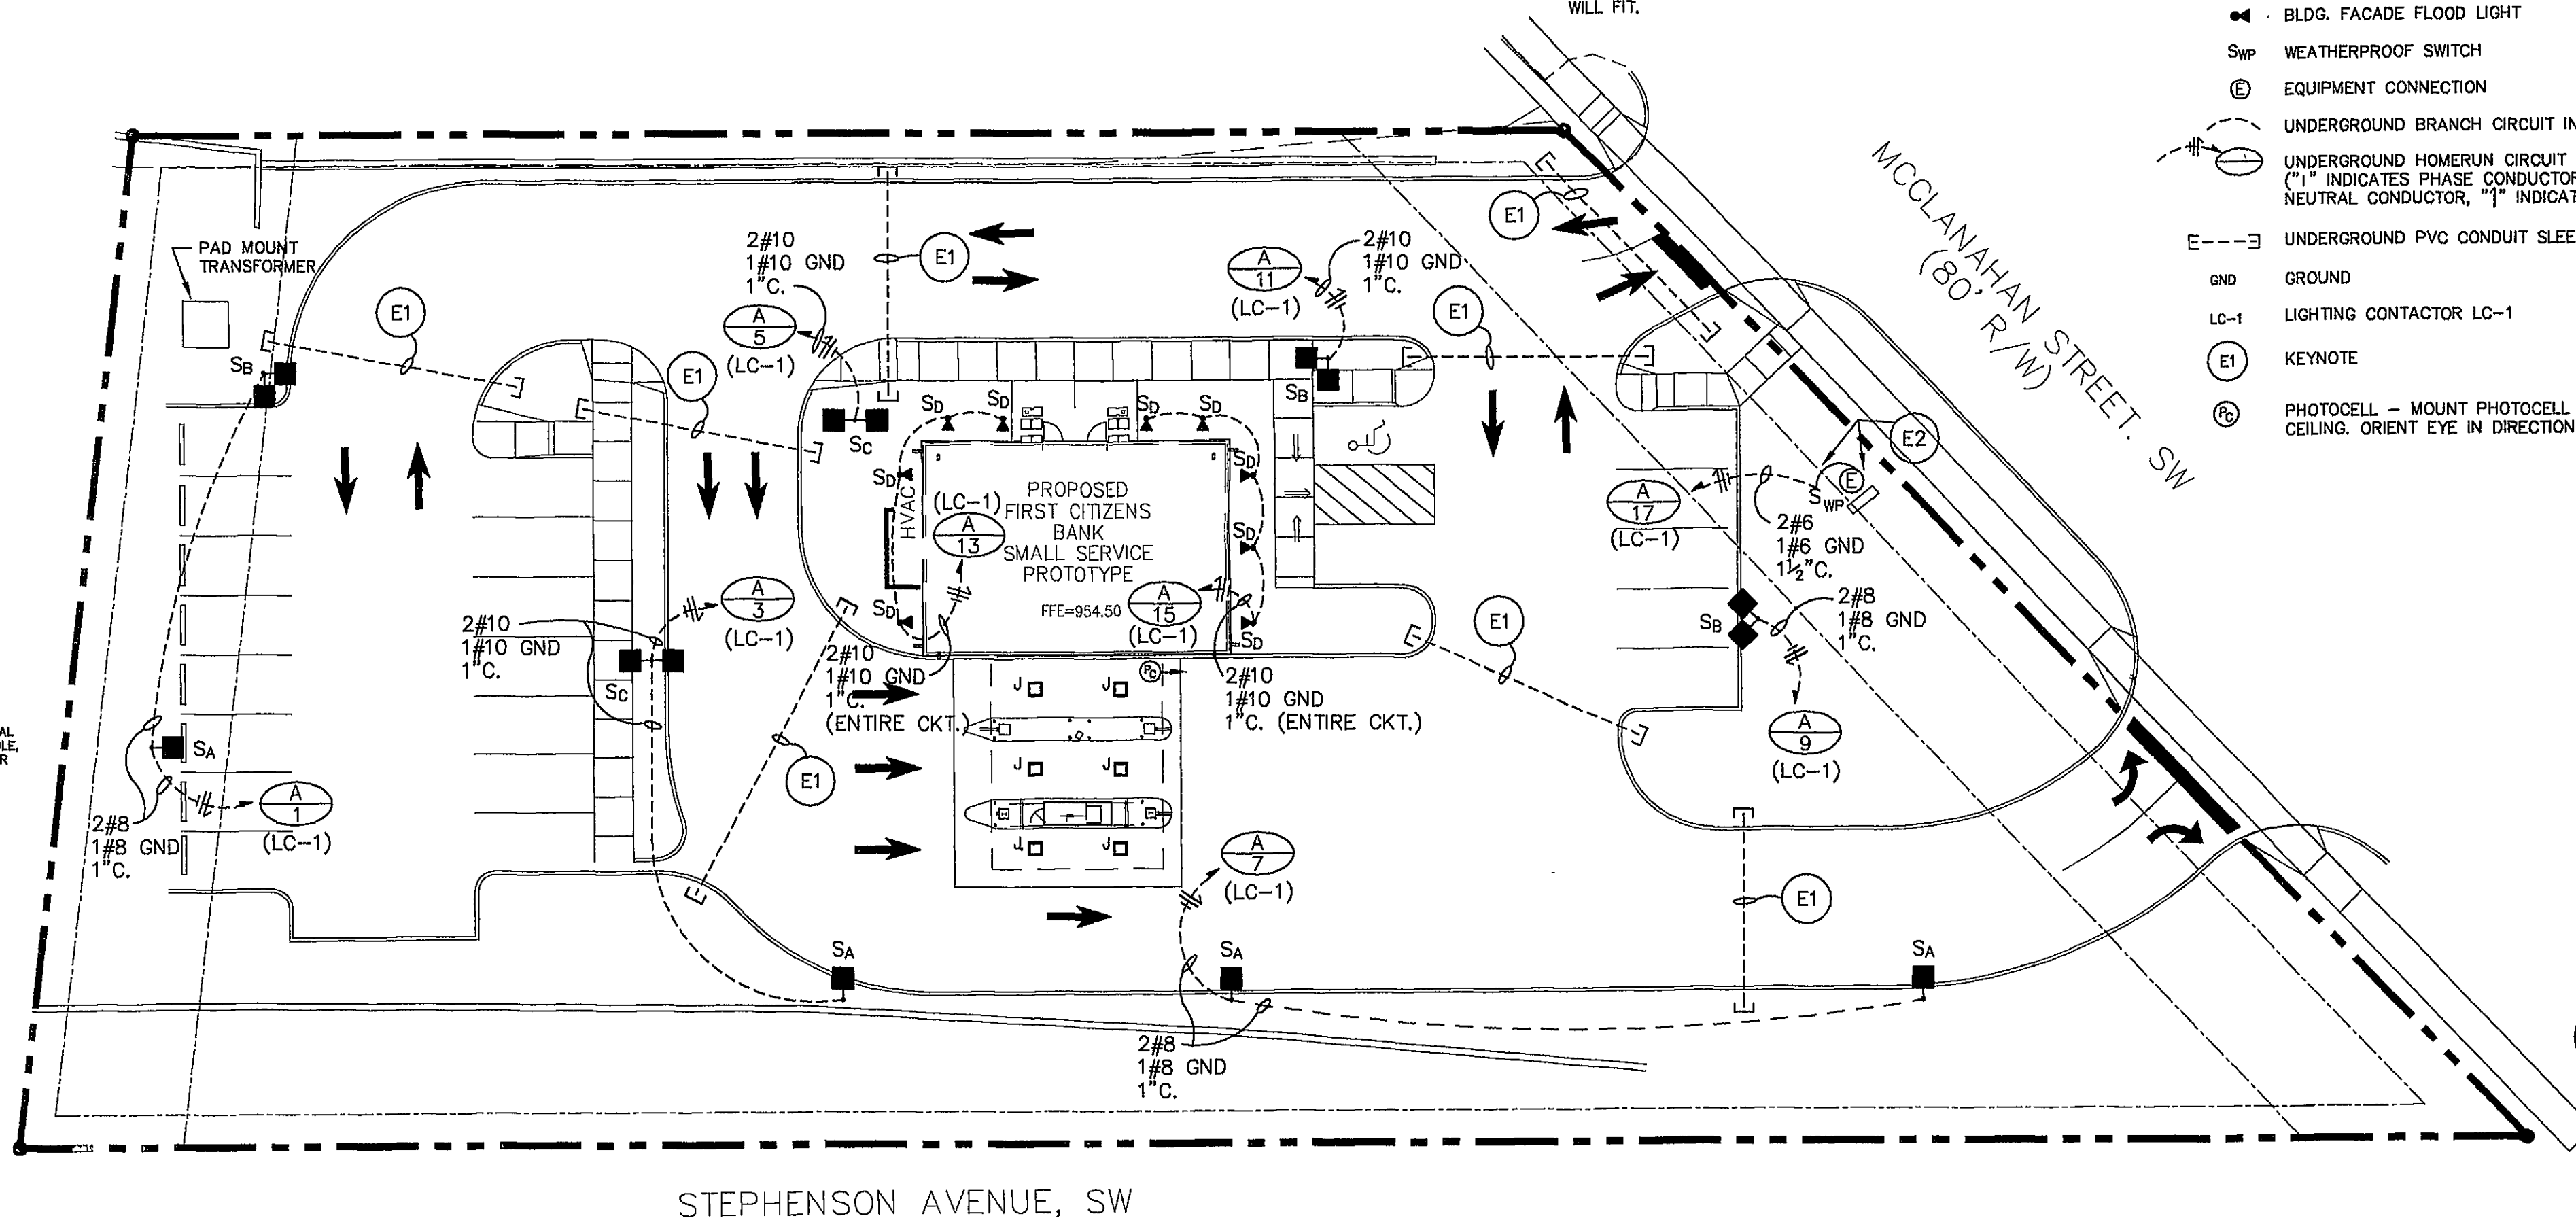

1 SITE LIGHTING PLAN
SCALE: 1"=20'-0"

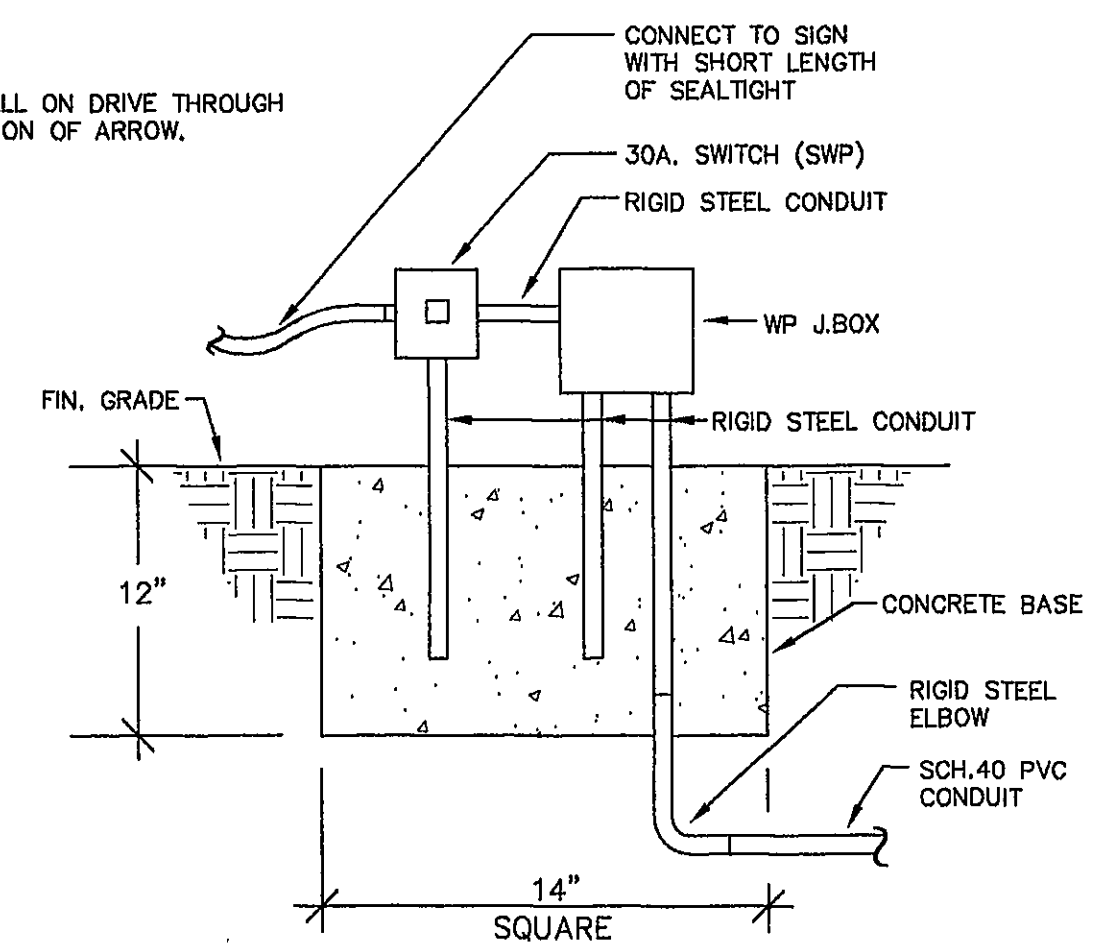

6 SWITCH & J.BOX MOUNTING DETAIL
N.T.S.


adcock engineering
PLUMBING, HVAC AND ELECTRICAL DESIGN

4801 LAKE BOONE TRAIL
RALEIGH, NC 27607
FAX (919) 881-0847
(919) 781-4336

A.E. PROJECT NO. 2003211

COMMONWEALTH OF VIRGINIA
SHELTON Y. ADCOCK
No.0402 031454
7/25/03
PROFESSIONAL ENGINEER

PREPARED IN THE OFFICE OF:

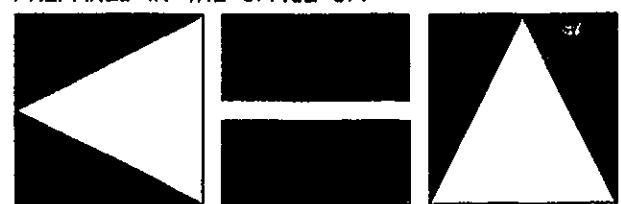

**Kimley-Horn
and Associates, Inc.**

P.O. BOX 33068 - RALEIGH, NORTH CAROLINA 27636-3068
PHONE: (919) 677-2000 FAX: (919) 677-2050

CLIENT:

FIRST CITIZENS BANK

TITLE:

SITE LIGHTING PLAN

SEAL:

DATE:

9/23/03

HORIZONTAL SCALE:

1" = 20'

VERTICAL SCALE:

DRAWN BY:

AIM

DESIGNED BY:

FLM

CHECKED BY:

SYA

PROJECT:

**McCLANAHAN STREET
ROANOKE, VA**

ATTACHED REFERENCE FILES:

JOB NUMBER:

011737090

SHEET NUMBER:

SL1 OF 1

REV. No.1 REVISION: DATE: DRAWN BY: CHECKED BY:

This document, together with the concepts and designs presented herein, as an instrument of service, is intended only for the specific purpose and client for which it was prepared. Reuse of and improper reliance on this document without written authorization and adoption by Kimley-Horn and Associates, Inc. shall be without liability to Kimley-Horn and Associates, Inc. Copyright Kimley-Horn and Associates, Inc., 2003