

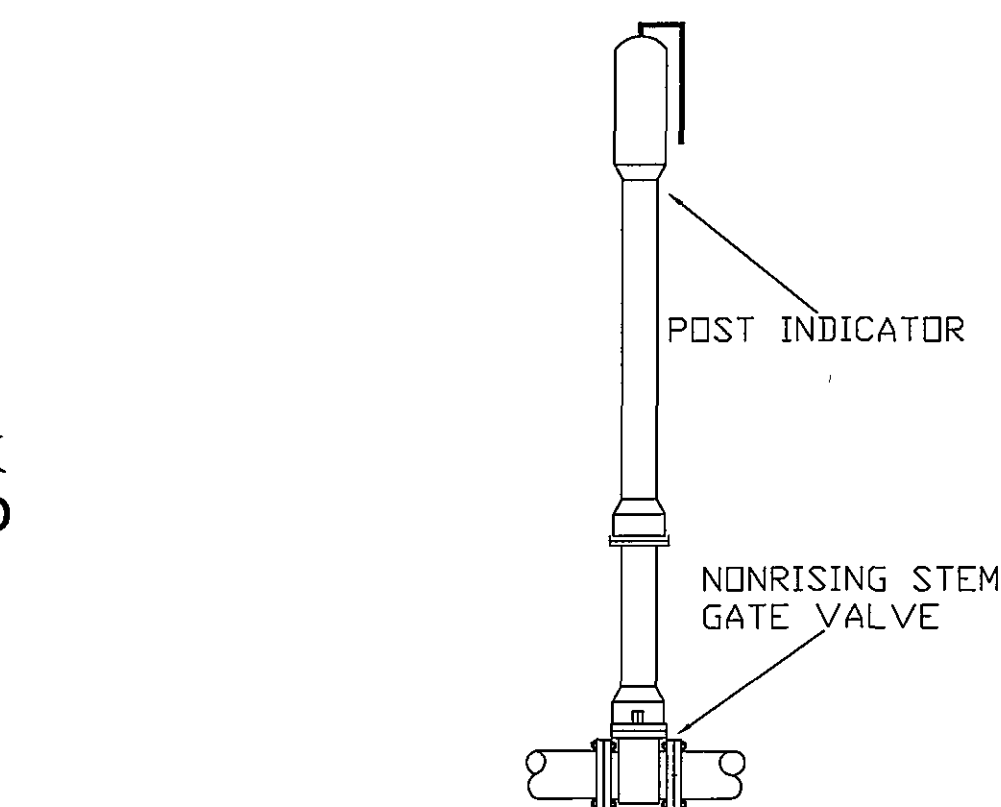


McCLANAHAN STREET


- GENERAL NOTES**
1. R.S.I. TO HOT TAP EXISTING 16" HIGH PRESSURE MAIN LOCATED IN JEFFERSON STREET.
 2. R.S.I. SHALL BE RESPONSIBLE FOR PATCHING OF STREET ASPHALT AND CONCRETE SIDEWALK.
 3. GENERAL CONTRACTOR TO REMOVE AND PATCH OWNER'S STONE WALKWAY WHERE 6" MAIN CROSSES.
 4. GENERAL CONTRACTOR TO REMOVE MULCH, SHURBBERY OR GRASS AS REQUIRED FOR EXCAVATION OF EARTH AT VAULT LOCATION OR FIRE MAIN PATH.
 5. MINIMUM 36" BURY FOR FIRE LINE.
 6. RESTRAIN ALL PIPE AND FITTINGS IN ACCORDANCE WITH NFPA 24.
 7. TEST AND FLUSH NEW FIRE MAIN IN ACCORDANCE WITH NFPA 24.

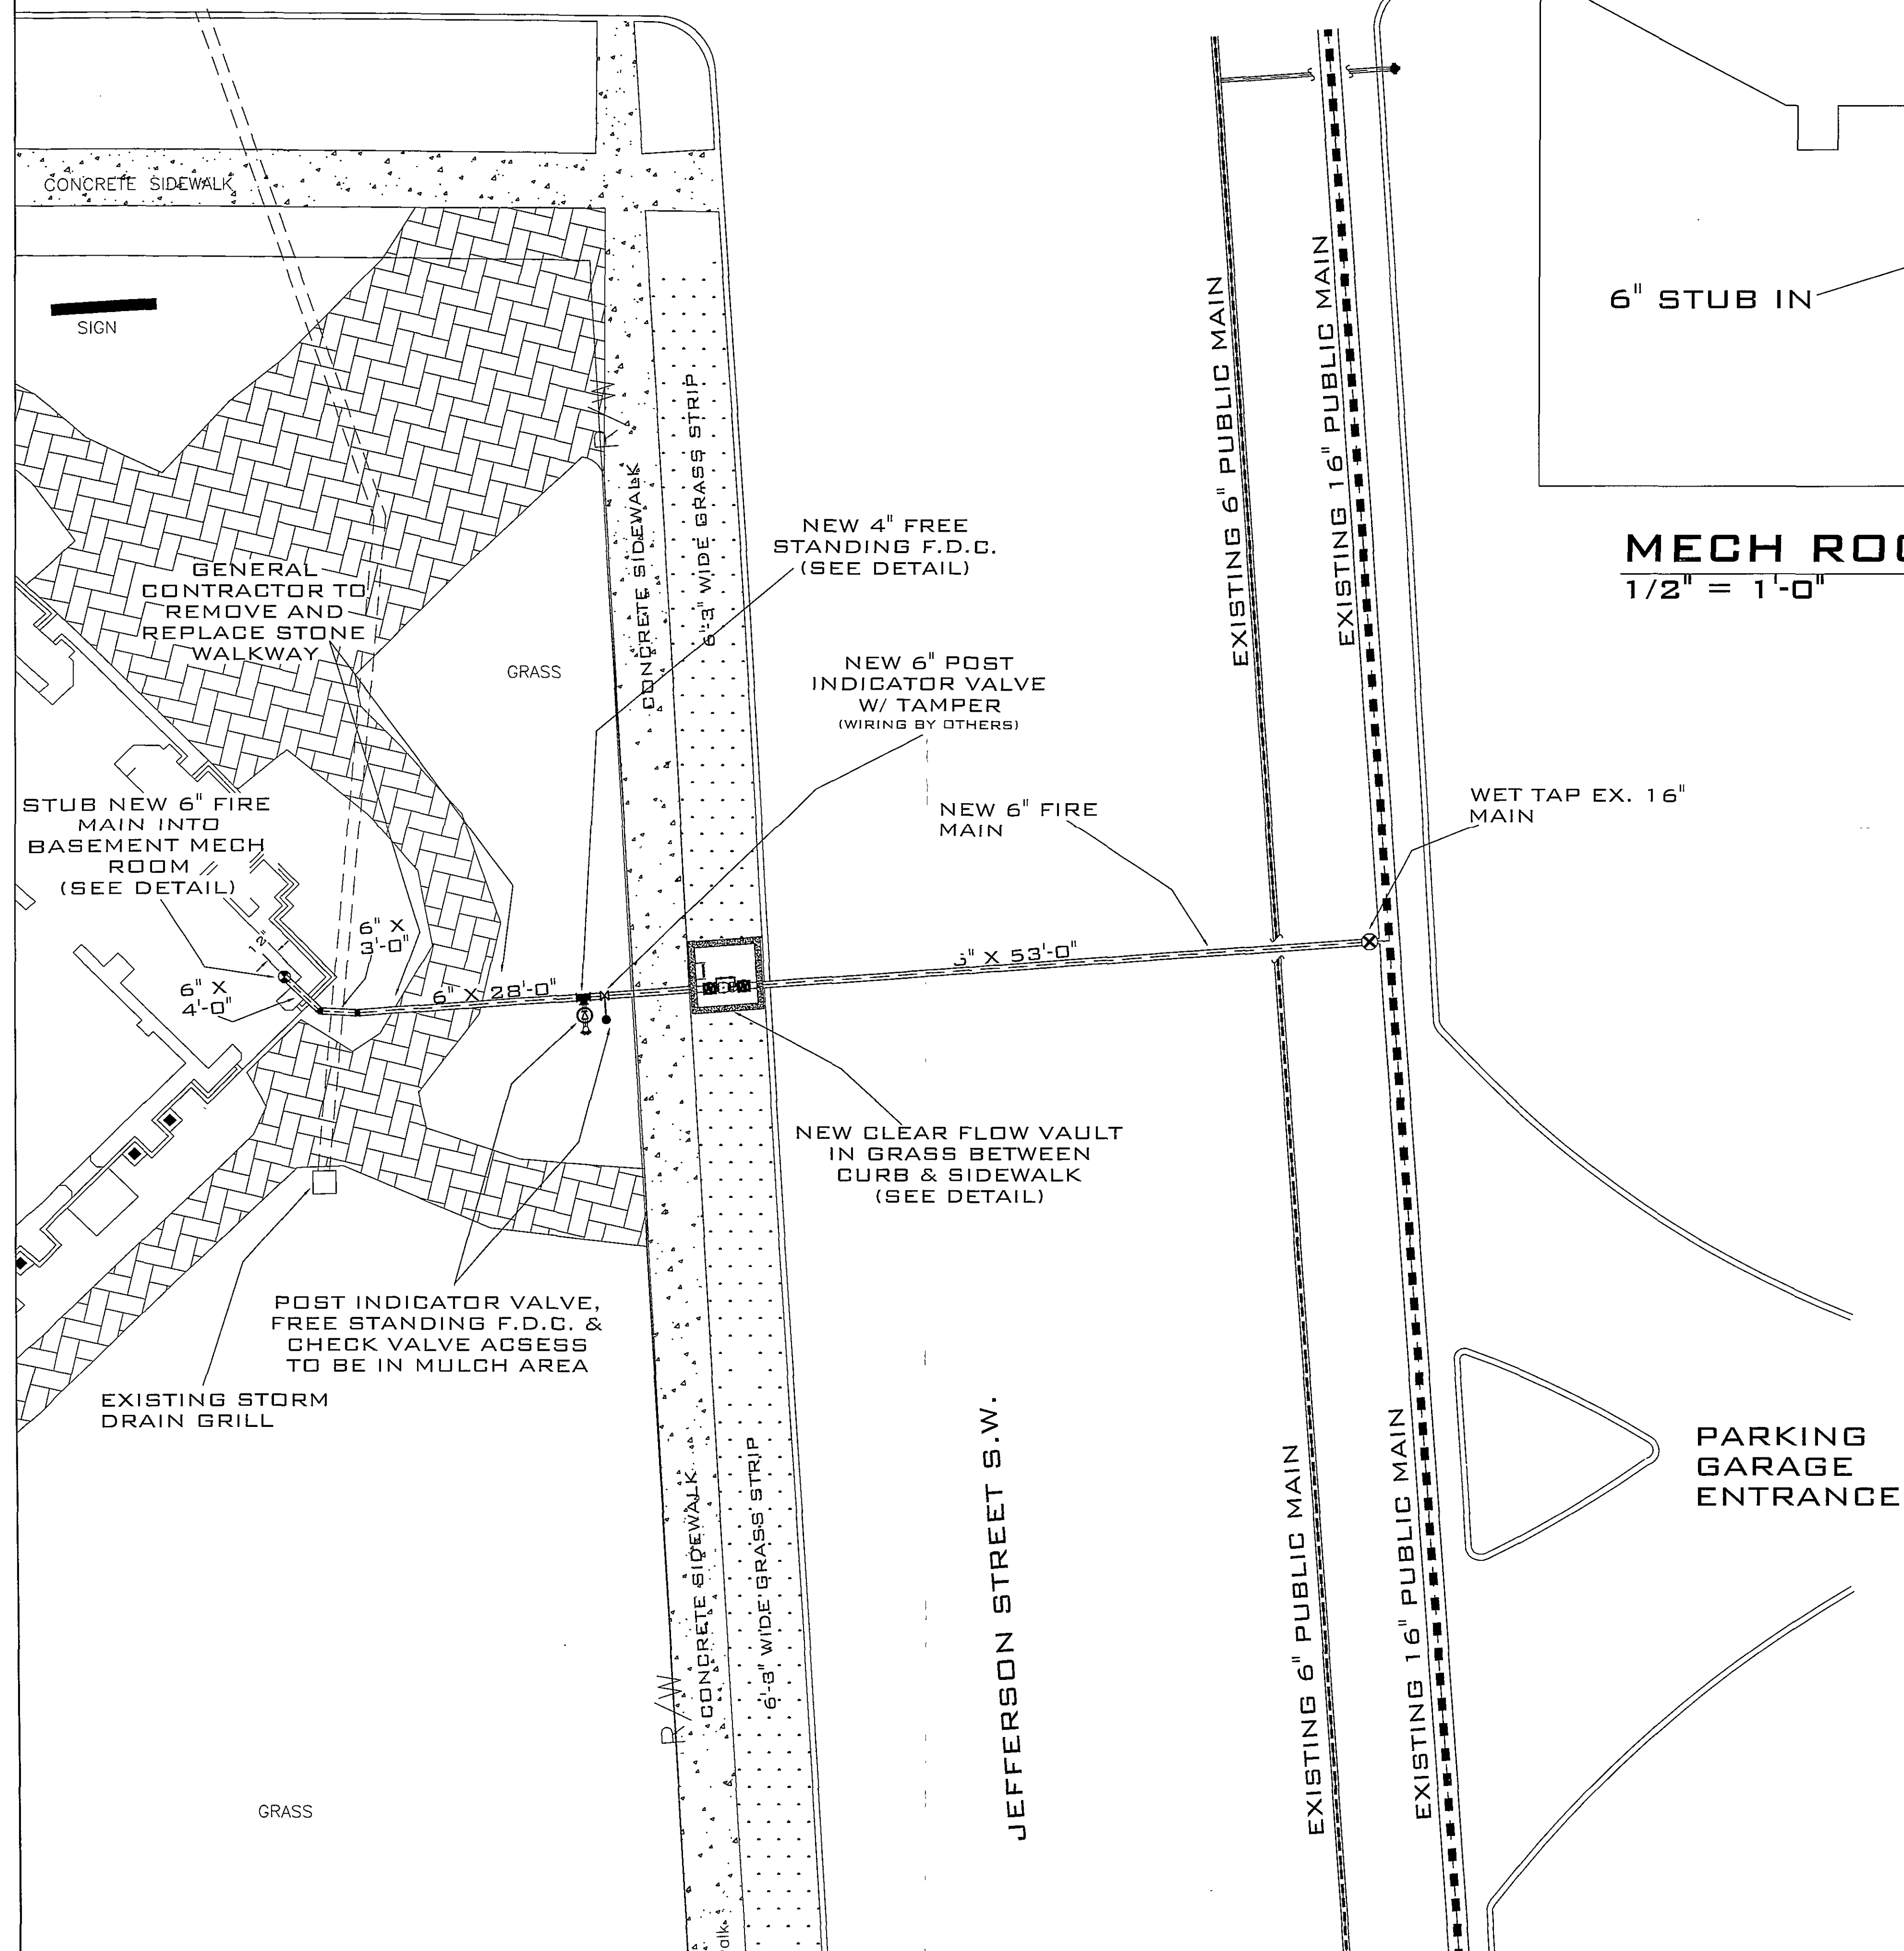


POST INDICATOR VALVE DETAIL
1/2" = 1'-0"

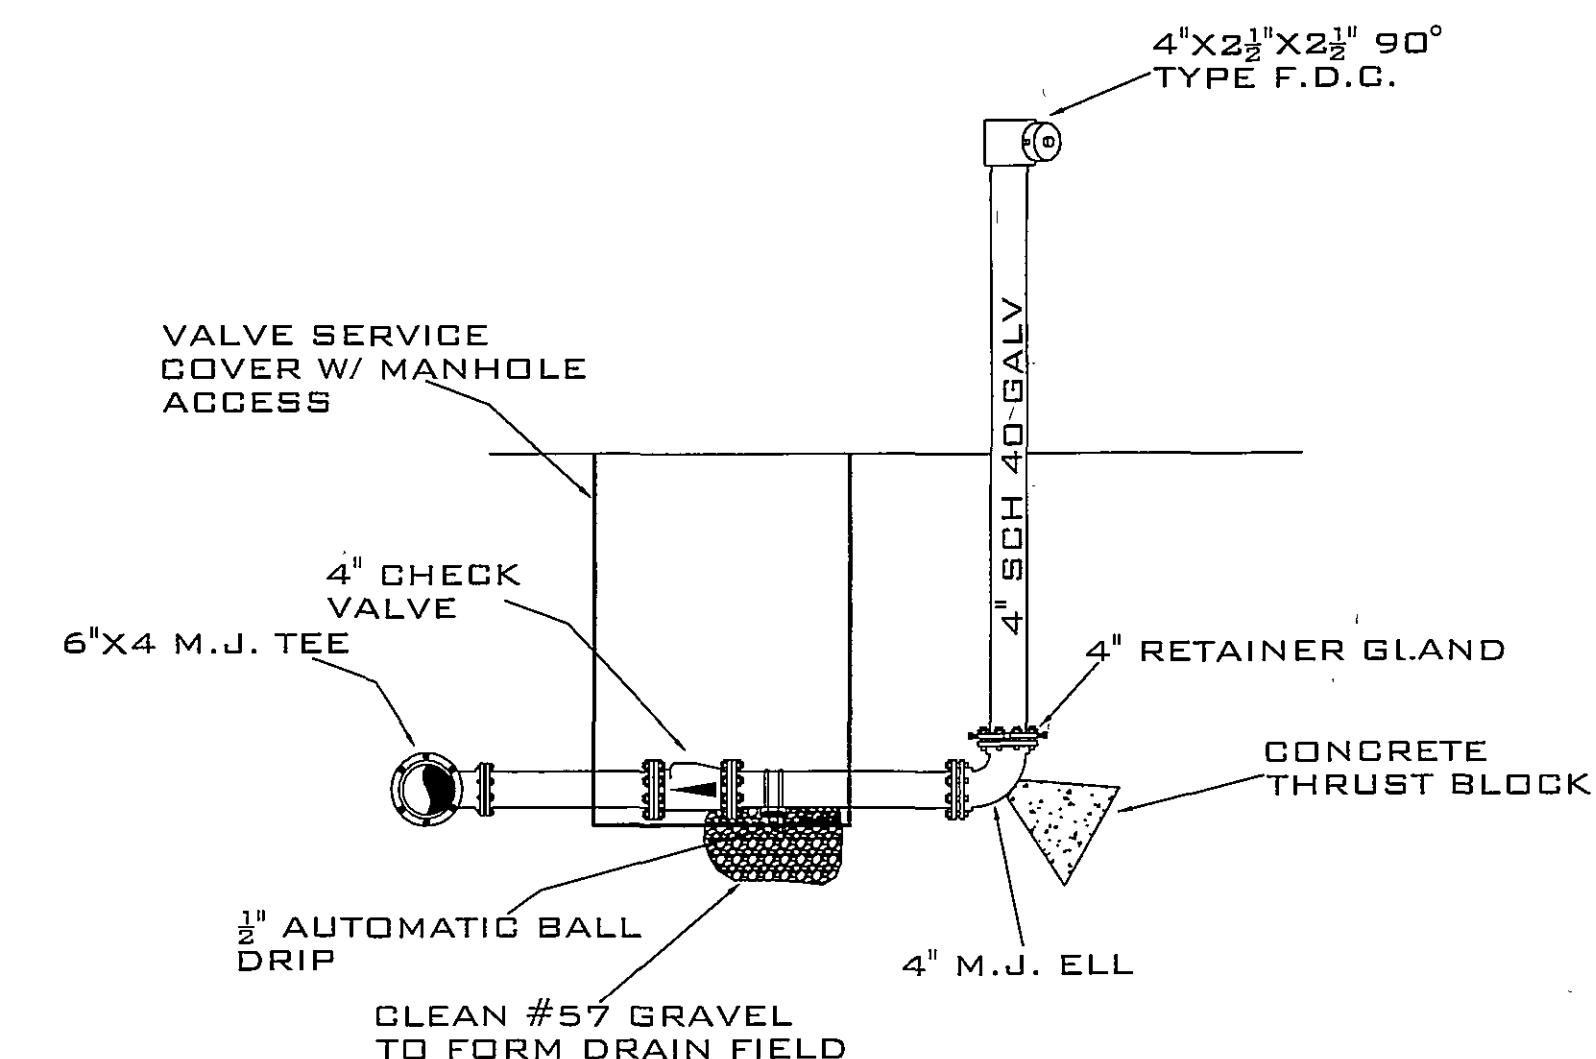


FREE STANDING F.D.C. DETAIL
1/2" = 1'-0"

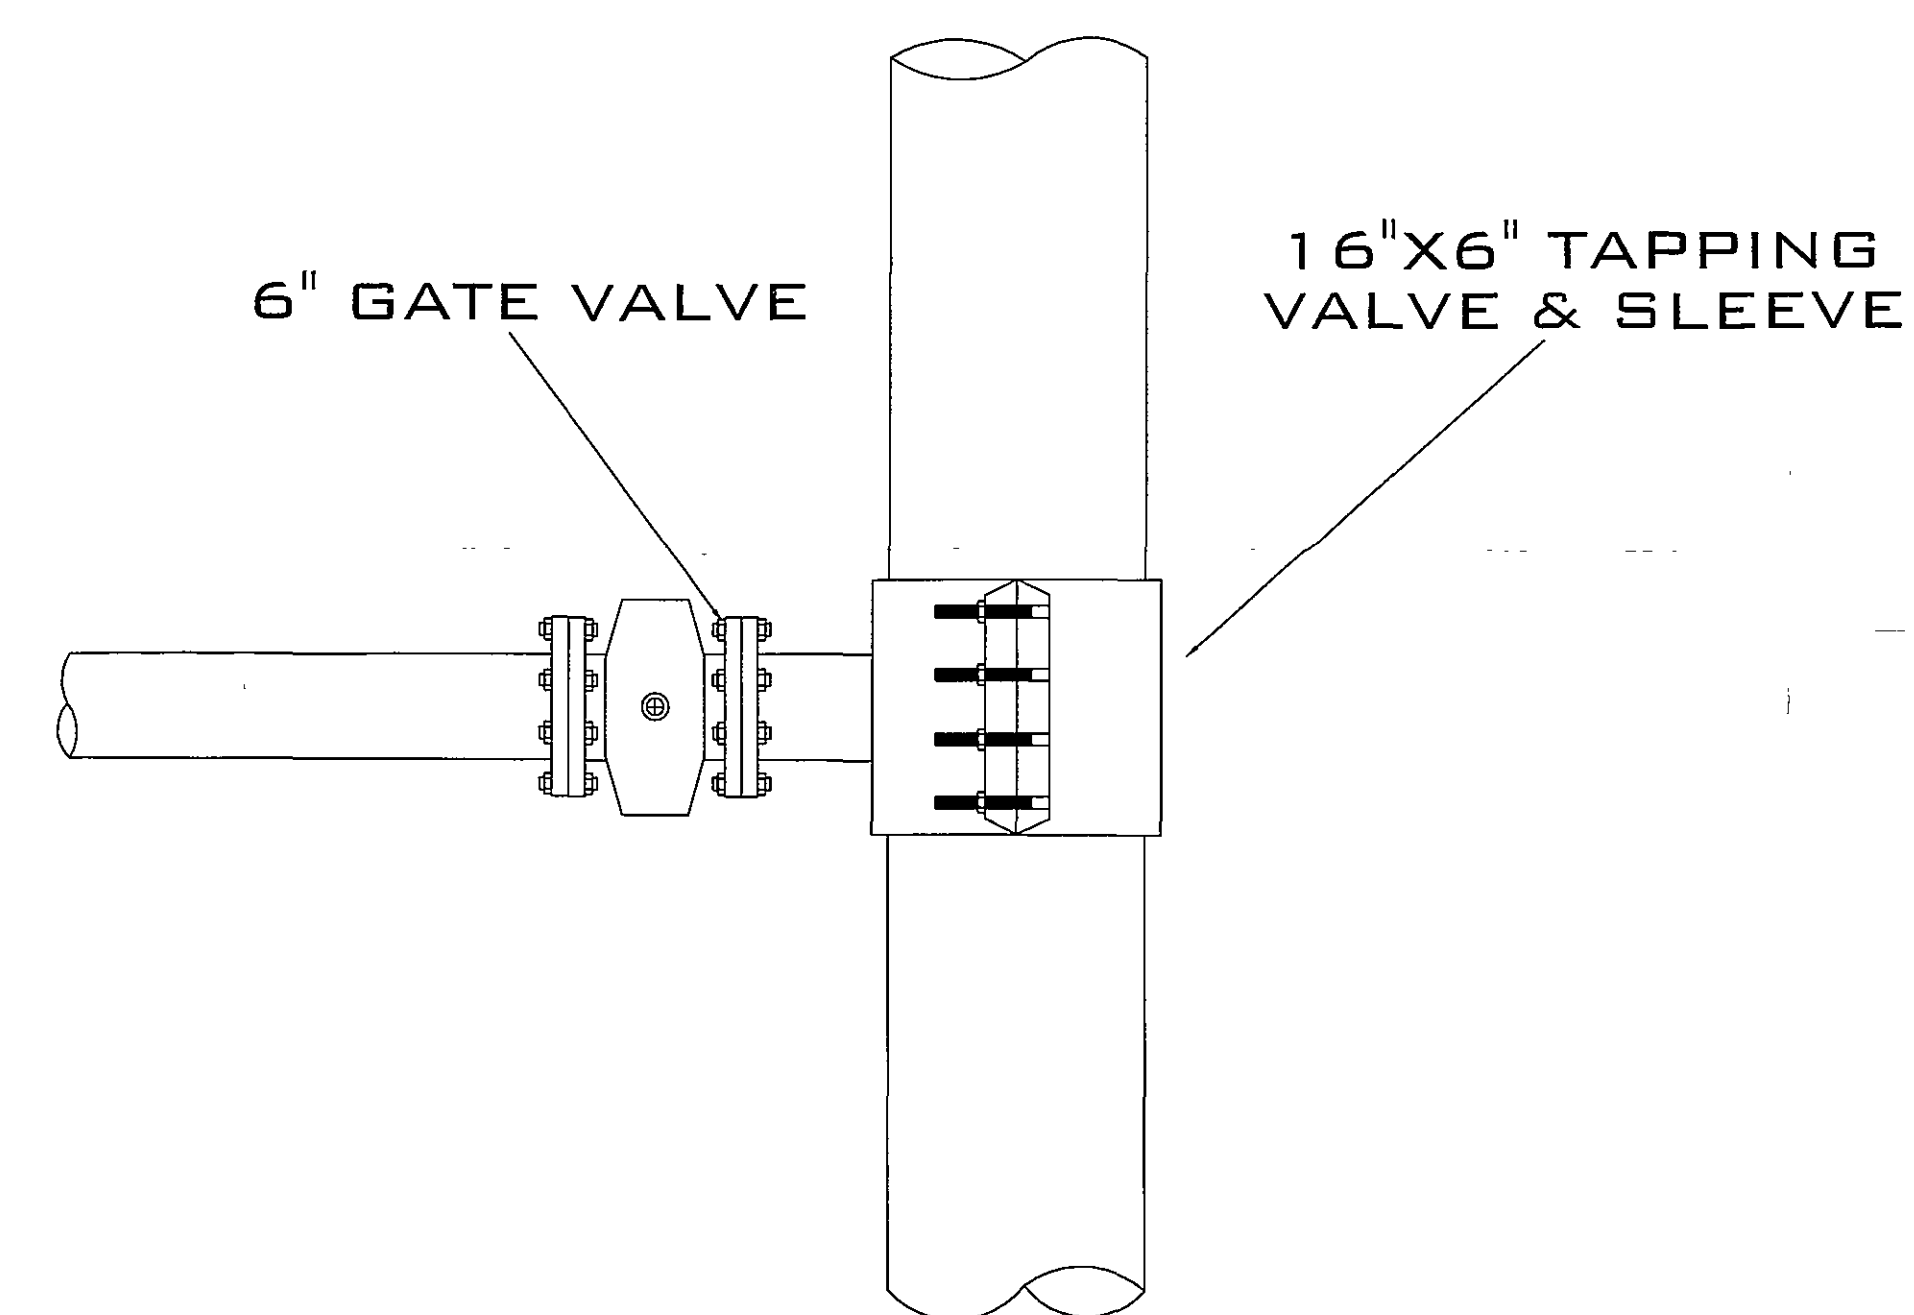

TAPPING VALVE & SLEEVE
1/2" = 1'-0"

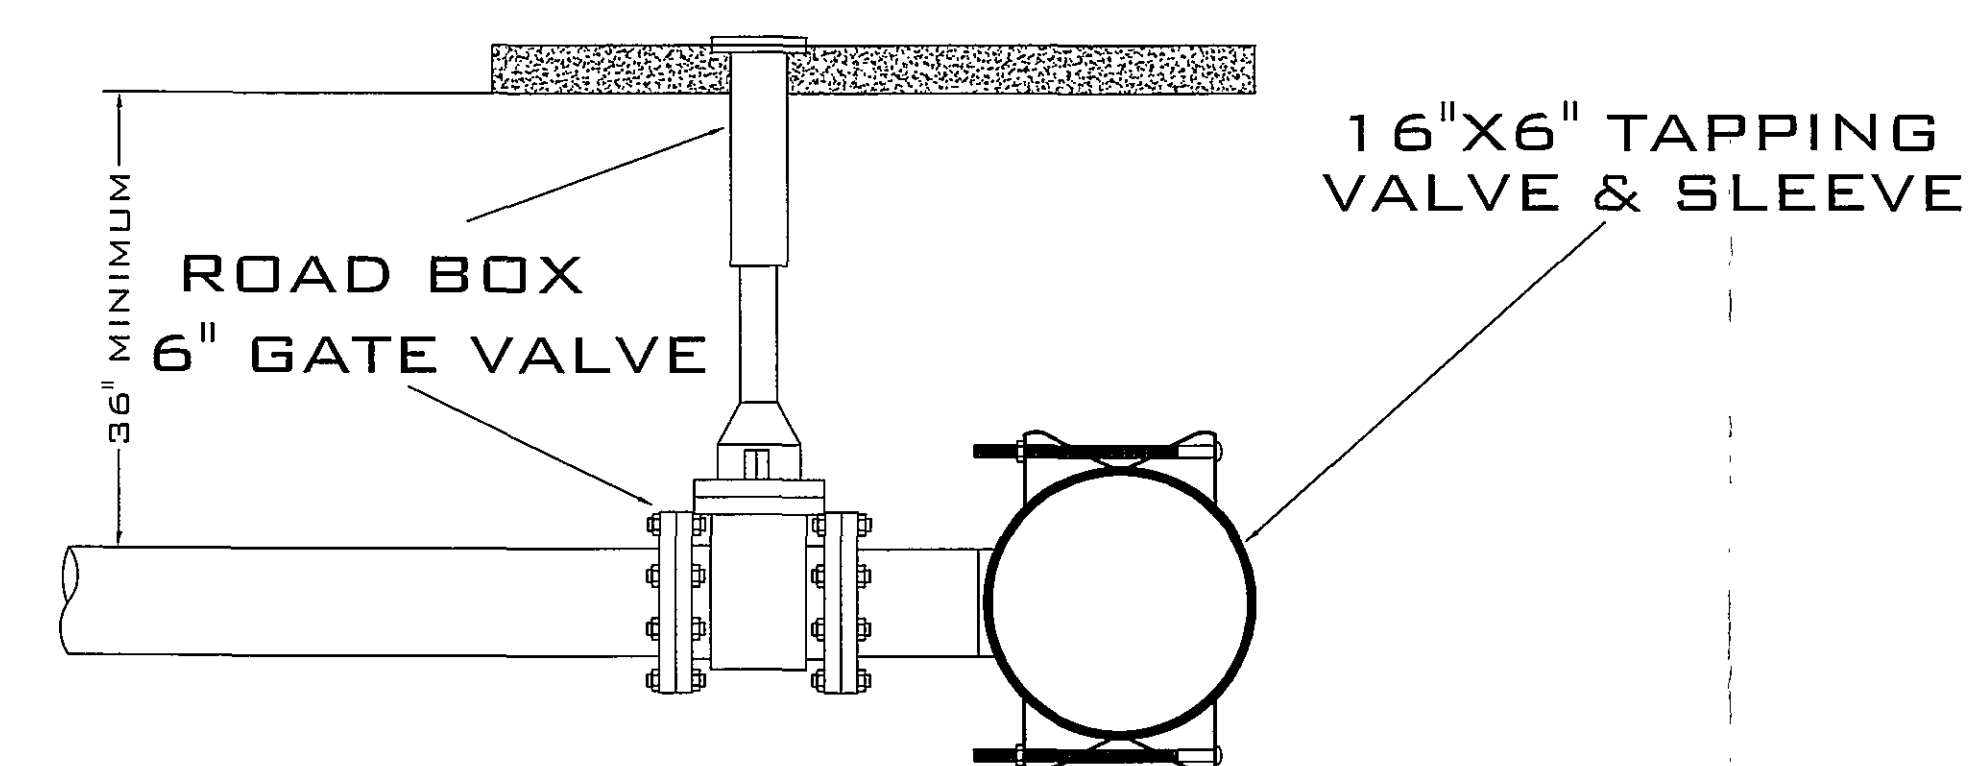

TAPPING VALVE & SLEEVE
 $\frac{1}{2}'' = 1'-0''$

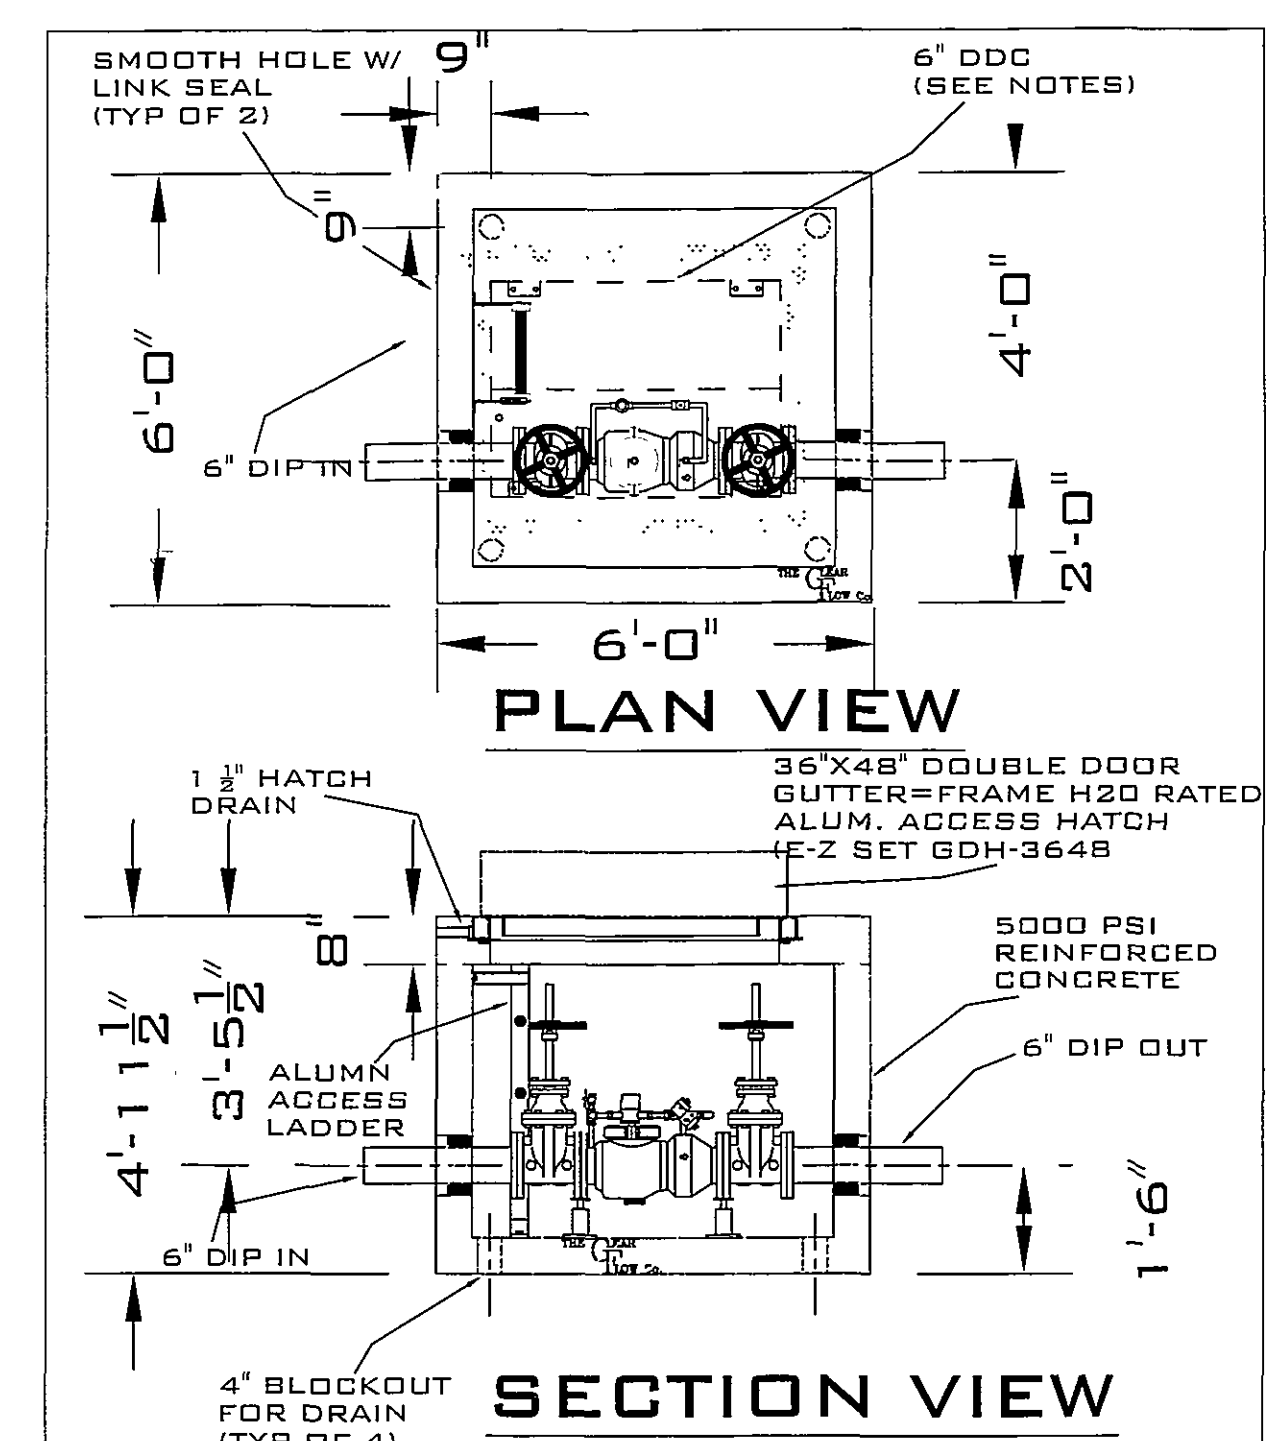

NOTES:

1. CLEAR FLOW VAULT SHIPPED ASSEMBLED WEIGHING APPROX. 16,000 LBS.
2. 6" WILKINS 350DA DOUBLE CHECK DETECTOR ASSEMBLY W/ O.S.&Y'S

DESIGN	STEVEN J. GORDON	11/7/78
CHECKED	CRAGG A. SHEPHERD	
APPROVED		
REVISIONS	DATE	
BYPASS SIDE	11/7/78	

THE CLEAR FLOW CO

P O BOX 1467
1321 NORTH DELPHINE AVENUE
WAYNESBORO, VIRGINIA 22980
(540) 942 - 3000

PROJECT NO P-31095-S

ROANOKE, VIRGINIA

FIRST PRESBYTERIAN CHURCH

6" DDC VAULT

SCALE: $\frac{1}{8}'' = 1'-0''$

SCALE: $\frac{1}{4}'' = 1'-0''$

SCALE: $\frac{1}{2}'' = 1'-0''$

RO NOKE SPRINKLER, INC.
FIRE PROTECTION SYSTEMS

[illegible]