


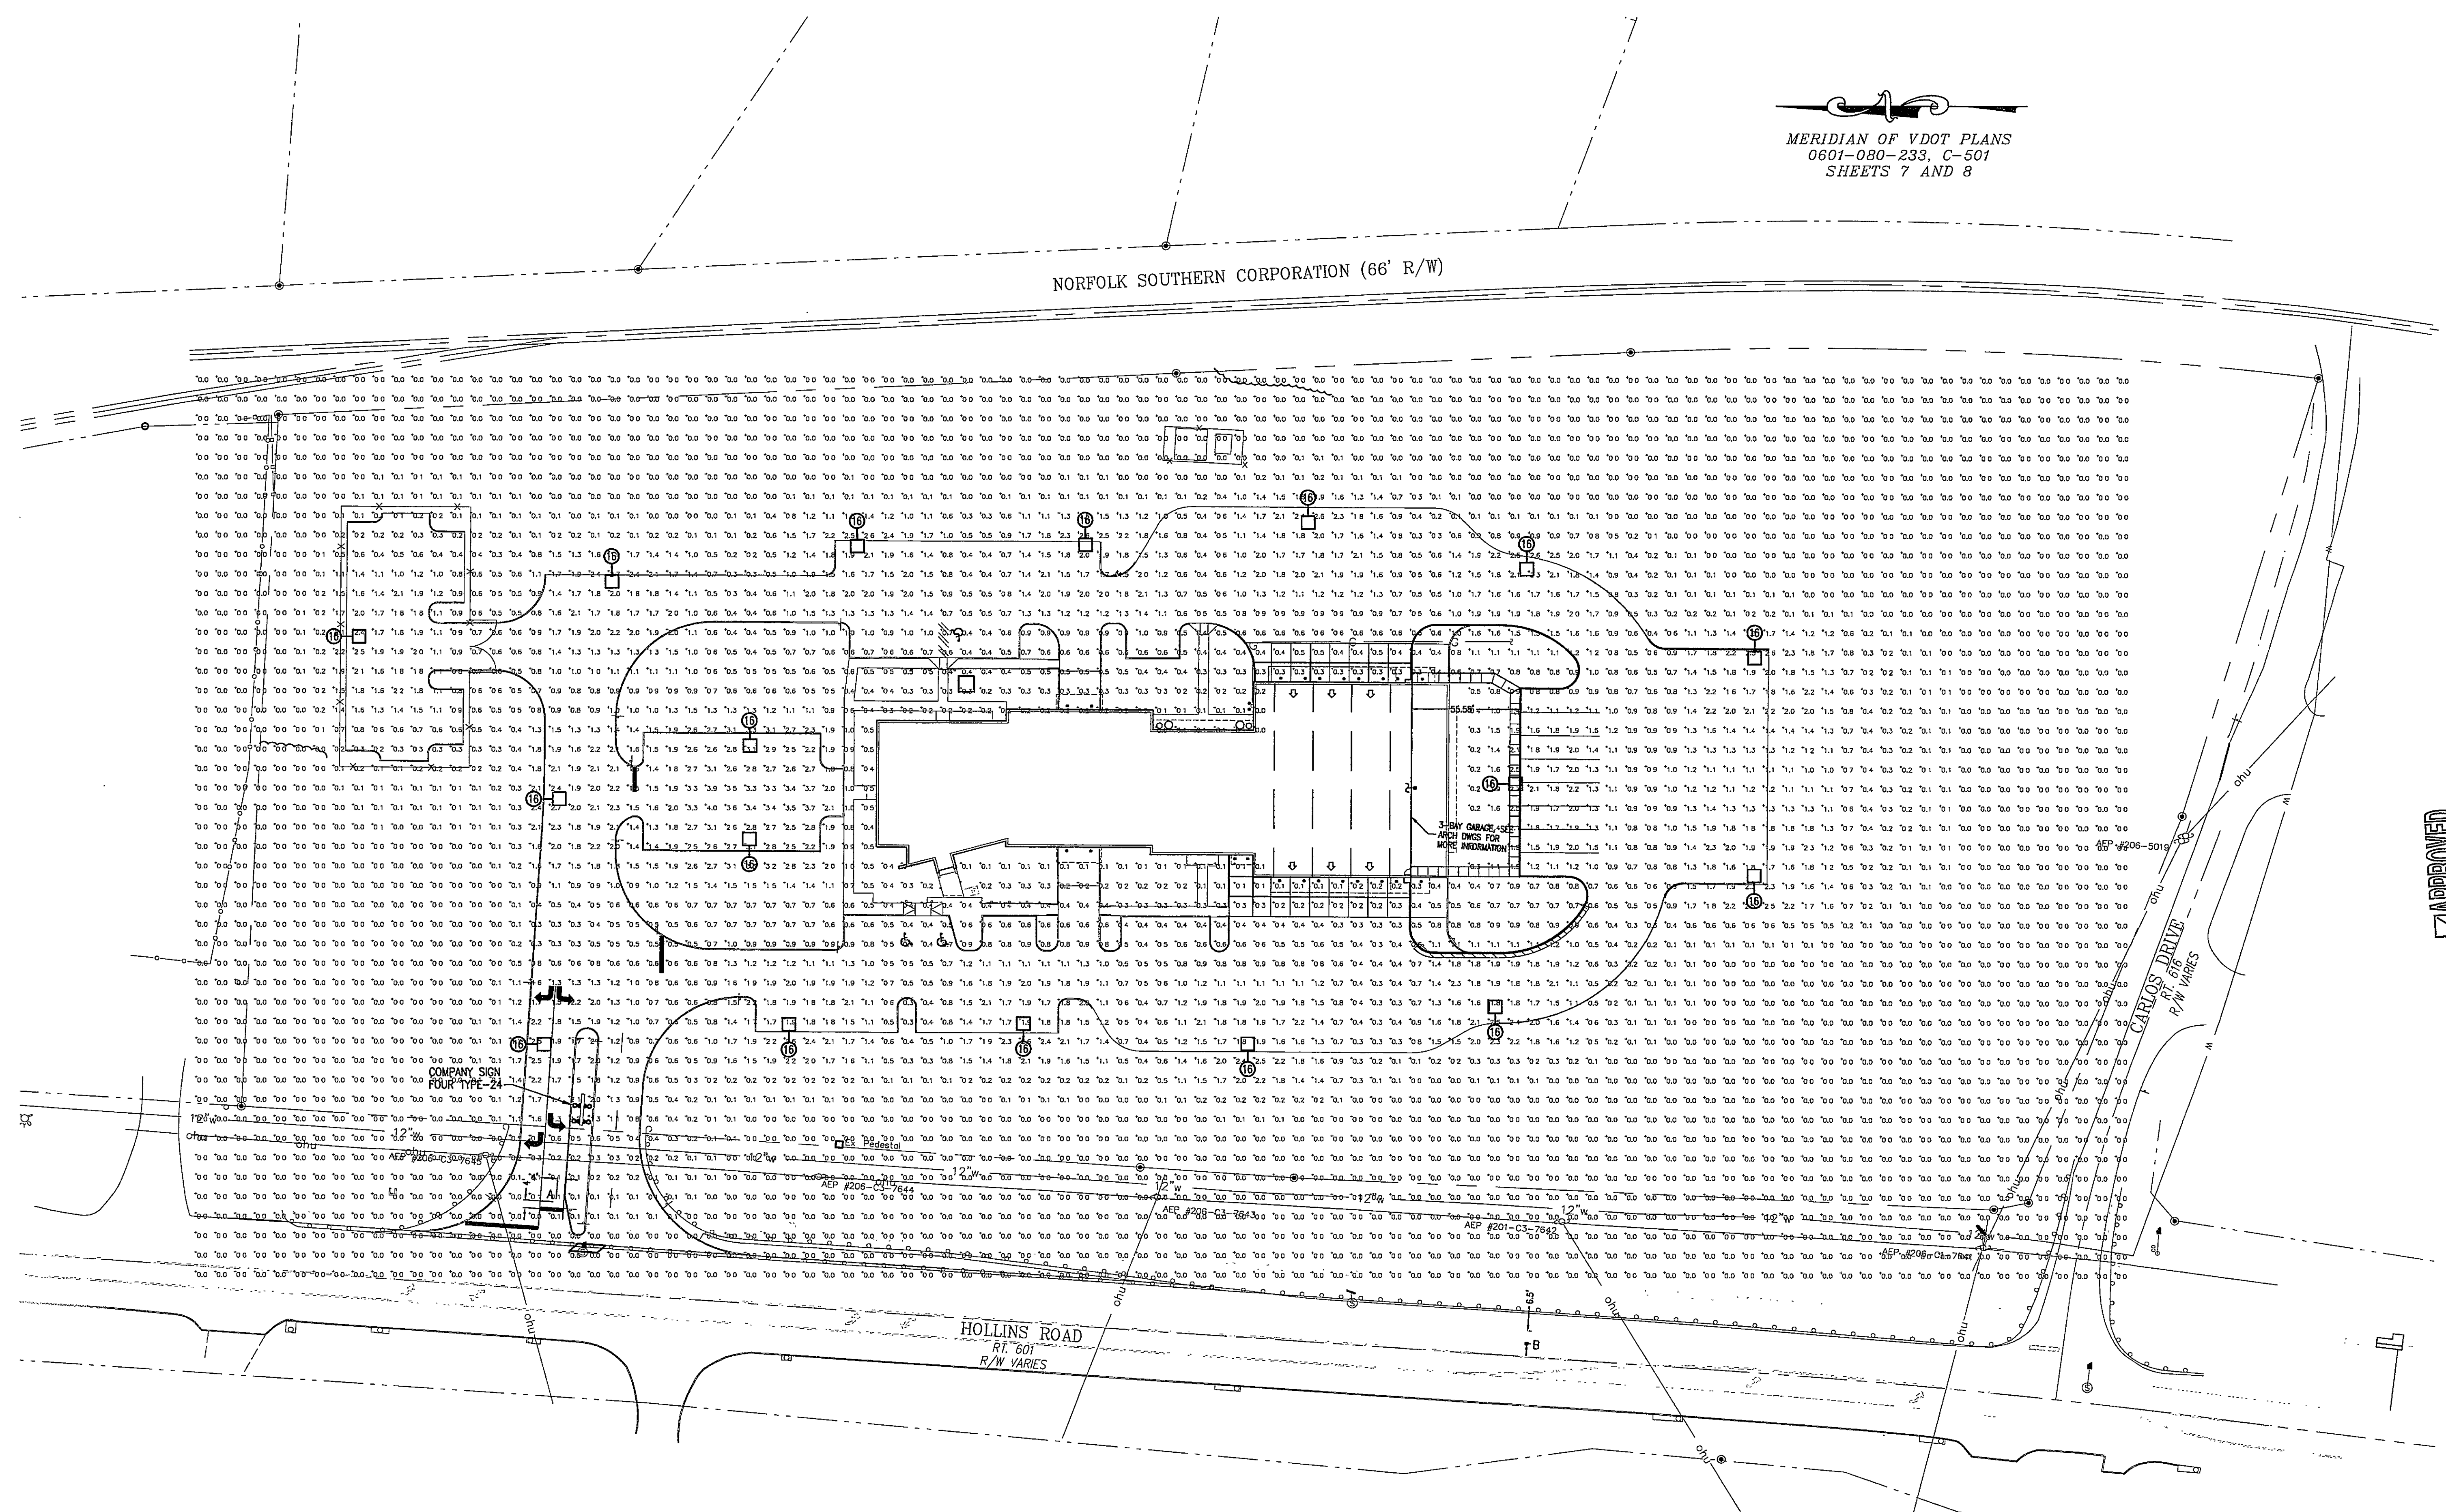


MERIDIAN OF VDOT PLANS
0601-080-233, C-501
SHEETS 7 AND 8

APPROVED

ALL EXTERIOR LIGHTING FIXTURES SHALL BE DESIGNED, LOCATED AND ARRANGED SO AS NOT TO DIRECT GLARE ON ADJACENT STREETS OR RESIDENTIAL PROPERTIES. THE INTENSITY AT ADJACENT STREETS OR RESIDENTIAL PROPERTIES SHALL NOT EXCEED 0.5 FOOT CANDLES.


ELECTRICAL - SITE LIGHTING PLAN
SCALE: 1" = 40'

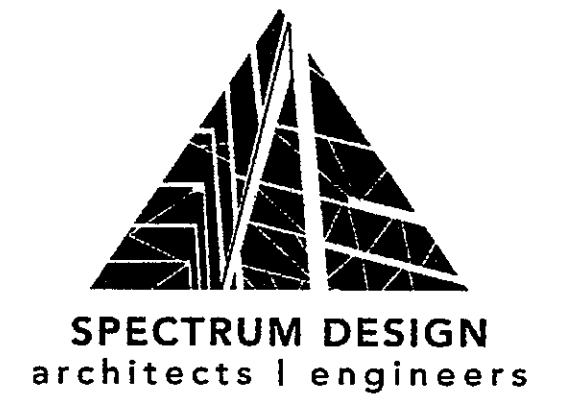

10 CHURCH AVE SE, PLAZA SUITE 1 ROANOKE, VIRGINIA 24011 540.342.6001
ROANOKE • MARION

FLEET SERVICE
CENTER
ROANOKE COUNTY
5253 Old Hollins Rd
Roanoke, VA 24019
IFB-0898

SPECTRUM DESIGN PROJECT NO. 06118

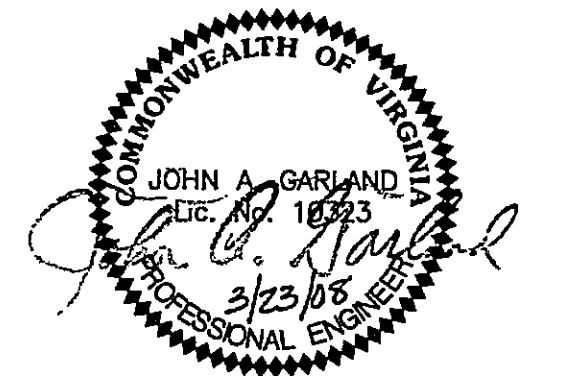

DATE	March 23, 2008	
DESIGN ARCHITECT	WWH	
PROJECT ARCHITECT		
PROJECT ENGINEER	LER/BSM	
CHECKED BY	JAG/LAD	
DRAWN BY	LER/BSM	
REVISIONS	NUMBER	DATE

SHEET TITLE
ELECTRICAL -
SITE LIGHTING PLAN

E302