
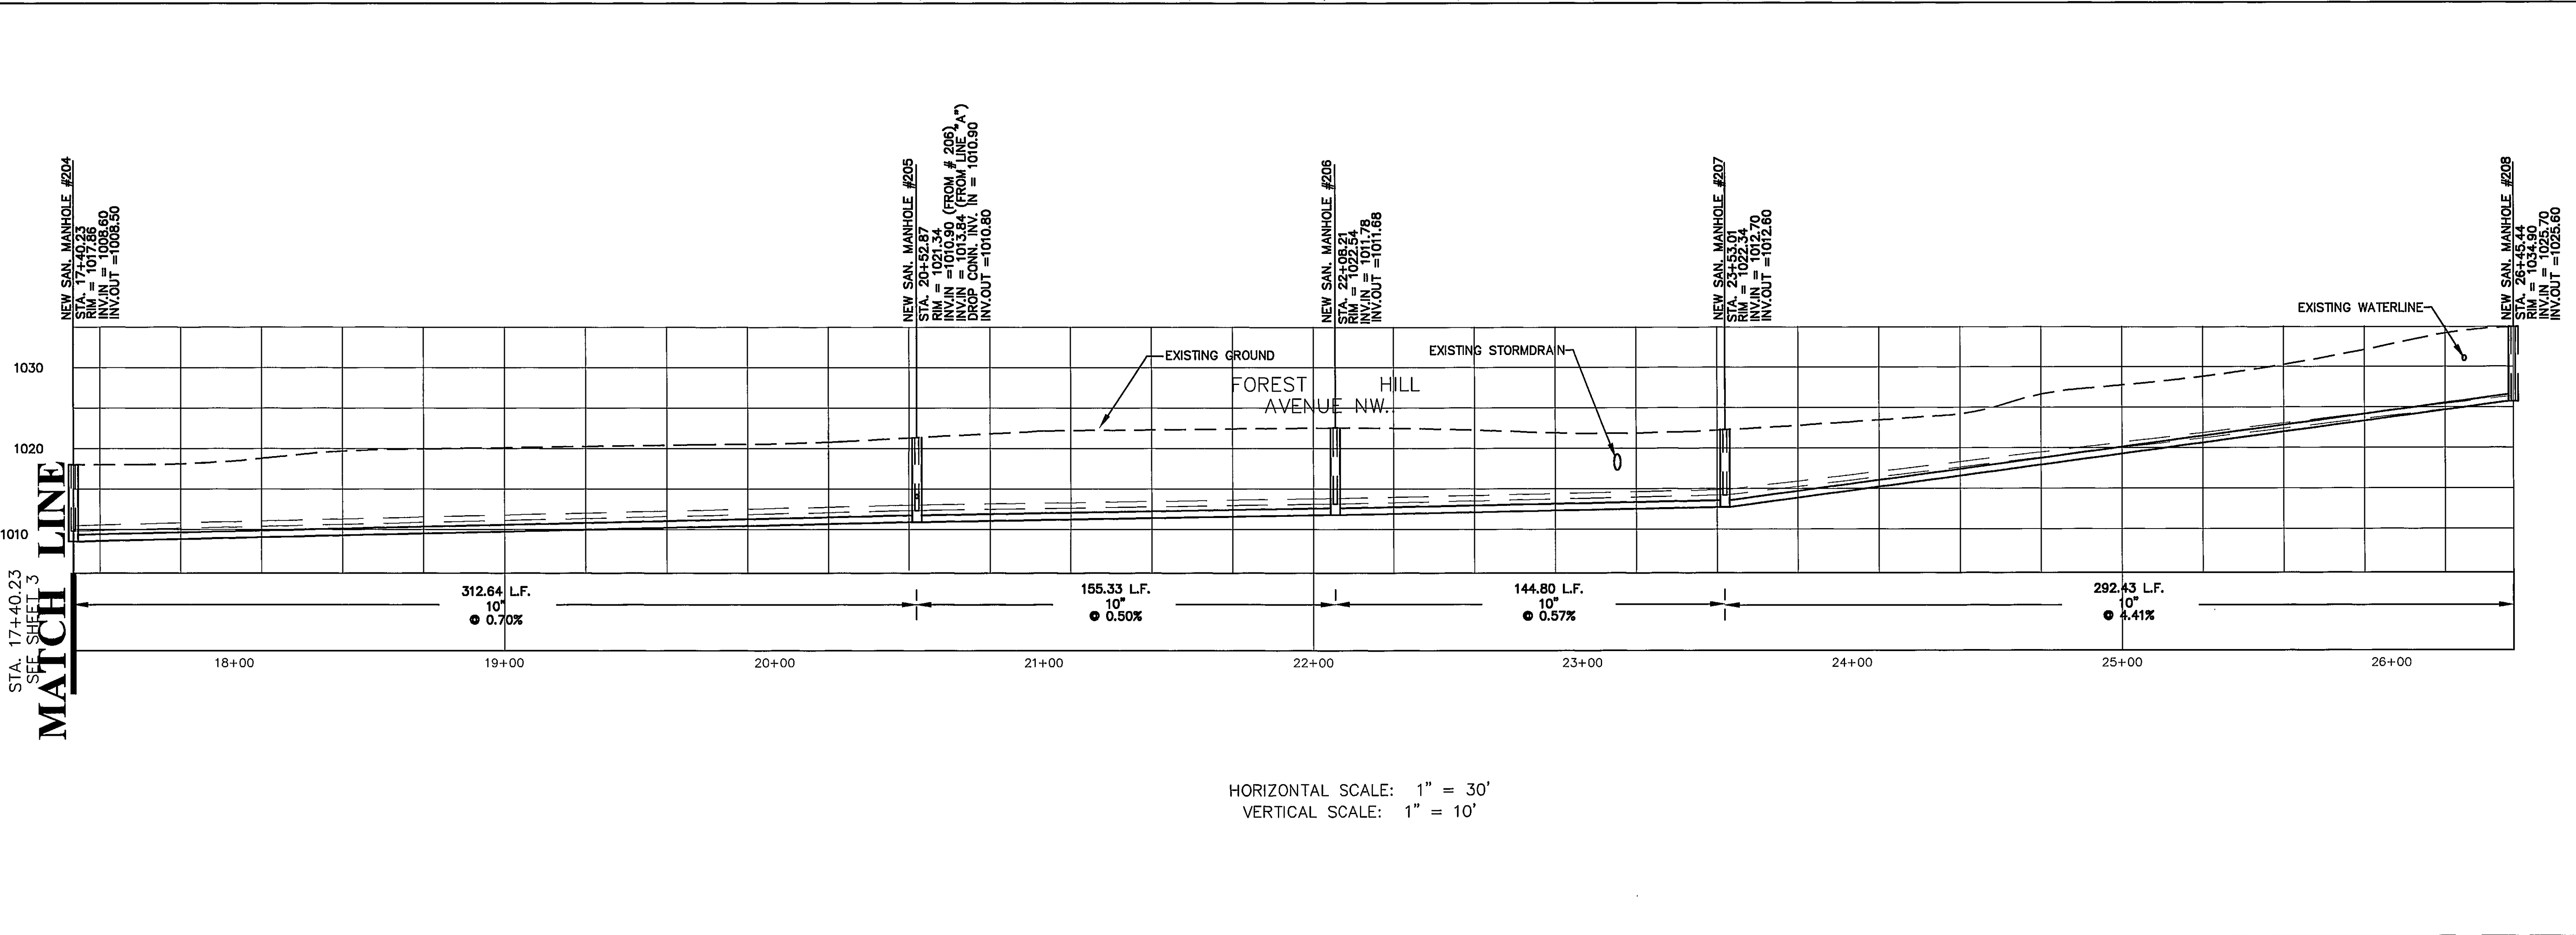


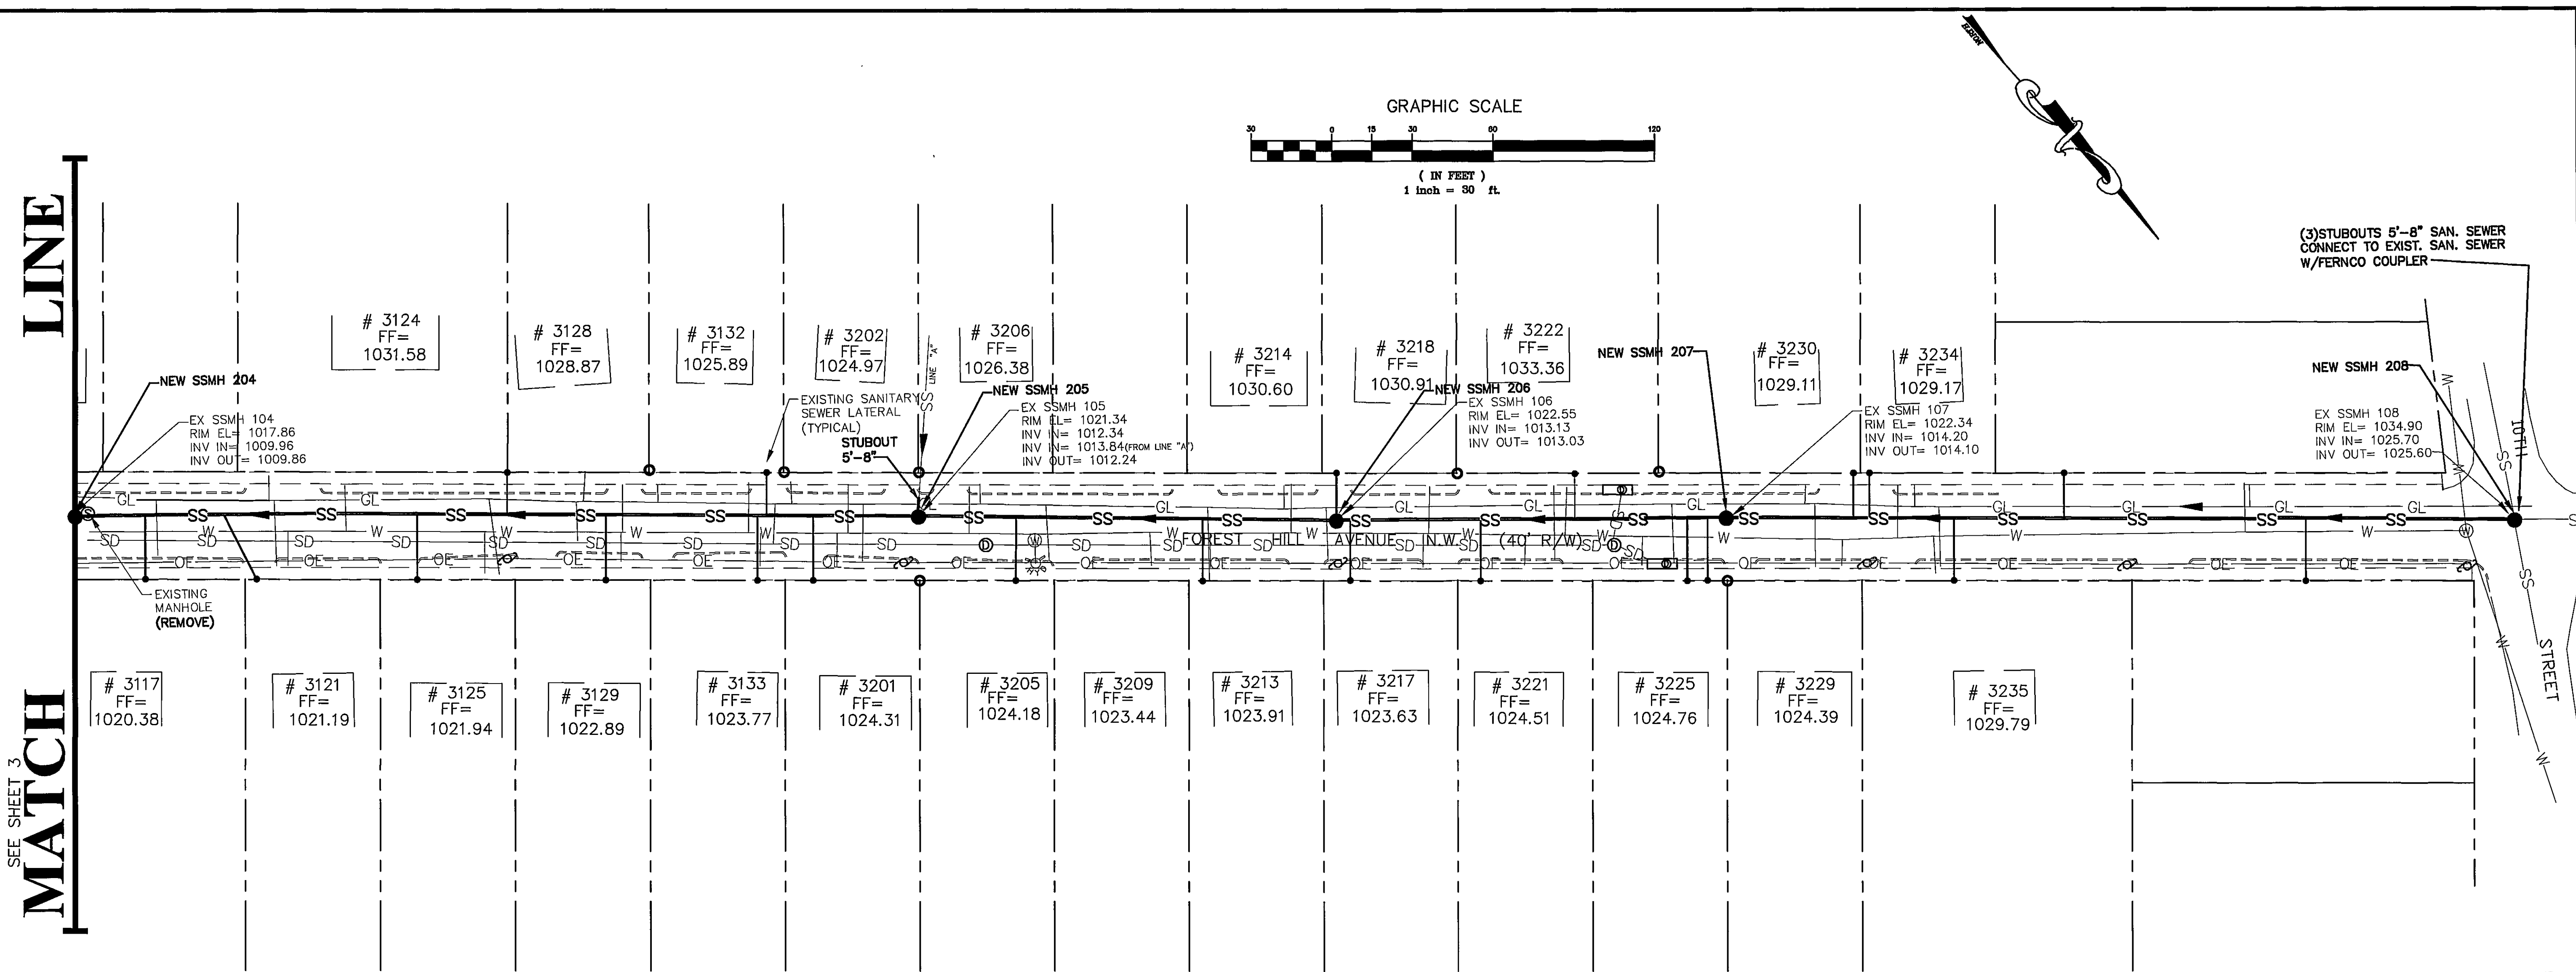

102 Albemarle Ave
Roanoke, Virginia
24013
www.lmwpc.com
ph: 540.345.0675
fax: 540.342.4456
lmweng@lmwpc.com

P.C.

W

M

L

Engineering
Architecture
Surveying
Landscape Design

FOREST HILL AVENUE
SANITARY SEWER IMPROVEMENTS
ROANOKE, VIRGINIA

NO.	DATE	DESCRIPTION	BY

PLAN AND PROFILE
STA. 17+40.23 - 26+45.44

COMMISSIONED BY
RICHARD C. WHITE
NO. 020021
2-14-05
PROFESSIONAL ENGINEER - VIRGINIA

Designed By CHW
Drawn By CHW
Checked By RCW
Approved By RCW
Submitted By RCW
Drawing RCW
Date 10/26/04
Scale AS SHOWN
Commission No. 2938

Sheet 4 of 5