

WATER POLLUTION CONTROL FACILITY

FOR THE


TOWN OF BOONES MILL

BOONES MILL, VIRGINIA



MEMBERS OF THE TOWN COUNCIL

HONORABLE FRANCES B. McNEIL	MAYOR
MAURICE TURNER	VICE - MAYOR
DALE FISHER	MEMBER
JOHN COOPER	MEMBER
CRAIG DREWERY	MEMBER
REV. JIMMY ROBINSON	MEMBER
W. O. NUNLEY	MEMBER
KATHERINE J. EATON	CLERK / TREASURER

RALPH B. RHODES, ATTORNEY	REGISTERED AGENT
HUTCHERSON AND RHODES	
ROCKY MOUNT, VIRGINIA	

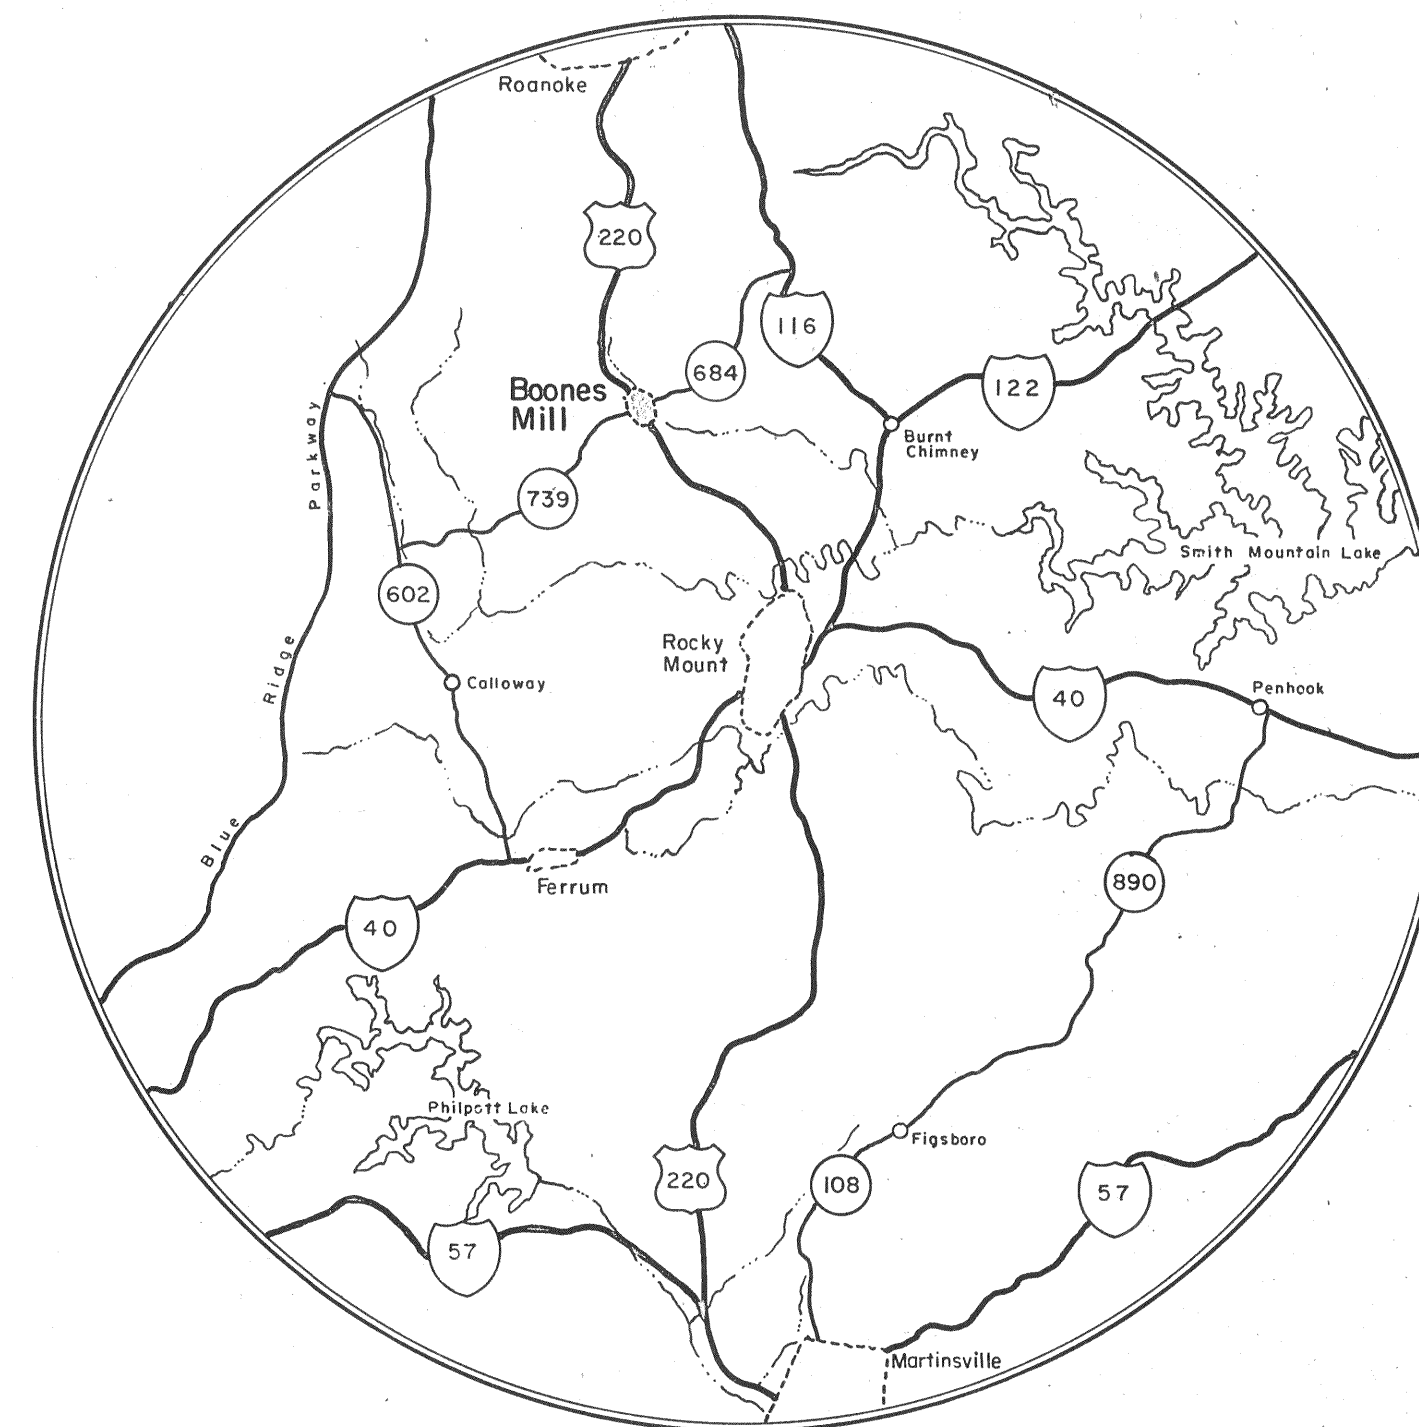

SCALE: 1" = 6 MILES

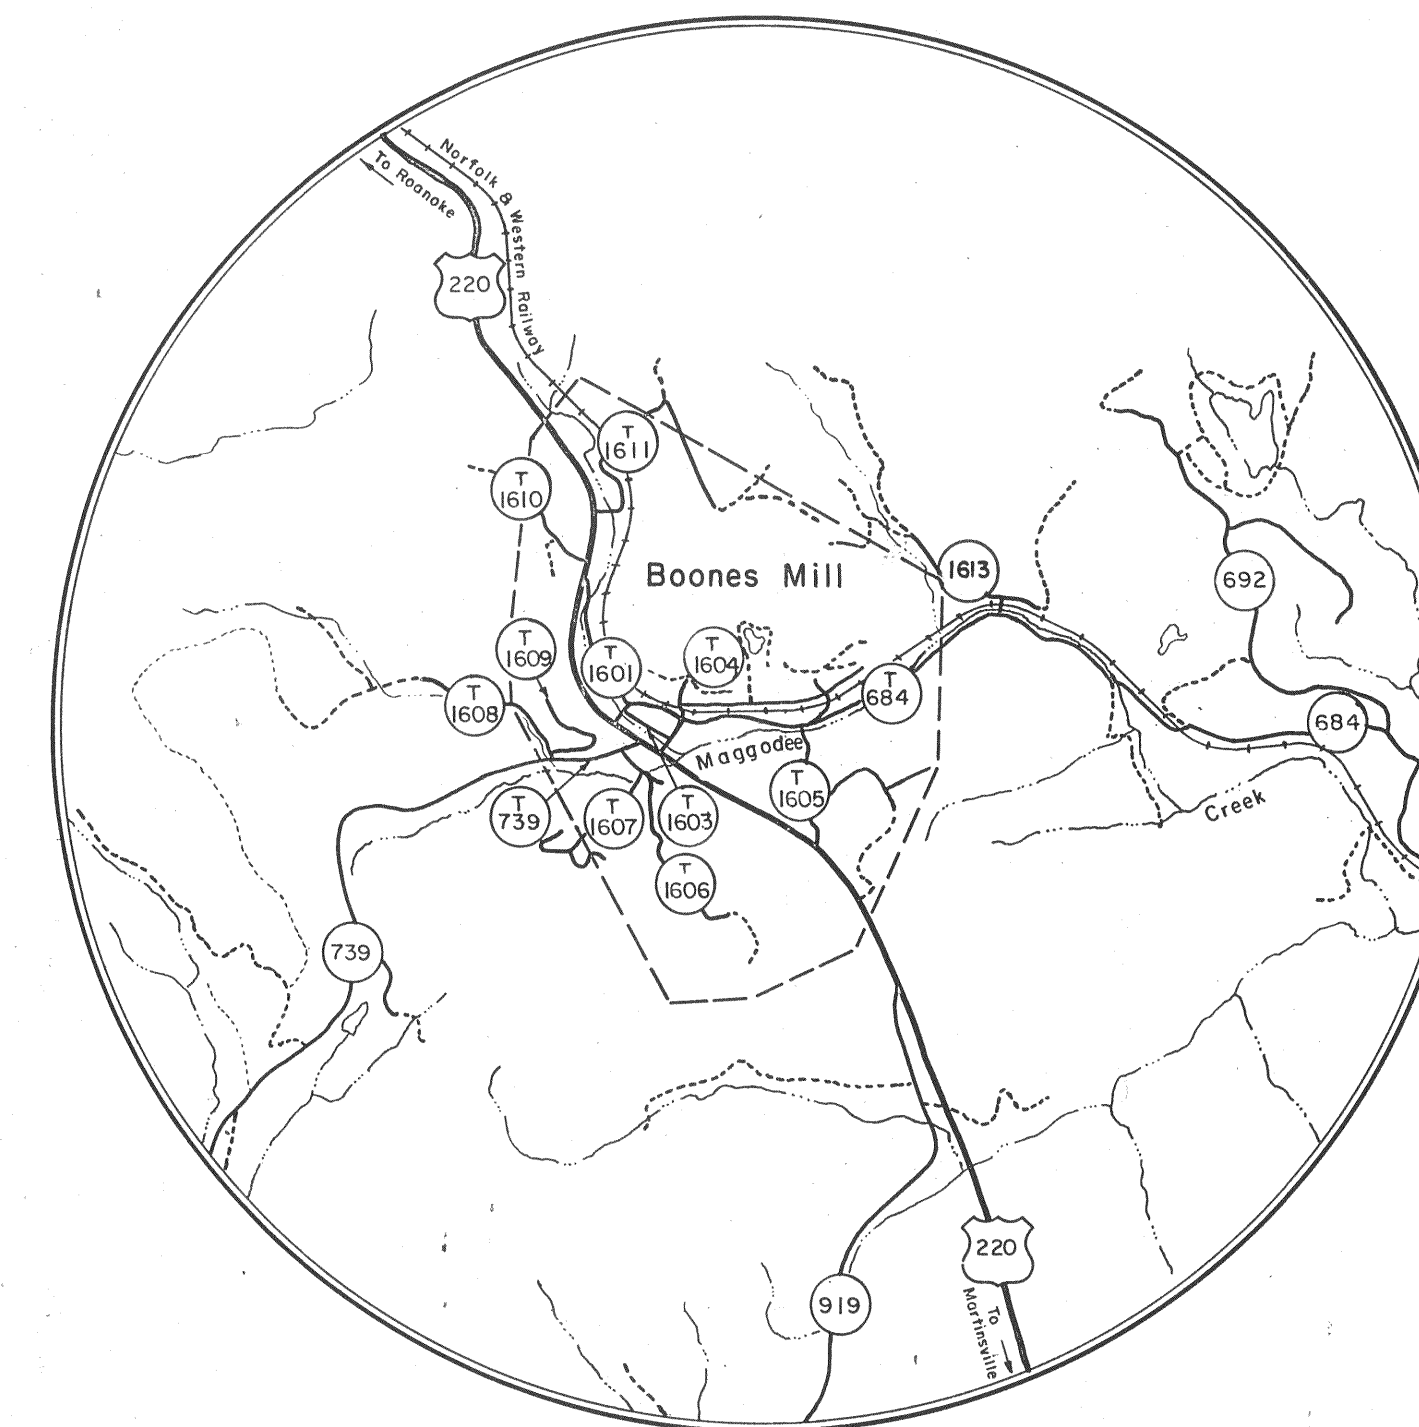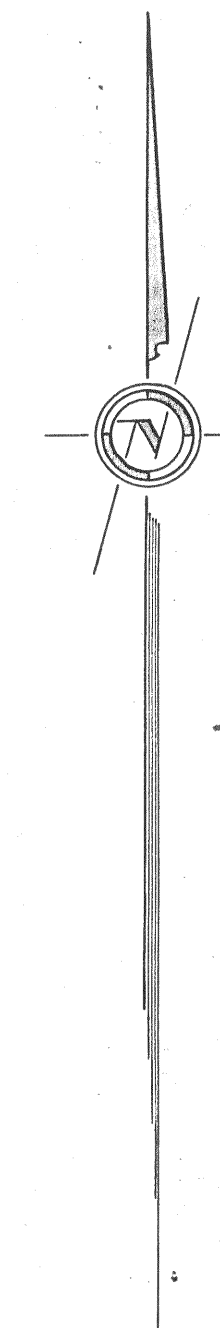

SCALE: 1" = 2000 FEET

SCHEDULE OF DRAWINGS

SHEET	TITLE	STATION
CS-1	COVER SHEET	
IS-2	INDEX SHEET	
PP-3	LINE 1A	3+32.00 - 12+00.00
PP-3A	LINE 1A	3+66.00 AND - 17+25.00
PP-4	LINE 1A	17+25.00 - 29+23.34 AND
PP-4A	LINE 1A	10+00.00 - 16+00.00 AND
	and LINE 1	16+11.87 - 29+41.87
PP-5	LINE 1	29+41.87 - 42+25.33
PP-6	LINE 1	42+25.33 - 54+21.29 BK.
PP-7	LINE 1	54+96.74 AND - 64+56.16 BK.
PP-8	LINE 1	70+00.00 AND - 81+45.70
PP-9	LINE 1	81+45.70 - 87+28.29
PP-10	LINE 1	87+28.29 - 98+73.16
PP-11	LINE 3	11+90.13 - 24+45.10
PP-12	LINE 4	10+00.00 - 17+01.65
PP-13	LINE 6	10+00.00 - 15+21.53
PP-14	LINE 7	10+00.00 - 13+79.09
PP-15	LINE 9	10+00.00 - 11+65.32
TF-16A	LEACHING FIELD SITE	
TF-16B	STABILIZATION POND SITE	
TF-17A	LEACHING FIELD SITE PLAN	
TF-17B	STABILIZATION POND SITE PLAN	
TF-17C	EROSION AND SEDIMENT CONTROL PLAN	
TF-18	HYDRAULIC PROFILE AND SCHEMATIC FLOW DIAGRAM	
TF-19	PACKAGED GRINDER PUMP STATION	
TF-20	AUXILIARY DETAILS	
TF-21	AUXILIARY DETAILS	
TF-22	AUXILIARY DETAILS	
TF-23	CONSTRUCTION DETAILS	
TF-24	CONSTRUCTION DETAILS	
TF-25	TEST DRILL HOLES	
TF-26	Not Used	51+02.16 - 42+31.37
TF-27	ALTERNATE BID	42+34.16 - 28+93.85
TF-28	ALTERNATE BID	28+93.85 - 14+30.87

EPA GRANT NO. C-510392-02
PLAN SET NO. _____

Final Dpt - PP-12

"AS BUILT" PLANS

PROPOSED SANITARY SEWERAGE SYSTEM TO SERVE THE TOWN OF BOONES MILL, VIRGINIA.			
REVISIONS		J. A. GUSTIN & ASSOCIATES CONSULTING ENGINEERS MARTINSVILLE, VIRGINIA	
3-6-85		DESIGNED BY	SCALE
6-3-85		JAG & RLD	As Noted
8-1-85		DRAWN BY	DATE
9-23-88		TAW	11-23-81
"As Built"		CHECKED BY	SHEET NO.
		NRC, JAG	CS-1