

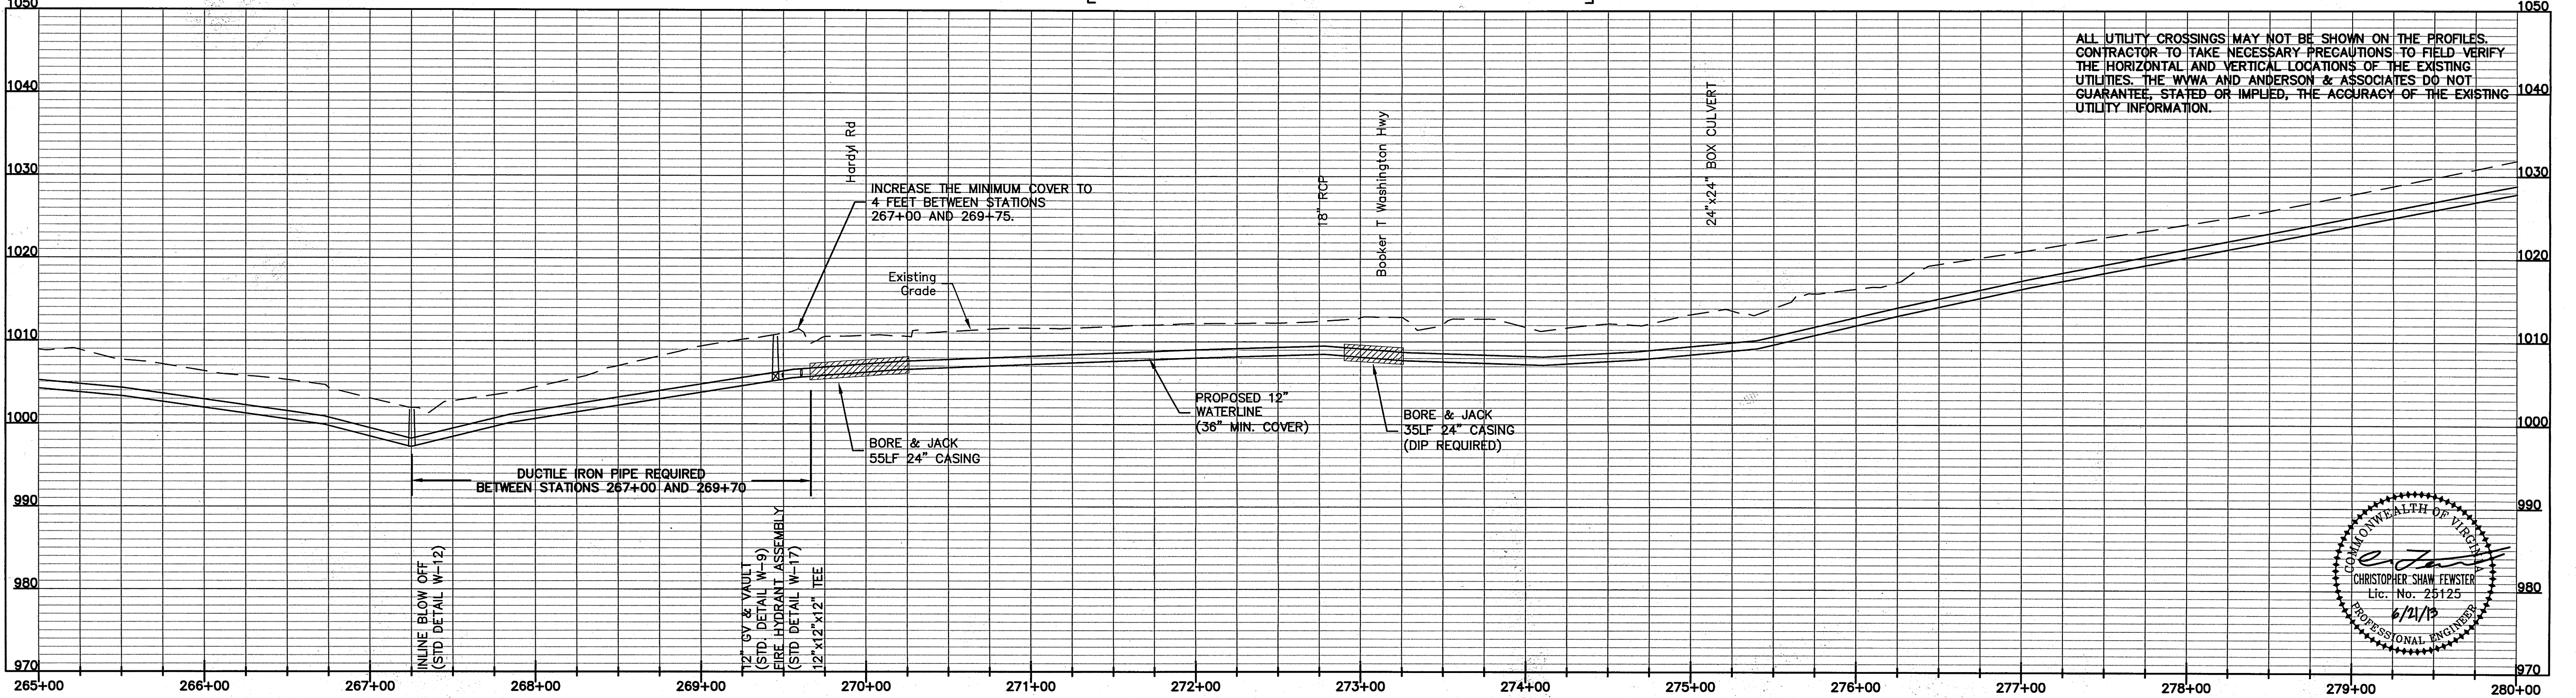


MARKER	OWNER	ADDRESS	METER SIZE	COMMENT
	HODGES RANDALL V & SUE M	11100 BOOKER T WASHINGTON HWY	5/8"	
	MEADOR C GERALD	11210 BOOKER T WASHINGTON HWY	5/8"	

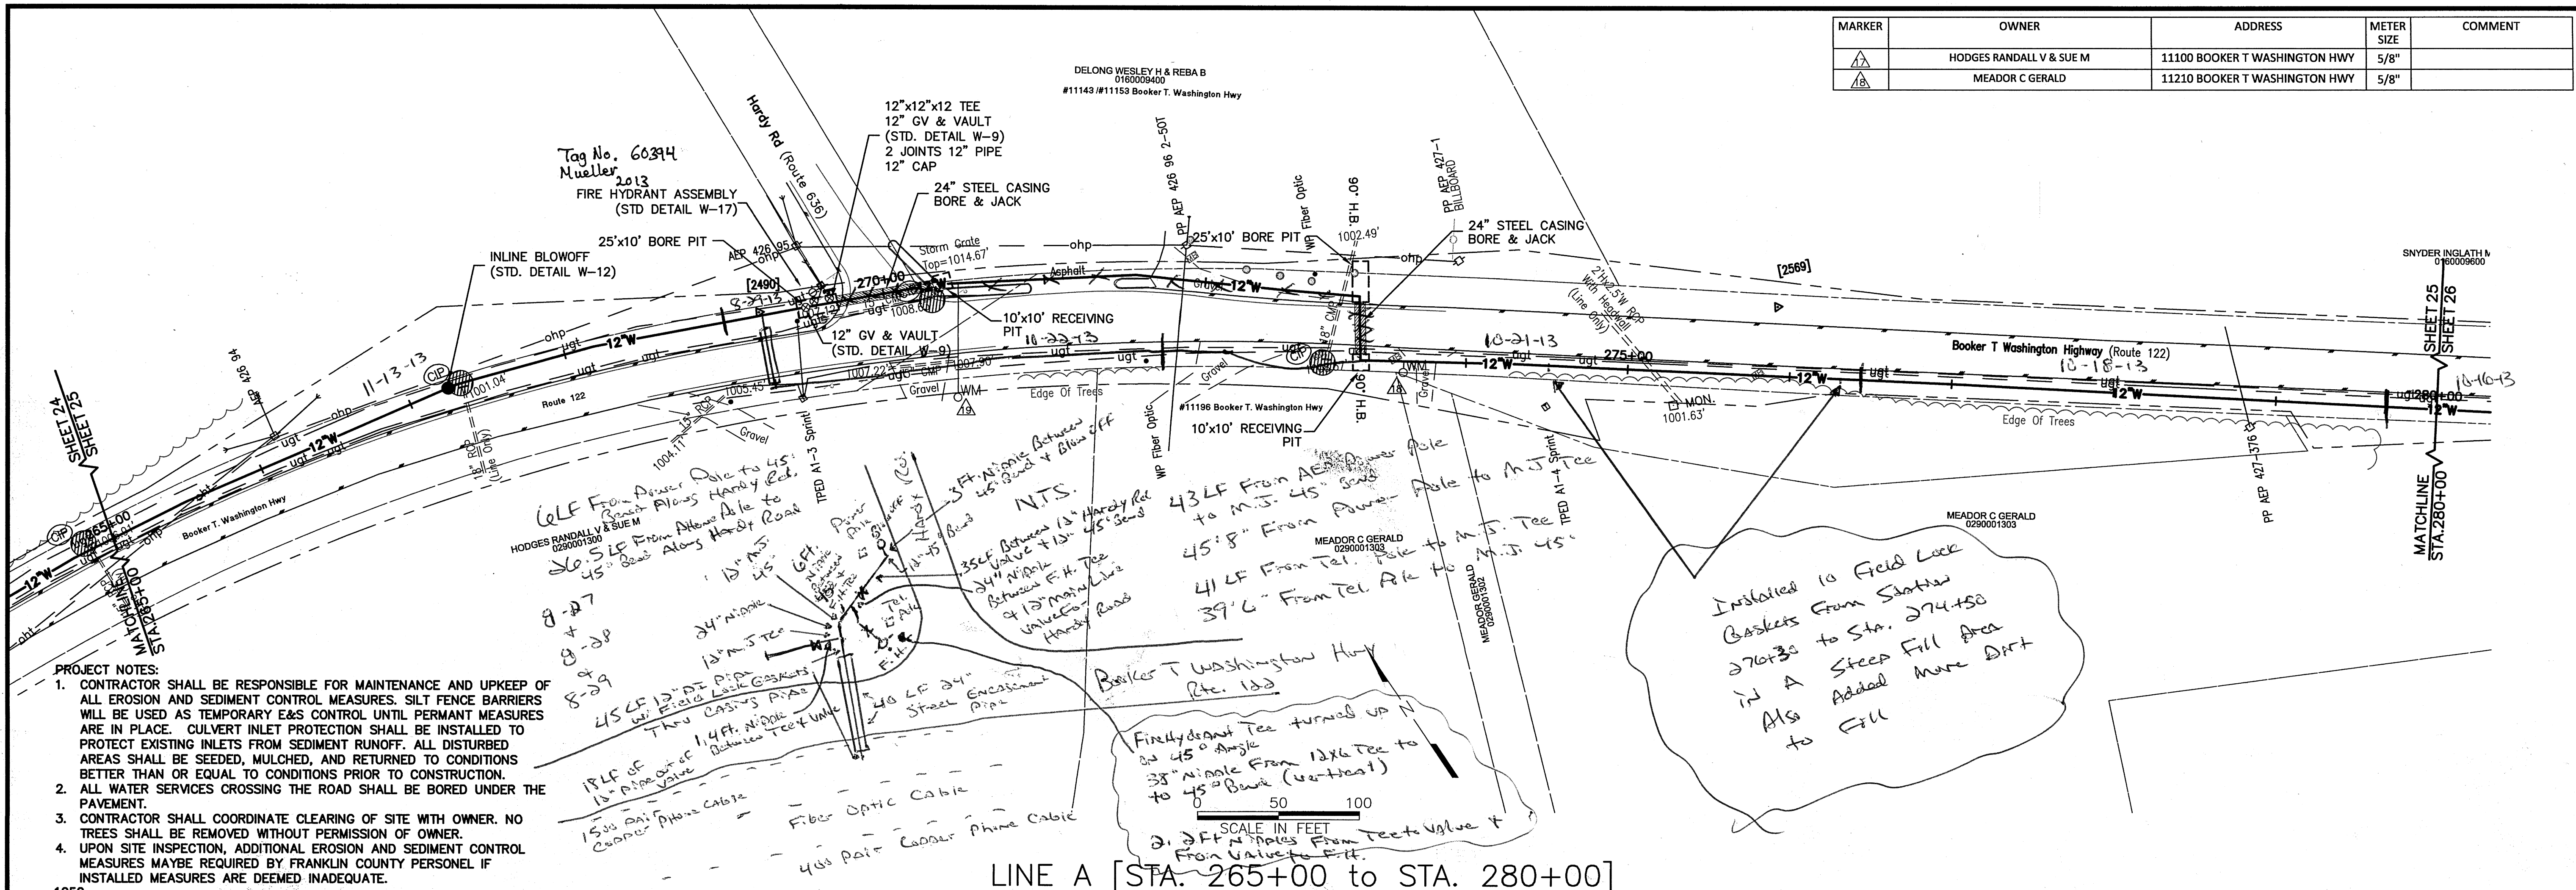

ALL UTILITY CROSSINGS MAY NOT BE SHOWN ON THE PROFILES. CONTRACTOR TO TAKE NECESSARY PRECAUTIONS TO FIELD VERIFY THE HORIZONTAL AND VERTICAL LOCATIONS OF THE EXISTING UTILITIES. THE WWA AND ANDERSON & ASSOCIATES DO NOT GUARANTEE, STATED OR IMPLIED, THE ACCURACY OF THE EXISTING UTILITY INFORMATION.

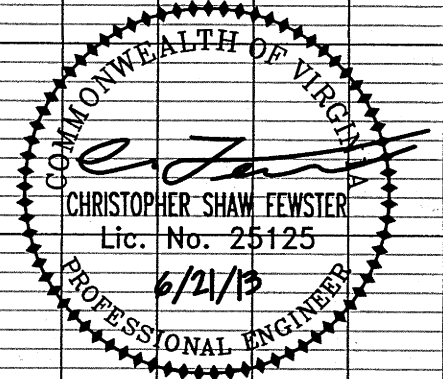

ANDERSON & ASSOCIATES, INC.
Professional Design Services
www.andassoc.com
100 Ardmore St.
Blacksburg, Va. 24060
540-552-5592

DATE : 07 JUN 13	REV. # : 1	COMMENTS : ADDENDUM #1	DATE : 21 JUN 13
DESIGNED: CSF			
DRAWN: SEC			
CHECKED: MGG			
QA/QC: CSF			

FRANKLIN COUNTY / WESTERN VIRGINIA WATER AUTHORITY
BURNT CHIMNEY WATER EXTENSION
FRANKLIN COUNTY, VIRGINIA

Line A - Sta 265+00 to 280+00
PLAN AND PROFILE

DOCUMENT NO. 30337-002
25 SHEET OF 44