



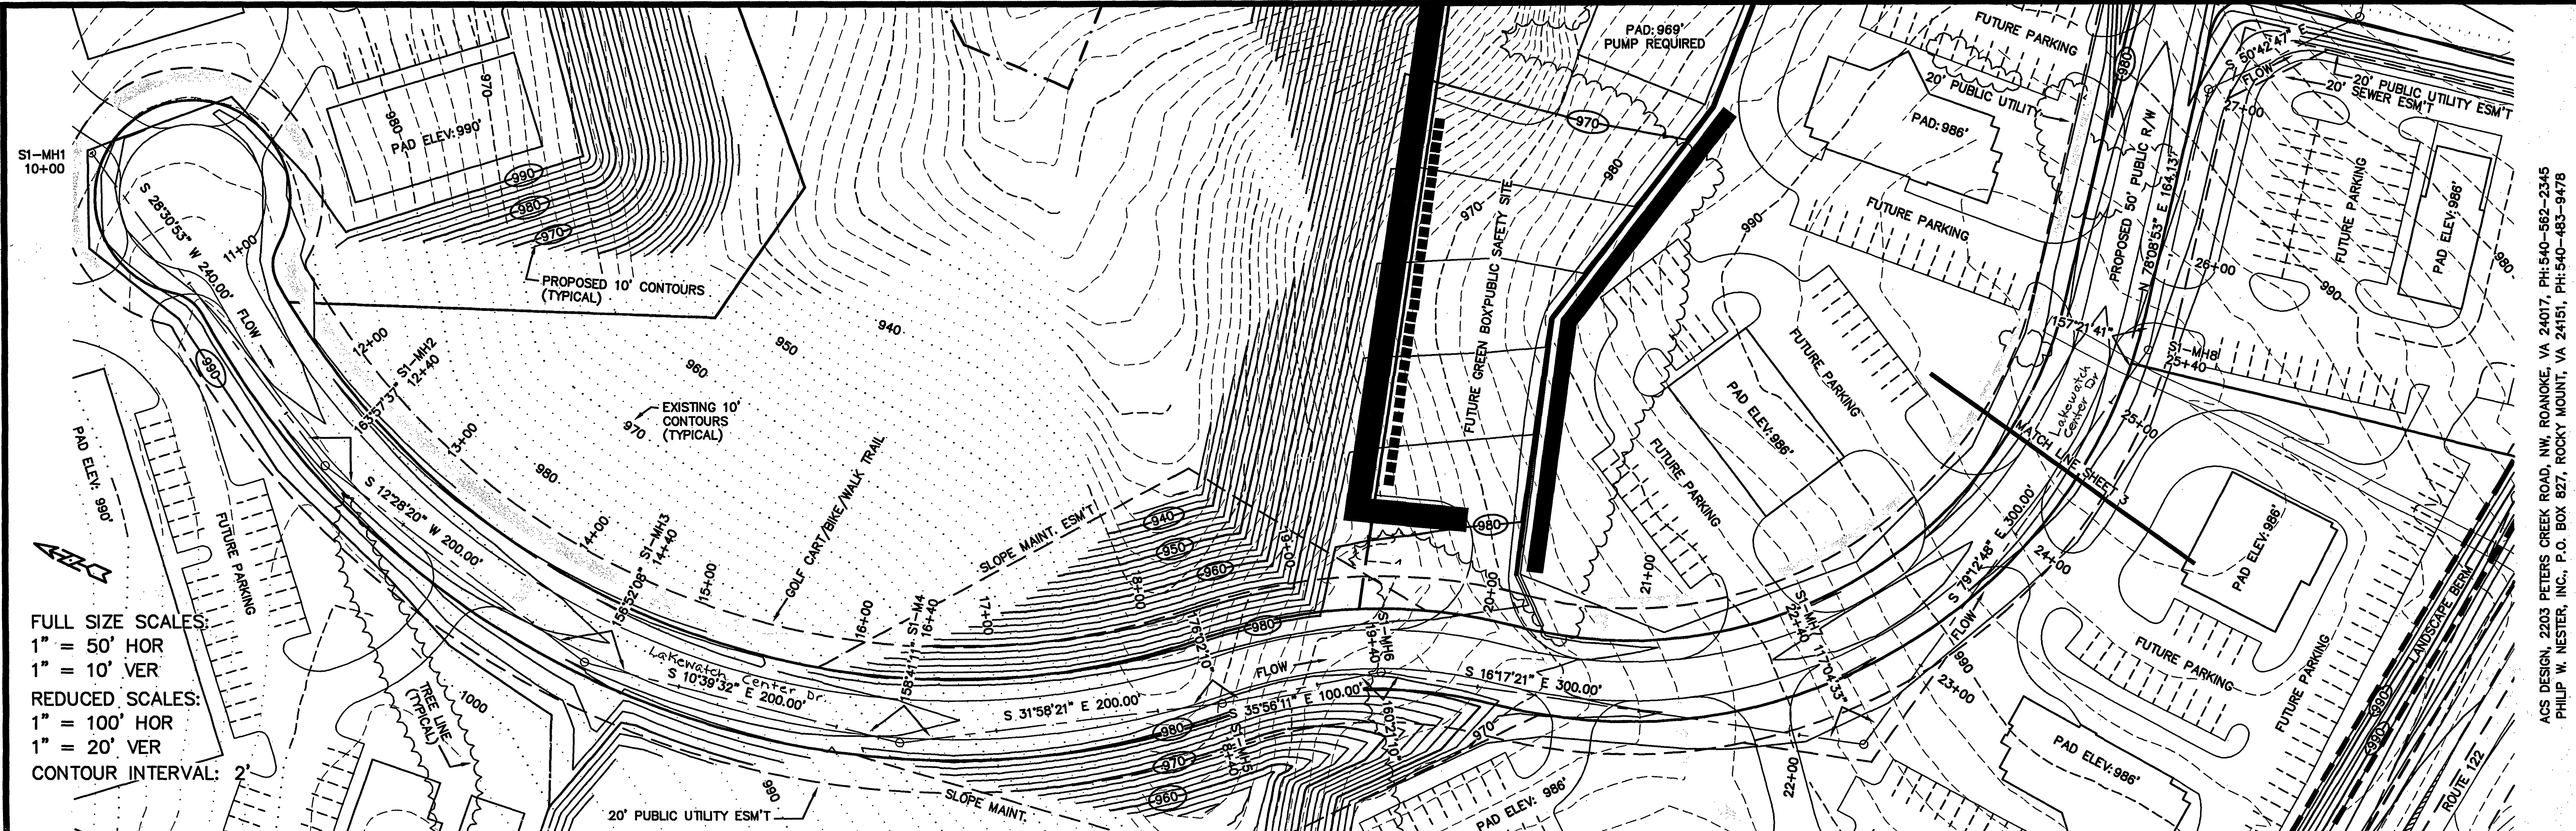

FULL SIZE SCALES:
1" = 50' HOR
1" = 10' VER
REDUCED SCALES:
1" = 100' HOR
1" = 20' VER
CONTOUR INTERVAL: 2'

ACS DESIGN, 2203 PETERS CREEK ROAD, NW, ROANOKE, VA 24017, PH:540-562-2345
PHILIP W. NESTER, INC., P.O. BOX 827, ROCKY MOUNT, VA 24151, PH:540-483-9478

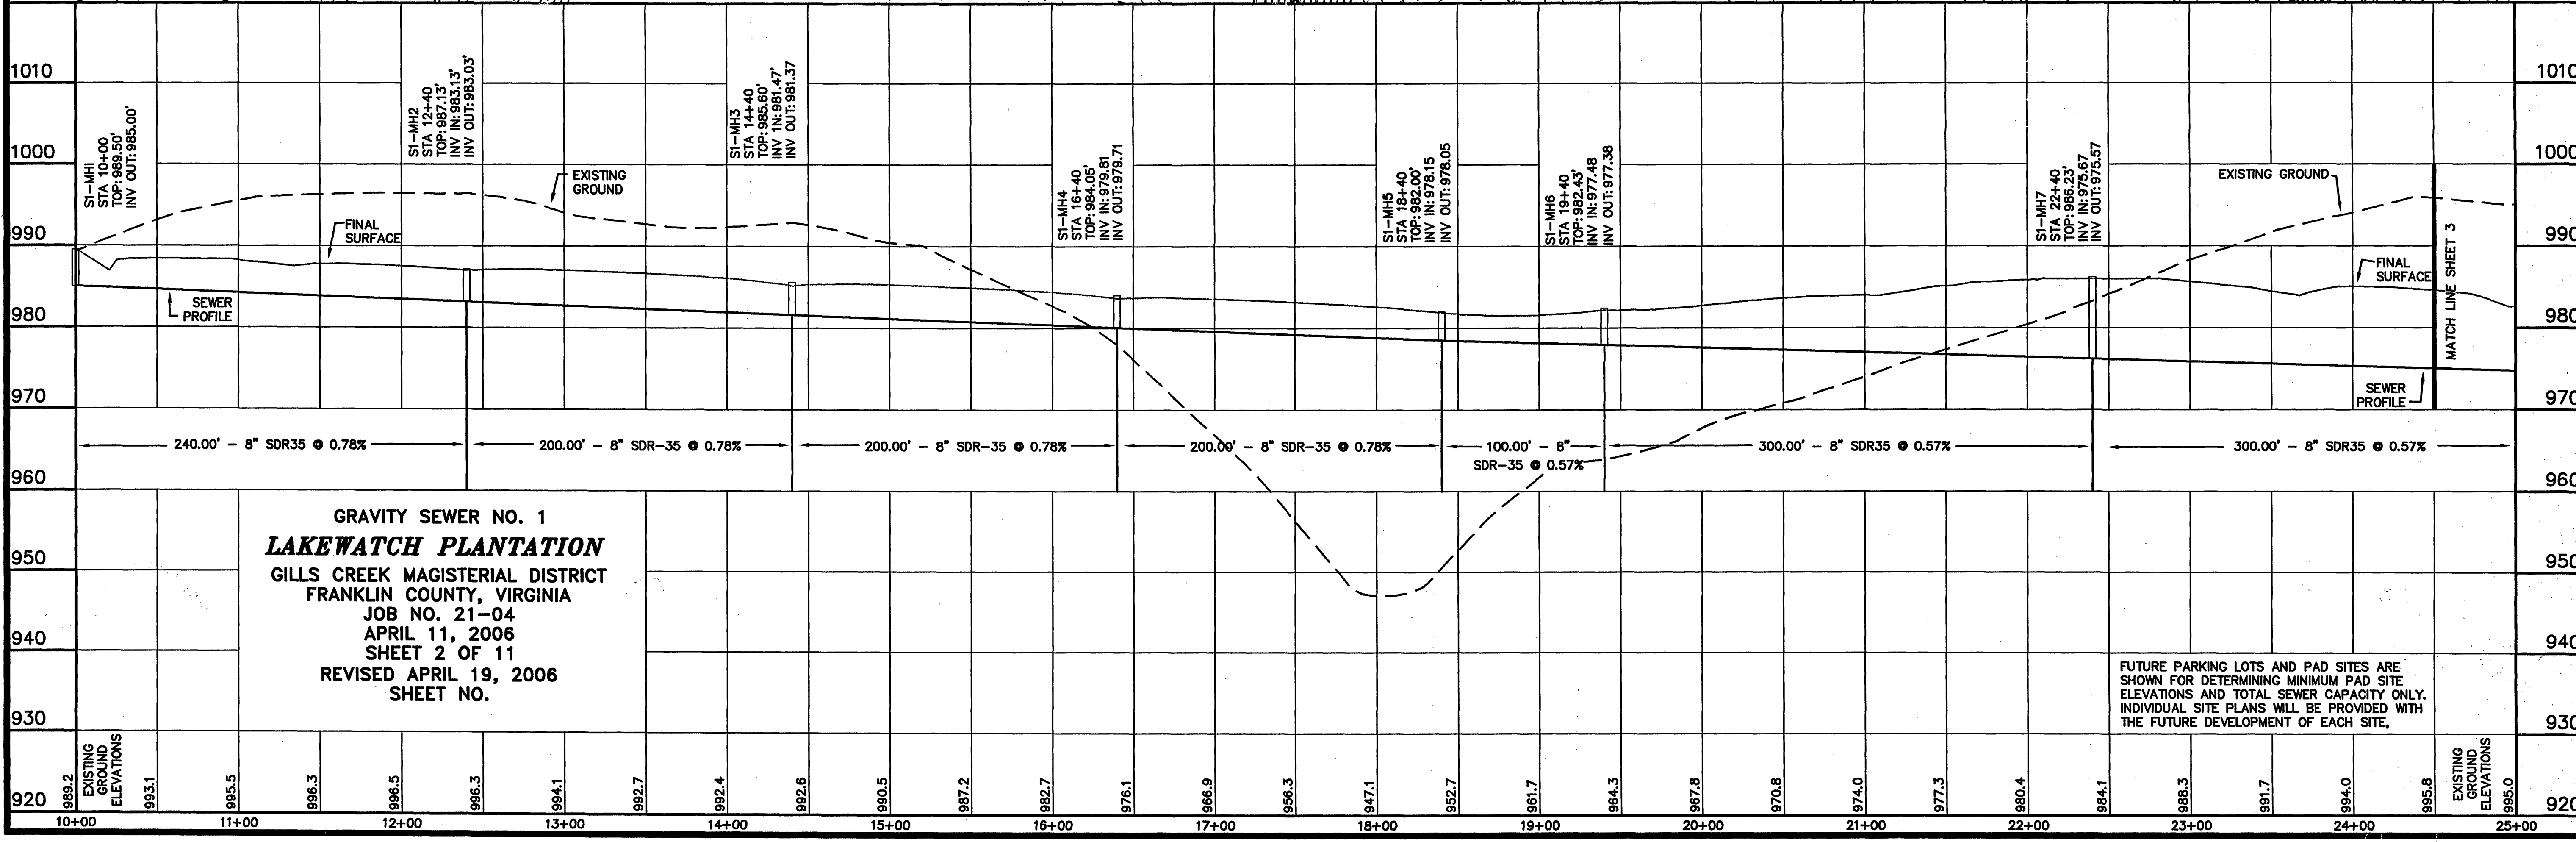

GRAVITY SEWER NO. 1
LAKEWATCH PLANTATION
GILLS CREEK MAGISTERIAL DISTRICT
FRANKLIN COUNTY, VIRGINIA
JOB NO. 21-04
APRIL 11, 2006
SHEET 2 OF 11
REVISED APRIL 19, 2006
SHEET NO.

FUTURE PARKING LOTS AND PAD SITES ARE SHOWN FOR DETERMINING MINIMUM PAD SITE ELEVATIONS AND TOTAL SEWER CAPACITY ONLY. INDIVIDUAL SITE PLANS WILL BE PROVIDED WITH THE FUTURE DEVELOPMENT OF EACH SITE.