


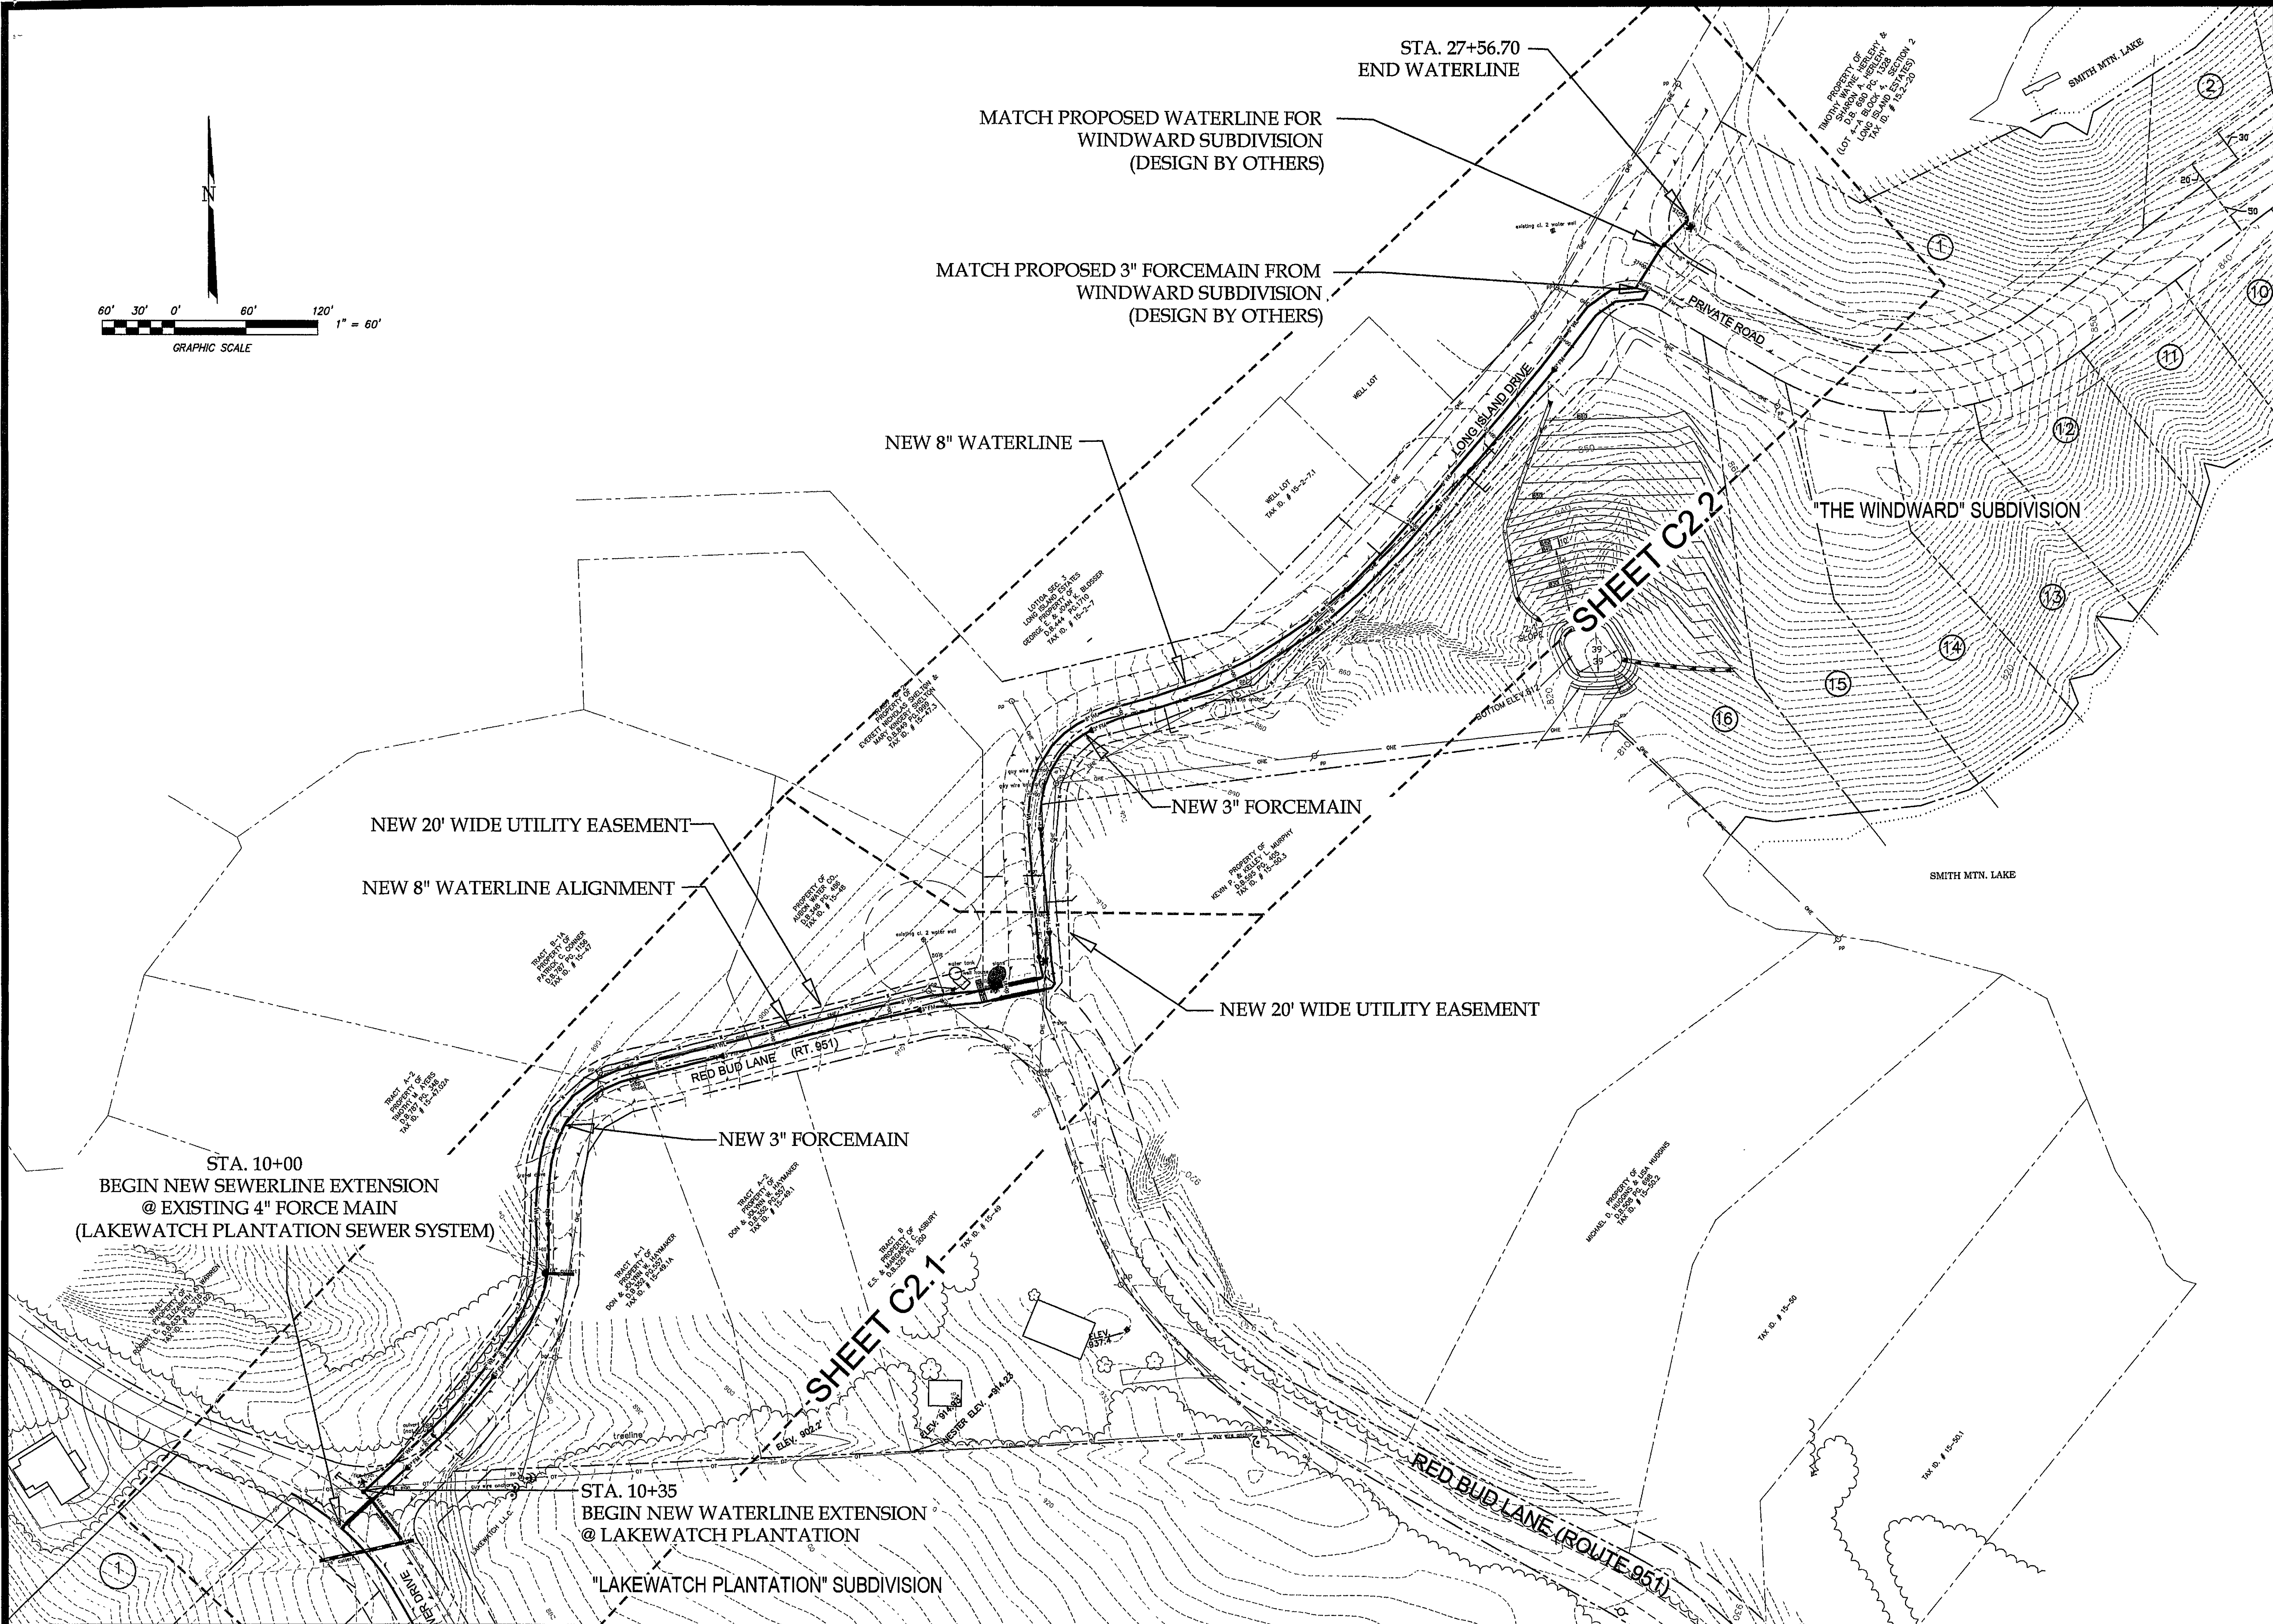

COMMONWEALTH OF VIRGINIA
Daniel M. Early
No. 031787
9/11/06
PROFESSIONAL ENGINEER

**ACS
DESIGN**

ENGINEERING • SURVEYING
LANDSCAPE ARCHITECTURE
CONSTRUCTION MANAGEMENT

2203 PETERS CREEK ROAD
ROANOKE, VIRGINIA 24017
P 540.582.2345 F 562.2344
INFO@ACSDSIGNLLC.COM
WWW.ACSDSIGNLLC.COM

**LAKEWATCH PLANTATION
WATER AND SEWER EXTENSION
FRANKLIN COUNTY, VIRGINIA**

DRAWN BY: CER
DESIGNED BY: CER
CHECKED BY: CME
DATE: 31 AUG. 2005
JOB NUMBER: 06090a

REVISIONS:	
NO. 1	REV. PER SMLGP 8/8/05
NO. 2	
NO. 3	
NO. 4	

SHEET NO.:
C1.1

SITE PLAN