



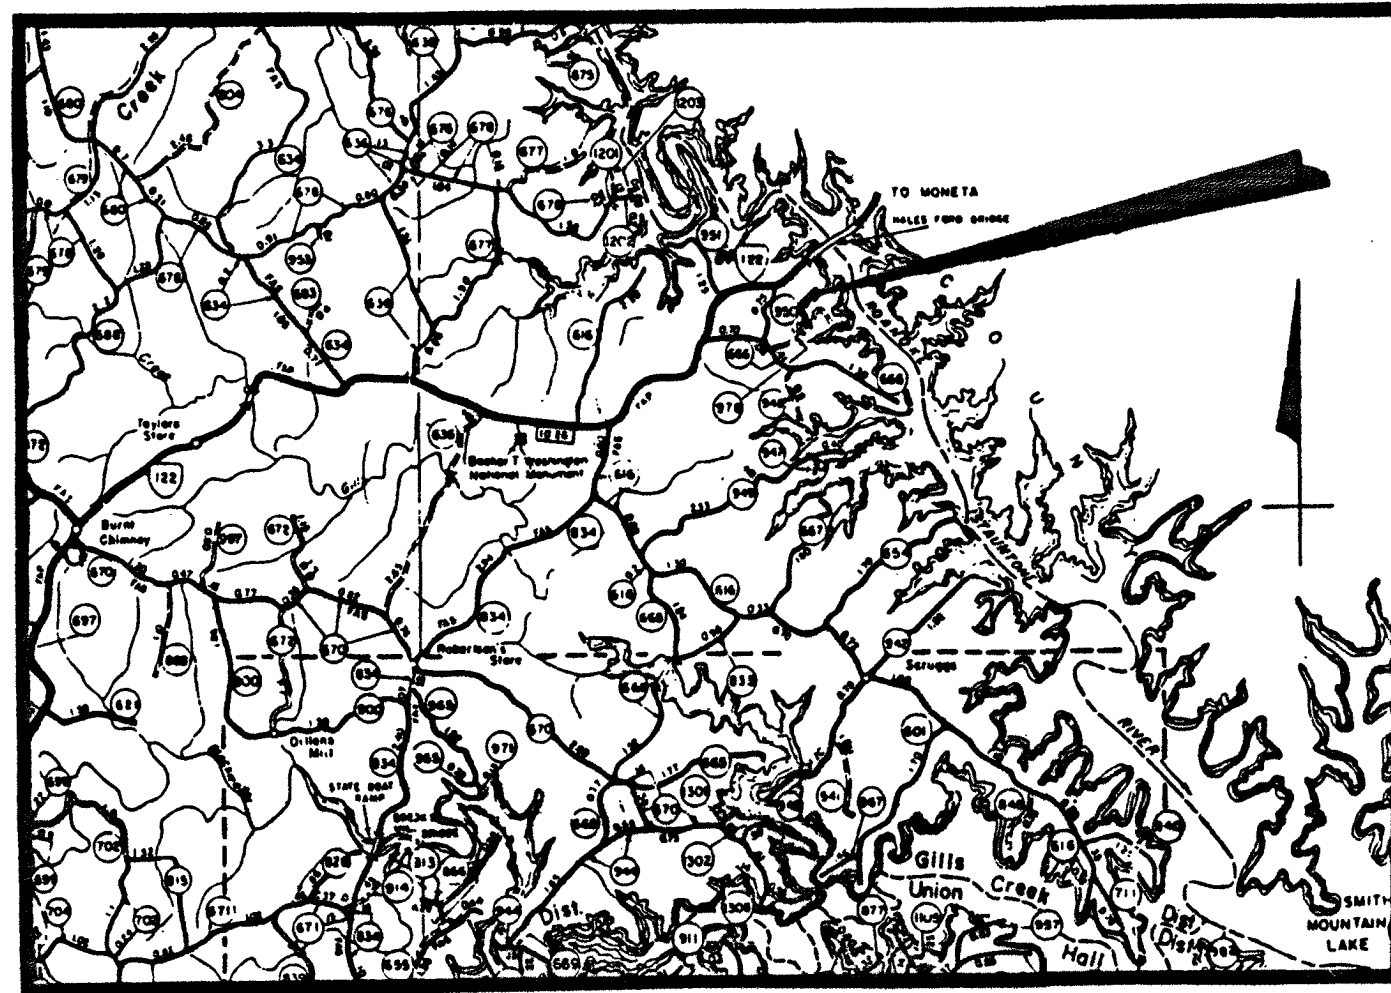

VICINITY MAP
N.T.S.

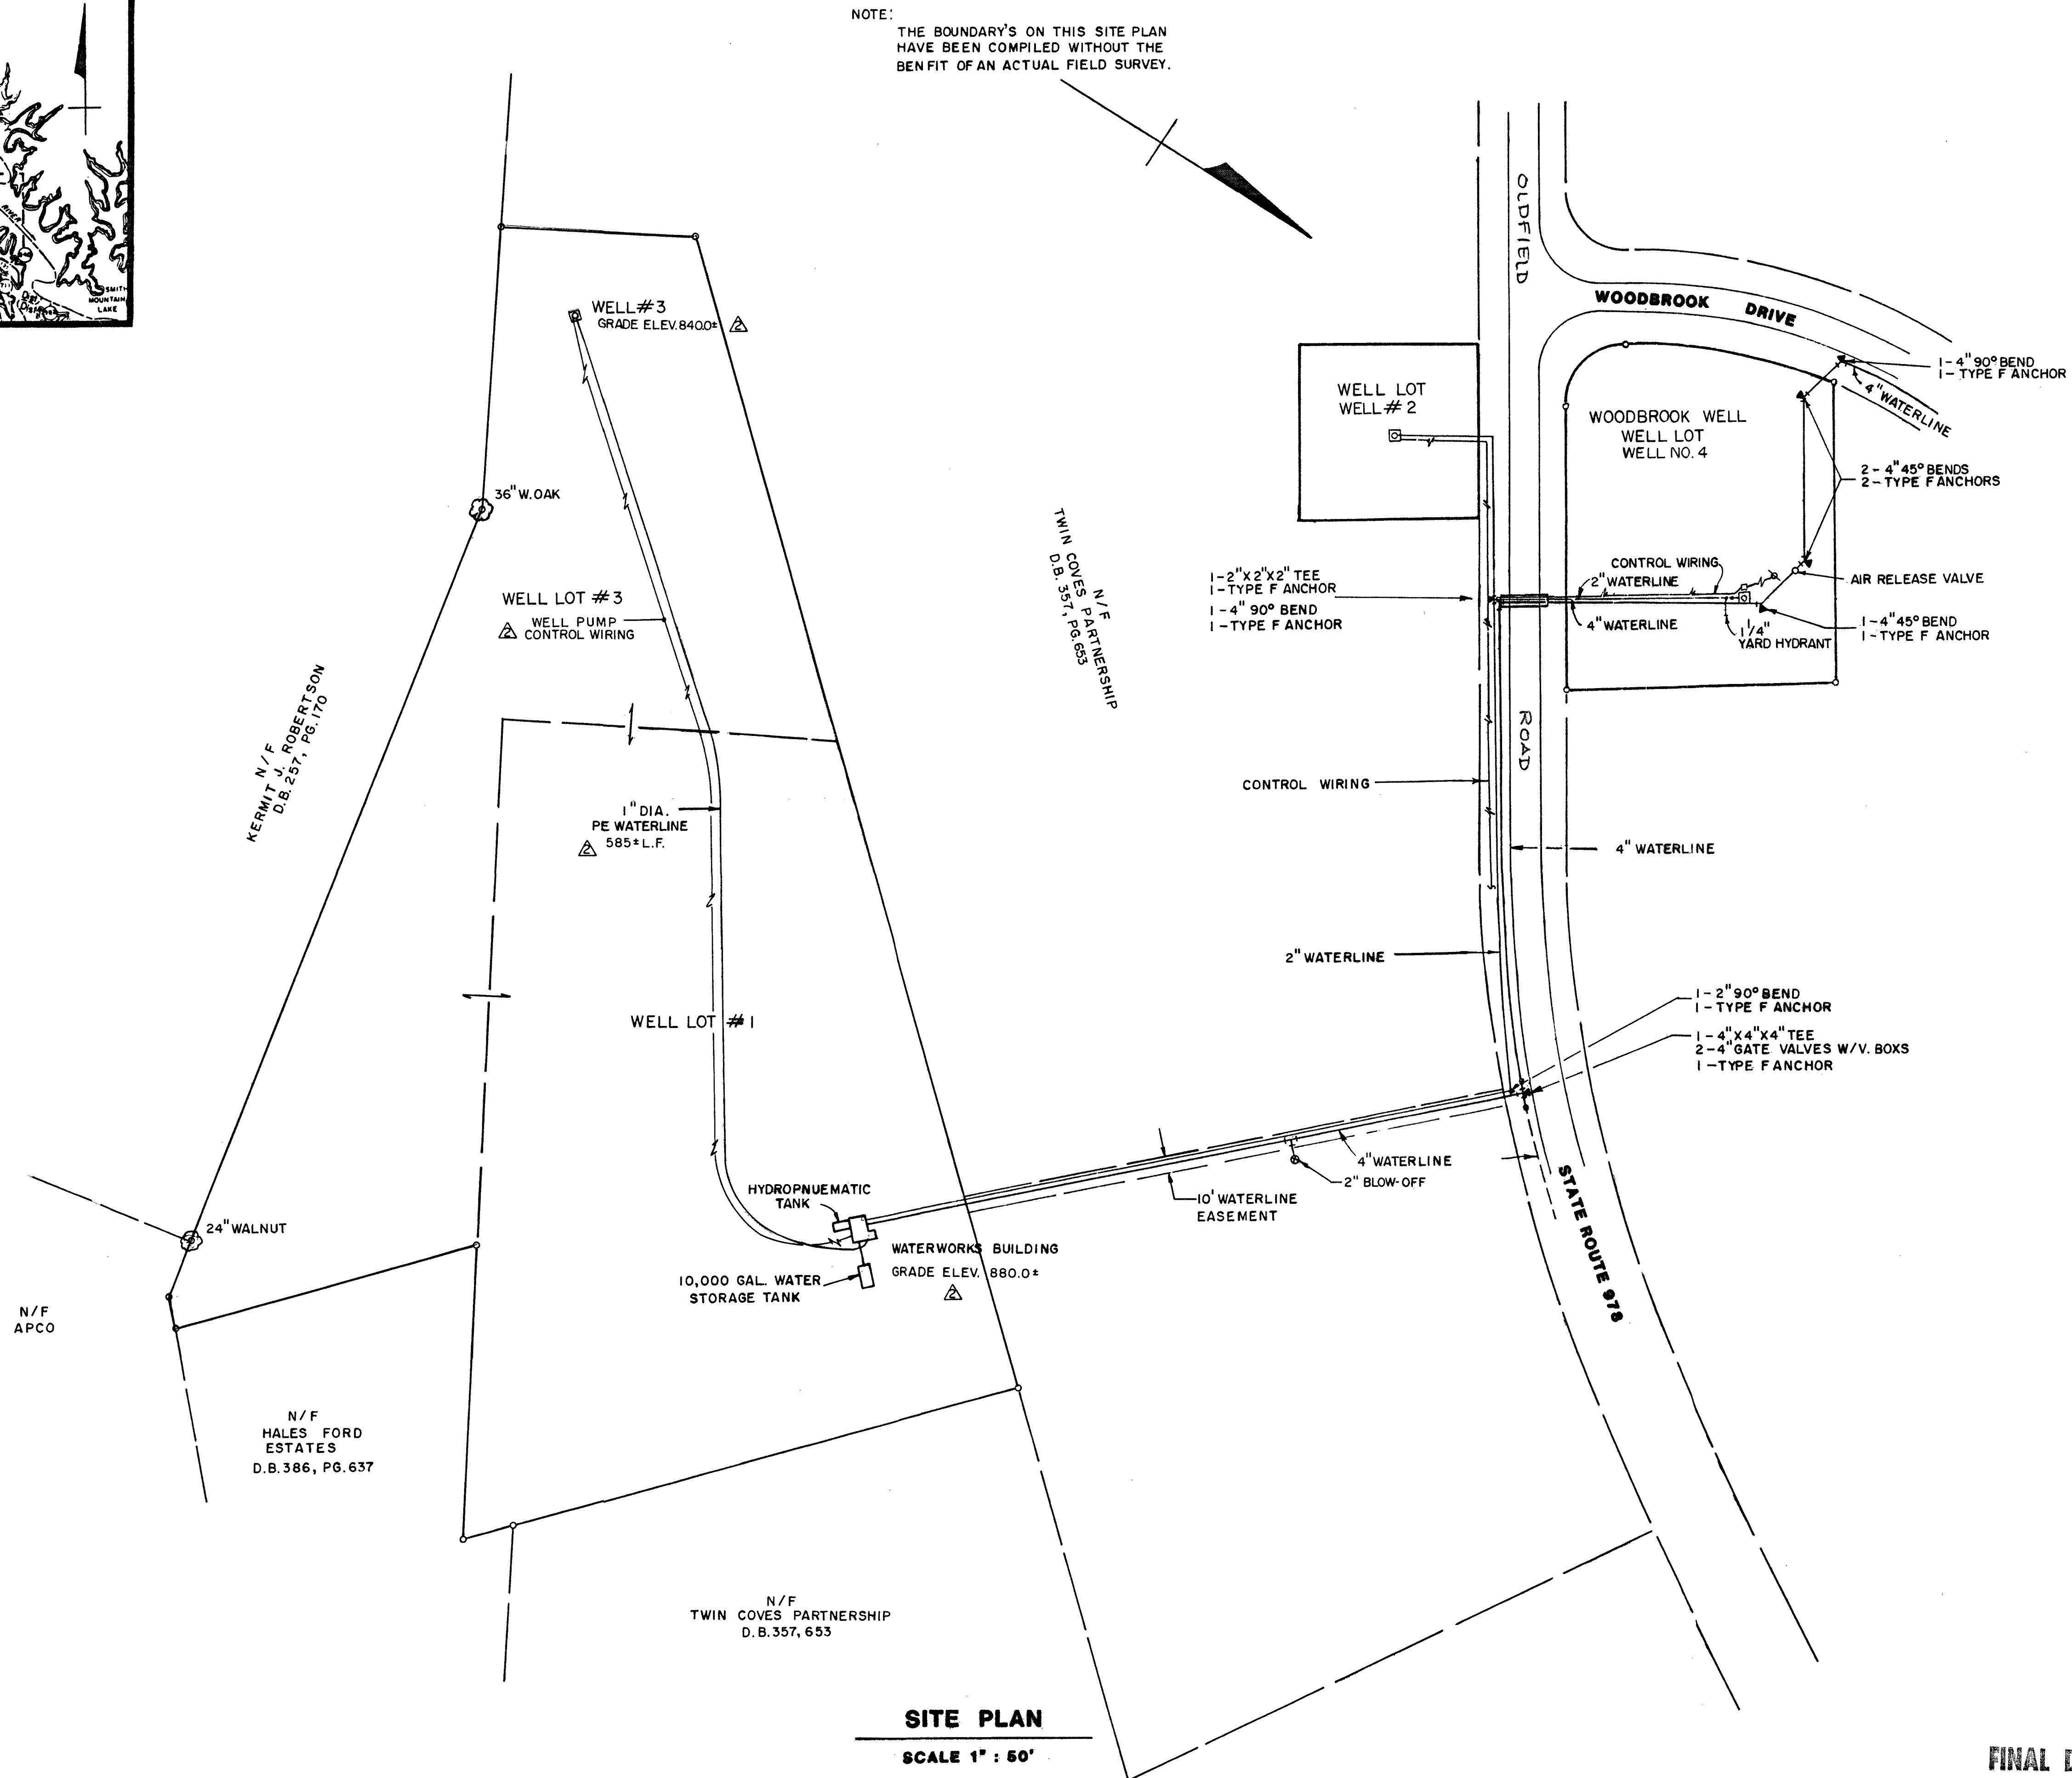

SITE PLAN

SCALE 1" = 50'

FINAL DRAFT

BERKLEY HOWELL & ASSOC., P.C. ENGINEERS • SURVEYORS • PLANNERS 1032 CLAYMONT DRIVE LYNCHBURG, VA. 24502 PH: (804) 385-7548 FAX: (804) 385-6178	
TWIN COVES WATER SYSTEM SILLS CREEK DISTRICT-FRANKLIN COUNTY, VIRGINIA	
WATERWORKS IMPROVEMENTS	
DATE: 1-05-01	
TECHNICIAN: TWM	
CHECKED BY: BCP	
REVISIONS	
NO.	DATE
1	2-21-02
SCALES AS SHOWN	
PROJ. NO. 99363	DIV.
SHEET NO. 1 OF 3	
DRAWING NO. WATER	

Twin Coves