




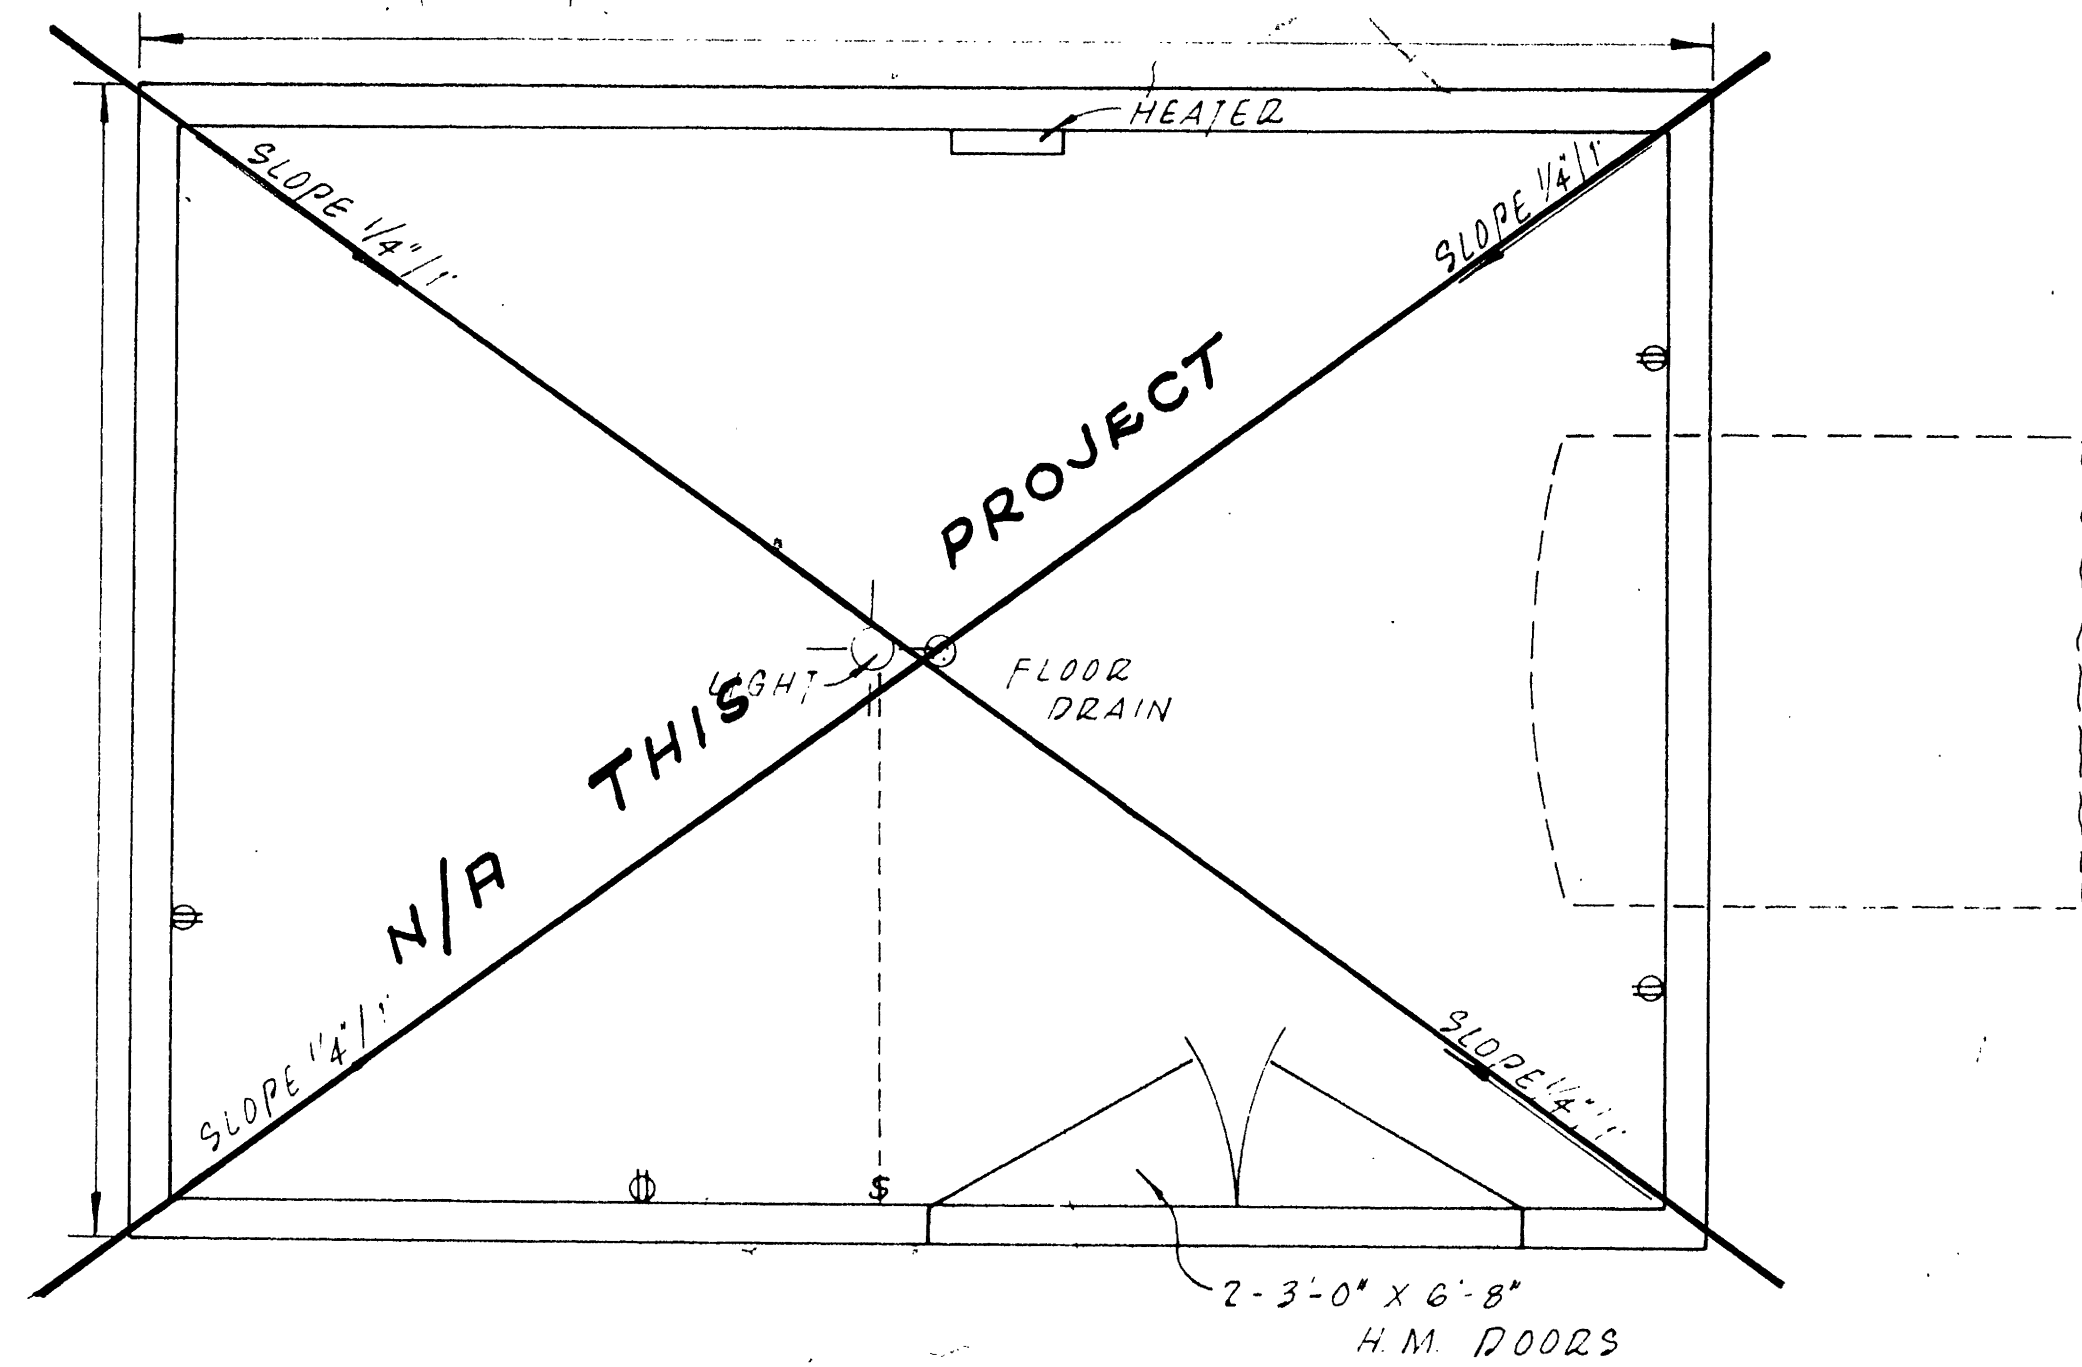



PUMP HOUSE PLAN

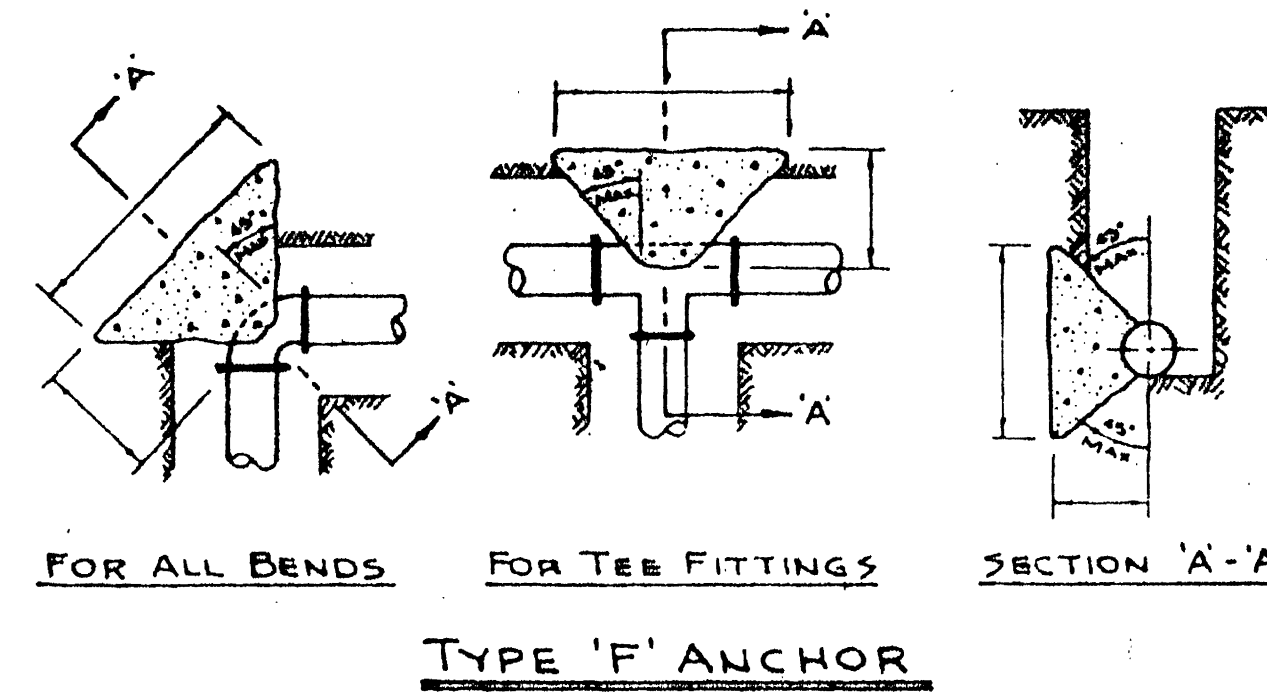


TYPE 'F' ANCHOR

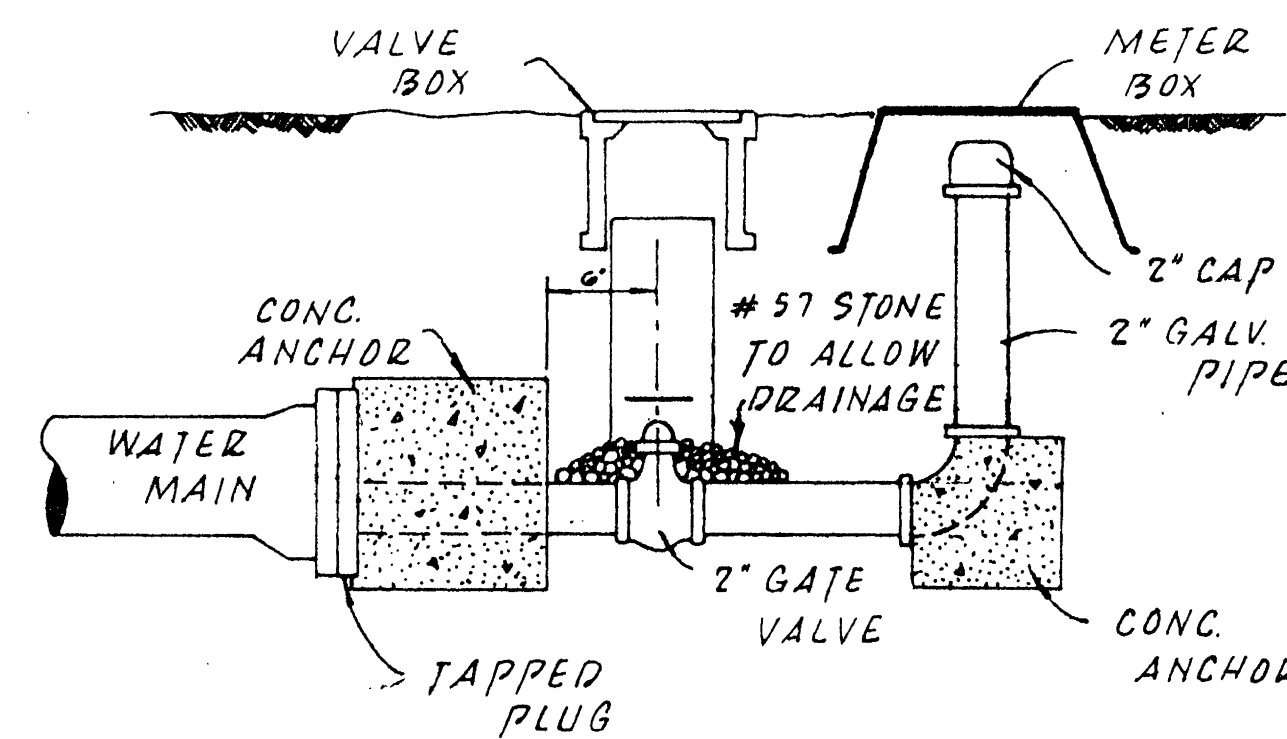


2" BLOW-OFF ASSEMBLY

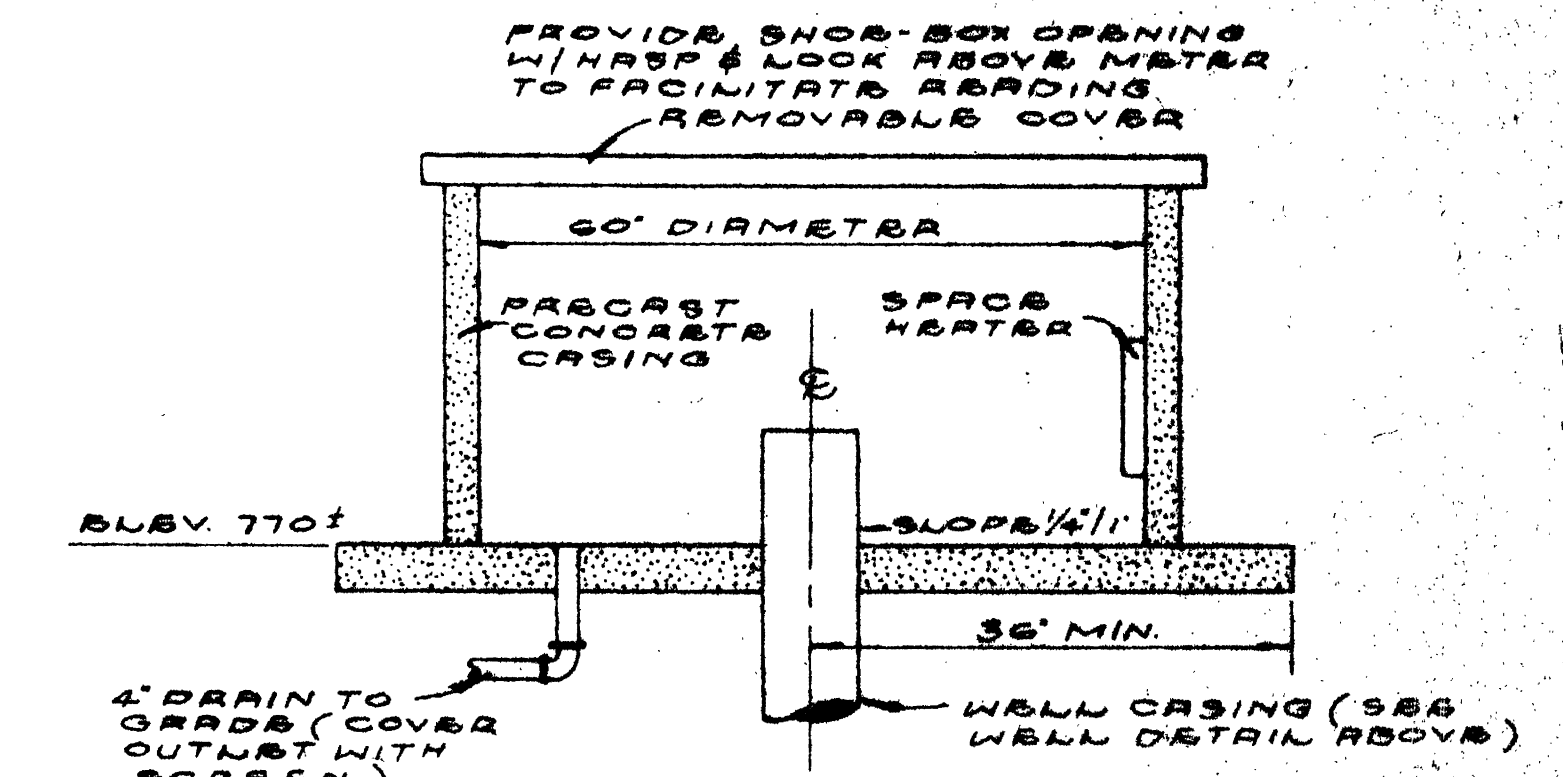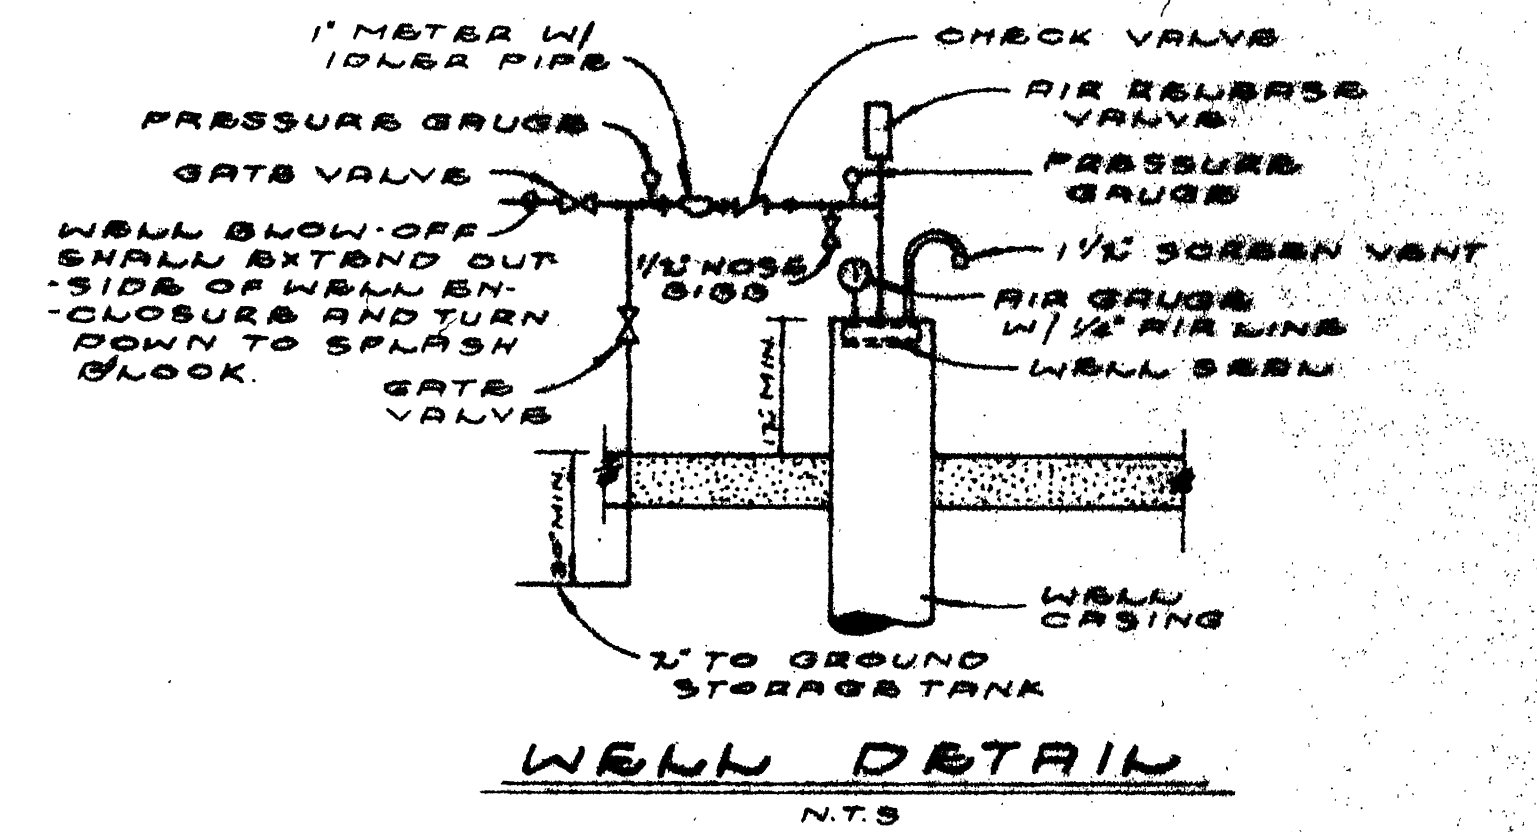


WELL HOUSING DETAIL

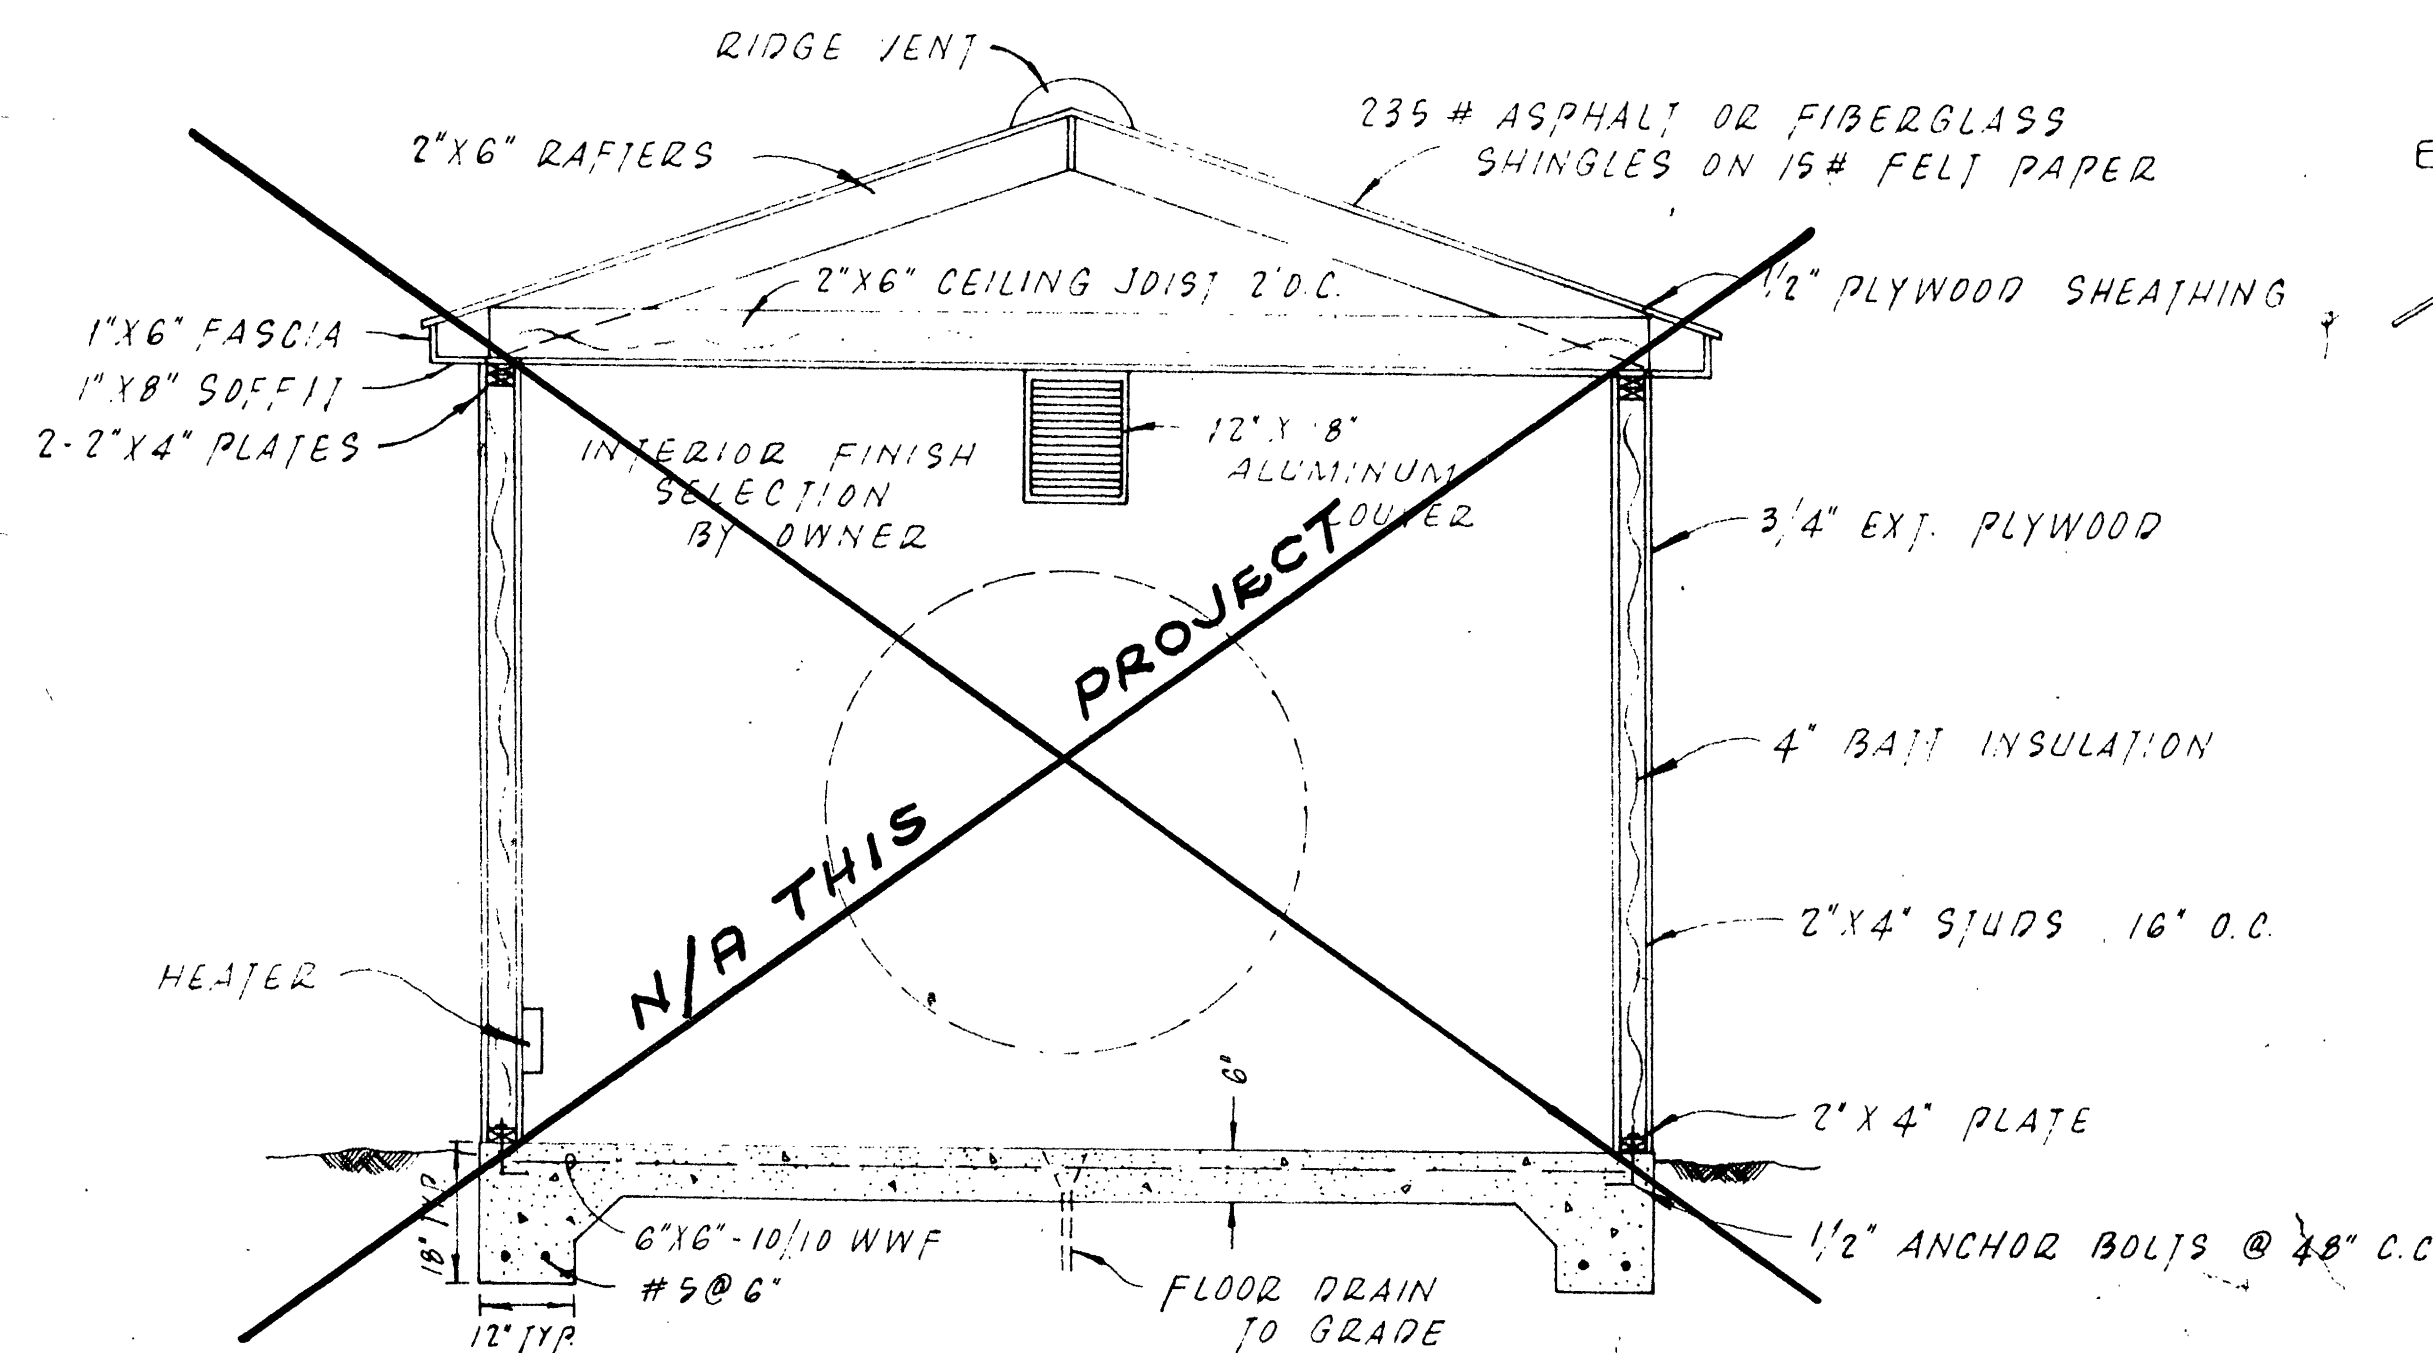

SECTION A-A

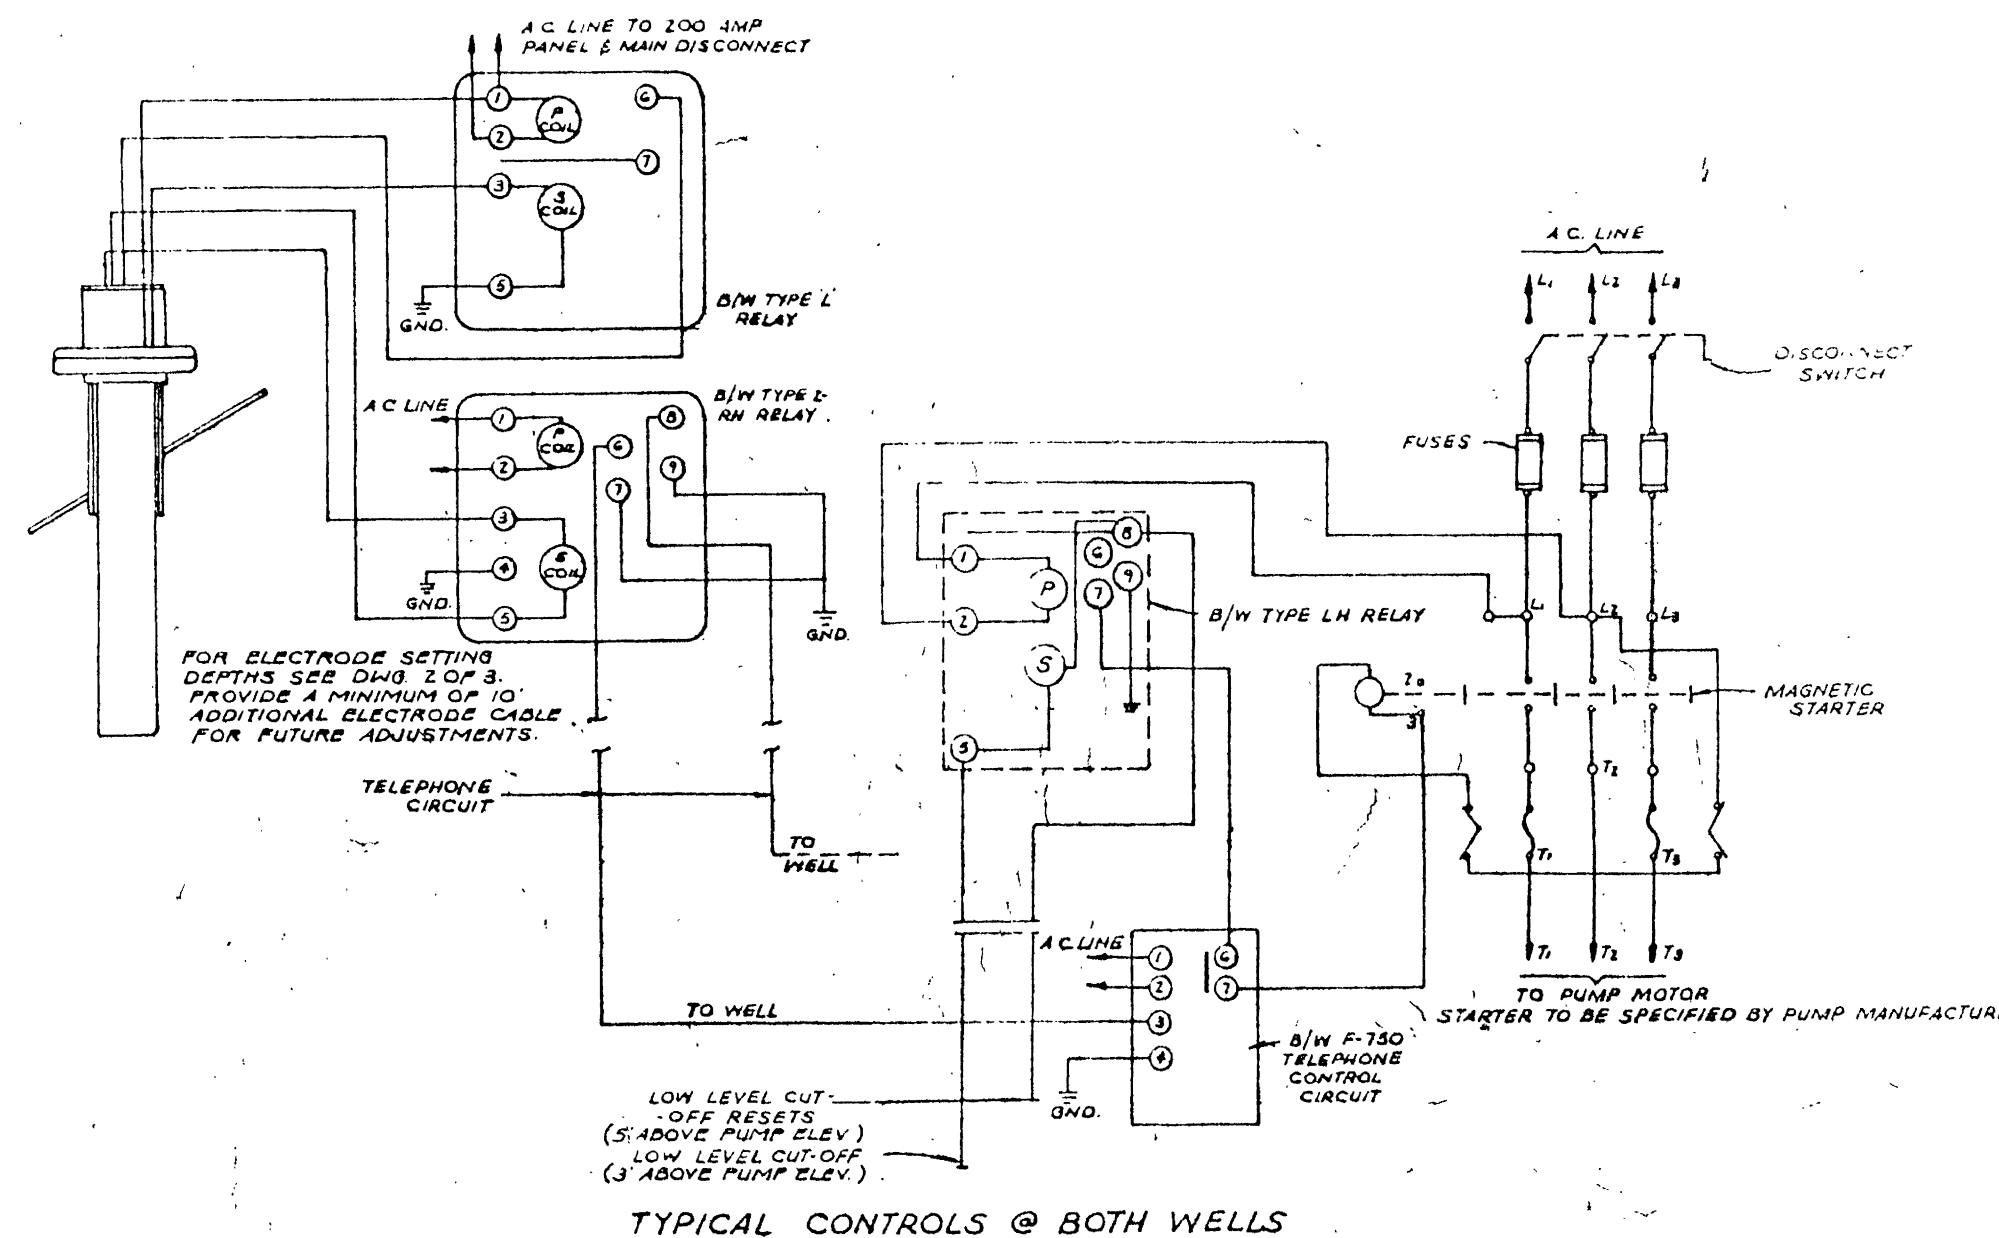


TYPICAL CONTROLS @ BOTH WELLS

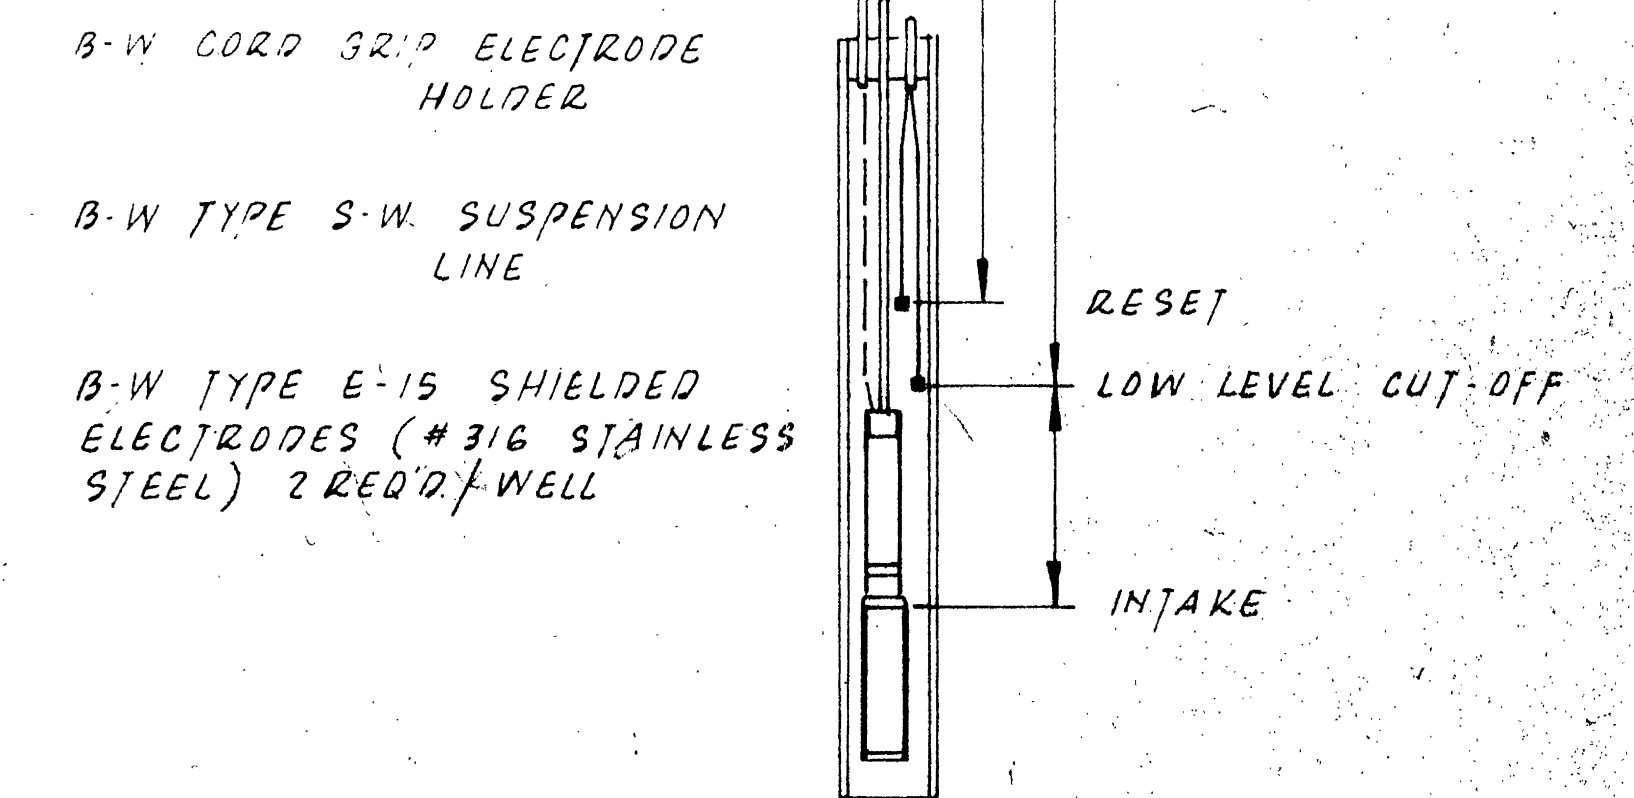

PUMP CONTROLS SCHEMATIC

WELL HEAD SPECIFICATIONS

| ITEM              | DESCRIPTION                                  |
|-------------------|----------------------------------------------|
| PUMP              | WELL #2 GOULDS MODEL 25EL 50412 - 5HP-16230V |
| REDUCER           | WELL #1 GOULDS MODEL 18B50412 5HP-16230V     |
| TEES              | 1 1/2\"                                      |
| CHECK VALVES      | 2\"                                          |
| GATE VALVES       | 2\"                                          |
| METER             | 2\"                                          |
| DISCHARGE PIPING  | 2\"                                          |
| SPACE HEATER      | 230V 500W SINGER                             |
| AIR RELEASE VALVE | HOFFMAN MODEL 79 OR EQUAL                    |

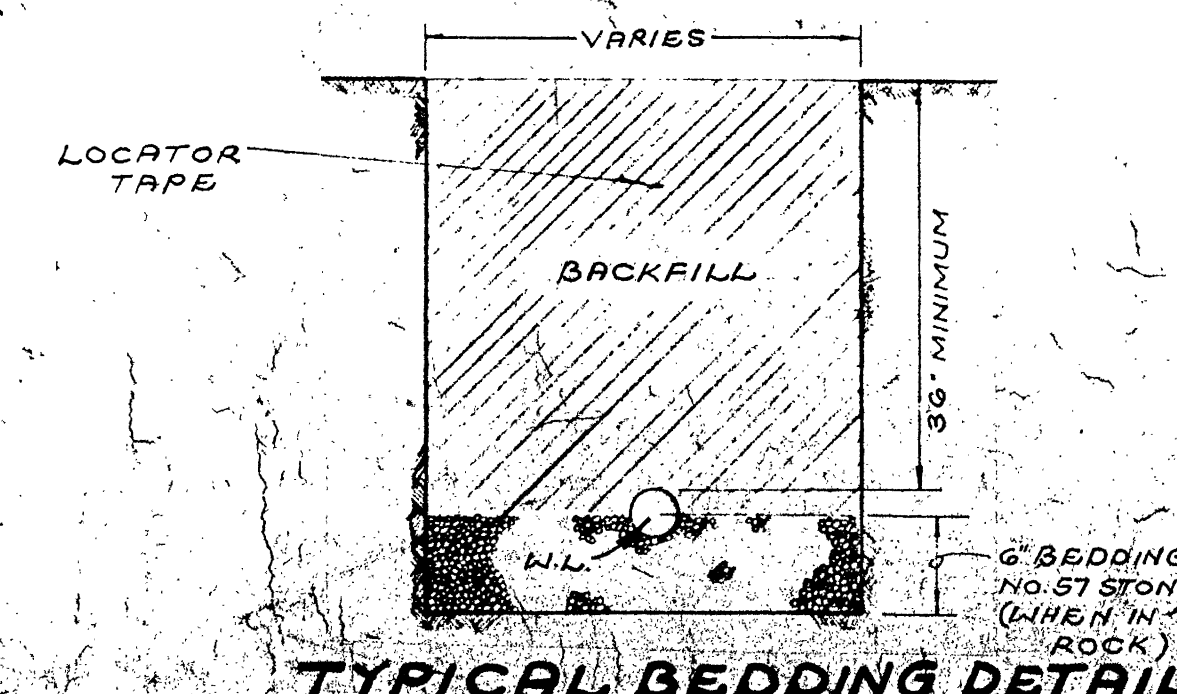

TYPICAL BEDDING DETAIL

|                                                            |              |                  |  |
|------------------------------------------------------------|--------------|------------------|--|
| Barkley Howell & Assoc.<br>ENGINEERS, SURVEYORS & PLANNERS |              |                  |  |
| SCALE:                                                     | APPROVED BY: | DRAWN BY:        |  |
| DATE: 10-1-87                                              |              | REVISED: 12-1-87 |  |
| WALNUT RUN CENTRAL WATER SYSTEM                            |              |                  |  |
| MISC. DETAILS                                              |              |                  |  |
| DRAWING NUMBER: 8 OF 9                                     |              |                  |  |