


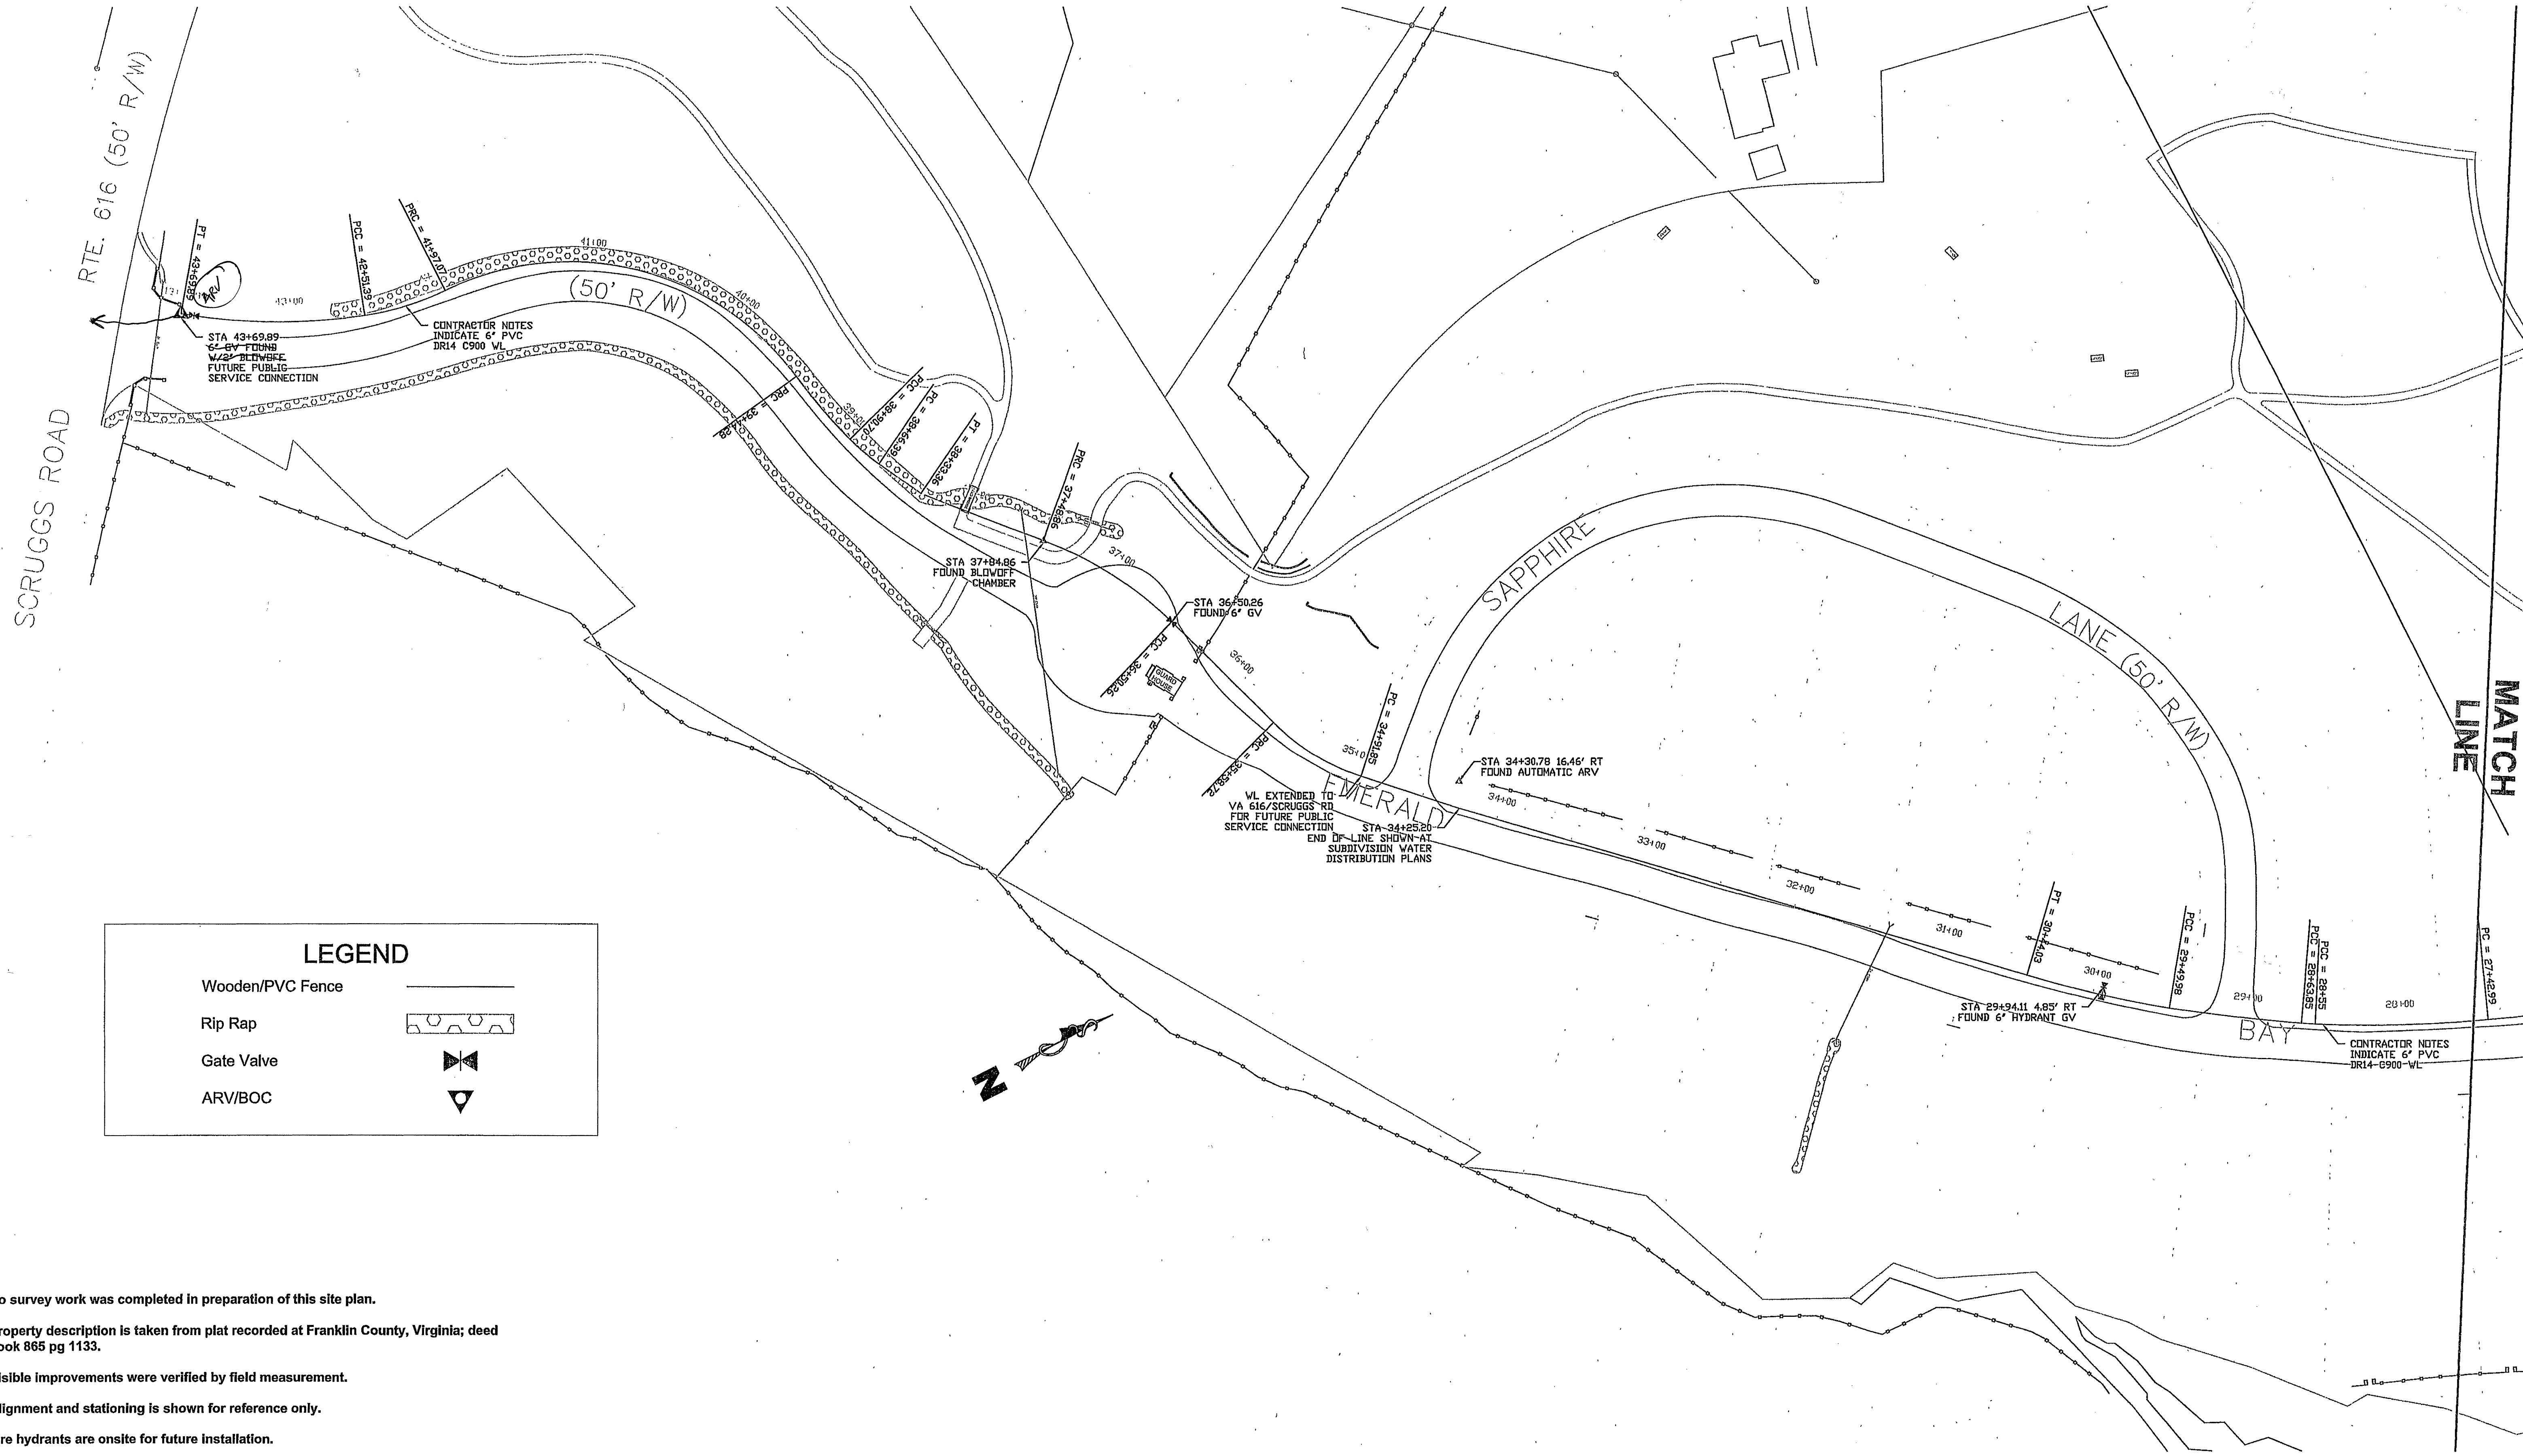

NOTES

- No survey work was completed in preparation of this site plan.
- Property description is taken from plat recorded at Franklin County, Virginia; deed book 865 pg 1133.
- Visible improvements were verified by field measurement.
- Alignment and stationing is shown for reference only.
- Fire hydrants are onsite for future installation.




Call Miss Utility Before You Dig
Dial 811 in VA, or 1-800-552-7001

(PROJECT RELATED INFORMATION)	(REVISIONS)
MASTER WORK ORDER NUMBER:	
PROJECT NUMBER: 2006-EBV	
DEED BOOK / PAGE: 865, p1133	
SHEET NO: 1 OF 1	
NETWORK LOCATION & DRAWING TITLE:	
P:\BAYVIEW ESTIMATING\EBV\EBV-AB\dwg\EBVAB.dwg	

**EMERALD BAY VILLAGE
AS-BUILT SITE PLAN**

**WATER DISTRIBUTION
SYSTEM**

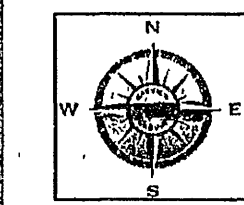

Bayview Construction Company
70 Homeplace Circle
Smith Mountain Lake
Moneta, VA 24121
(540) 537-6056 Fax (540) 721-5614
www.bayviewconstructioncompany.com

DESIGN BY:	AS BUILT	DATE:
DRAWN BY:	PKS	DATE: JUNE 10, 2008
APPROVED BY:		DATE:
SURVEYED BY:		SCALE: 1" = 50' HORIZ.

SHEET

U1