



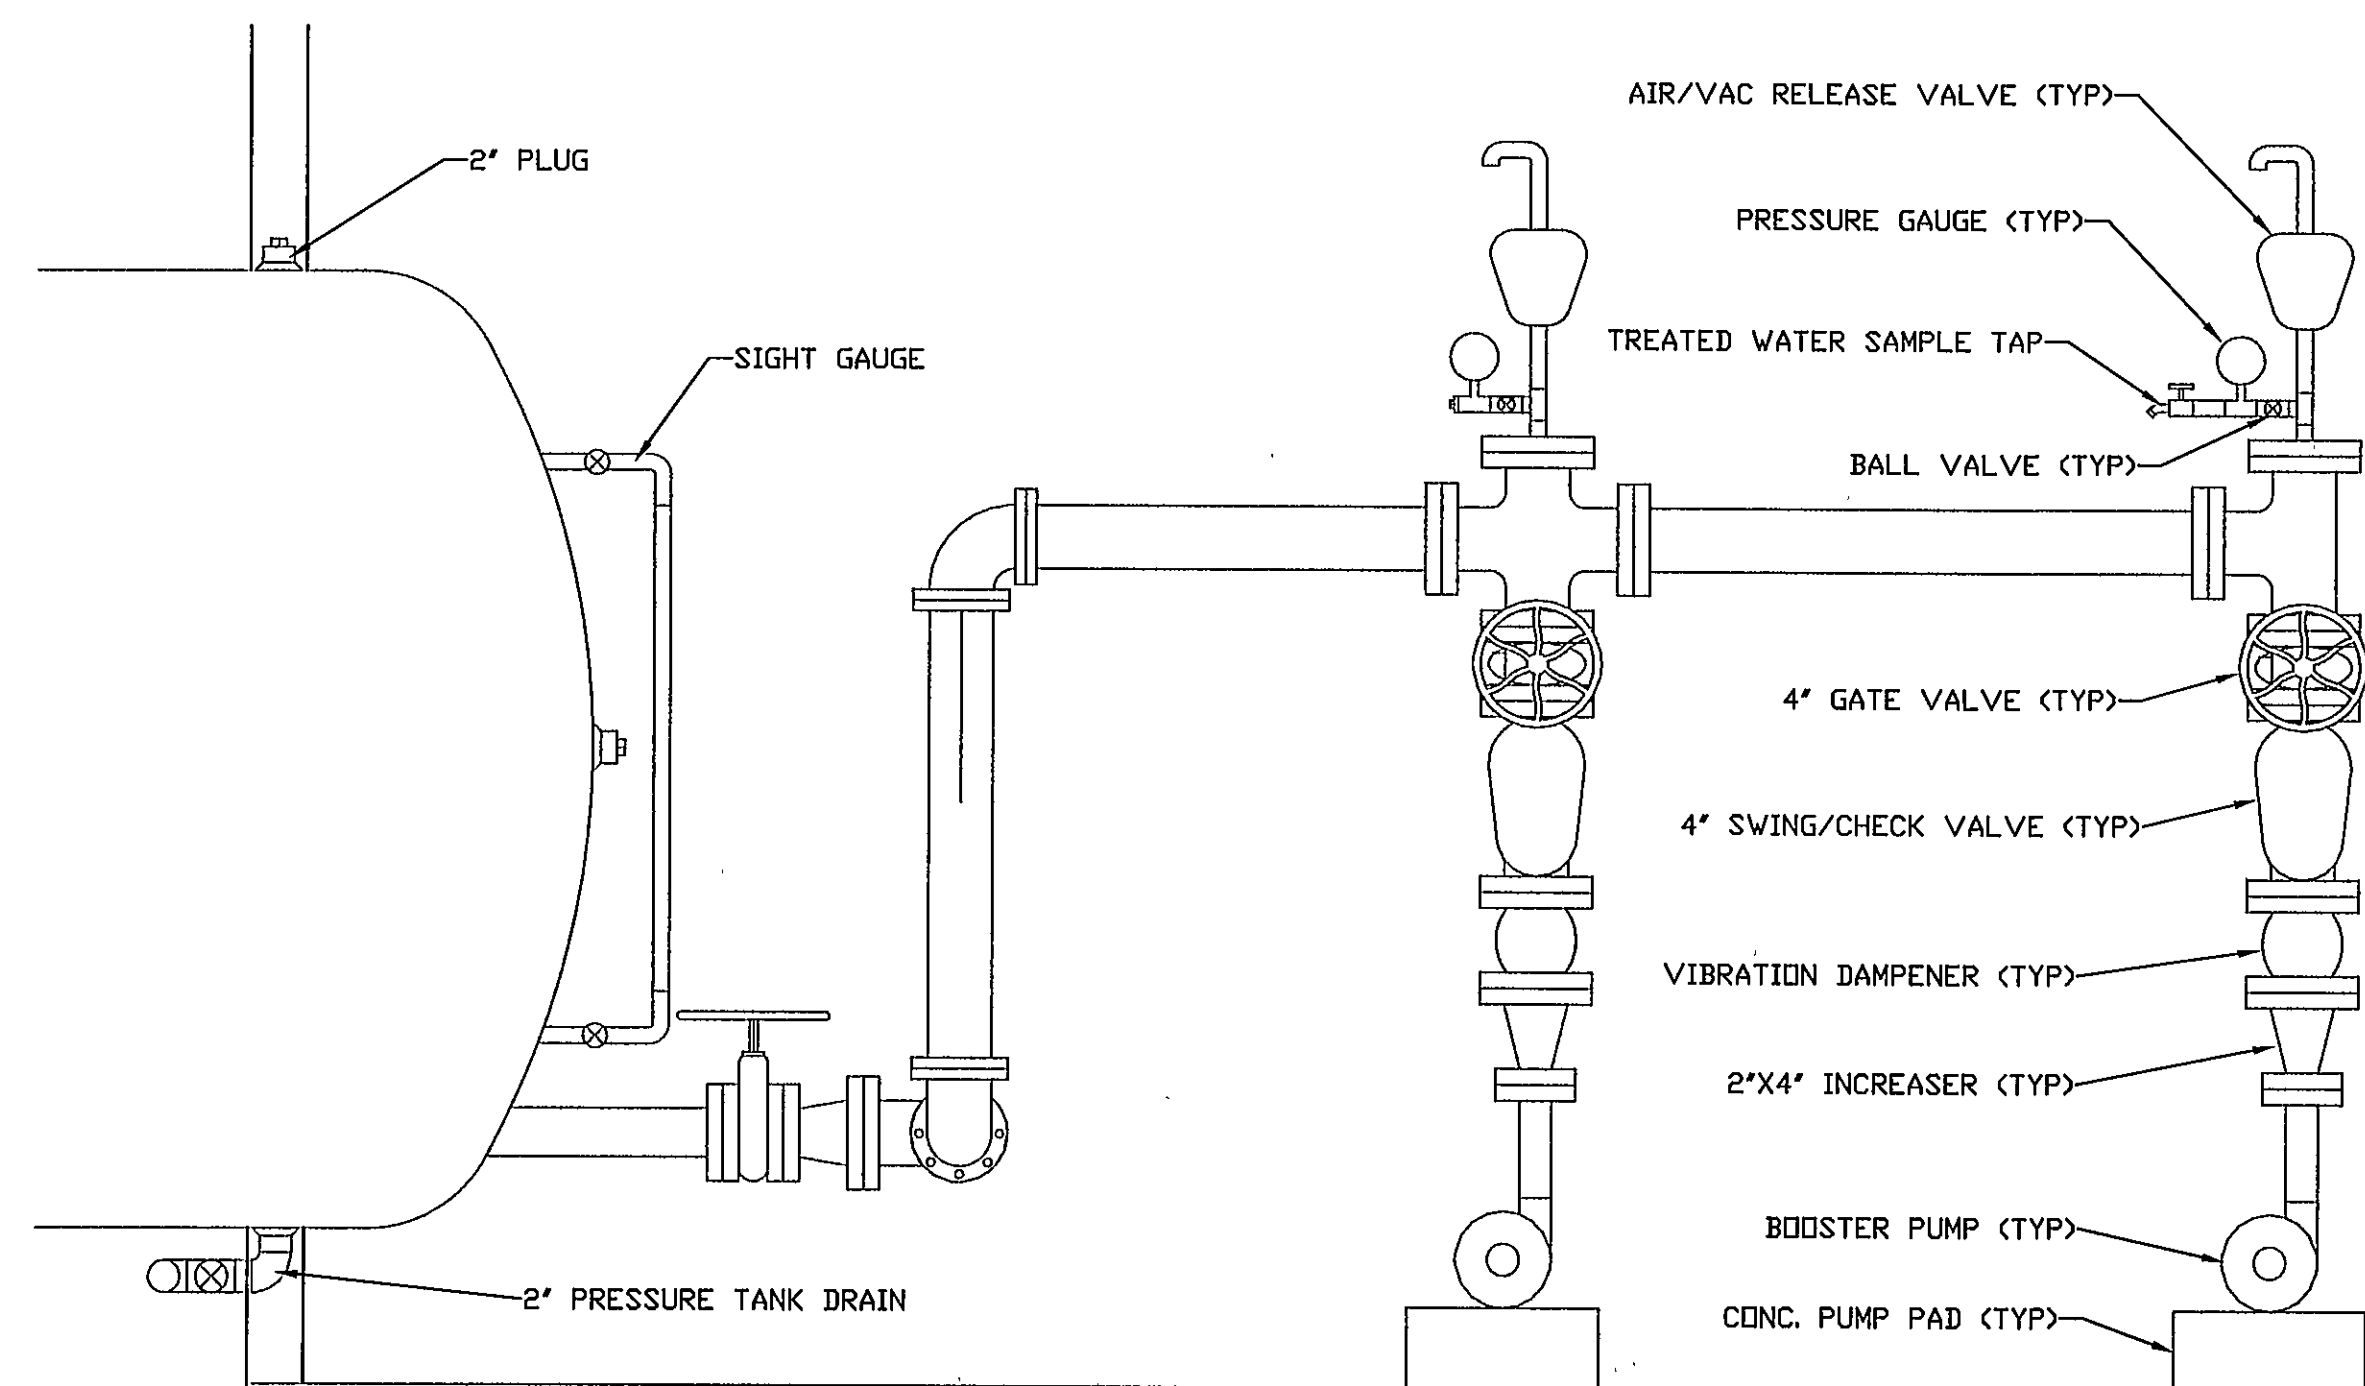


(A) ELEVATION
1" = 1'-0"

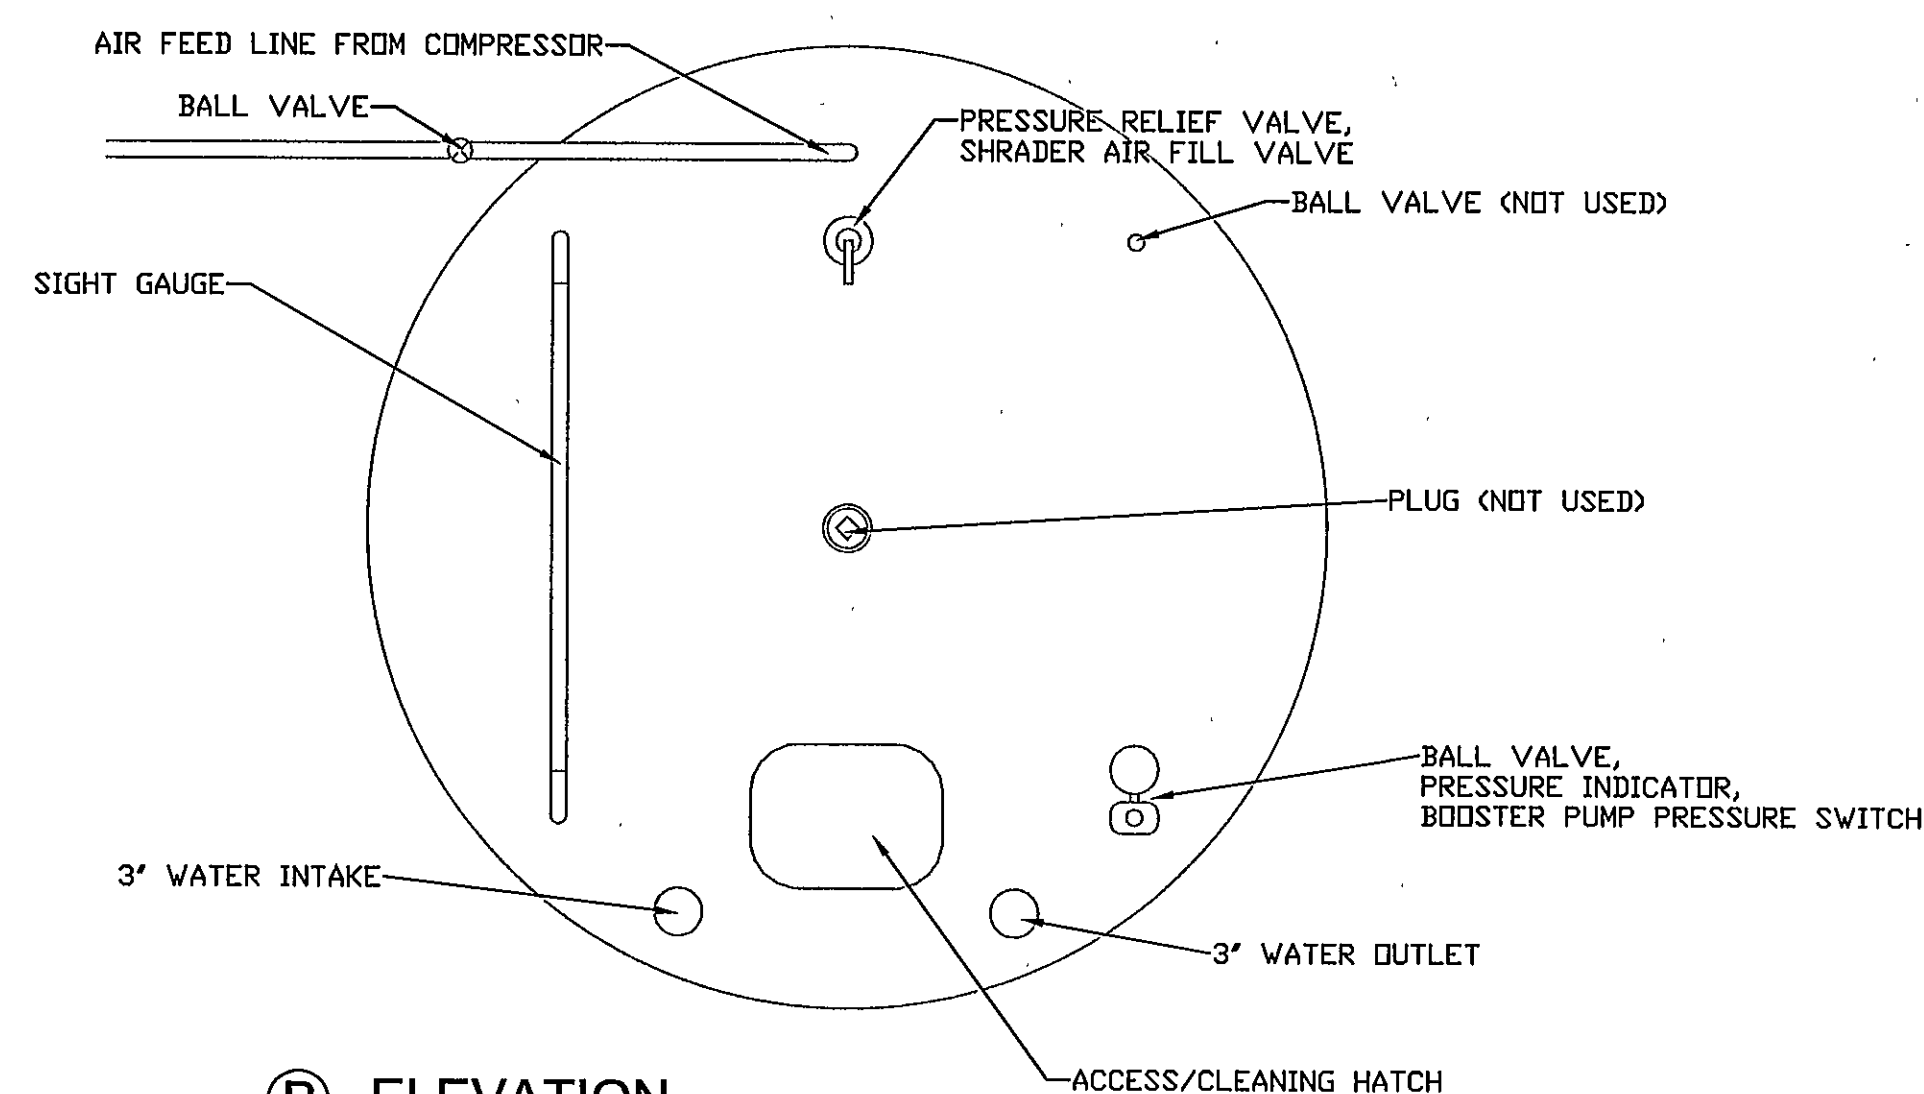

(B) ELEVATION
1" = 1'-0"

NOTES

1. No survey work was completed in preparation of this site plan.
2. Property description is taken from plat recorded at Franklin County, Virginia; deed book 865 pg 1133.
3. Visible improvements were verified by field measurement.
4. Alignment and stationing is shown for reference only.
5. Fire hydrants are onsite for future installation.

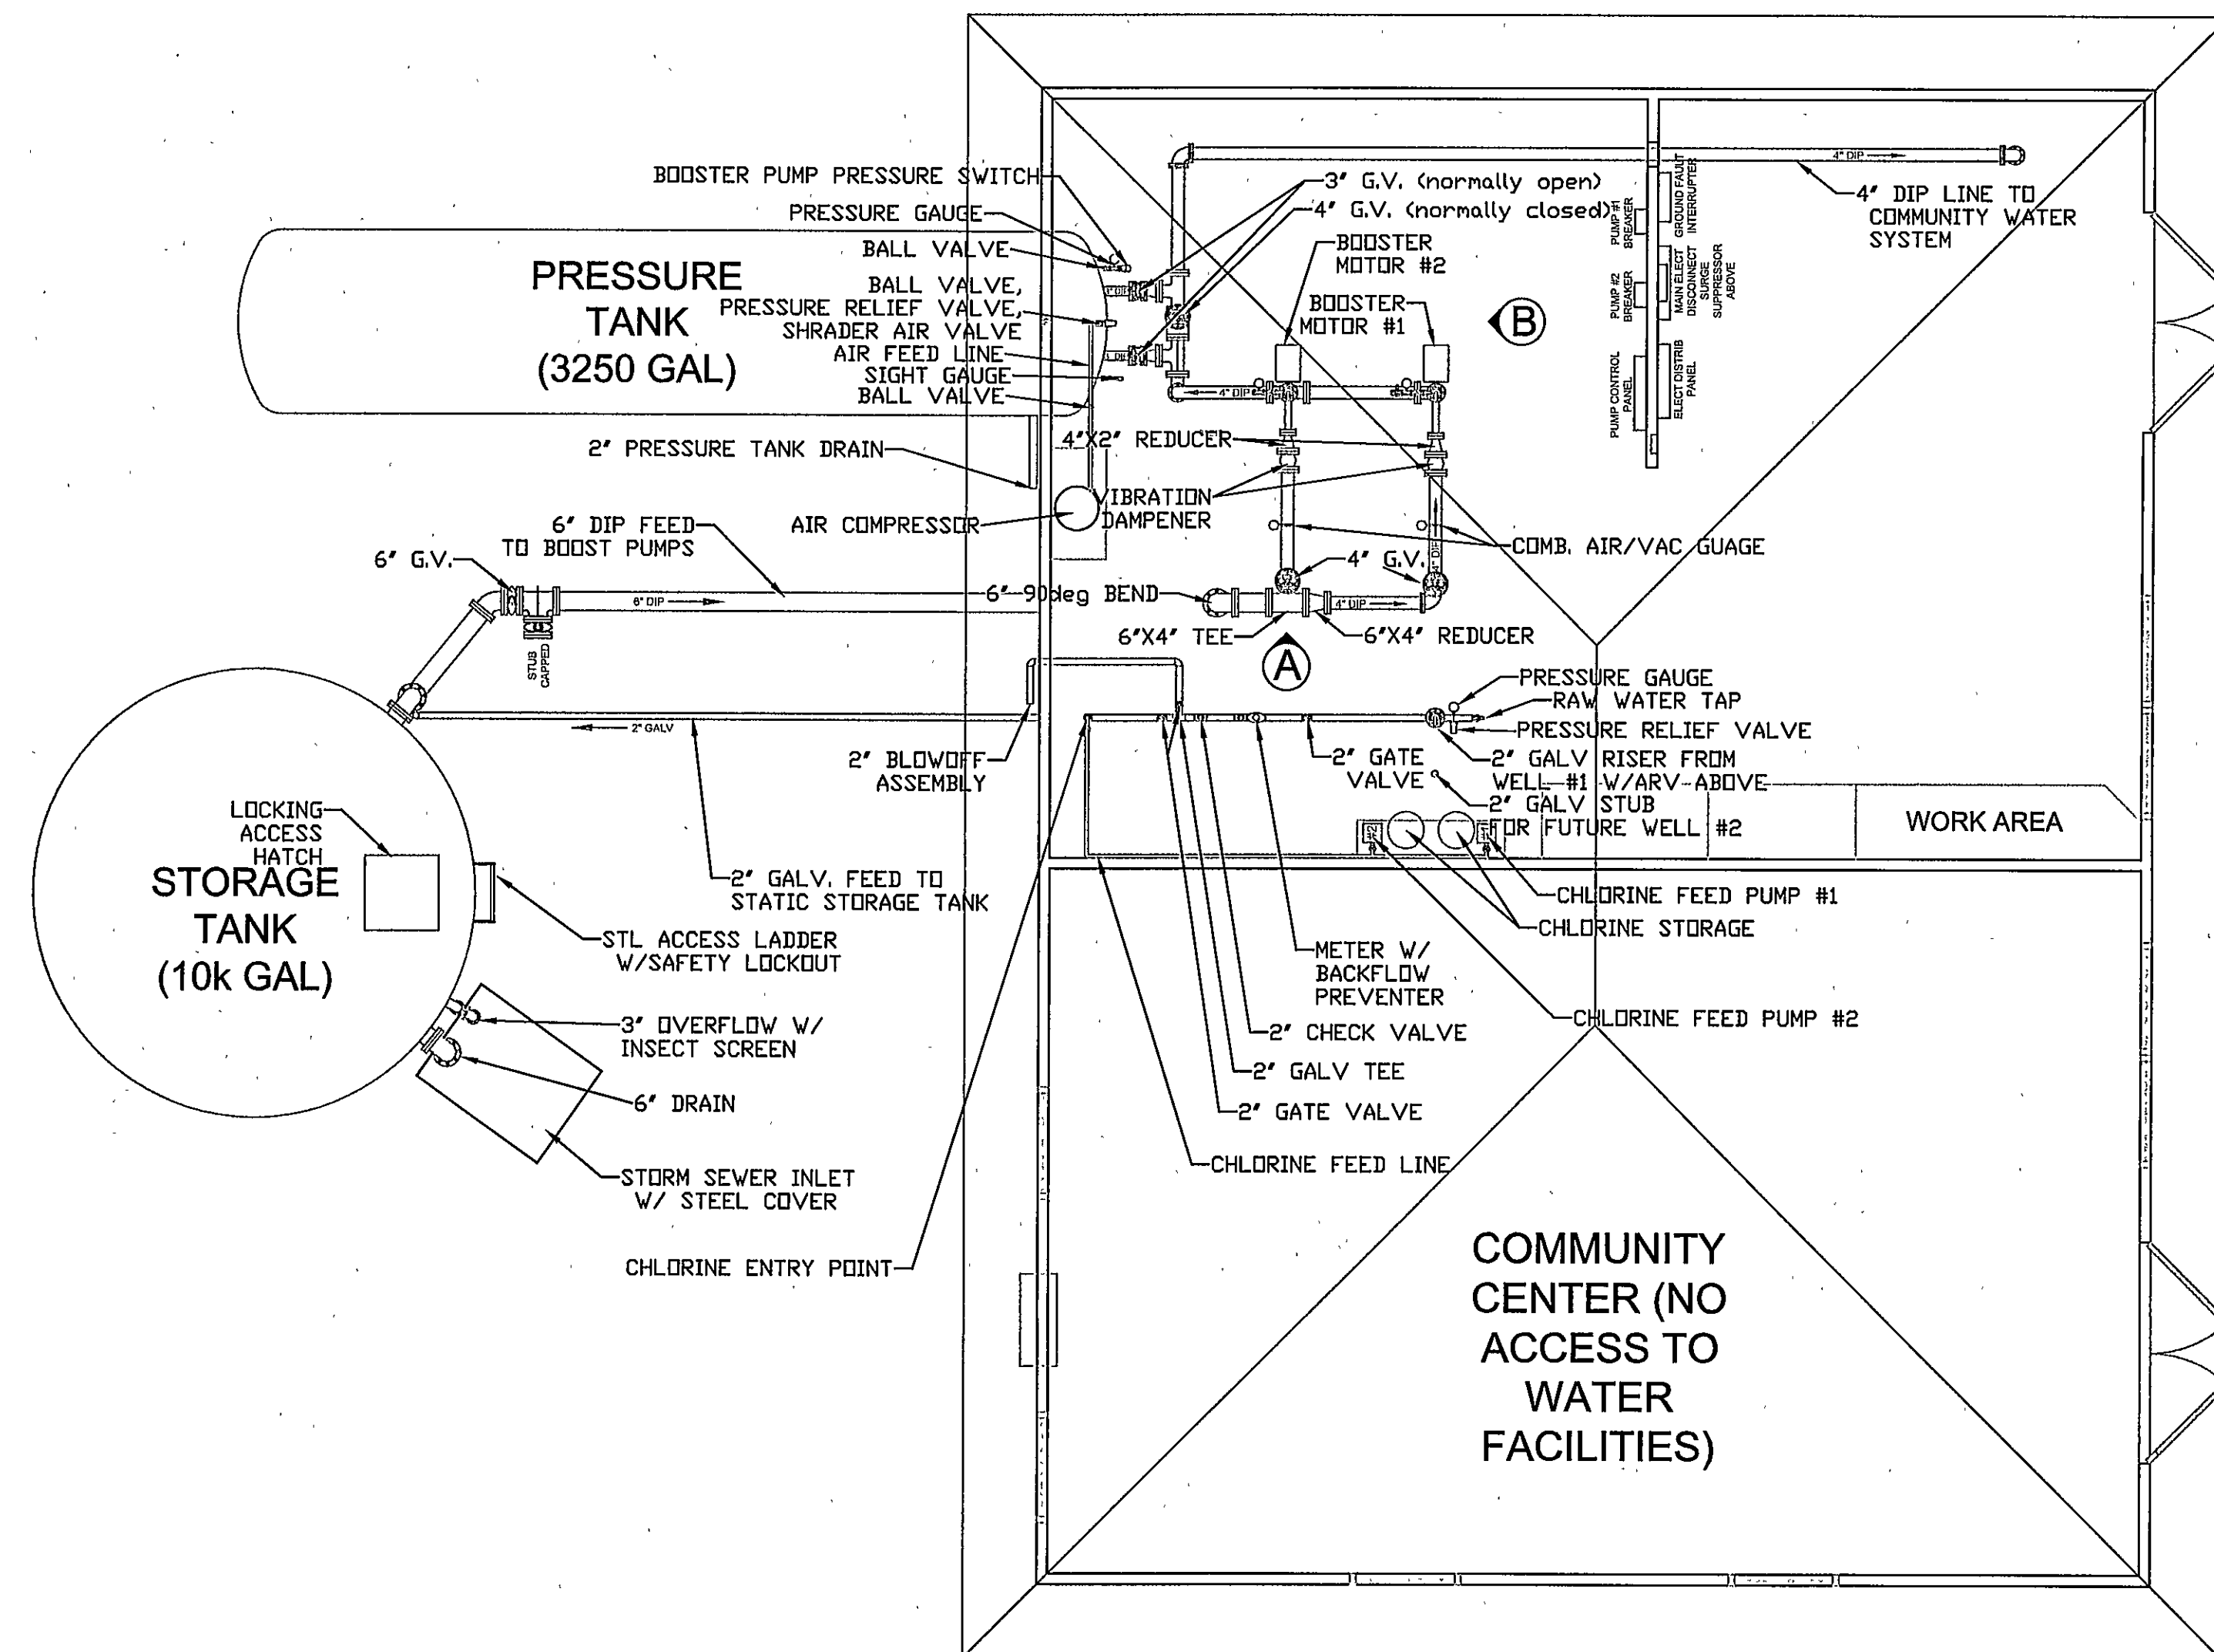


Call Miss Utility Before You Dig
Dial 811 in VA, or 1-800-552-7001

(PROJECT RELATED INFORMATION)
MASTER WORK ORDER NUMBER:
PROJECT NUMBER: 2006-EBV
DEED BOOK / PAGE: 865, p1133
SHEET NO: 1 OF 1
NETWORK LOCATION & DRAWING TITLE:
P:\BAYVIEW ESTIMATING\EBV\EBV-AB\dwg\EBVAB.dwg

(REVISIONS)

EMERALD BAY VILLAGE AS-BUILT SITE PLAN

WATER DISTRIBUTION SYSTEM - WELLHOUSE

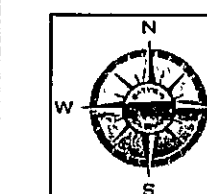

Bayview Construction Company
70 Homeplace Circle
Smith Mountain Lake
Moneta, VA 24121
(540) 337-6056 Fax (540) 721-5614
www.bayviewconstructioncompany.com

DESIGN BY:	AS BUILT	DATE:
DRAWN BY:	PKS	DATE: JUNE 10, 2008
APPROVED BY:	DATE:	
SURVEYED BY:	SCALE: 1/4" = 1'-0"	

SHEET
U3