



P:\FC - WATER LINE\09-0029\EEC.DWG\SHEETS\09-0029_C2-PP.DWG

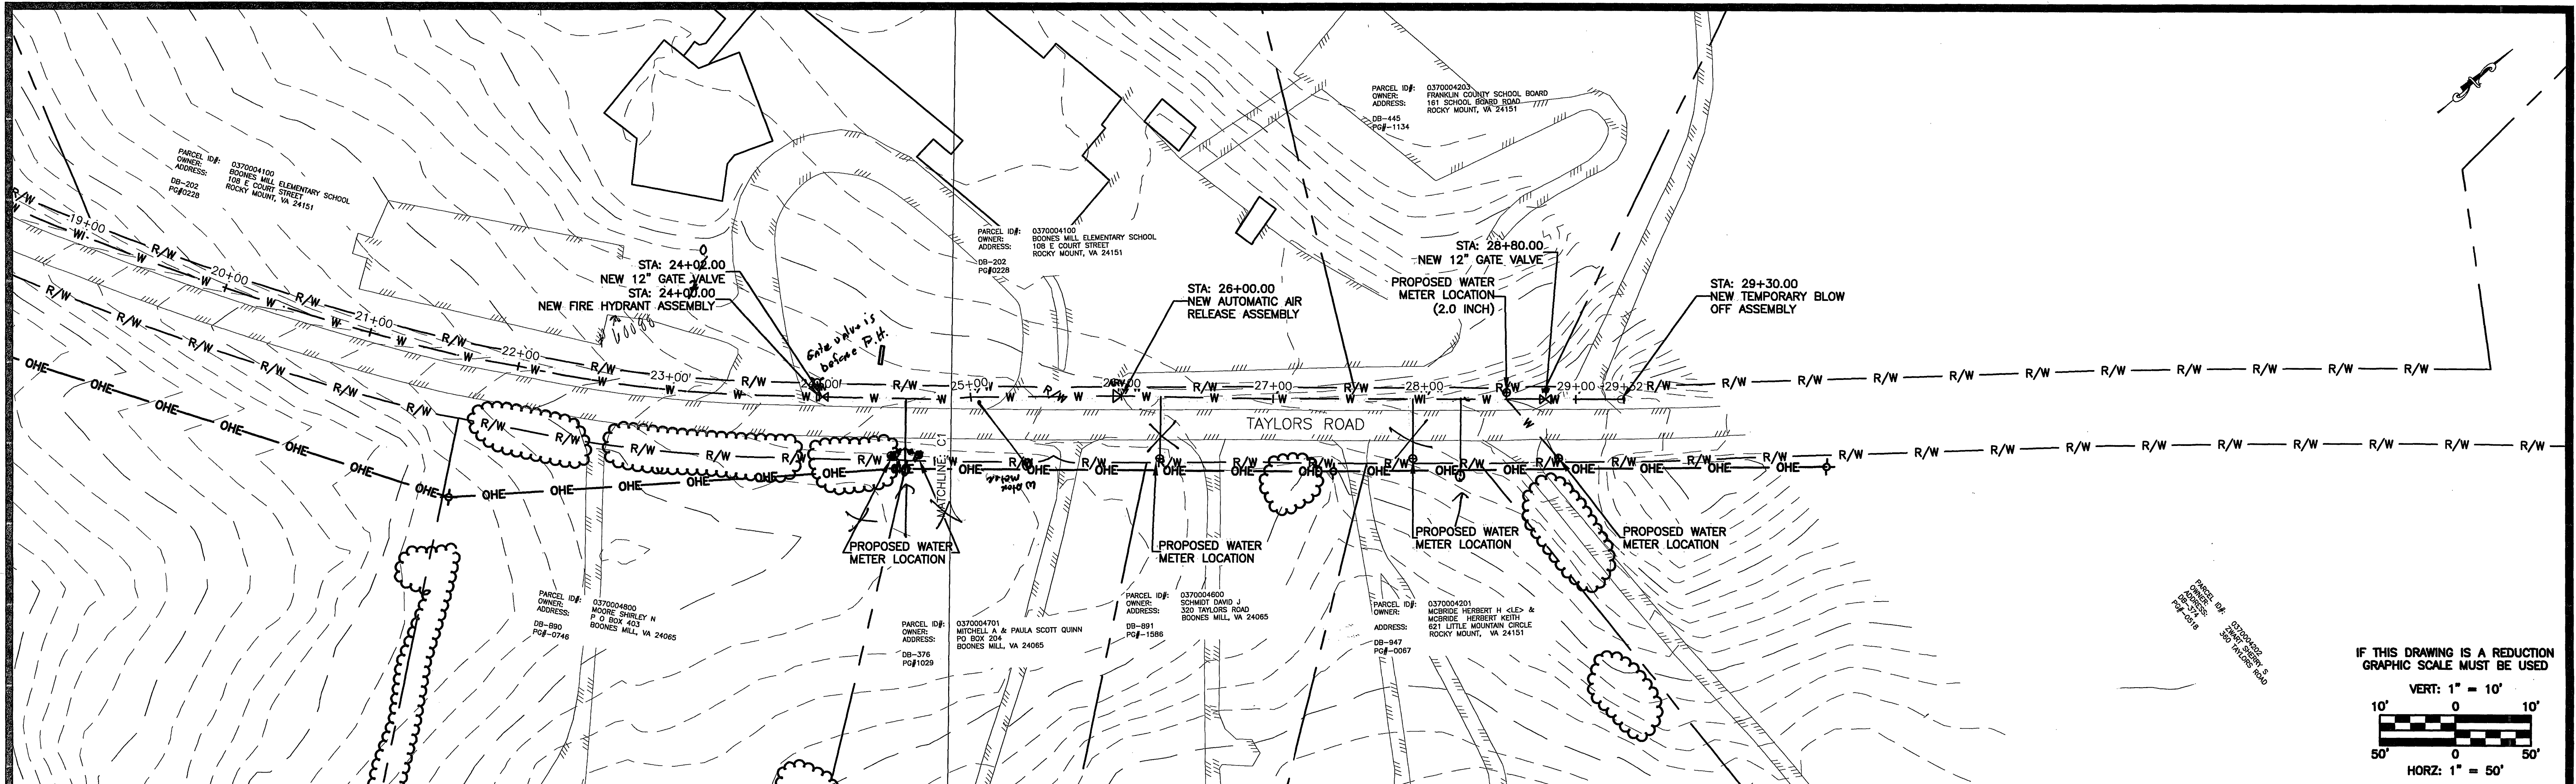

IF THIS DRAWING IS A REDUCTION
GRAPHIC SCALE MUST BE USED

VERT: 1" = 10'
10' 0 10'
50' 0 50'

HORZ: 1" = 50'

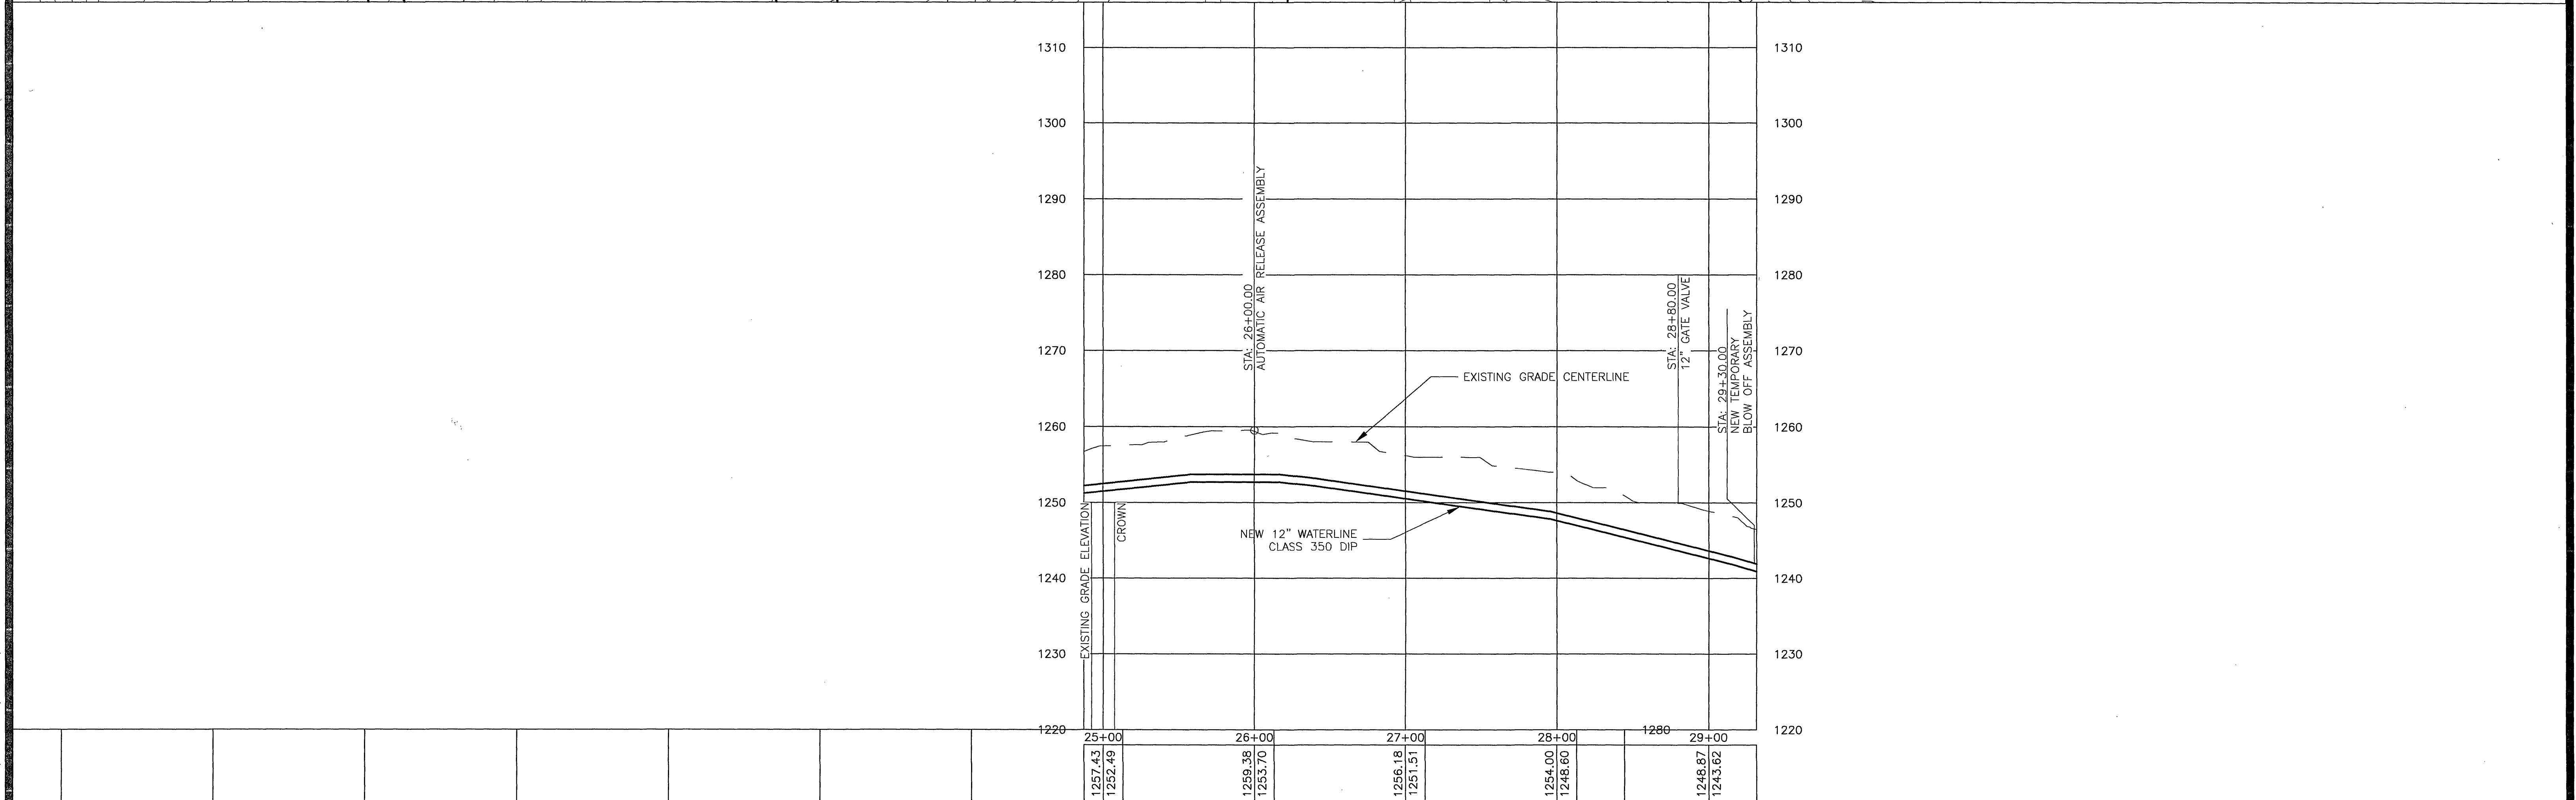

NO:		REVISIONS:		DATE:			ADDRESS: 235 CLAIBORNE AVE. ROCKY MOUNT, VA 24151					DESIGN BY: BKS	PROJECT: FRANKLIN COUNTY BOONES MILL WATERLINE EXTENSION BOONES MILL, VIRGINIA		DATE: 3/22/10			
							PHONE NUMBERS: PHONE: (540) 483-5975 FAX: (540) 483-2221					DRAWN BY: BKS	TITLE: PLAN AND PROFILE STA - 24+87.12 TO 29+31.62		DRAWING NUMBER: C2			
							WEBSITE WWW.EARTHENV.COM					REVIEWED BY: JNL	PROJECT NUMBER: 09-0029		DRAWING NAME: 09-0029_C2-PP.DWG		SHEET NUMBER: 3 of 5	
														SCALE: H: 1" = 50' V: 1" = 10'				