



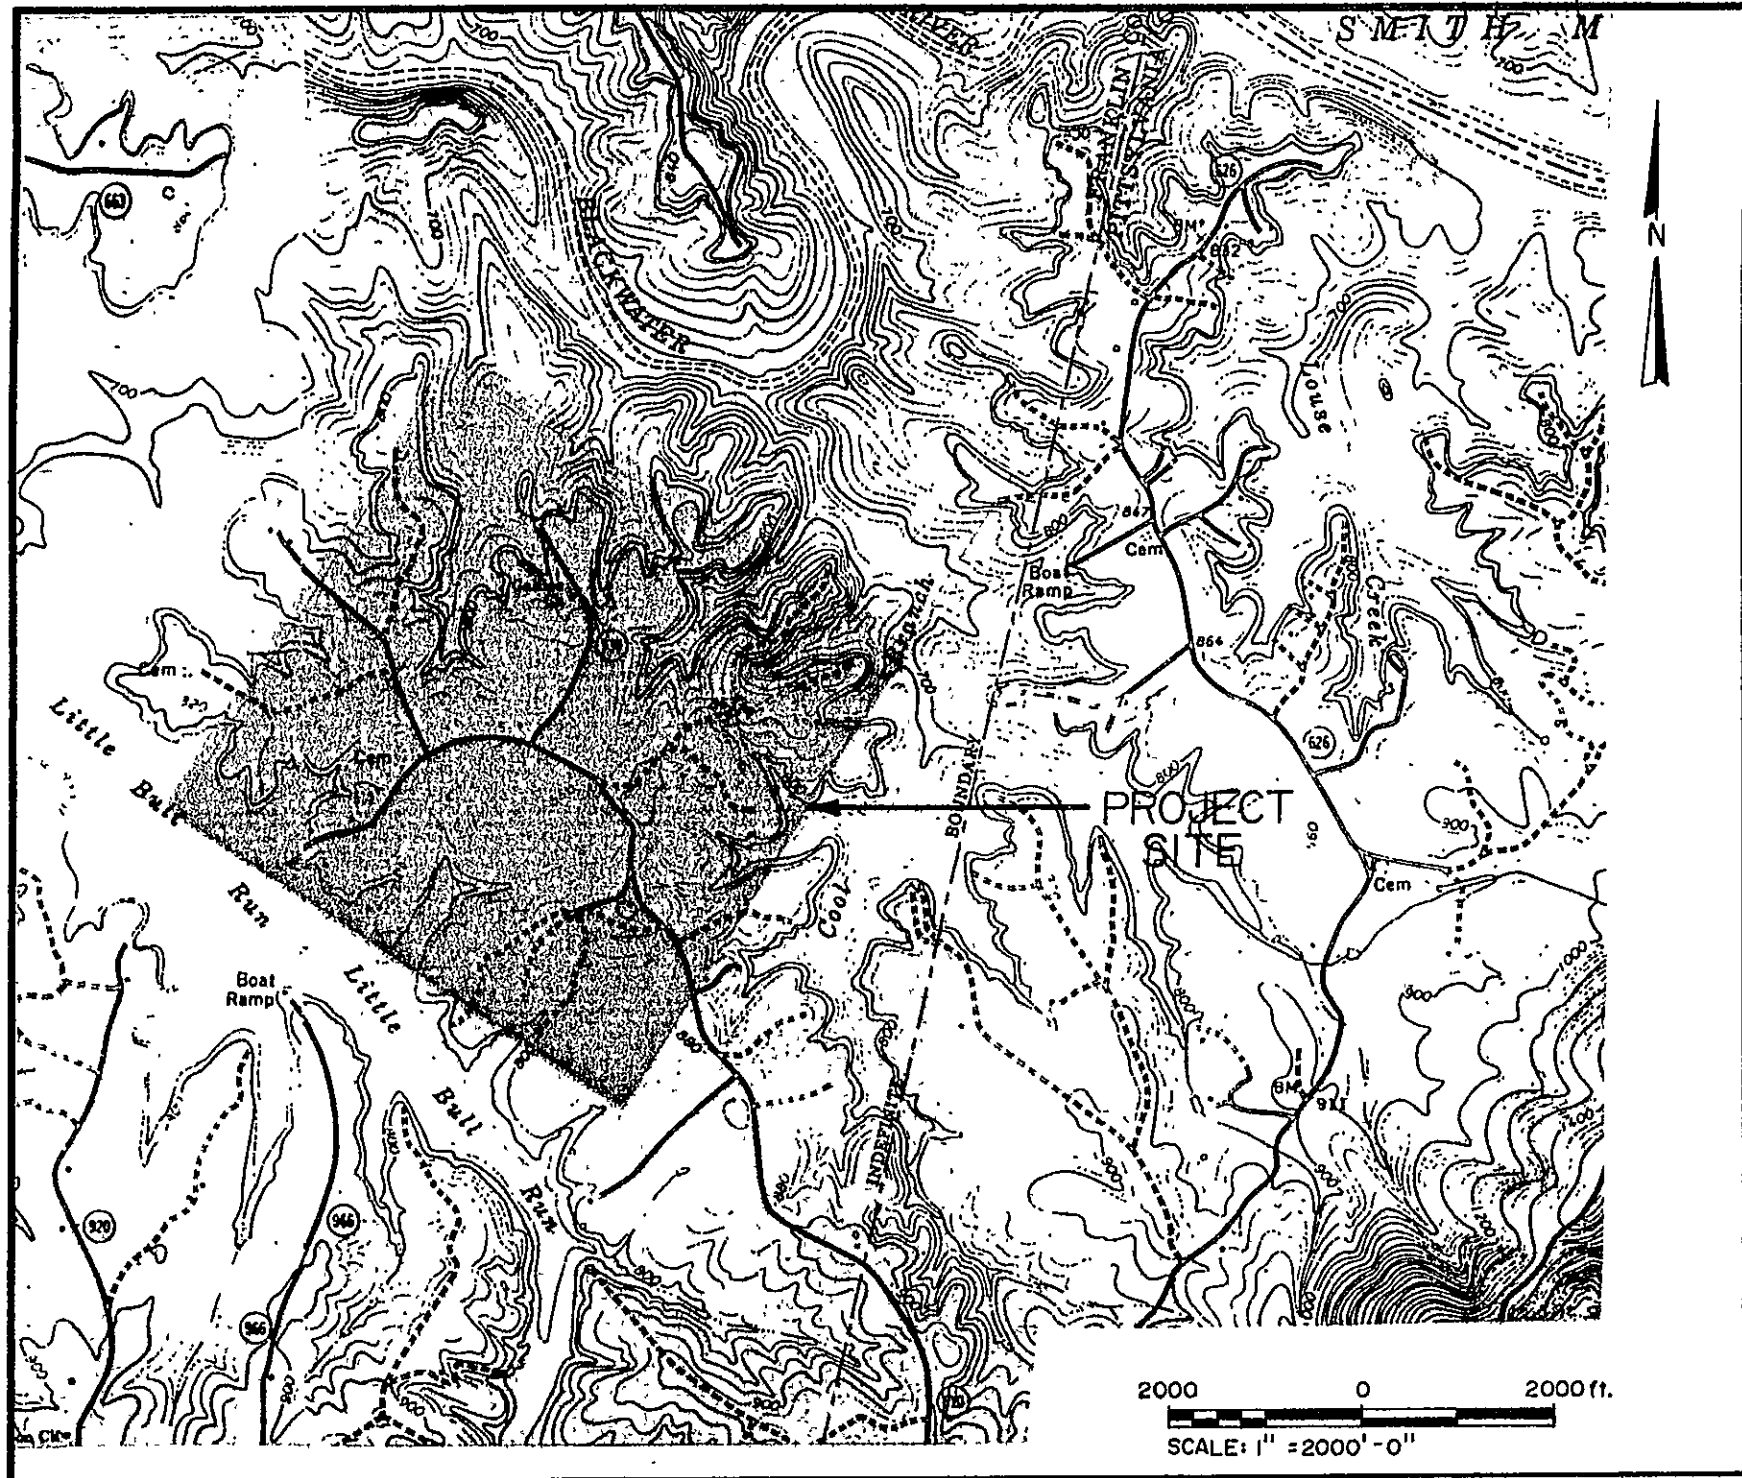

LOCATION MAP

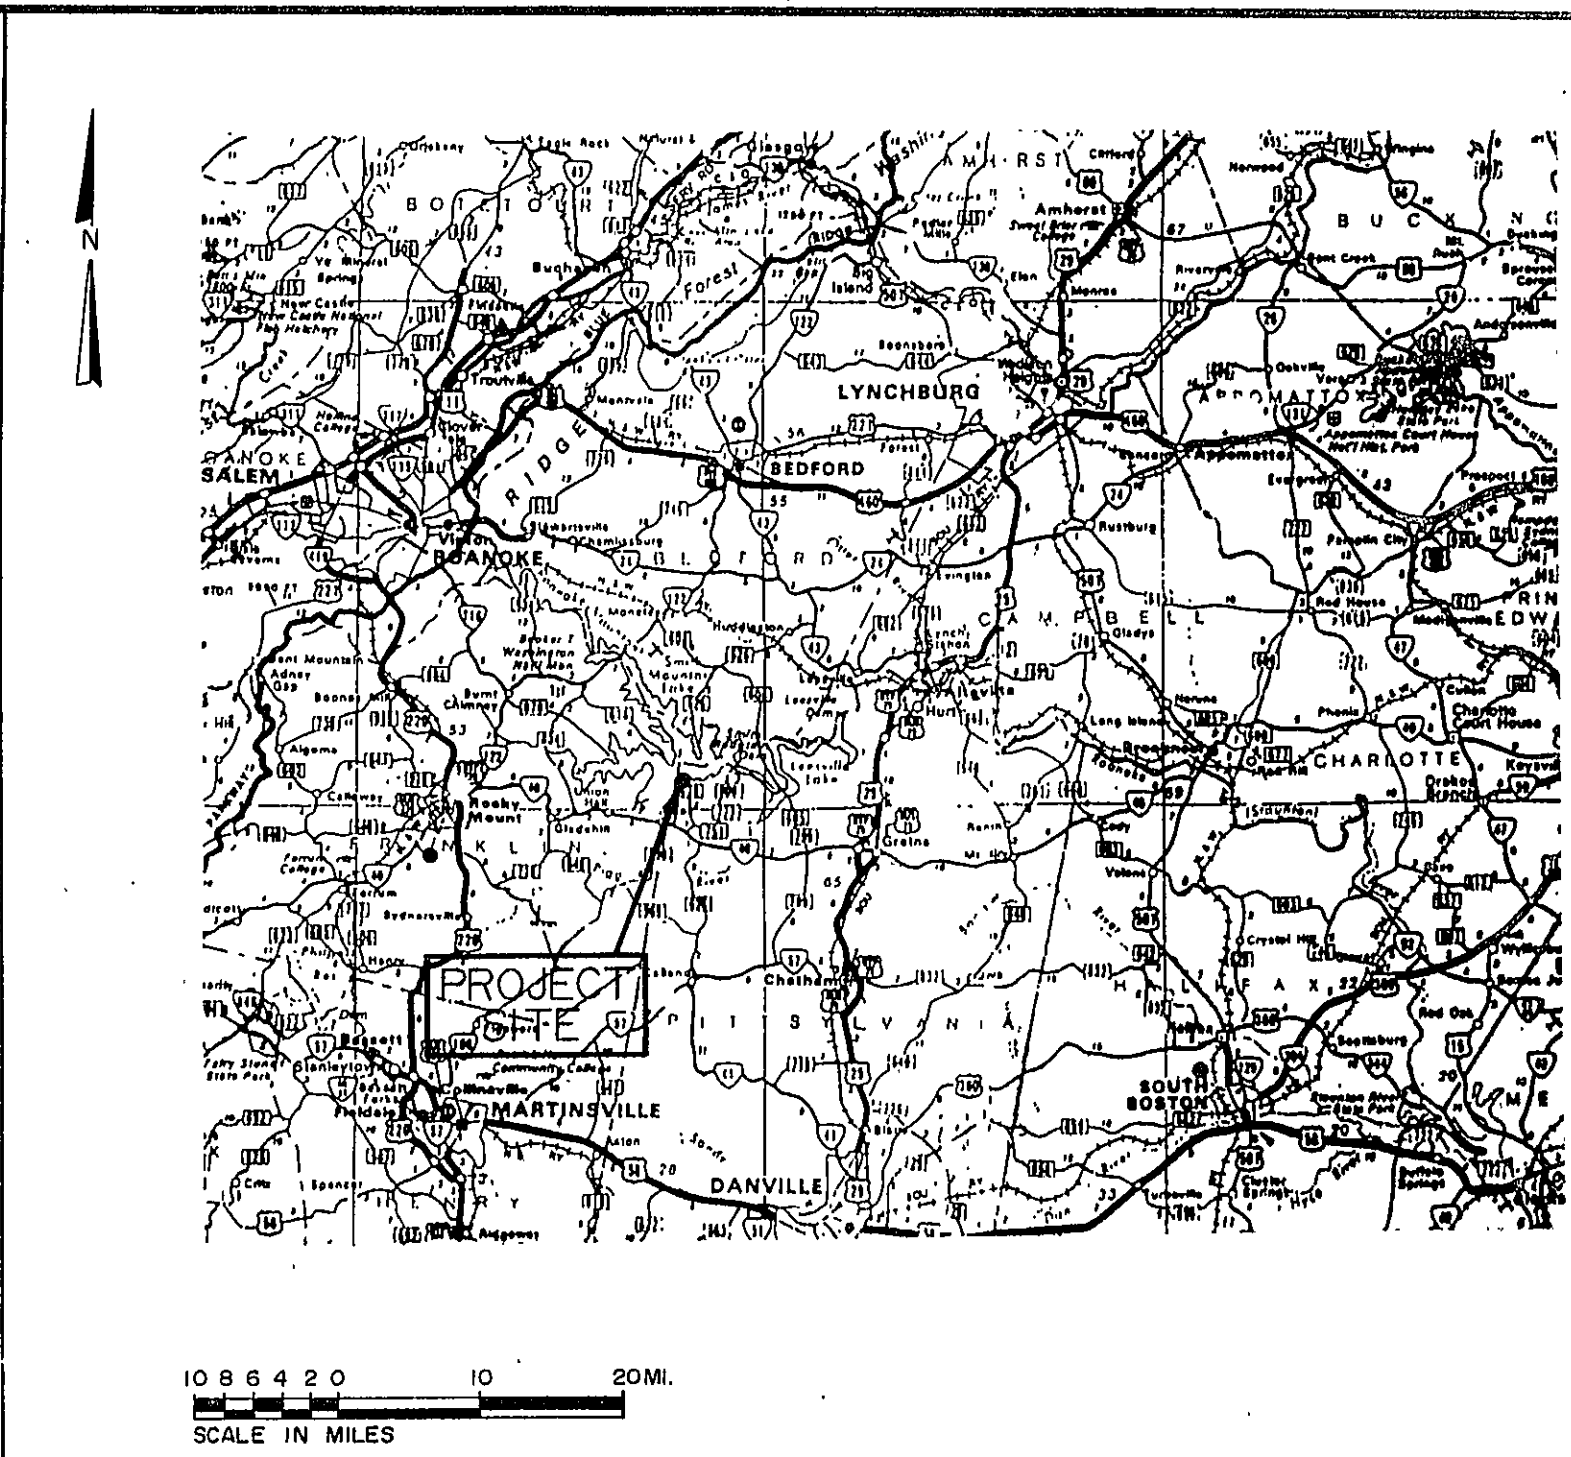


VICINITY MAP

WILLARD CONSTRUCTION OF ROANOKE VALLEY, INC. THE WATER'S EDGE WATER DISTRIBUTION SYSTEM

PHASE I - ISLAND GREEN DRIVE
MARINA BAY DRIVE AND CONDOMINIUMS

TABLE OF CONTENTS	
SHEET NUMBER	DESCRIPTION
101	TITLE SHEET
102	DEVELOPMENT PLAN
201	PLAN AND PROFILE
202	PLAN AND PROFILE
203	PLAN AND PROFILE
204	PLAN AND PROFILE
205	PLAN AND PROFILE
301	DETAIL SHEET

302 REPRESENTS THE SHEET NUMBER
ON WHICH THE DETAIL IS DRAWN.
1 REPRESENTS THE DETAIL NUMBER
ON THAT SHEET.
105 REPRESENTS THE SHEET NUMBER
FROM WHICH THE DETAIL OR SECTION
WAS CUT OR TAKEN.

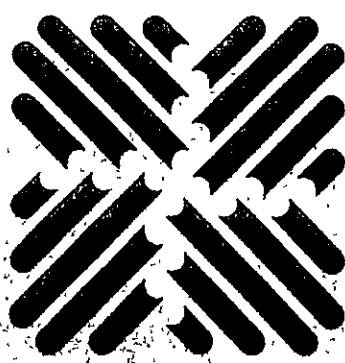

OLVER INCORPORATED
Consulting Engineers • Environmental Laboratories

1116 SOUTH MAIN STREET
BLACKSBURG, VIRGINIA 24060 (703) 552-5548

Designed KEM
Drawn SEL
Checked PBH

Scale NO SCALE
Job No. 10982
10983
Date APR. 1, 1988

THE WATER'S EDGE
WATER DISTRIBUTION SYSTEM

TITLE SHEET

					Sheet No.
					101
					File No.
I	REVISED - PHASE I	5/ 6 /88	KEM		
O	DESIGN ISSUE - PHASE I	4/ 1 /88	KEM		
Rev.	Description	Date	By		