
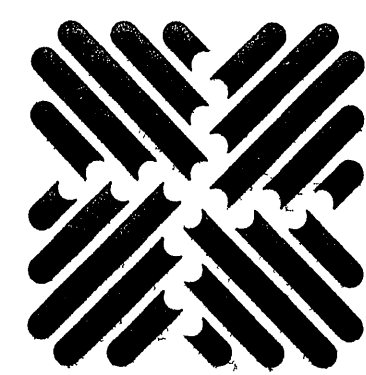
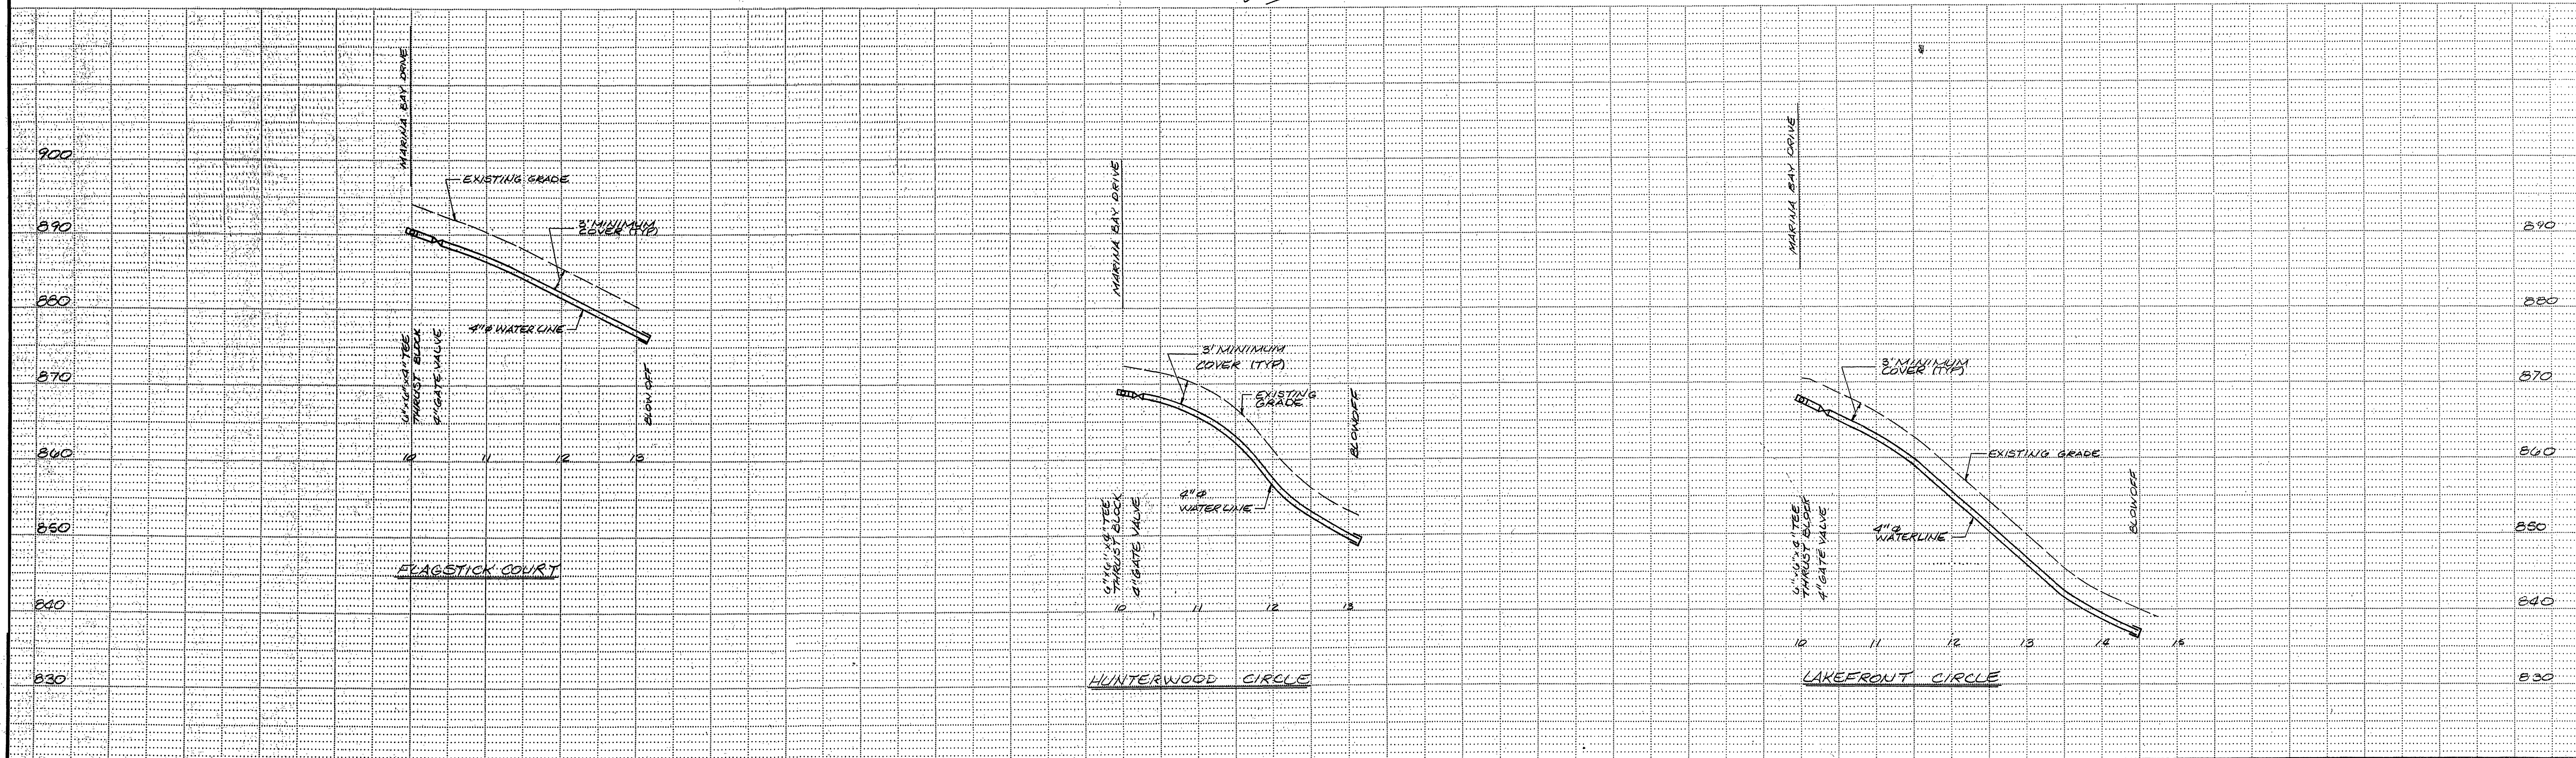


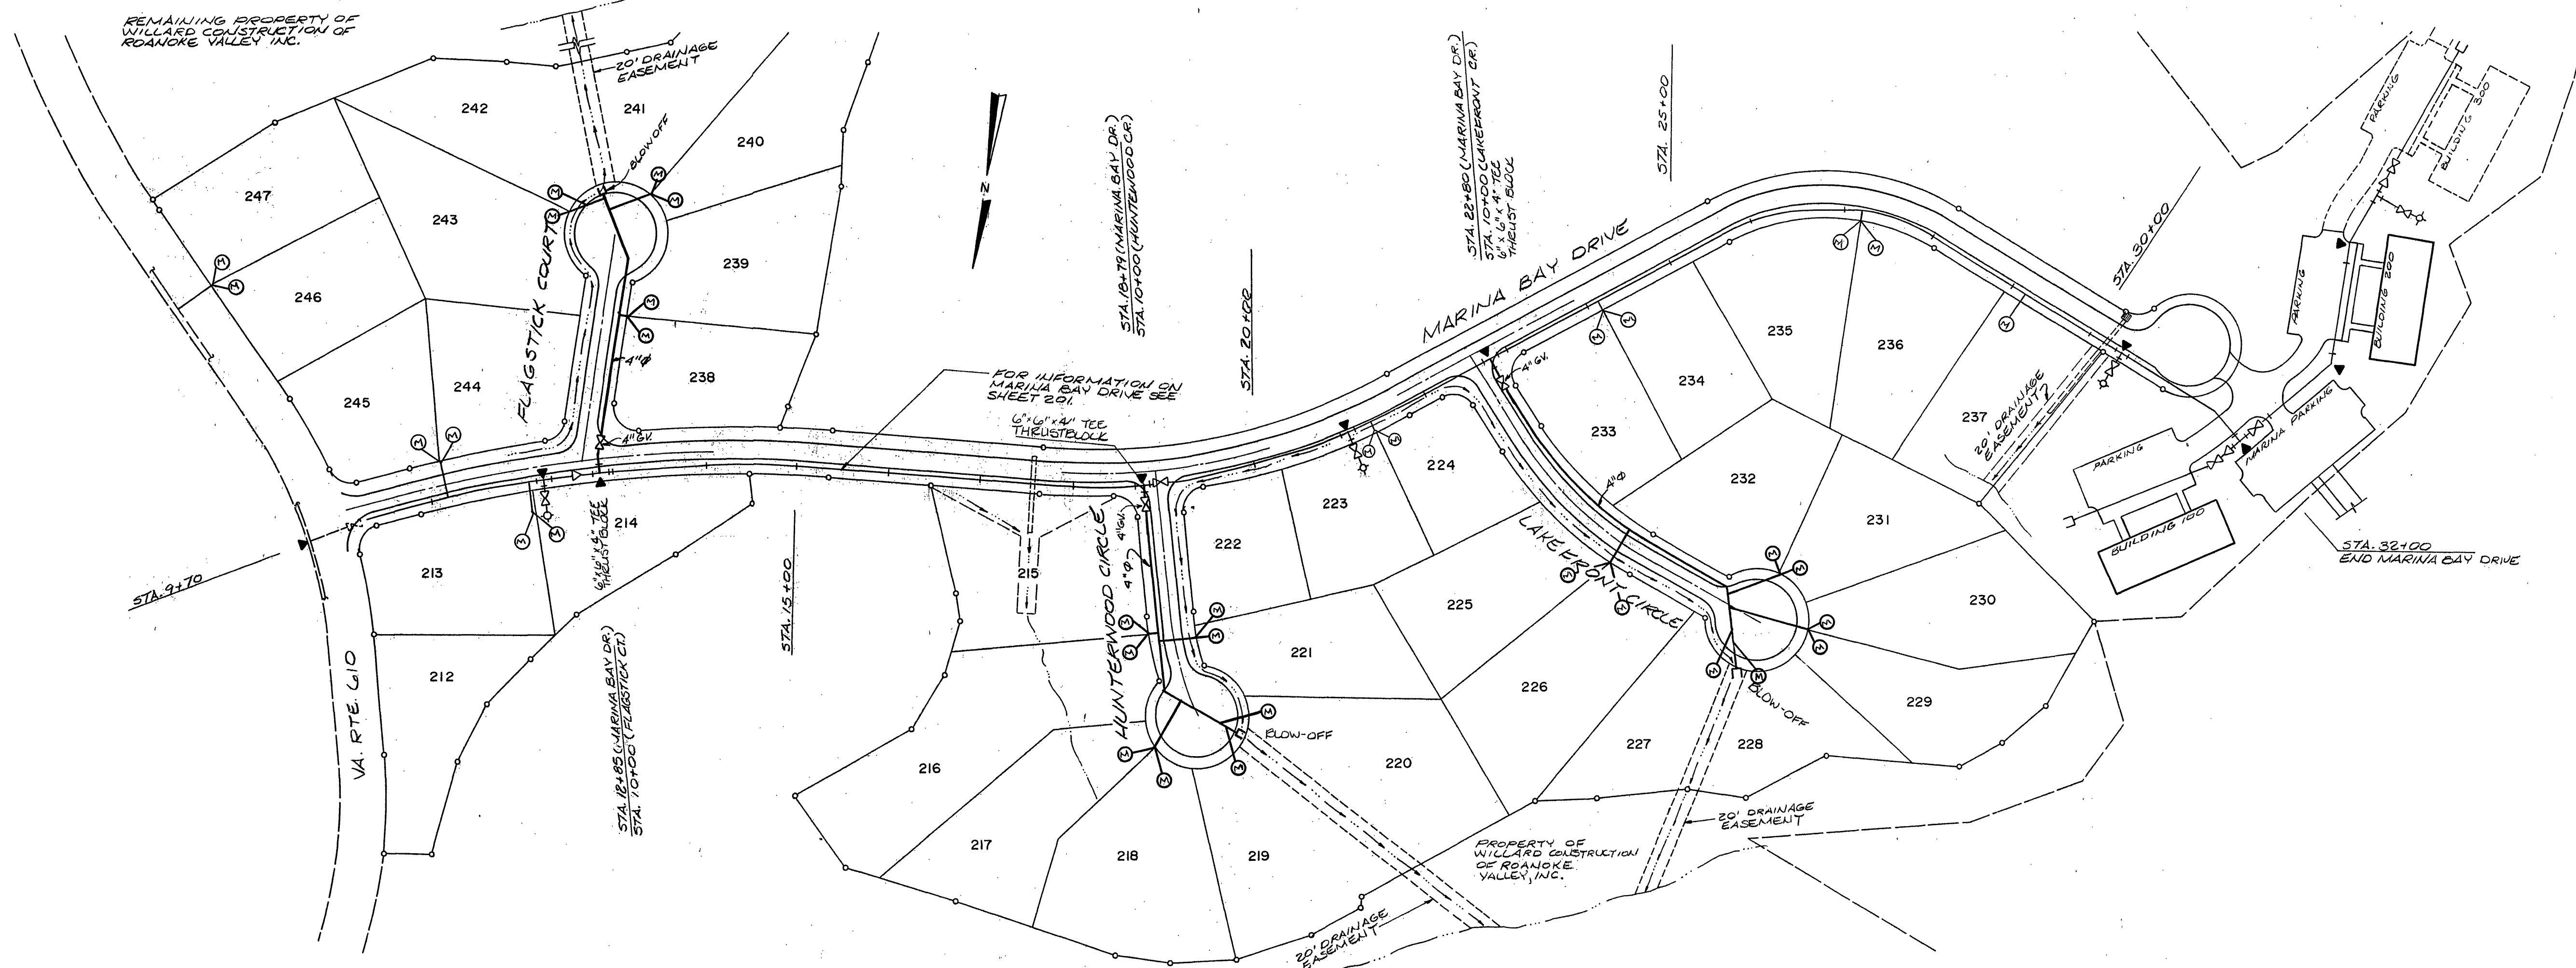

OLVER INCORPORATED
Consulting Engineers • Environmental Laboratories

1531 NORTH MAIN STREET
BLACKSBURG, VIRGINIA 24060

(703) 552-5548

Designed KEM

Drawn CWC

Checked PBH

Scale 1" = 100'-0"

Job No 10983

Date APR. 1, 1988

THE WATER'S EDGE WATER DISTRIBUTION SYSTEM

PLAN AND PROFILE

Rev.	Description	Date	By
1	REVISED - PHASE I	5/ 6 /88	KEM
0	DESIGN ISSUE- PHASE I	4/ 1 /88	KEM

Sheet No.

202

File No.