
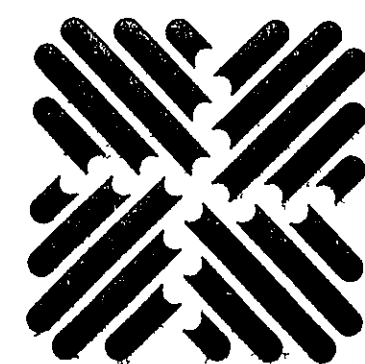
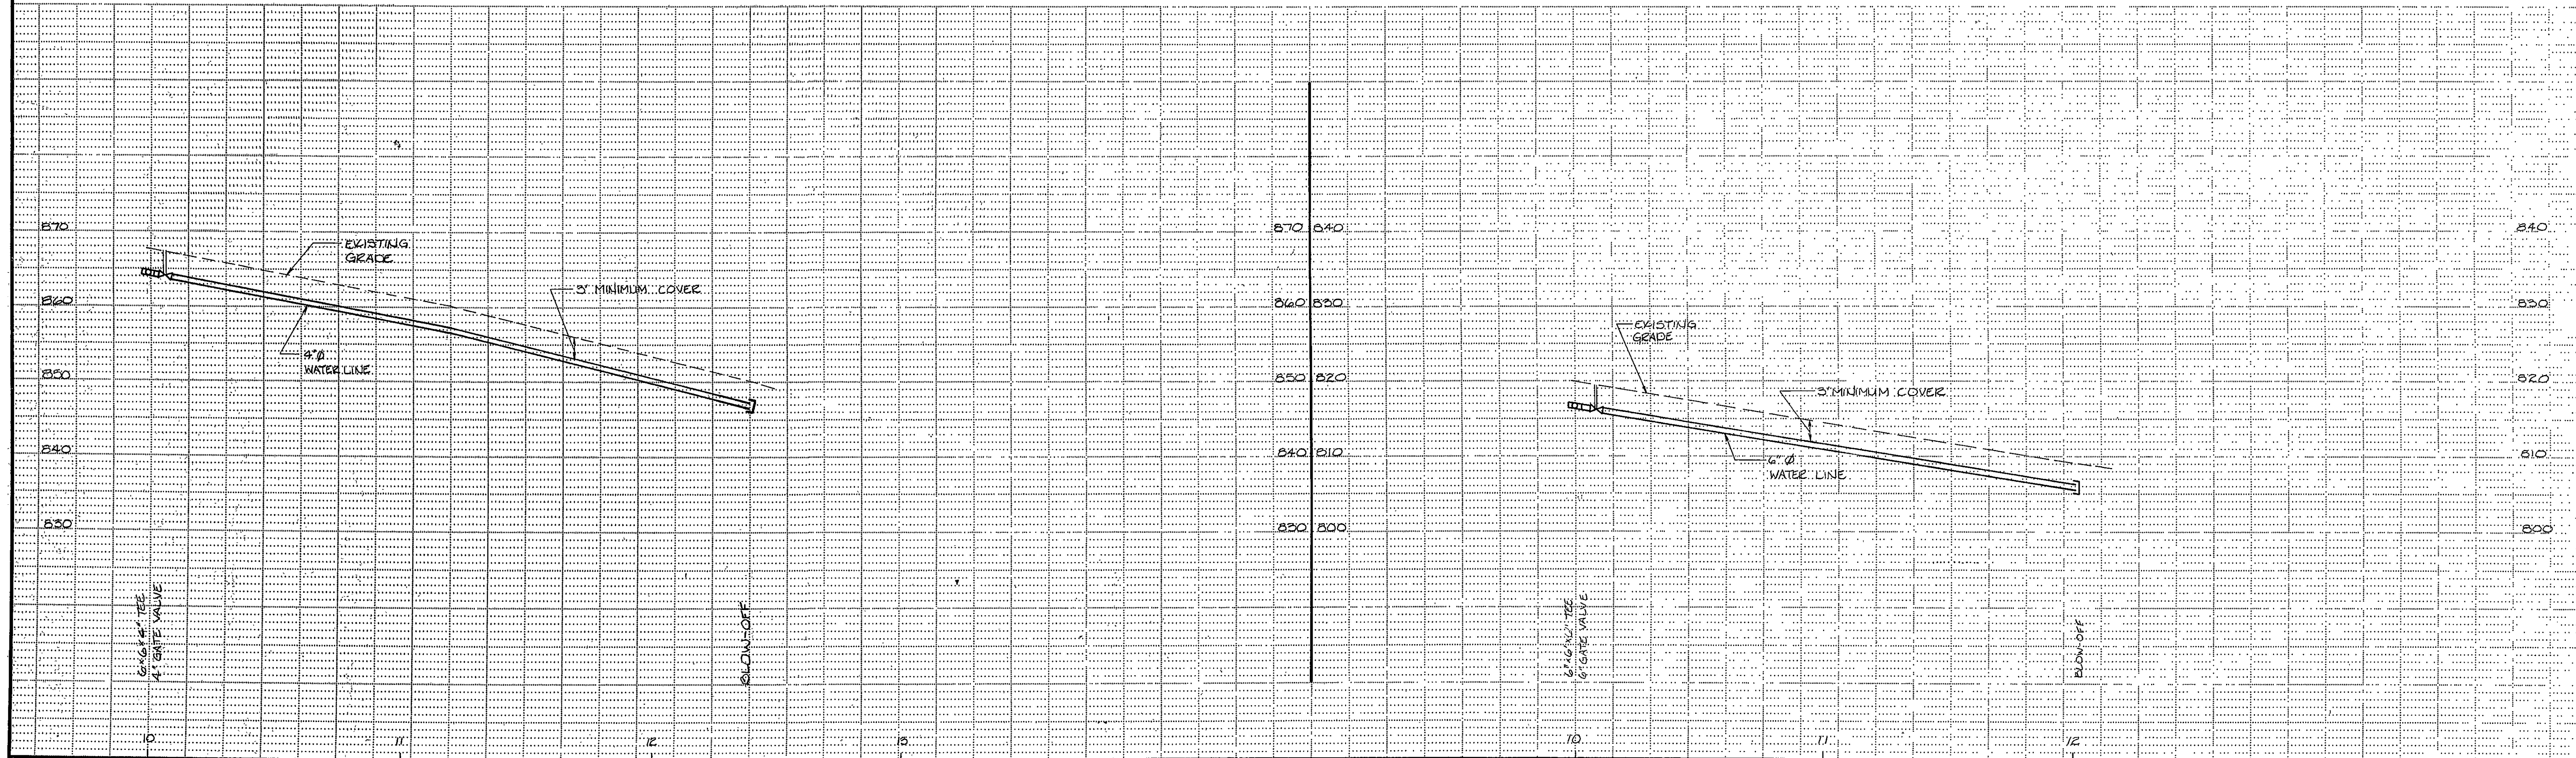


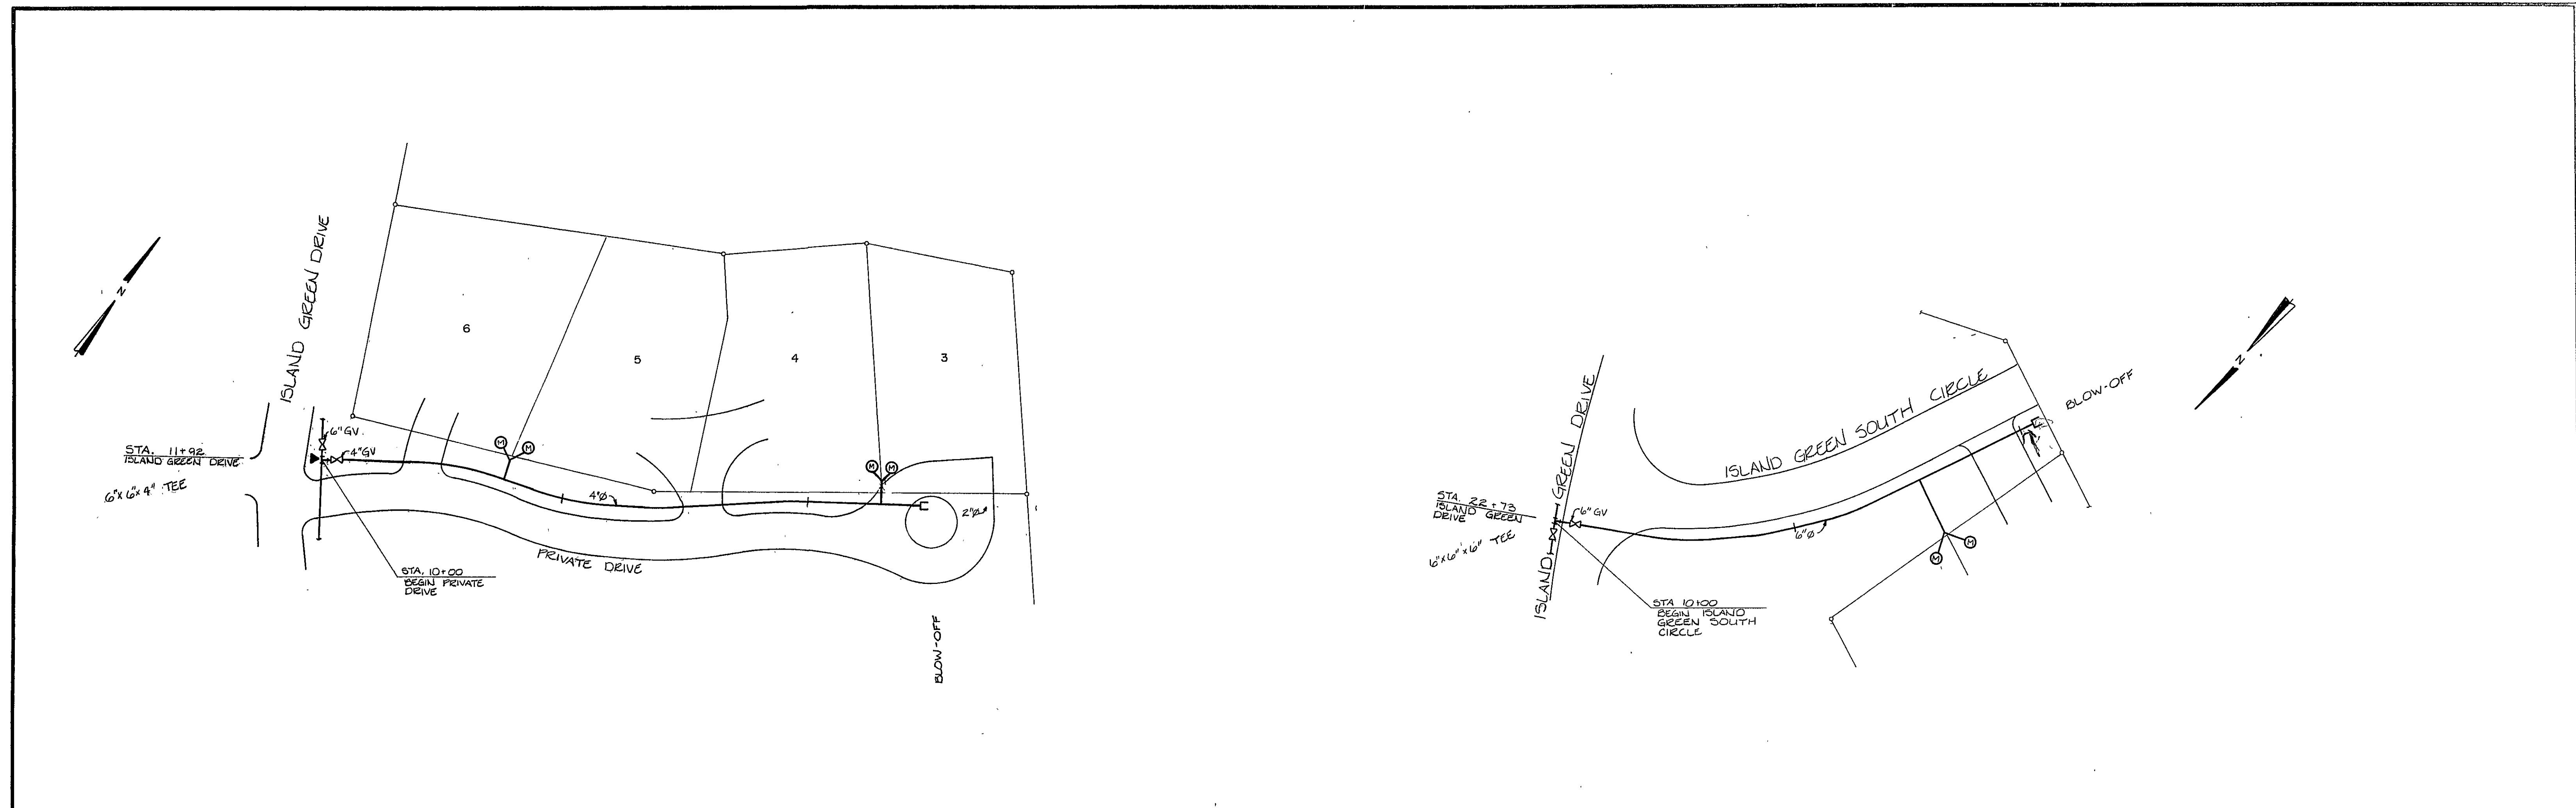

OLVER INCORPORATED
Consulting Engineers • Environmental Laboratories

1531 NORTH MAIN STREET
BLACKSBURG, VIRGINIA 24060

(703) 552-5548

Designed KEM

Drawn TLP

Checked PBH

1" = 10' - 0" VERT.
Scale 1" = 30' - 0" HORIZ.

Job No. 10982

Date APR. 1, 1988

THE WATER'S EDGE WATER DISTRIBUTION SYSTEM

PLAN AND PROFILE

Rev.	Description	Date	By
1	REVISED - PHASE I	5/ 6 /88	KEM
0	DESIGN ISSUE - PHASE I	4/ 1 /88	KEM

Sheet No.

205

File No.