


SMITH MOUNTAIN LAKE


SMITH MOUNTAIN LAKE

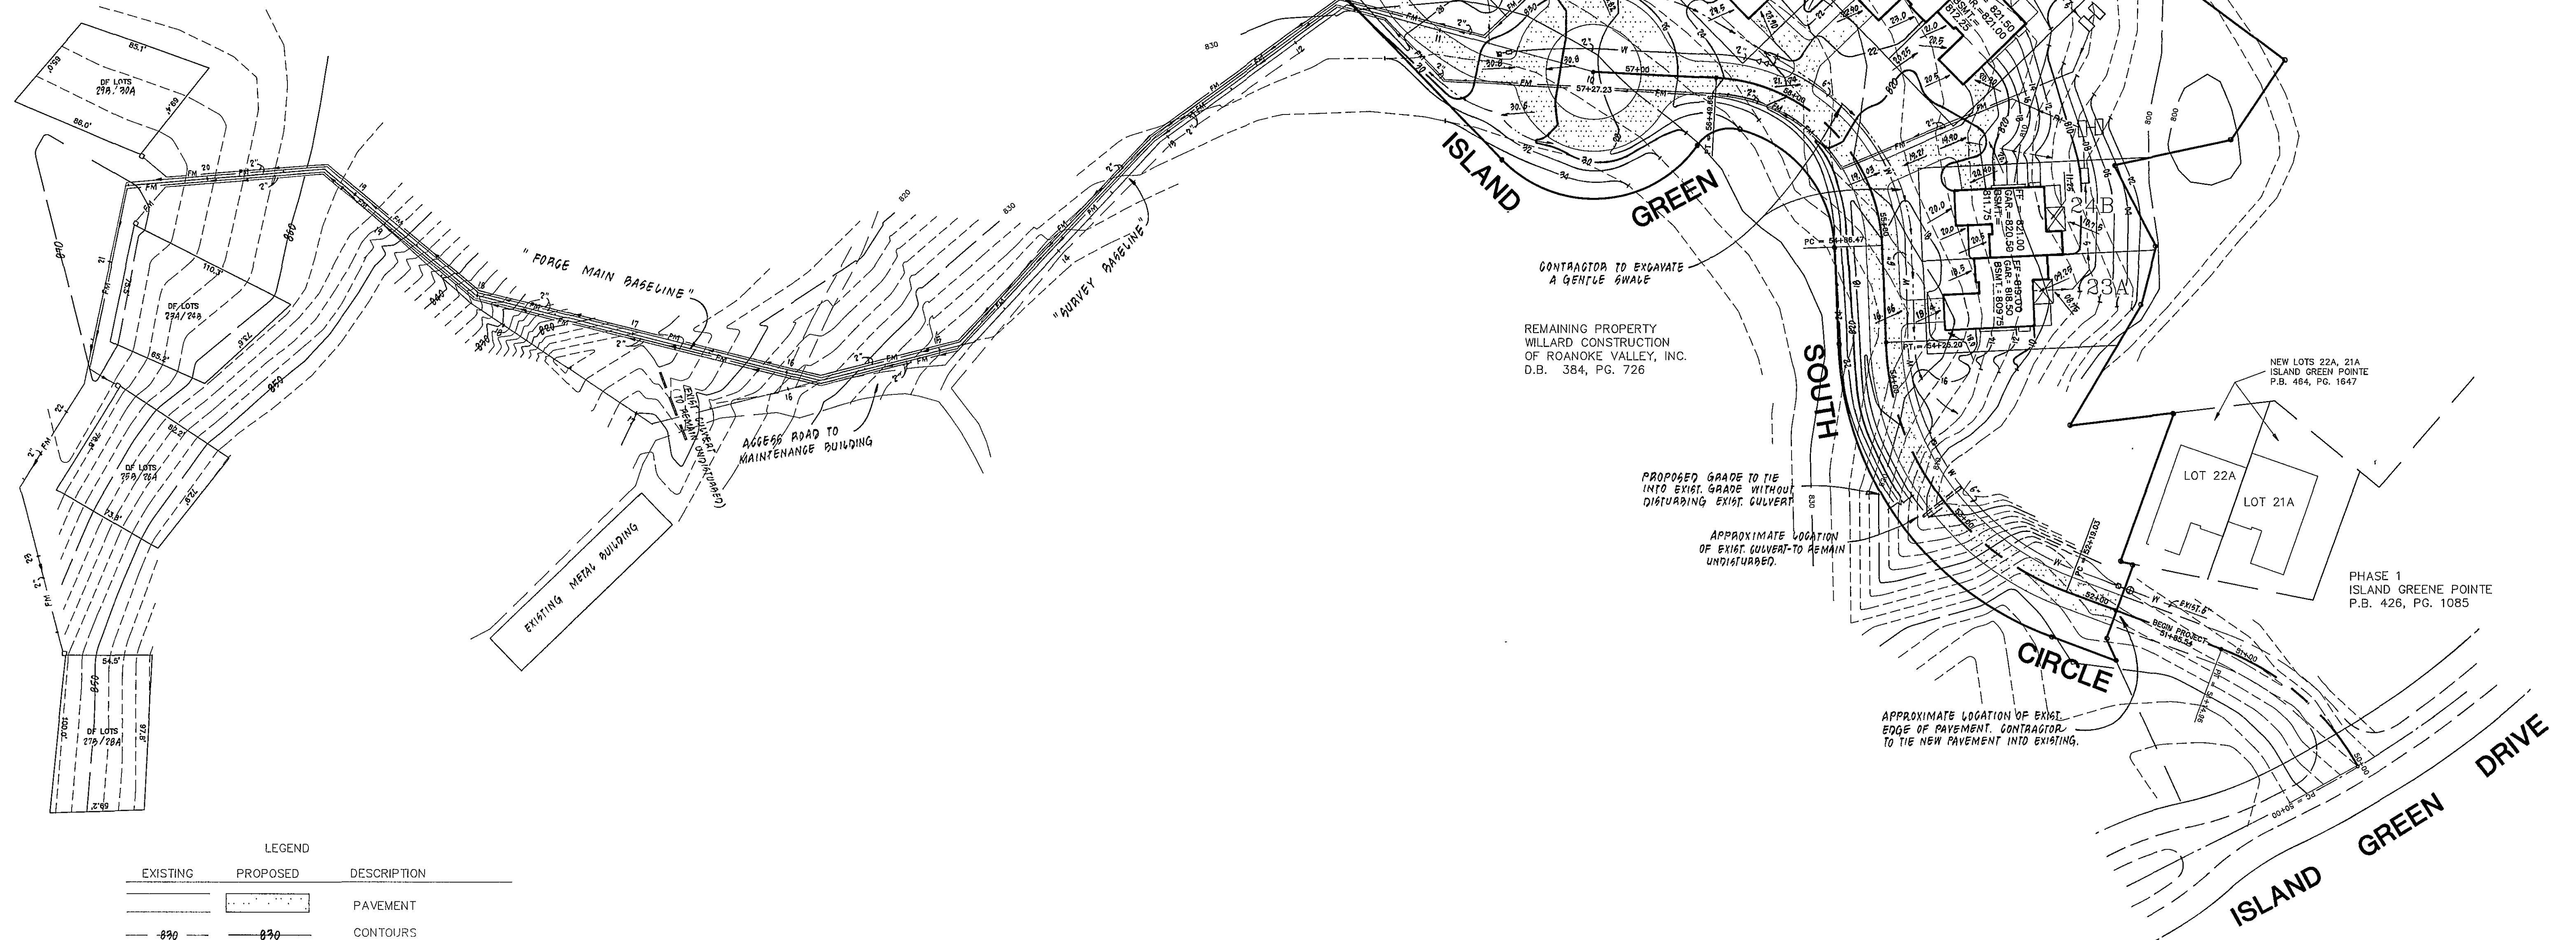

LEGEND		DESCRIPTION
EXISTING	PROPOSED	
---	---	PAVEMENT
---	---	CONTOURS
---	---	FF = FIRST FLOOR ELEVATION
S	---	SANITARY SEWER
W	---	WATER LINE
+	+	FIRE HYDRANT
□	□	BLOW-OFF
E F M	F M	FORCE MAIN (SEWER)
⊕	⊕	GATE VALVE
□	□	AIR RELEASE VALVE (WATER)
▽	▽	AIR RELEASE VALVE (SEWER)
⌵	⌵	DOUBLE WATER METER
⌵	⌵	SINGLE WATER METER
DF	DF	DRAINFIELD (DF)
---	---	FORCE MAIN BASELINE
---	---	SURVEY BASELINE
---	---	DRAINAGE FLOW

SHEET REFERENCES:

SEE SHEET #3 FOR RECORD MAP
SEE SHEET #4 FOR NOTES & DETAILS
SEE SHEET #5 FOR DIMENSIONAL LAYOUT & UTILITIES
SEE SHEET #6 FOR SITE PLAN
SEE SHEET #7 FOR PROFILE-ROAD, WATER & FORCE MAINS
SEE SHEET #8 FOR PROFILE-PUMP STATIONS & FORCE MAINS
SEE SHEET #9 FOR SEWER SPECIFICATIONS & DETAILS
SEE SHEET #10 FOR WATER SPECIFICATIONS & DETAILS
SEE SHEET #11 FOR EROSION AND SEDIMENT CONTROL

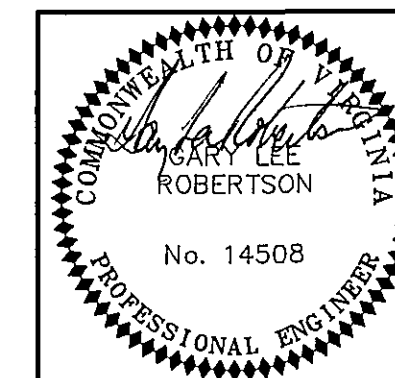

REVISION	DATE	DESCRIPTION
DESIGNED	5MP	SITE PLAN FOR "ISLAND GREEN POINTE, PHASE II" at THE WATERS EDGE
DRAWN	FGH, RAG	PREPARED FOR WILLARD CONSTRUCTION OF ROANOKE VALLEY, INC. UNION HALL MAGISTERIAL DISTRICT FRANKLIN COUNTY, VIRGINIA
CHECKED	GIC	
LUMSDEN ASSOCIATES, P.C. ENGINEERS-SURVEYORS-PLANNERS ROANOKE, VIRGINIA		SCALE: 1" = 50' COMM: 84-665
		DATE: 10 JAN. 1992 SHEET 6 of 11