



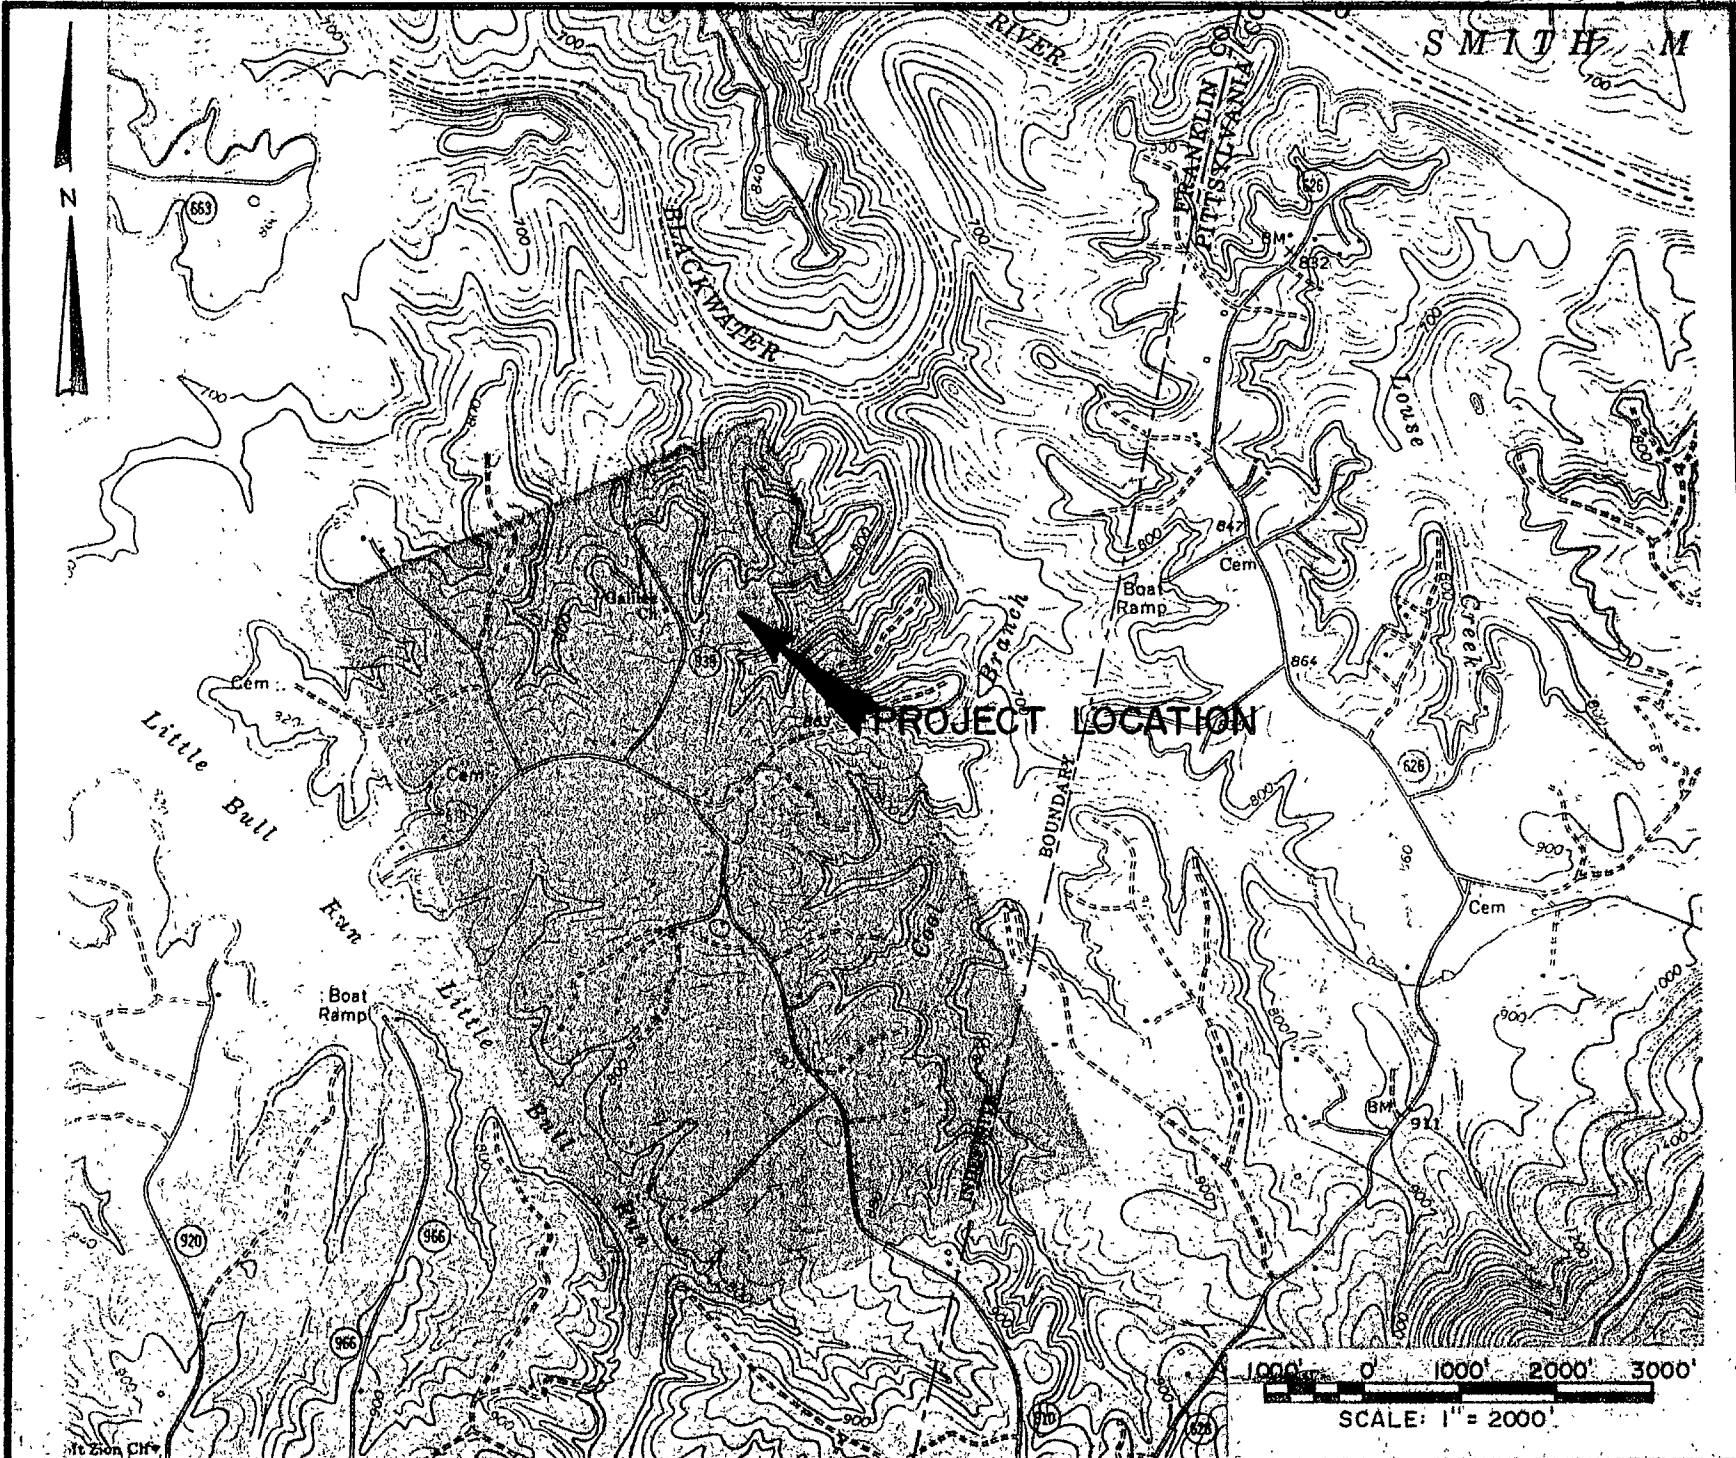

LOCATION MAP

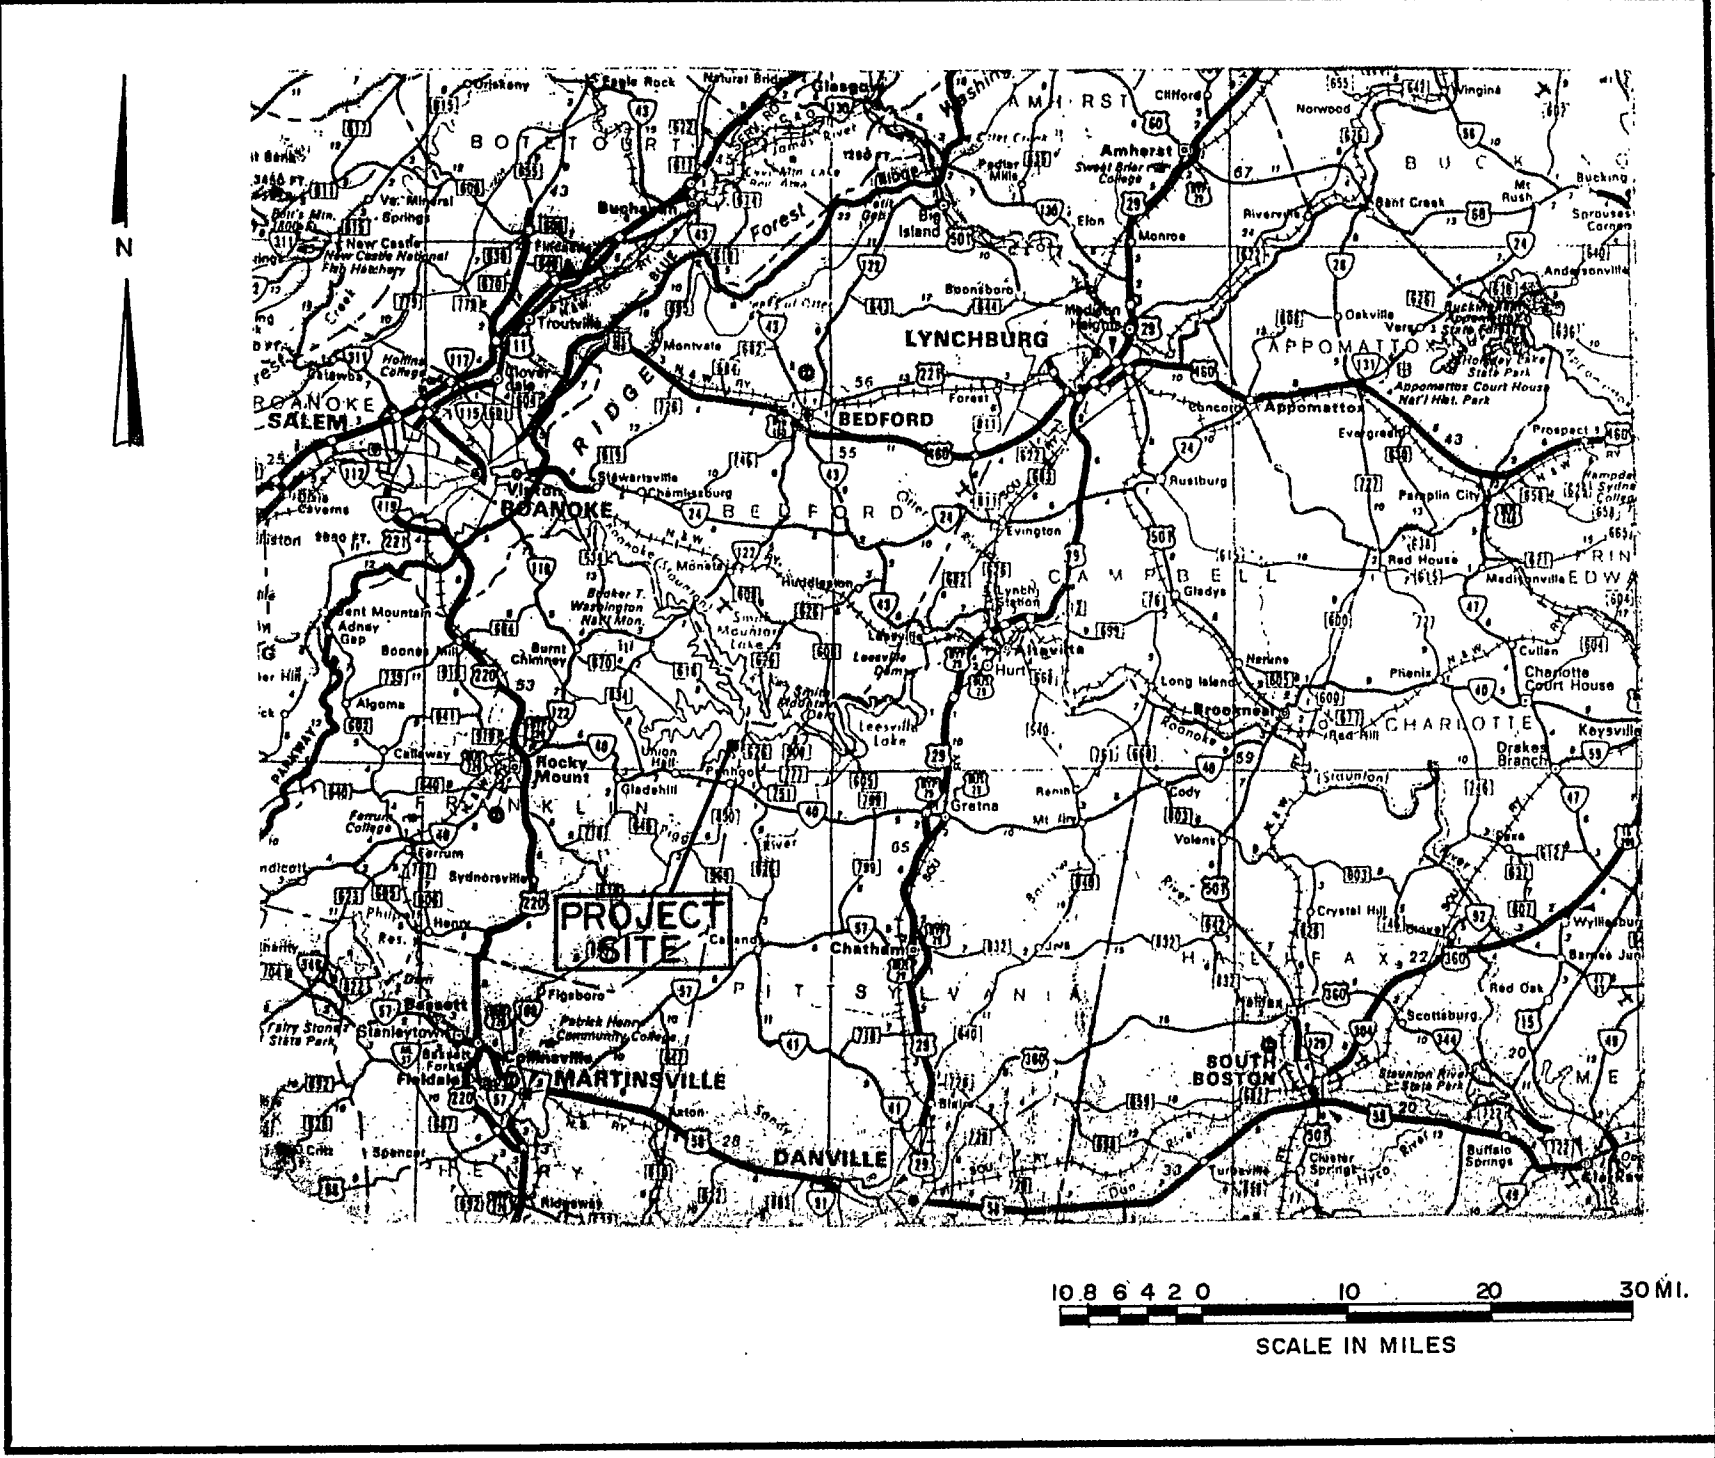

VICINITY MAP

WILLARD CONSTRUCTION OF ROANOKE VALLEY, INC. THE WATER'S EDGE


WATER DISTRIBUTION SYSTEM SILVER TEE DRIVE SECTION III

TABLE OF CONTENTS	
SHEET NO.	DESCRIPTION
101	TITLE SHEET
102	DEVELOPMENT PLAN
201	PLAN AND PROFILES
202	PLAN AND PROFILES
203	PLAN AND PROFILES
301	DETAIL SHEET
302	WELL HOUSE DETAIL

301.1
201

301 REPRESENTS THE SHEET NUMBER
ON WHICH THE DETAIL IS DRAWN
201 REPRESENTS THE DETAIL NUMBER
ON THAT SHEET
201 REPRESENTS THE SHEET NUMBER
FROM WHICH THE DETAIL OR SECTION
WAS CUT OR TAKEN

LEGEND	ABBREVIATIONS
WATER LINE	CENTERLINE
BASE LINE	CORRUGATED METAL PIPE
PROPERTY LINE	DEED BOOK
PIPE PROFILE	ELEVATION
THRUST BLOCK	EASEMENT
WATER VALVE	GATE VALVE
FIRE HYDRANT	DIAMETER
WATER METER	INVERT
UNDERGROUND PIPE - SECTION	PAVEMENT
DROP INLET	STATION
PIPE TEE	TYPICAL
EG-1, TYPE "A" EROSION CONTROL STONE	
SLOPES DOWN	
COMBINATION AIR RELEASE VALVE	

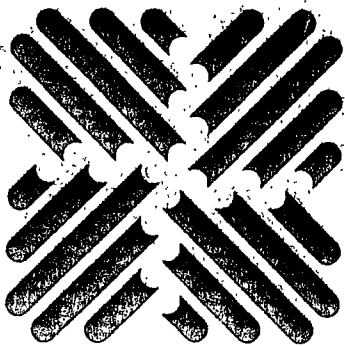

OLVER INCORPORATED
Consulting Engineers • Environmental Laboratories
1531 NORTH MAIN STREET
BLACKSBURG, VIRGINIA 24060
(703) 552-5548

Designed KEM
Drawn RGW
Checked PBH

Scale NO SCALE
Job No. 10977
Date NOV. 19, 1987

THE WATER'S EDGE

TITLE SHEET

Rev.	Description	Date	By
2	REVISED	5/6/88	KEM
1	DESIGN ISSUE	3/11/88	KEM
0	DESIGN ISSUE	11/19/87	KEM

Sheet No.

101

File No.