
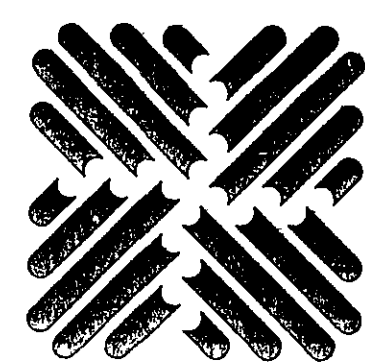
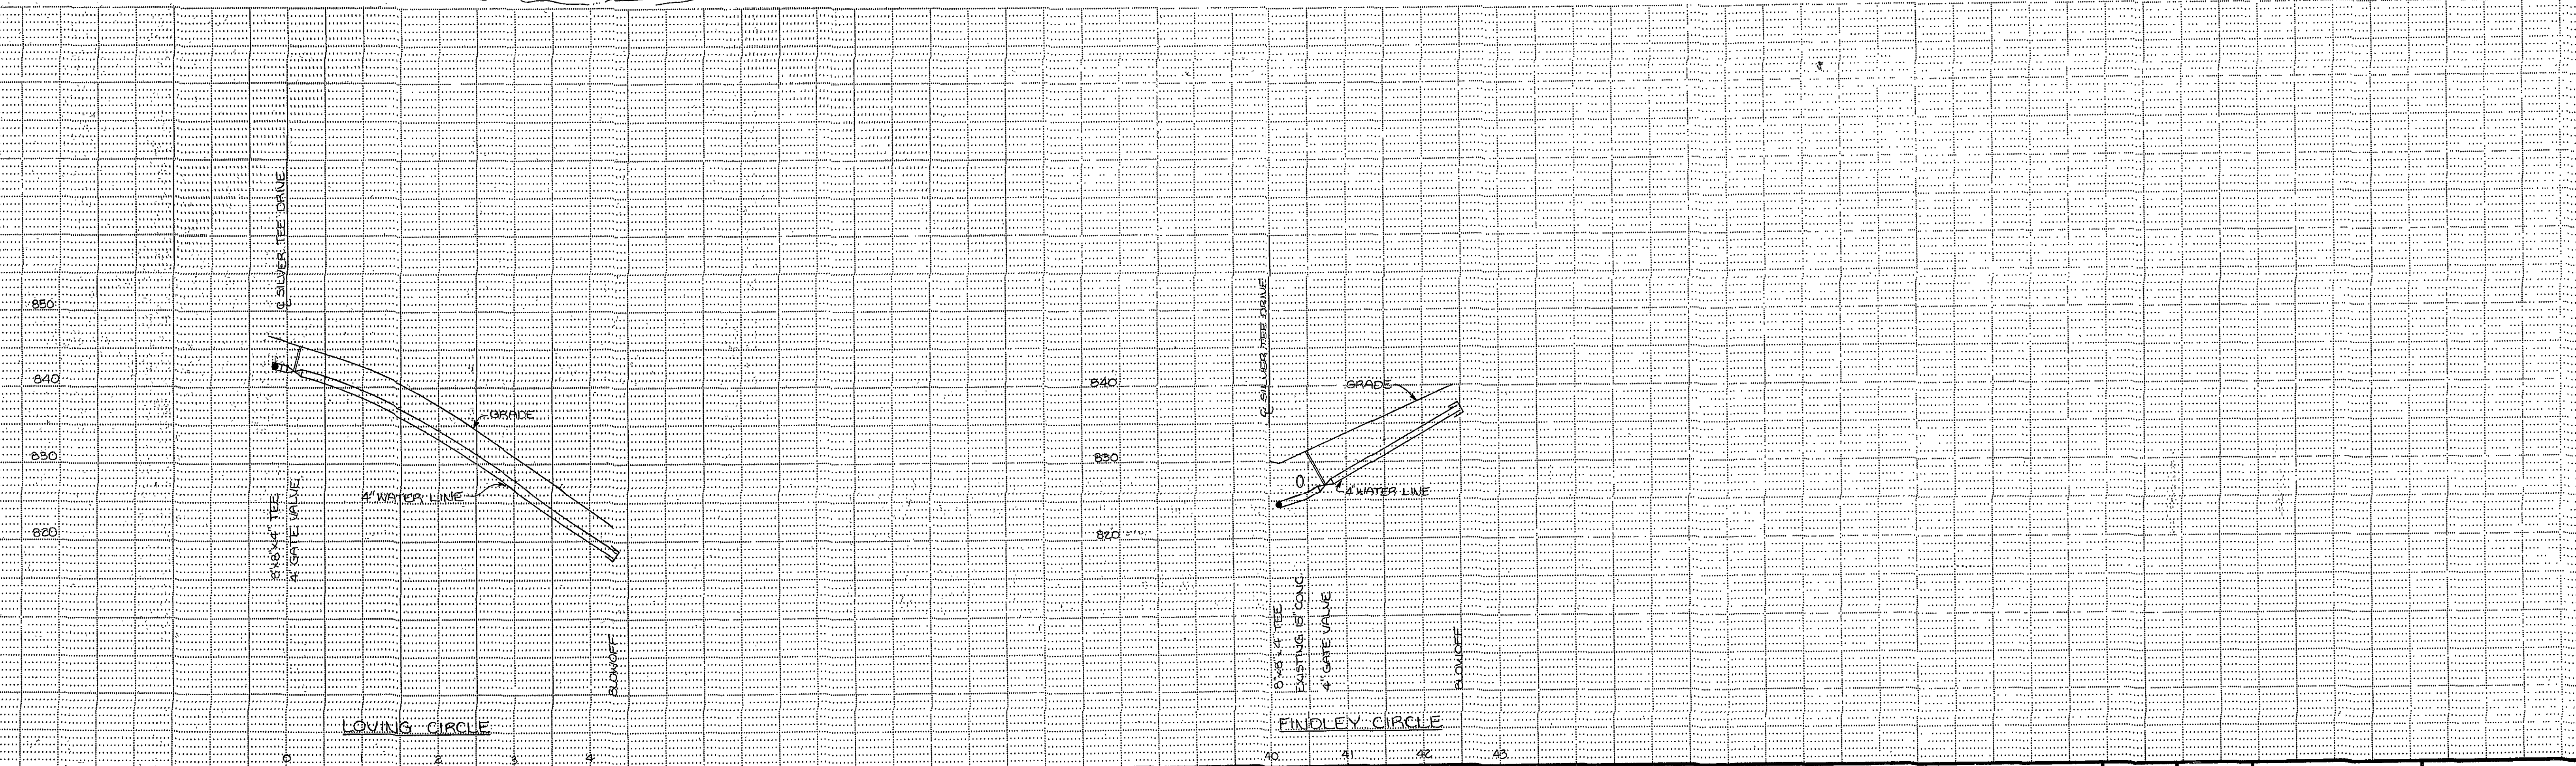


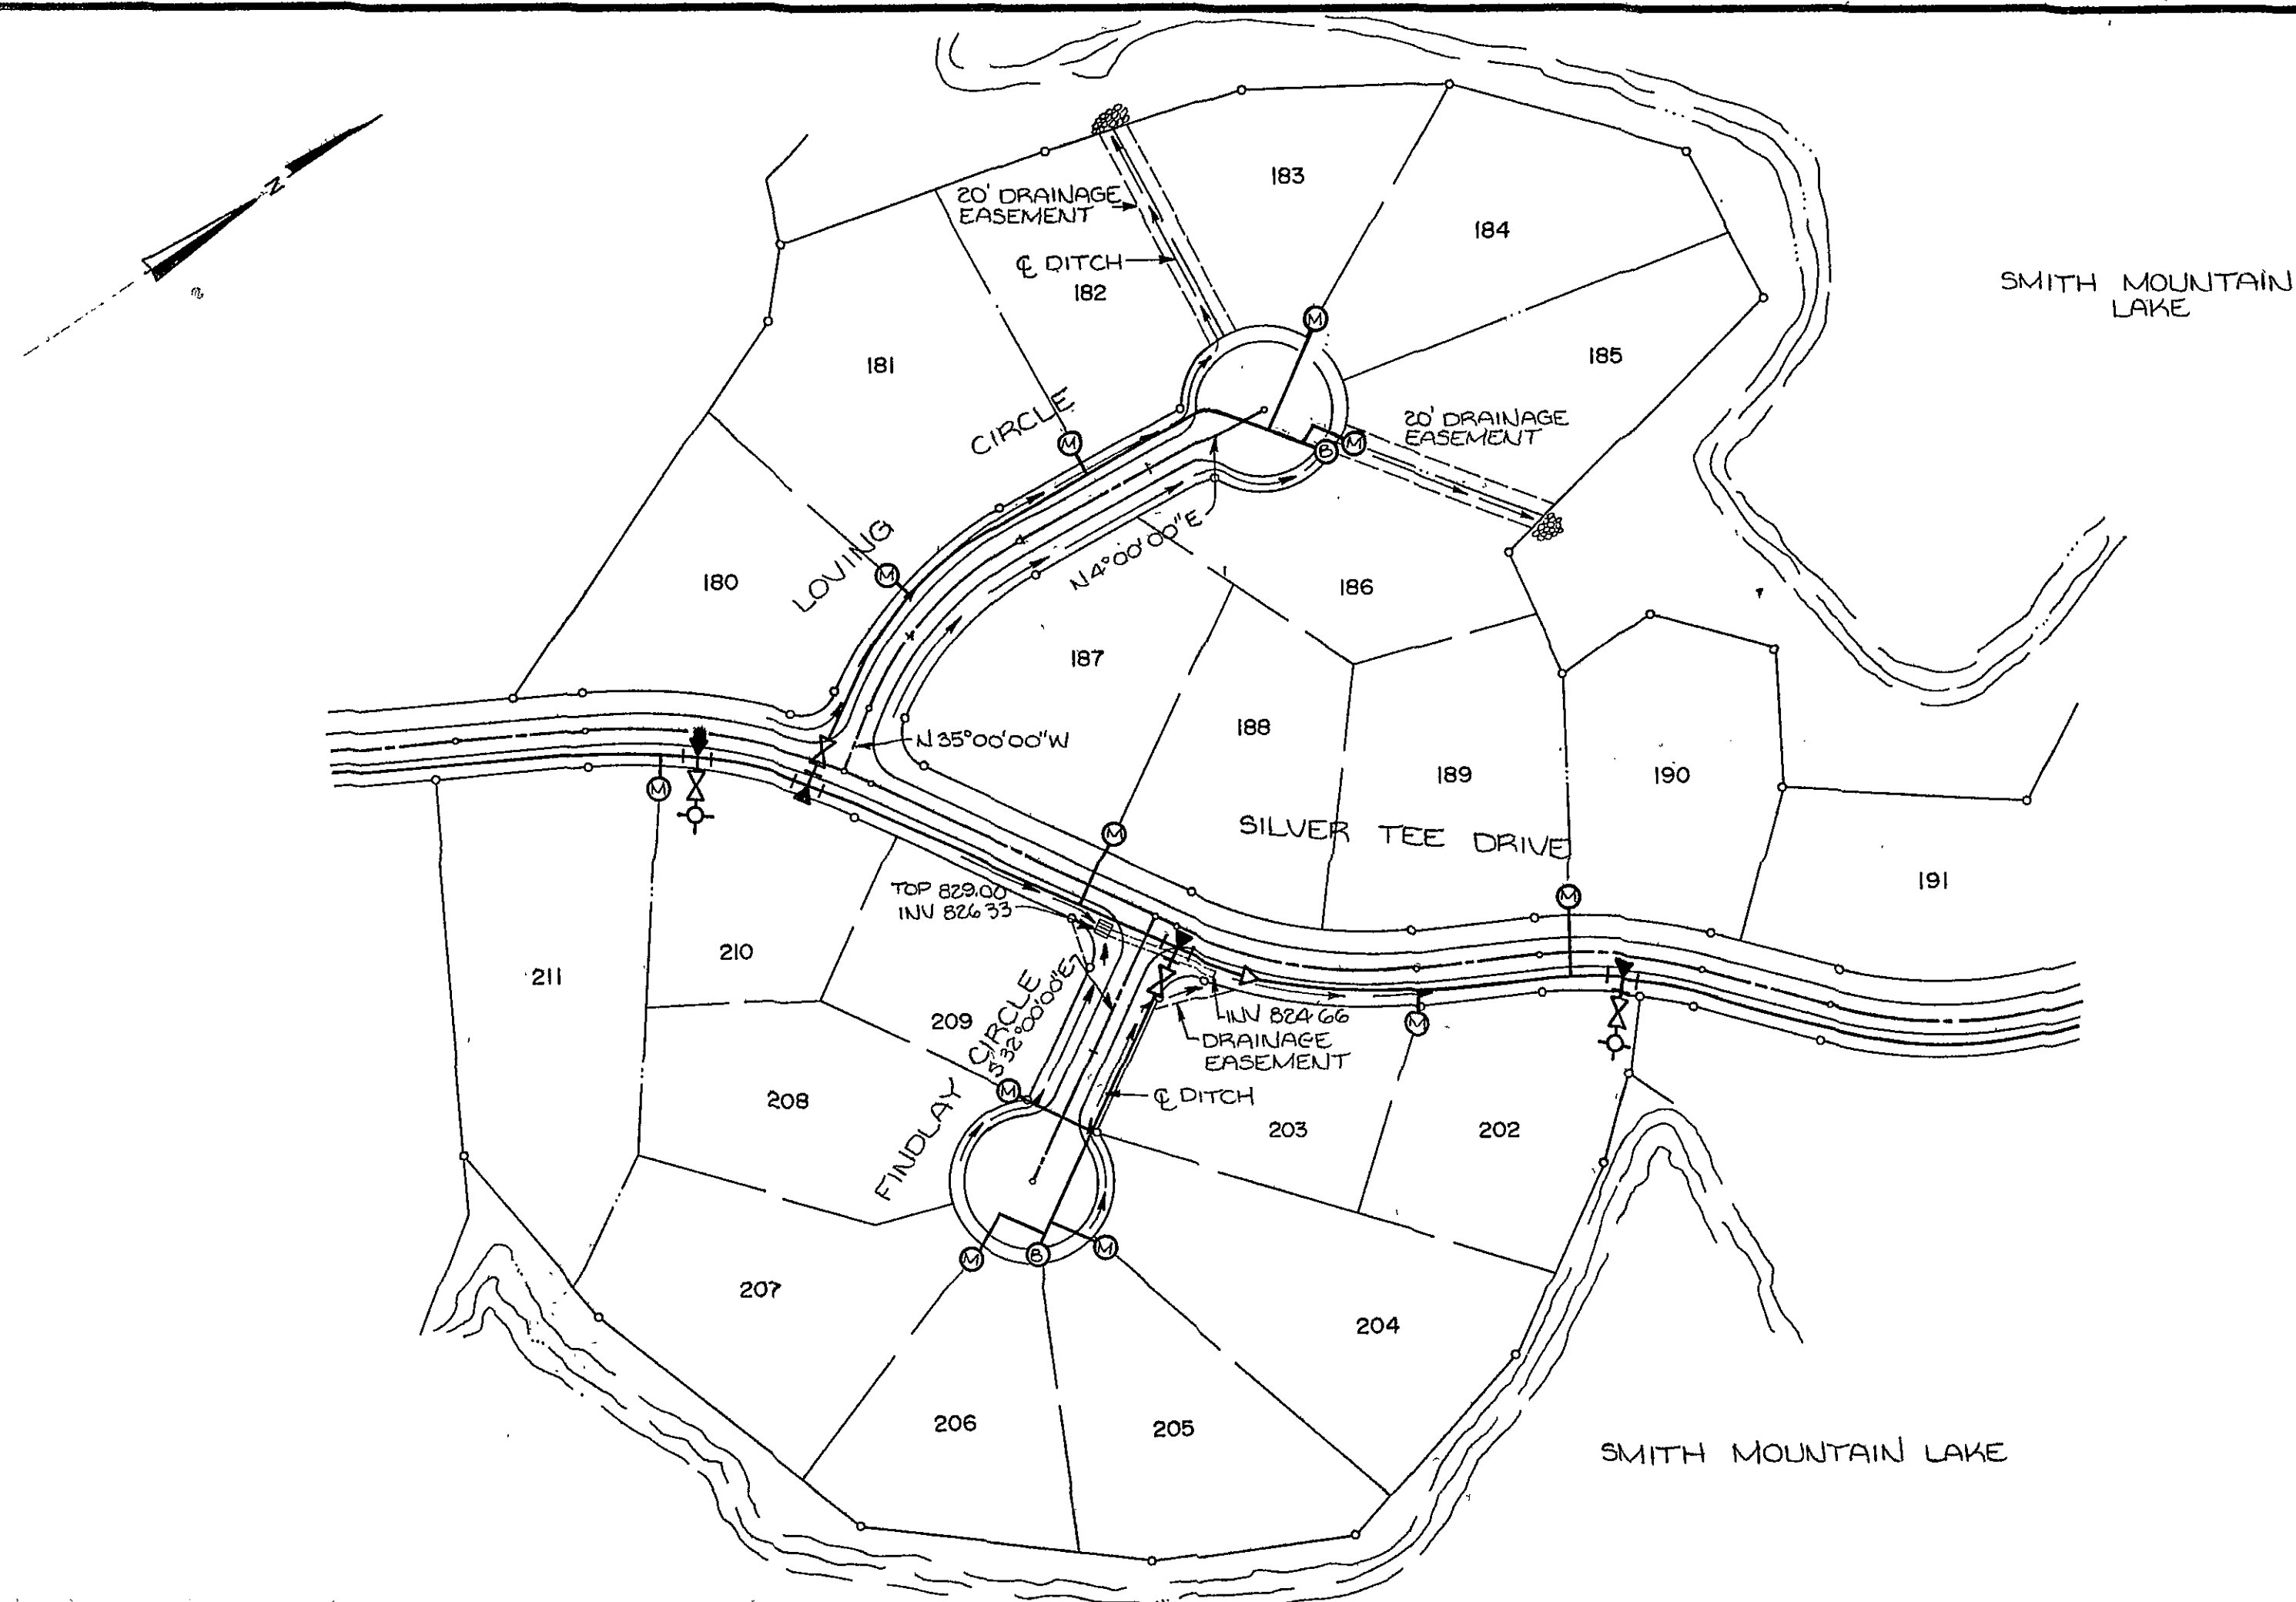

OLVER INCORPORATED
Consulting Engineers • Environmental Laboratories

1531 NORTH MAIN STREET
BLACKSBURG, VIRGINIA 24060 (703) 552-5548

Designed KEM

Drawn RGW

Checked PBH

1" = 10'-0" VERT.
Scale 1" = 100'-0" HORIZ.

Job No. 10977

Date NOV. 19, 1987

THE WATER'S EDGE

WATER DISTRIBUTION SYSTEM PLAN AND PROFILES

Rev.	Description	Date	By
2	REVISED	5/6/88	KEM
1	DESIGN ISSUE	3/11/88	KEM
0	DESIGN ISSUE	11/19/87	KEM

Sheet No.

202

File No.