

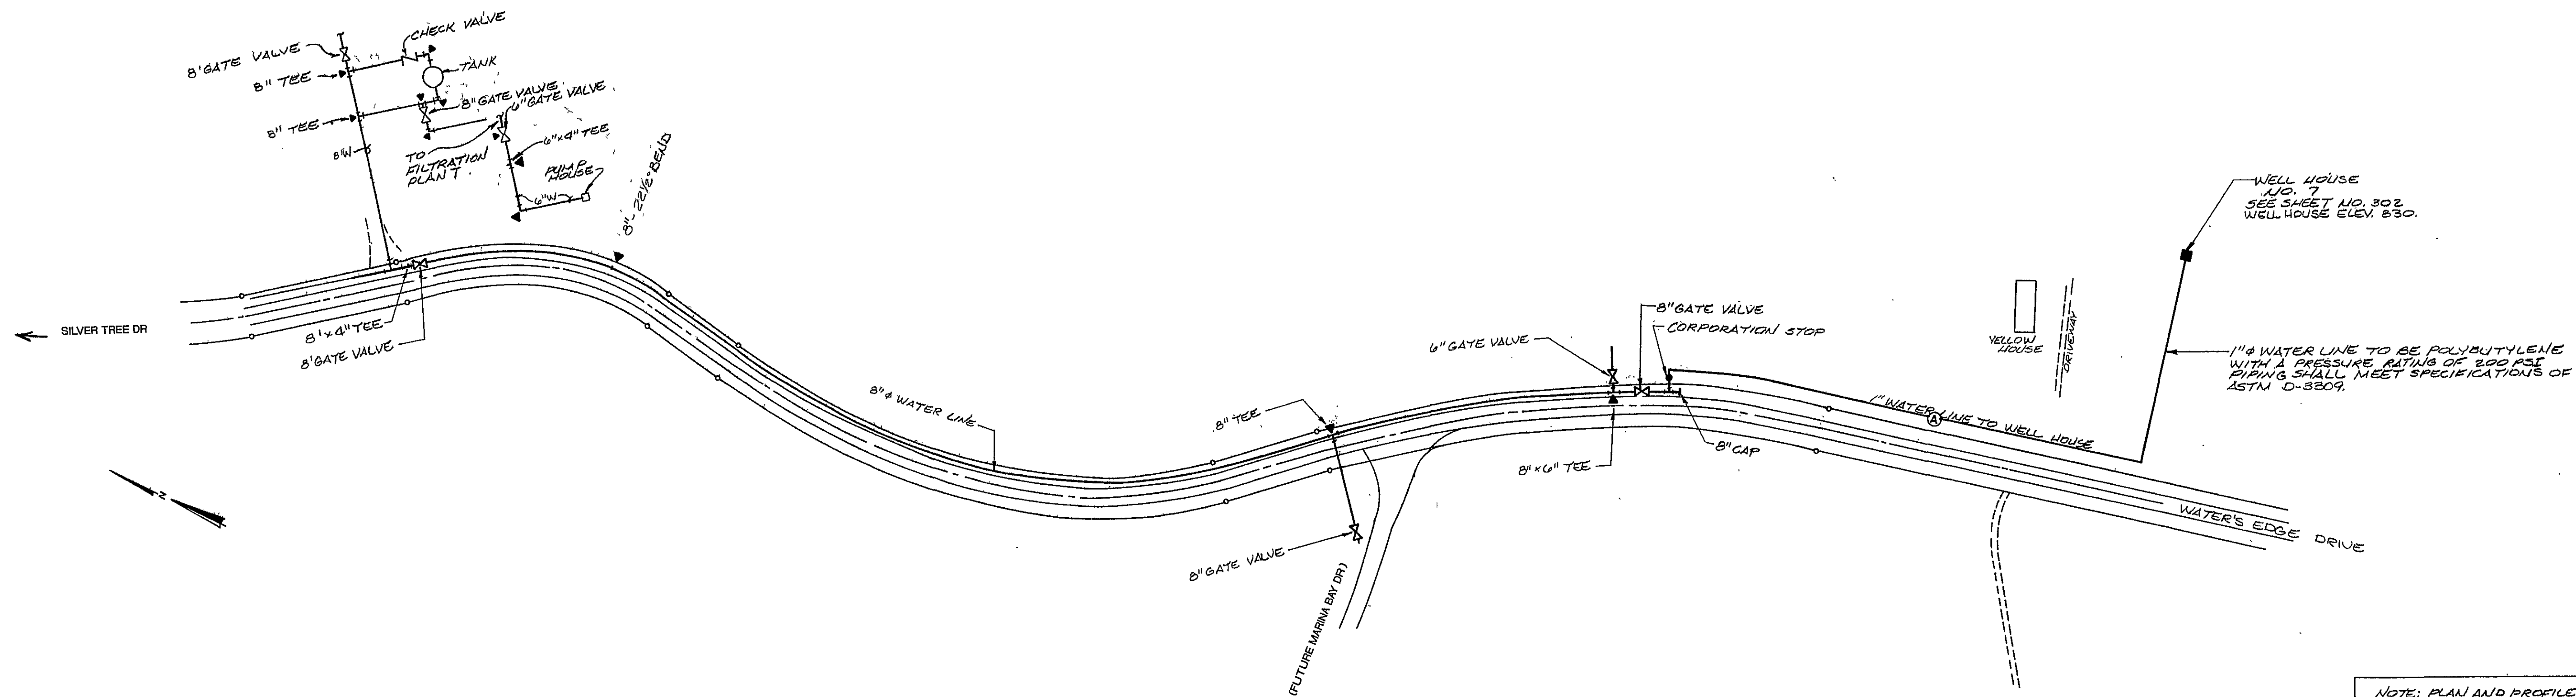


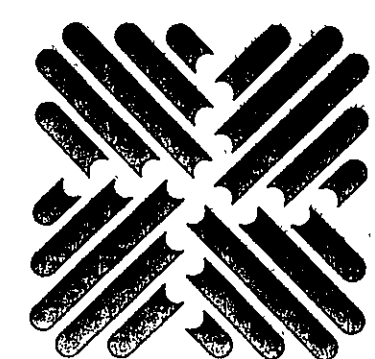

NOTE: PLAN AND PROFILE SHOWN ARE APPROXIMATE. CONTRACTOR SHALL MAINTAIN A MINIMUM 3' OF COVER ABOVE BELL OF PIPE.

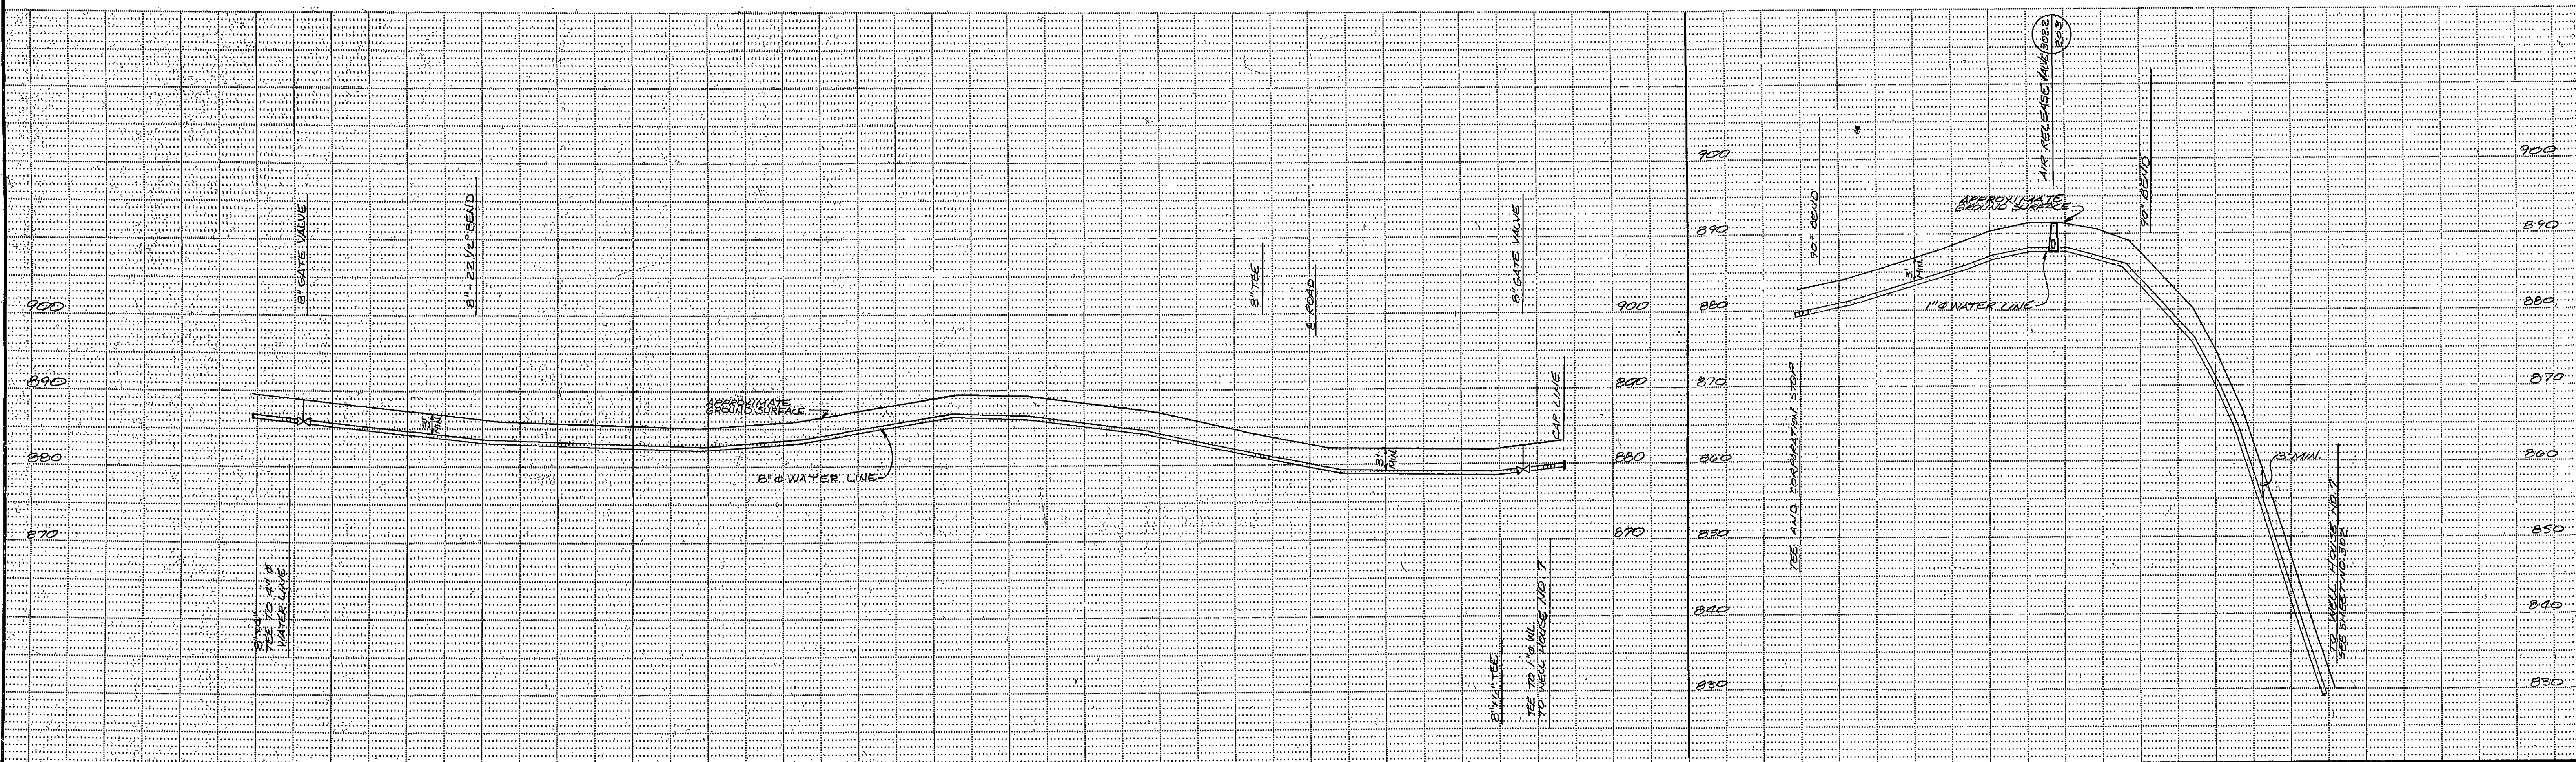

OLVER INCORPORATED
Consulting Engineers • Environmental Laboratories

1531 NORTH MAIN STREET
BLACKSBURG, VIRGINIA 24060

(703) 552-5548

Designed KEM
Drawn CWC/TLP
Checked PBH

1"=10'-0" VERT.
Scale 1"=100'-0" HORIZ.
Job No. 10977
Date NOV. 19, 1987

THE WATER'S EDGE

WATER DISTRIBUTION SYSTEM PLAN AND PROFILES

Rev.	Description	Date	By
2	REVISED	5/6/88	KEM
1	DESIGN ISSUE	3/11/88	KEM
0	DESIGN ISSUE	11/19/87	KEM

Sheet No.

203

File No.