
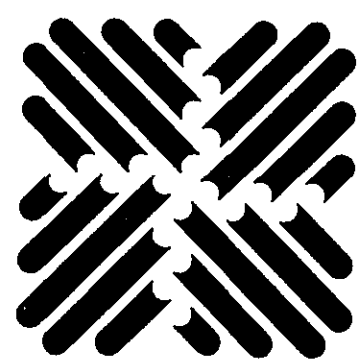
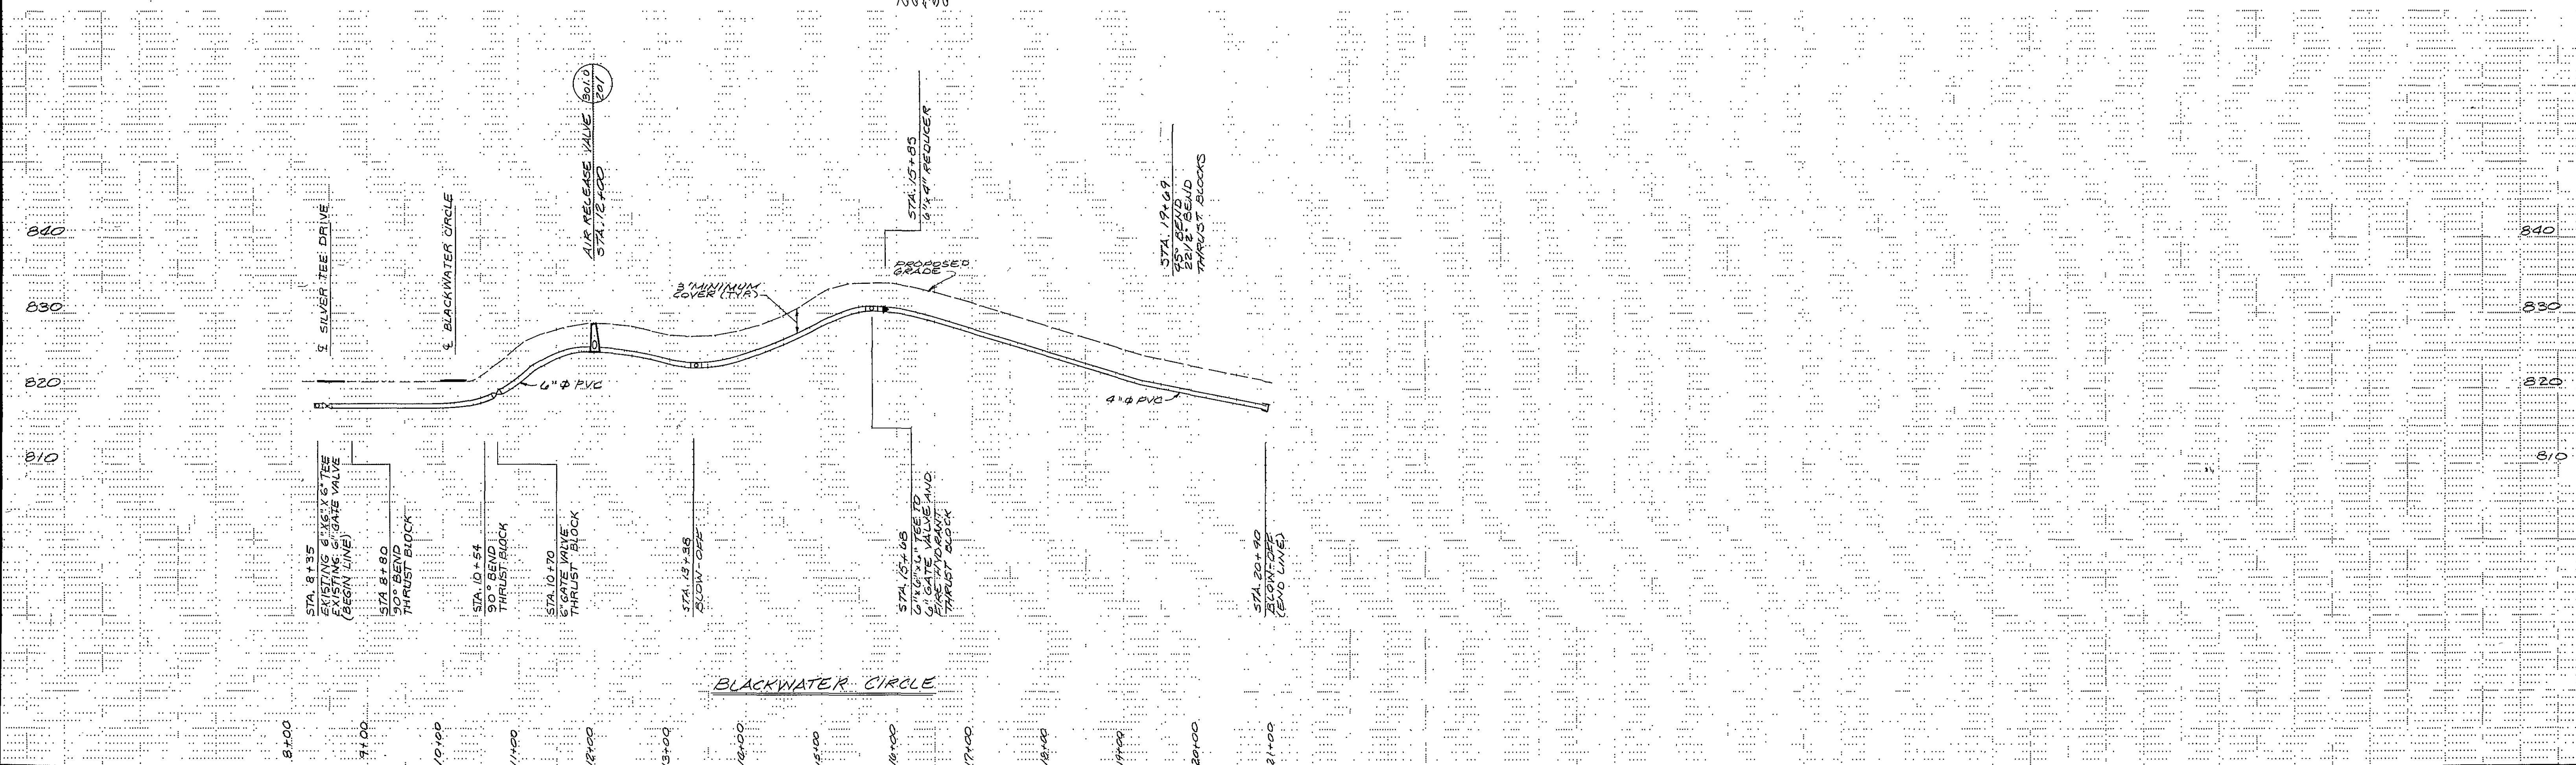
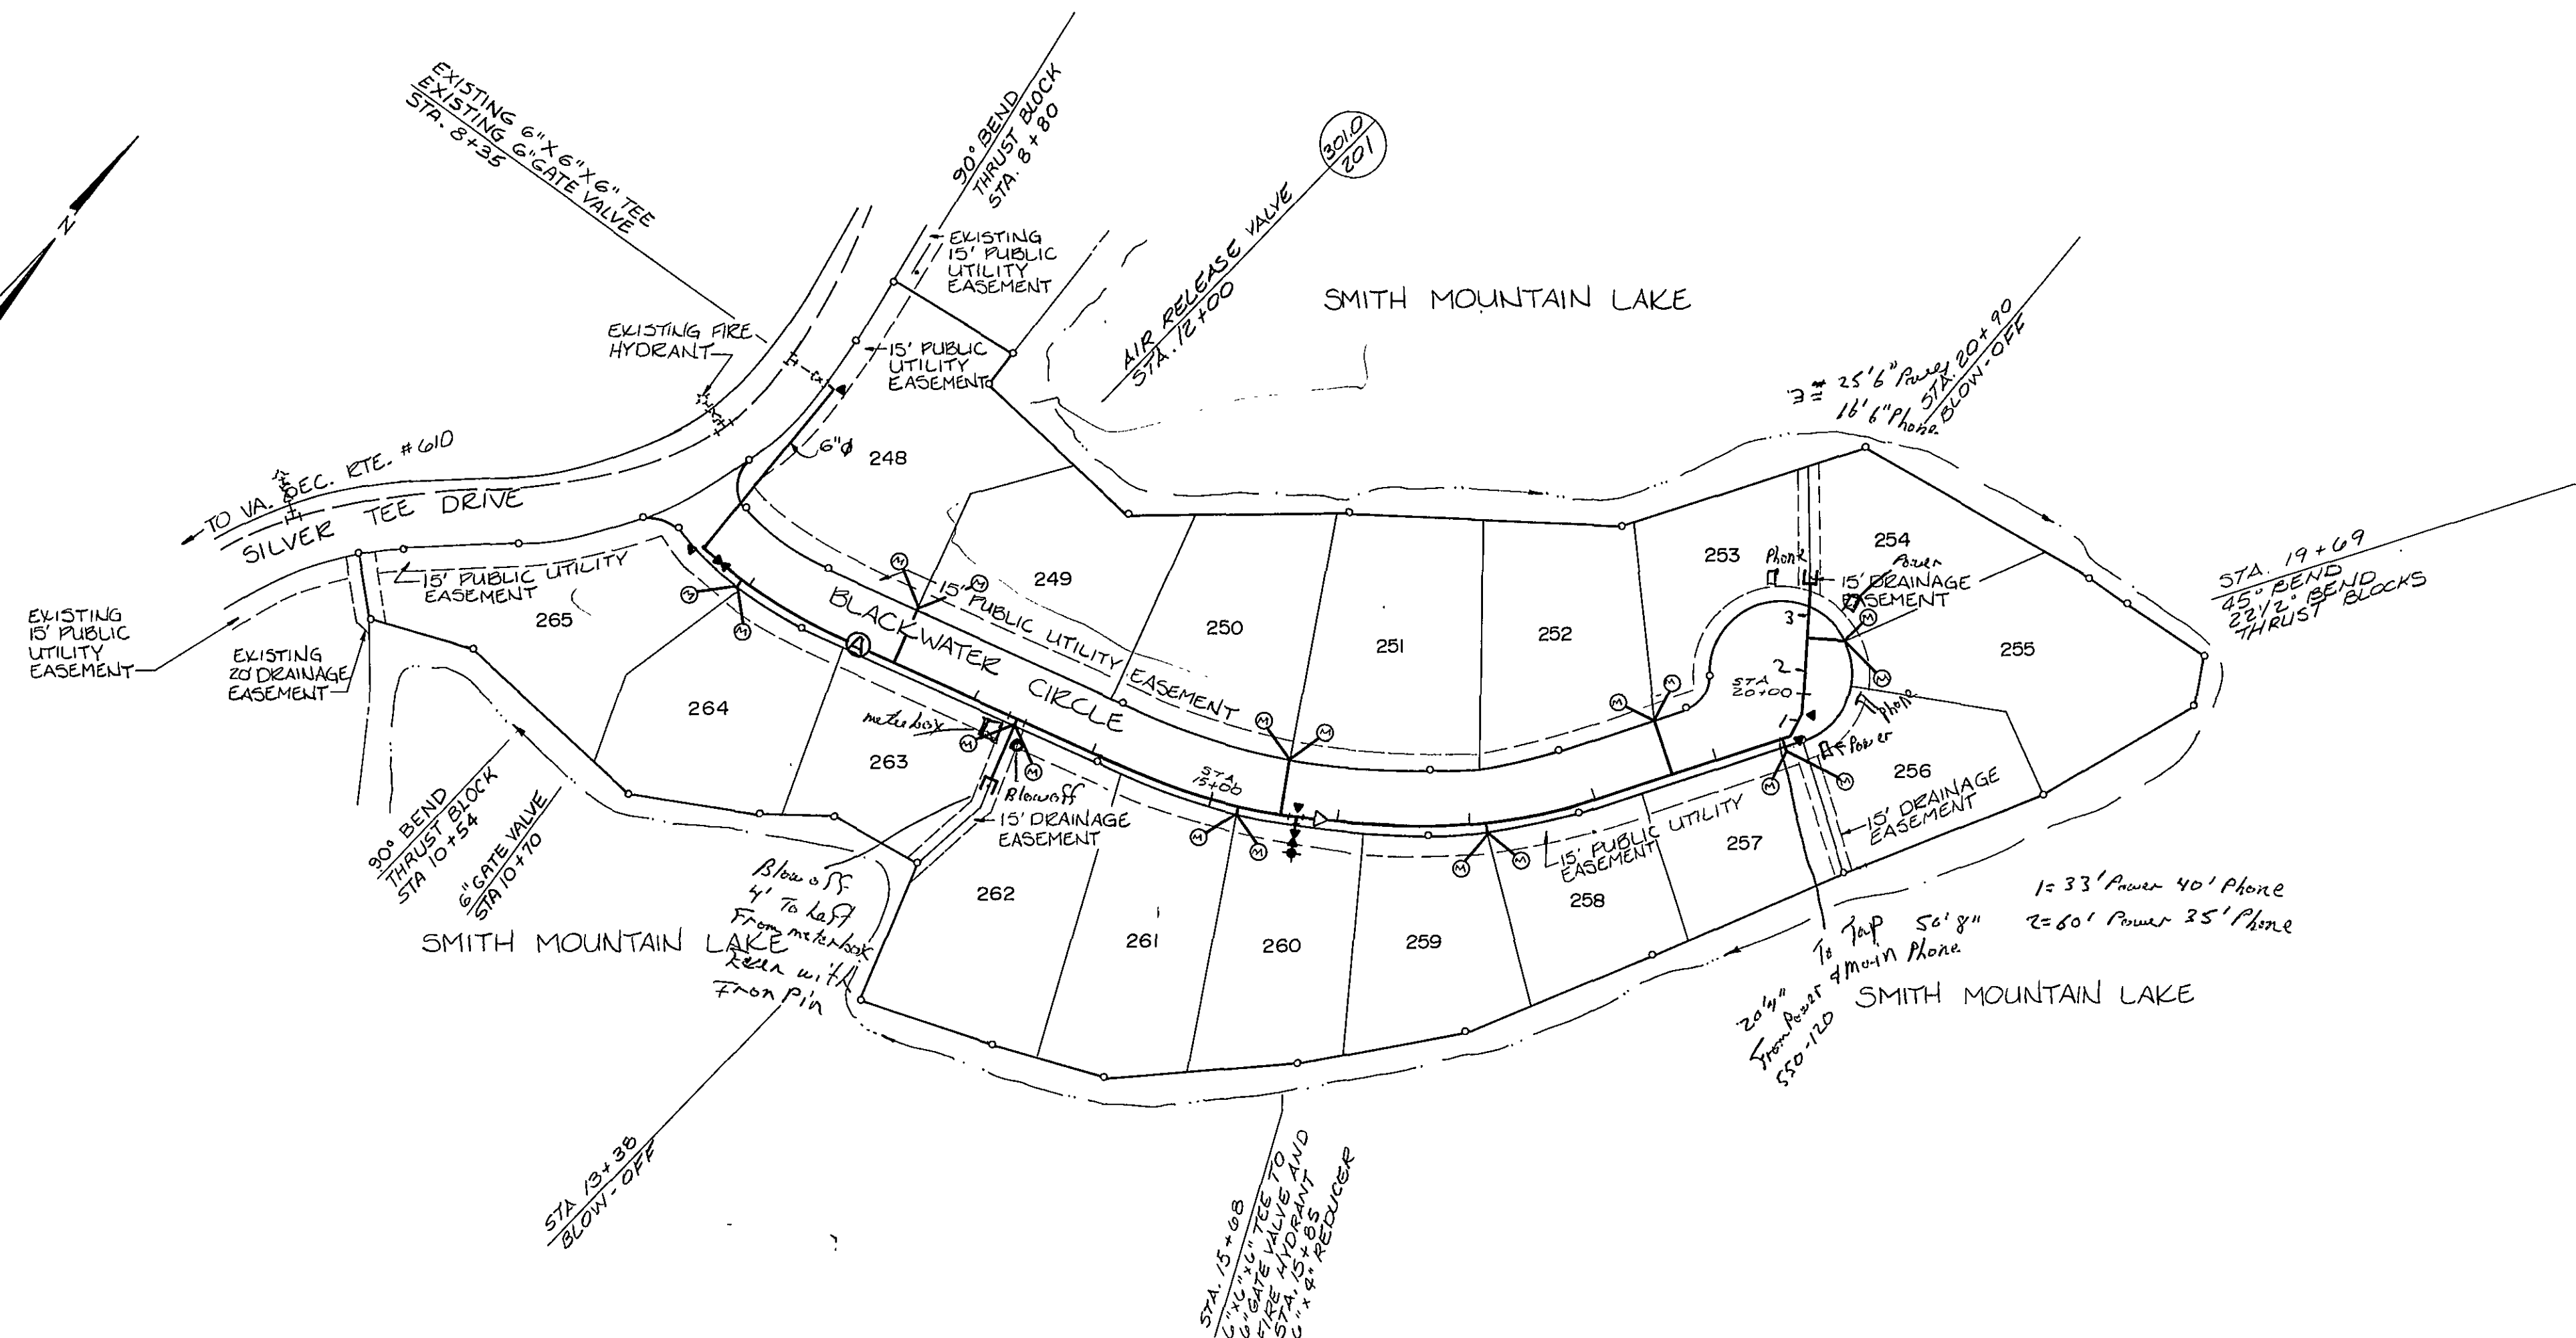


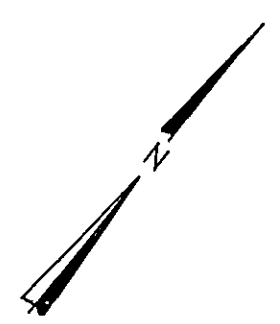

OLVER INCORPORATED
Consulting Engineers • Environmental Laboratories

1116 SOUTH MAIN STREET
BLACKSBURG, VIRGINIA 24060

(703) 552-5548

Designed KEM

Drawn CWC

Checked PBH

1" = 10'-0" VERT.
Scale 1" = 100'-0" HORIZ.

Job No. 10979

Date APR. 8, 1988

THE WATER'S EDGE WATER DISTRIBUTION SYSTEM

PLAN AND PROFILE

Rev.		Description	Date	By
1		REVISED	5/6/88	KEM
0		DESIGN ISSUE - SECTION V	4/8/88	KEM

Sheet No.		201	
File No.			