
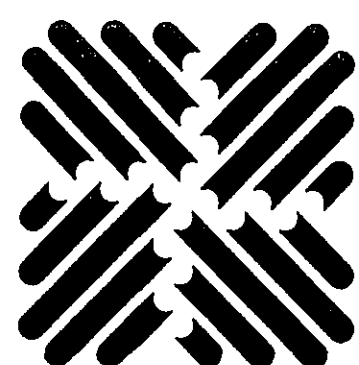
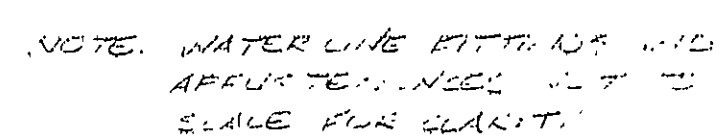


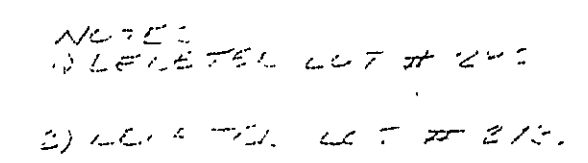

OLVER INCORPORATED
Consulting Engineers • Environmental Laboratories

1116 SOUTH MAIN STREET
BLACKSBURG, VIRGINIA 24060

(703) 552-5548

Designed PBH

Drawn CWC/OPM

Checked KEM

$$I'' = IO' - O'' \text{ VERT.}$$

Scale 1" = 100'-0" HORIZ.

Job No. 10980

Date SEPT. 20, 1988

THE WATER'S EDGE WATER DISTRIBUTION SYSTEM

PLAN AND PROFILE

2	REVISED--LOT REVISIONS	7/07/89	PBH
1	DESIGN ISSUE - SECTION VI	11/15/88	RMR
0	DESIGN ISSUE - SECTION VI	9/20/88	KEM
Rev.	Description	Date	By

Sheet No.

202

File No.