




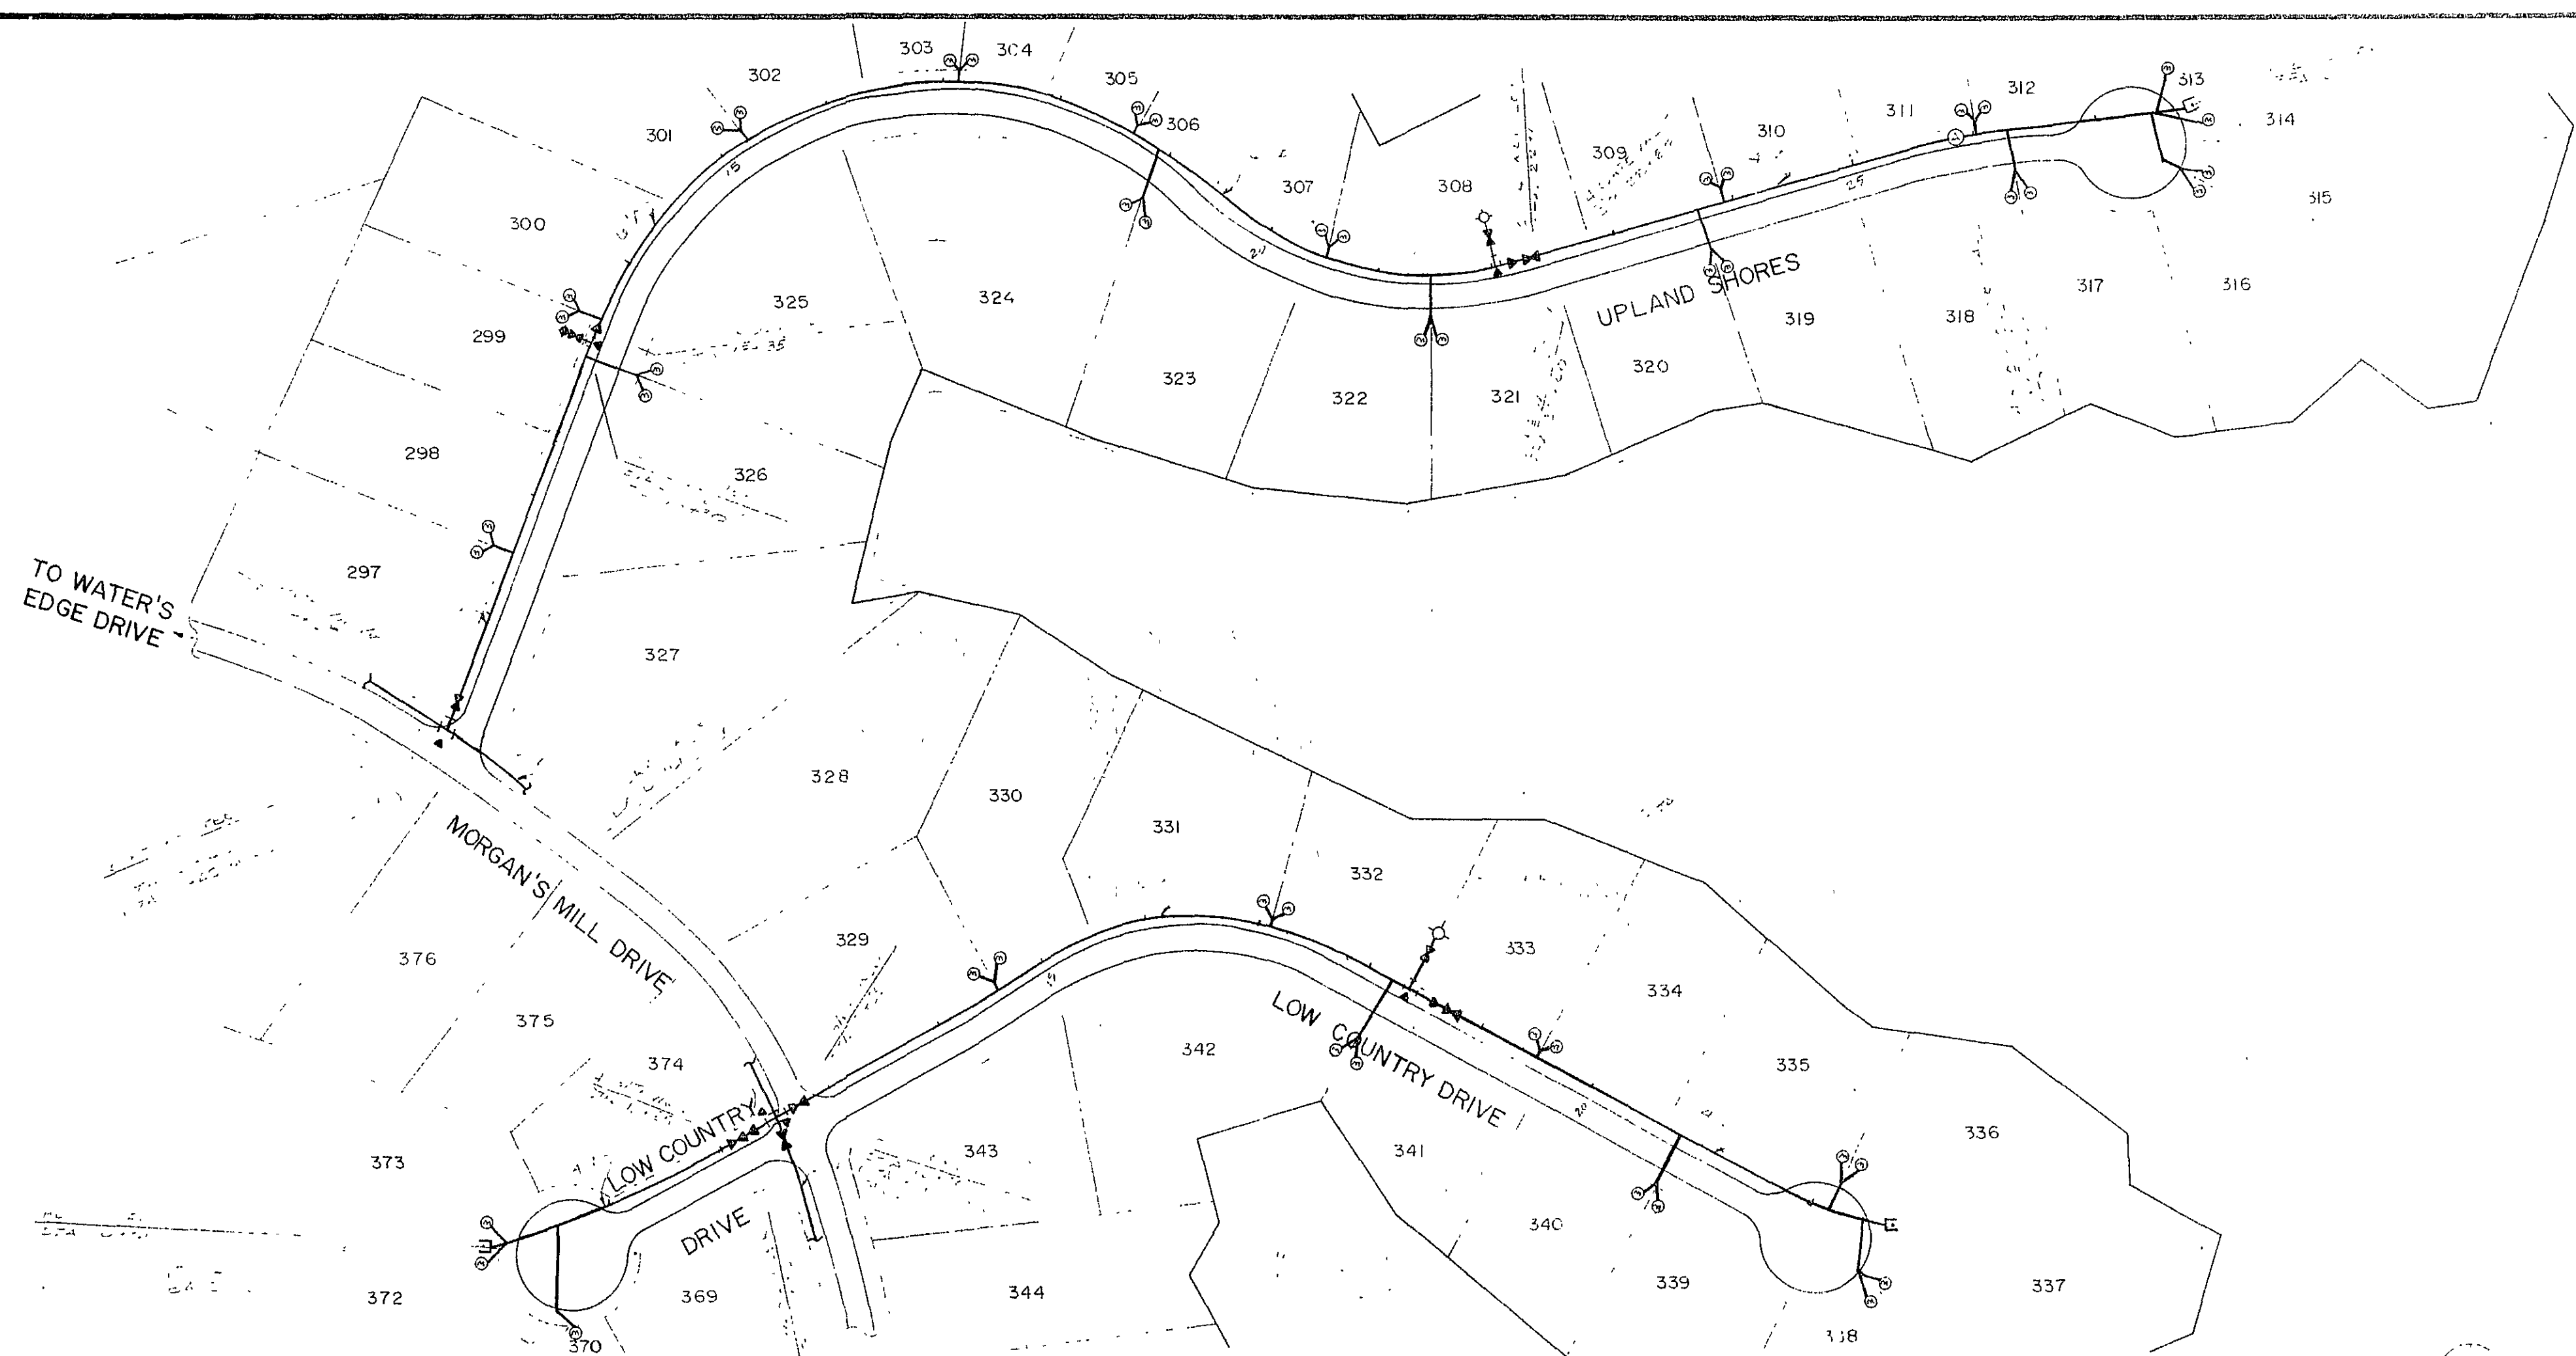

NOTE WATER LINE FITTINGS AND
APPROXIMATELY 1/2" TO
SCALE FOR 1/4" DIA.

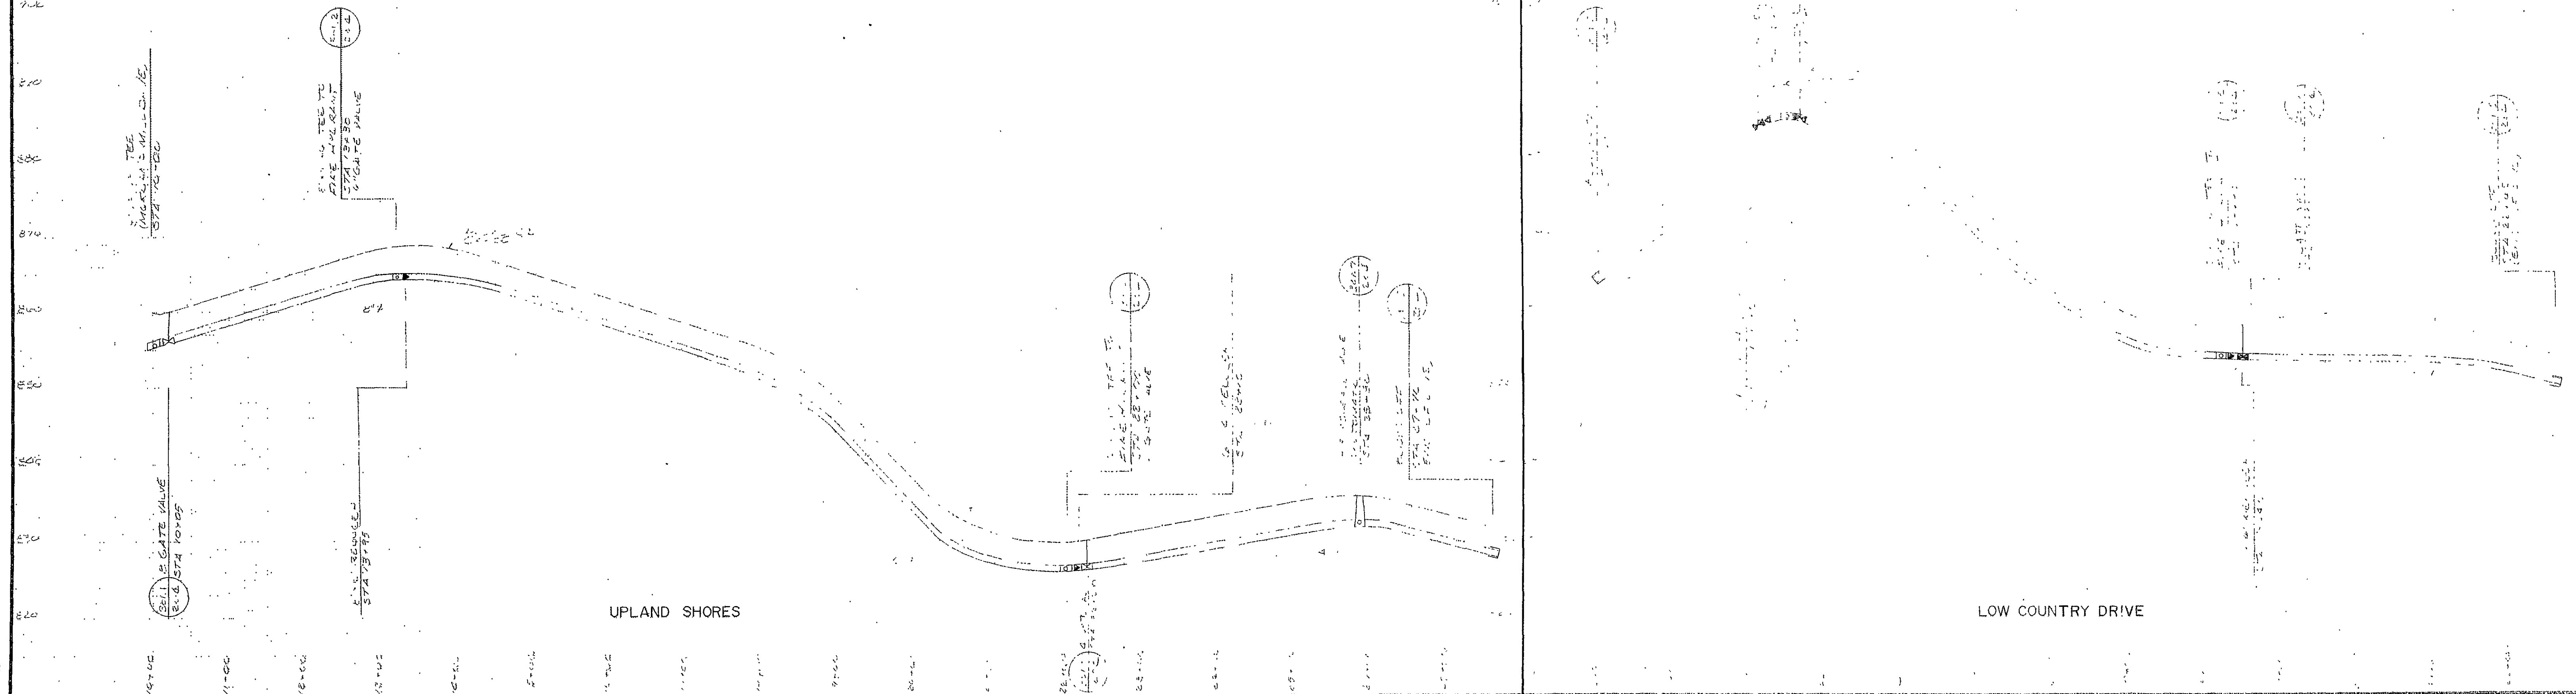

DRAFTING & TECHNICAL SUPPLIES 44-232-73519

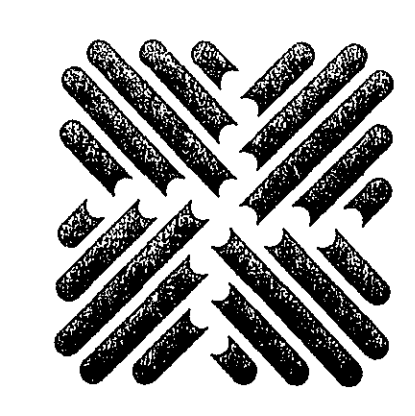

OLVER INCORPORATED
Consulting Engineers • Environmental Laboratories
1116 SOUTH MAIN STREET
BLACKSBURG, VIRGINIA 24060
(703) 552-5548

Designed PBH
Drawn CWC/OPM
Checked KEM

Scale 1" = 10' - 0" VERT.
1" = 100' - 0" HORIZ.
Job No. 10980
Date SEPT. 20, 1988

**THE WATER'S EDGE
WATER DISTRIBUTION SYSTEM**

PLAN AND PROFILE

Rev	Description	Date	By
2	REVISED-LOT REVISIONS	7/07/89	PBH
1	DESIGN ISSUE - SECTION VI	11/15/88	RMR
0	DESIGN ISSUE - SECTION VI	9/20/88	KEM

Sheet No.
204
File No.