



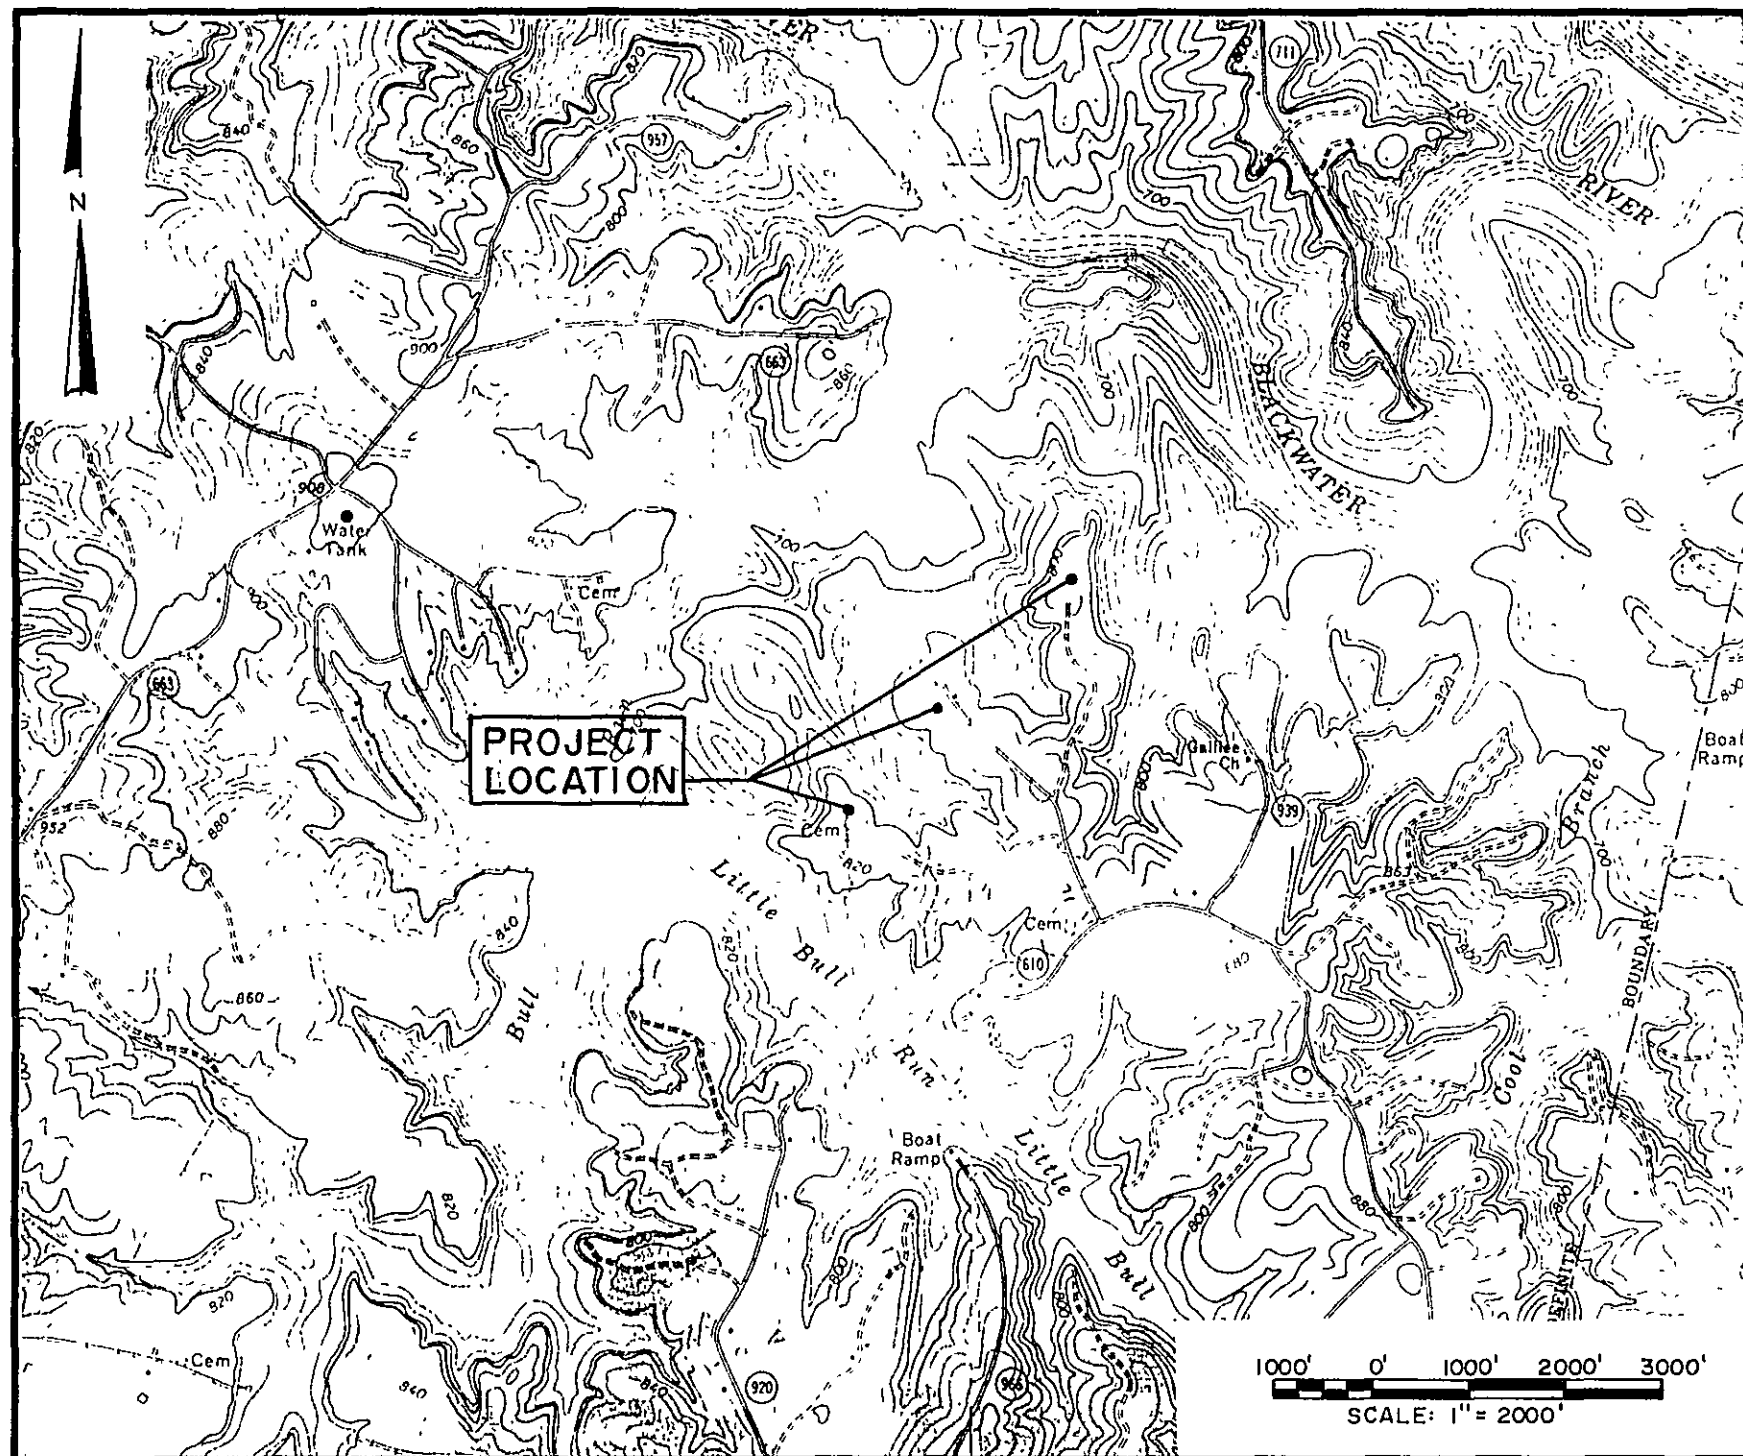

LOCATION MAP

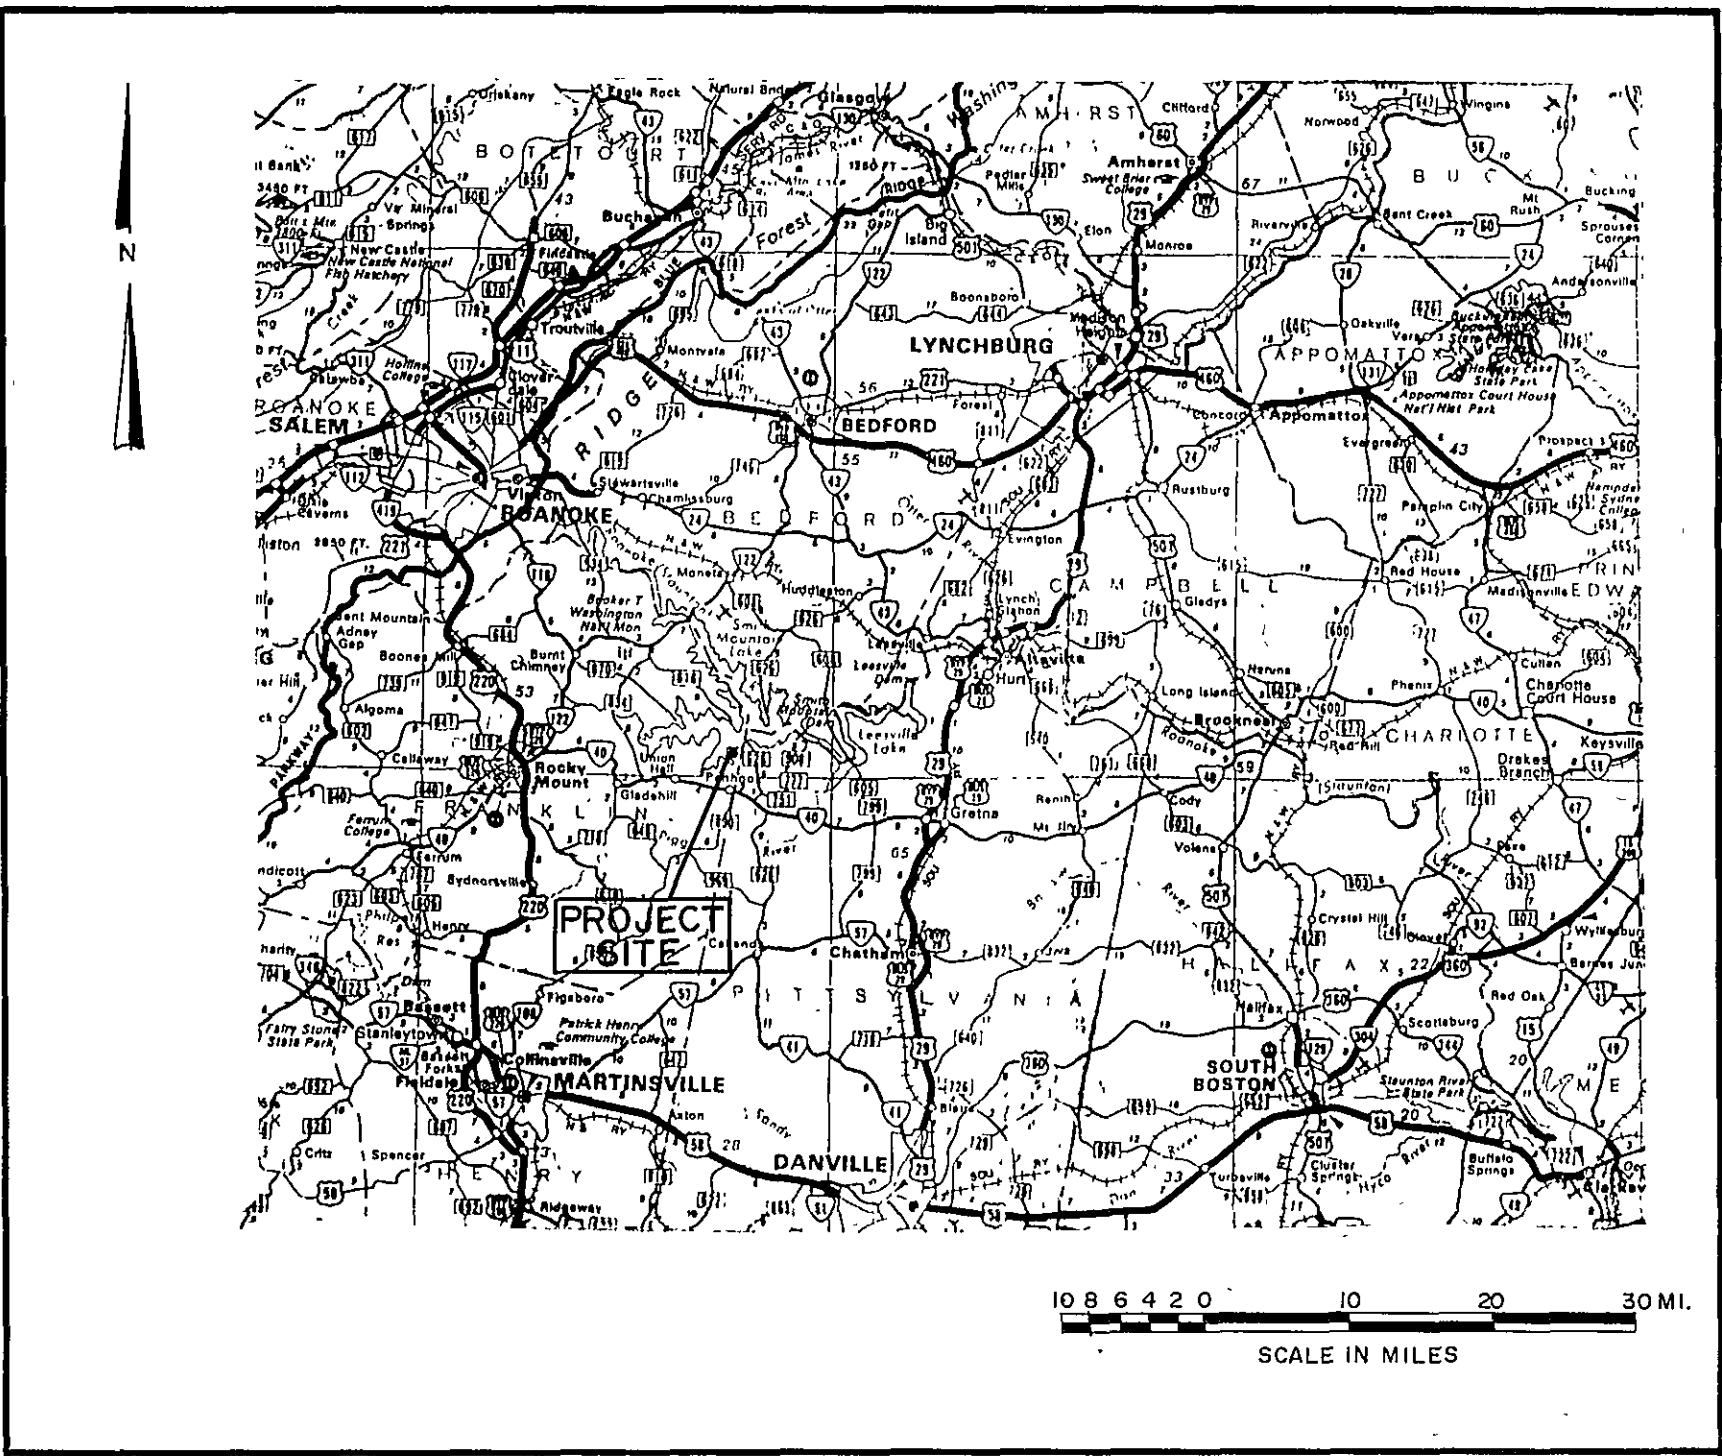

VICINITY MAP

WILLARD CONSTRUCTION OF ROANOKE VALLEY, INC. THE WATER'S EDGE WATER DISTRIBUTION SYSTEM

TABLE OF CONTENTS	
SHEET NO.	DESCRIPTION
101	TITLE SHEET
102	DEVELOPMENT PLAN
103	WELL HOUSE AND WATER TANK
201	PLAN AND PROFILES
202	PLAN AND PROFILES
203	PLANS AND PROFILES
204	PLAN AND PROFILES
205	PLAN AND PROFILES
206	PLAN AND PROFILES
301	DETAILS


301.1
201

301 REPRESENTS THE SHEET NUMBER ON WHICH THE DETAIL IS DRAWN

1 REPRESENTS THE DETAIL NUMBER ON THAT SHEET

201 REPRESENTS THE SHEET NUMBER FROM WHICH THE DETAIL OR SECTION WAS CUT OR TAKEN

LEGEND	ABBREVIATIONS
— WATER LINE	CL CENTERLINE
— BASE LINE	CMP CORRUGATED METAL PIPE
— PROPERTY LINE	D.B. DEED BOOK
— PIPE PROFILE	EL ELEVATION
▲ THRUST BLOCK	ESMT EASEMENT
⊕ WATER VALVE	G.V. GATE VALVE
⊕ FIRE HYDRANT	DIA. ∅ DIAMETER
⊕ WATER METER	INV INVERT
— UNDERGROUND PIPE - SECTION	PVMT PAVEMENT
● DROP INLET	STA STATION
— PIPE TEE	TYR TYPICAL
EG-1, TYPE "A" EROSION CONTROL STONE	
→ SLOPES DOWN	
⊕ COMBINATION AIR RELEASE VALVE	

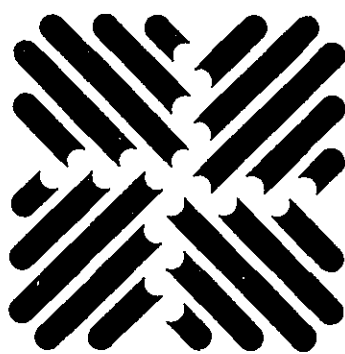

OLVER INCORPORATED
Consulting Engineers • Environmental Laboratories

1531 NORTH MAIN STREET
BLACKSBURG, VIRGINIA 24060

(703) 552-5548

Designed WCK

Drawn RLP

Checked KEM

Scale NO SCALE

Job No. 10645

Date JULY 23, 1985

THE WATER'S EDGE

TITLE SHEET

3	VDH SUBMITTAL	8/27/86	WCK
2	VDH SUBMITTAL	7/31/86	WCK
1	VDH SUBMITTAL	6/20/86	WCK
0	DESIGN ISSUE	7/23/85	WCK
Rev.	Description	Date	By