
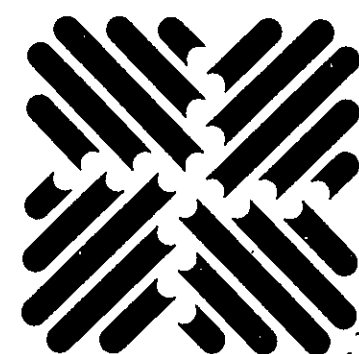
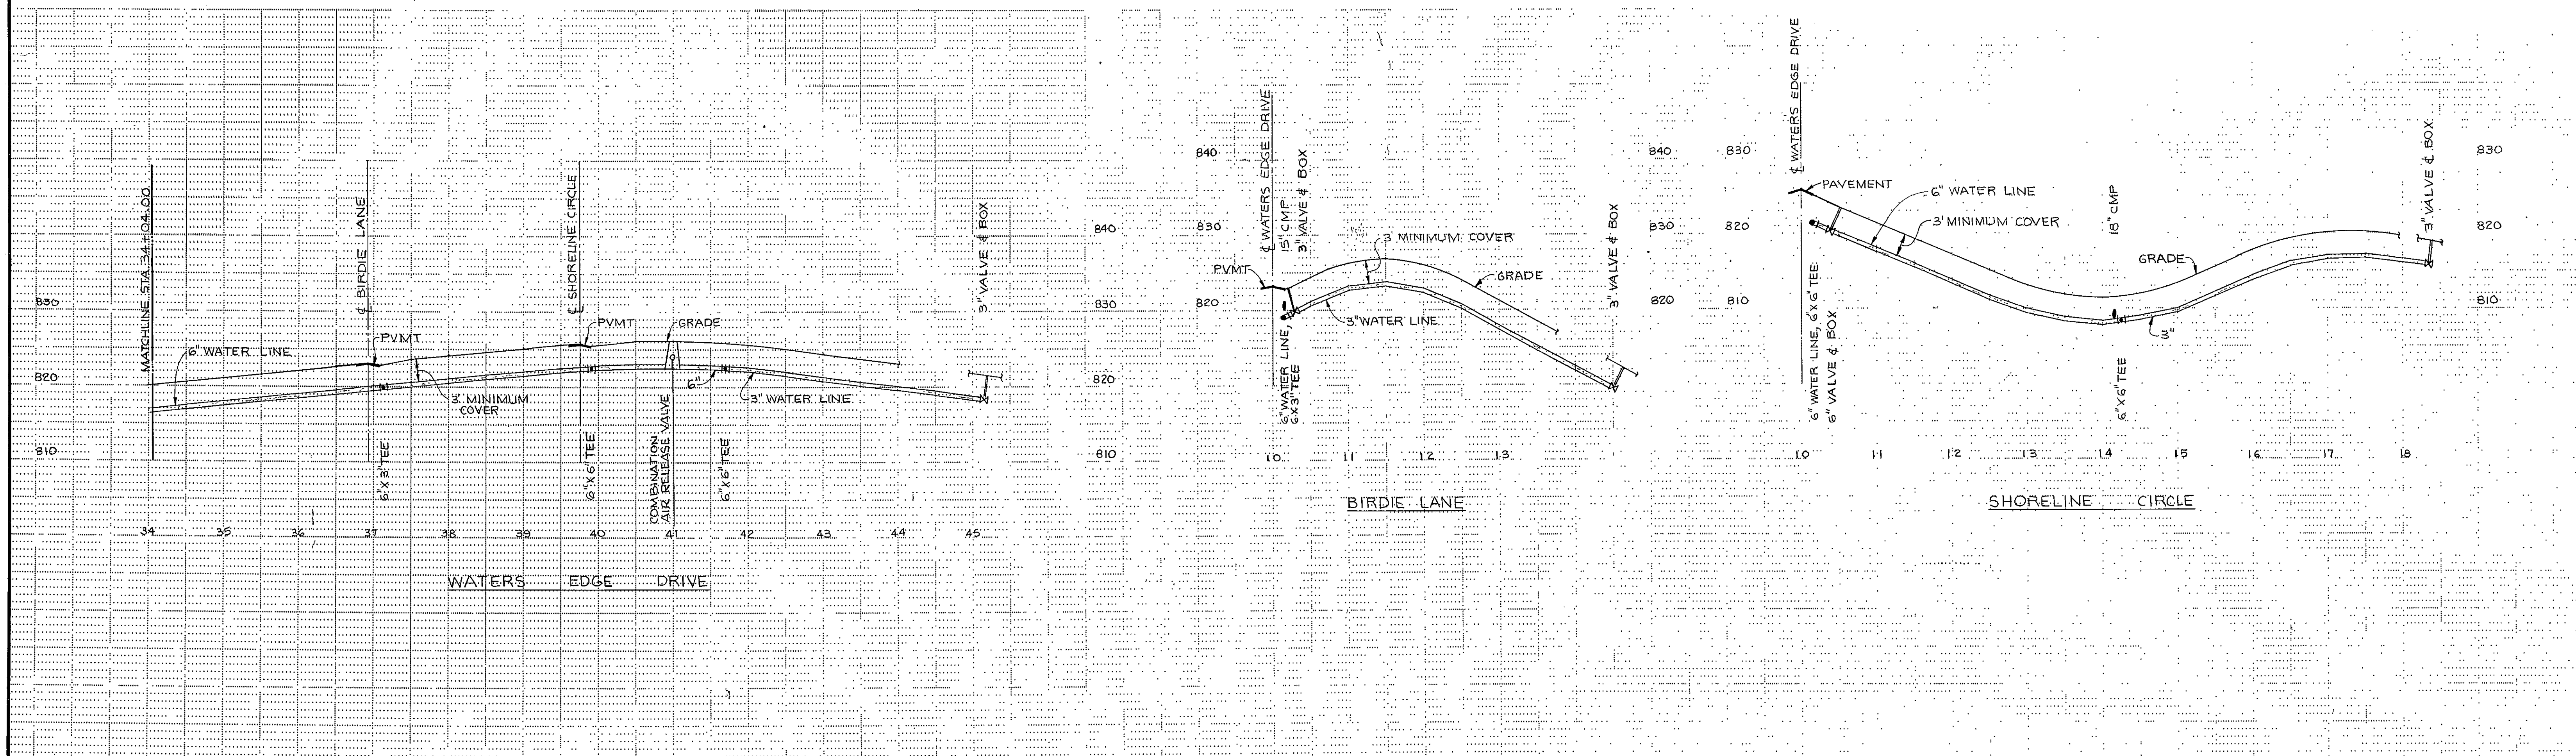


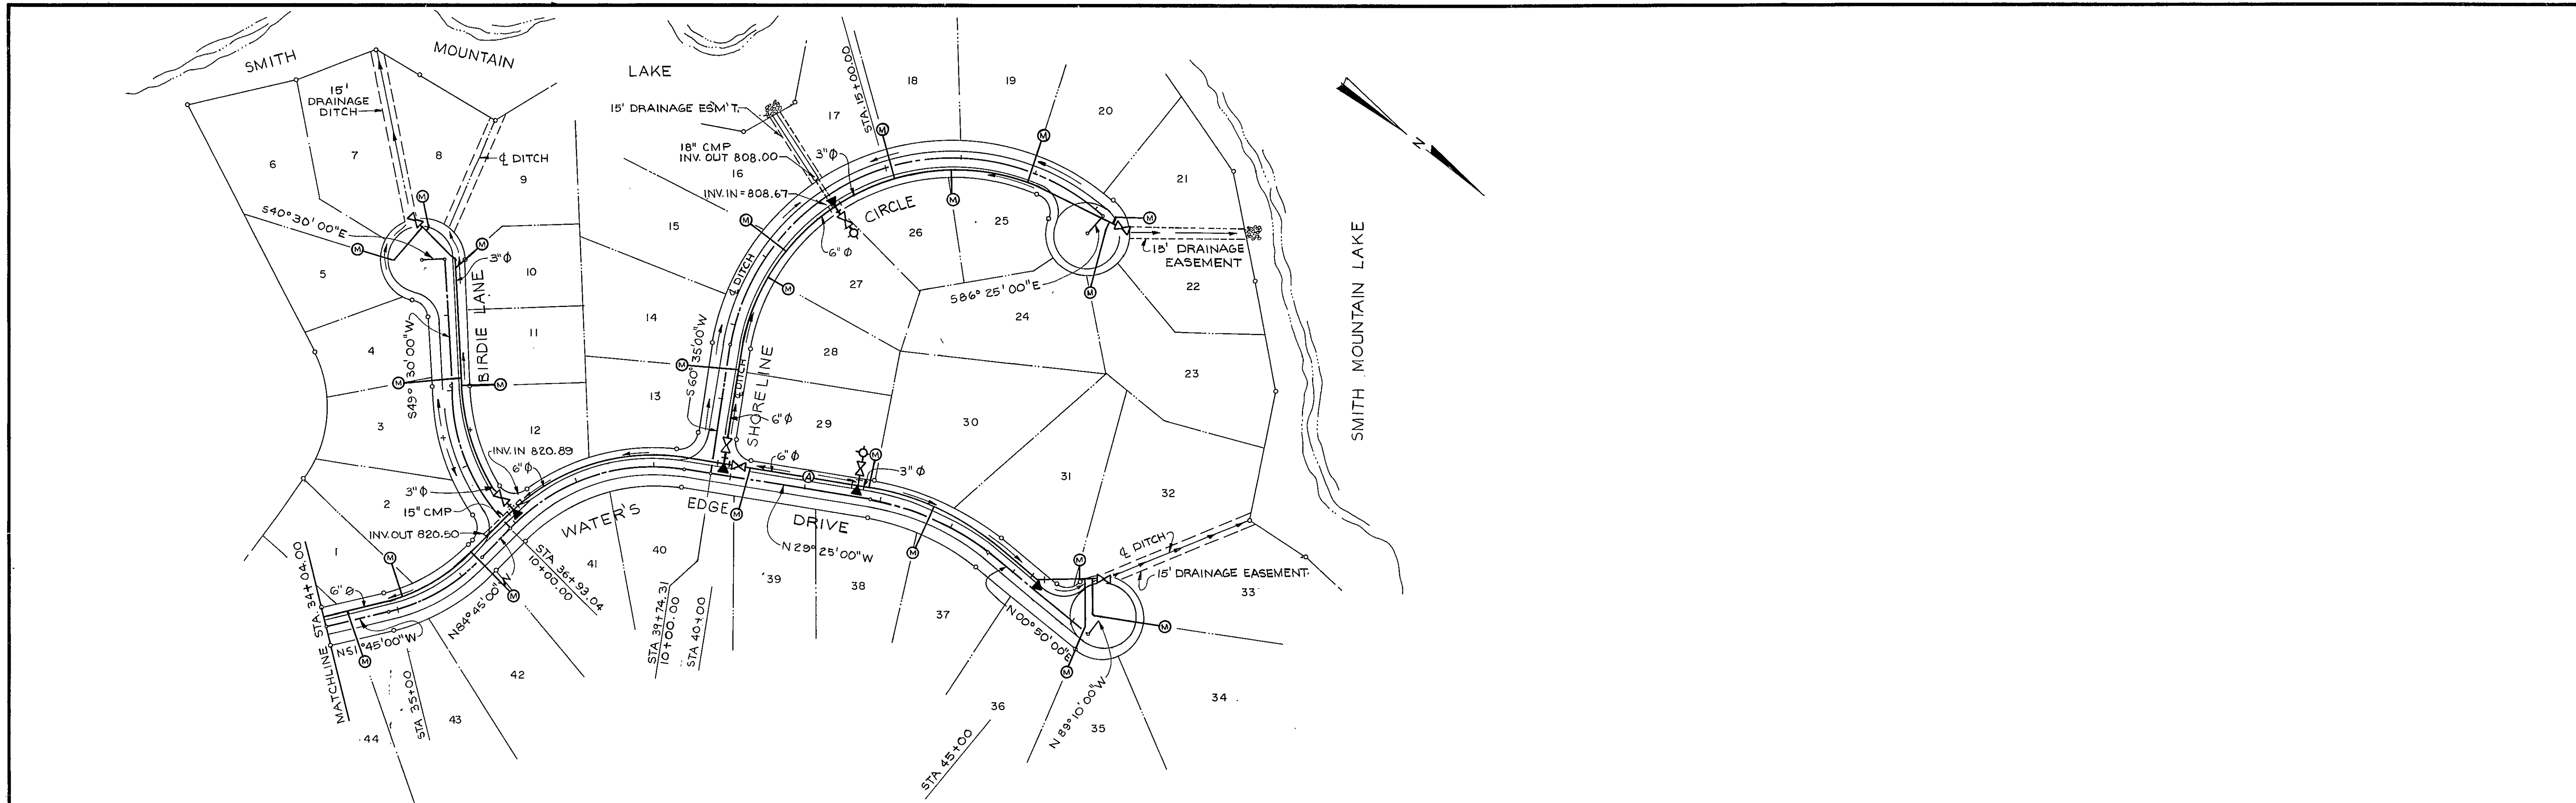

OLVER INCORPORATED
Consulting Engineers • Environmental Laboratories

1531 NORTH MAIN STREET
BLACKSBURG, VIRGINIA 24060

(703) 552-5548

Designed WCK

Drawn WFT

Checked KEM

1" = 10' - 0" VERT.
Scale 1" = 100' - 0" HORIZ.

Job No. 10645

Date JULY 23, 1985

THE WATER'S EDGE

WATER DISTRIBUTION SYSTEM PLAN AND PROFILES

Rev.	Description	Date	By
2	VDH SUBMITTAL	8/27/86	WCK
1	VDH SUBMITTAL	6/20/86	WCK
0	DESIGN ISSUE	7/23/85	WCK

Sheet No.

202

File No.