
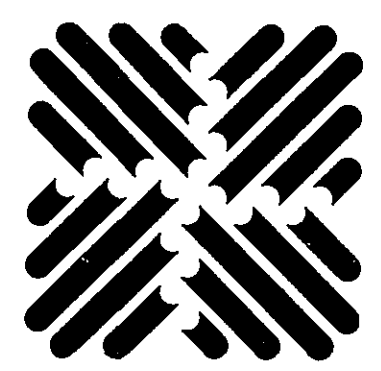
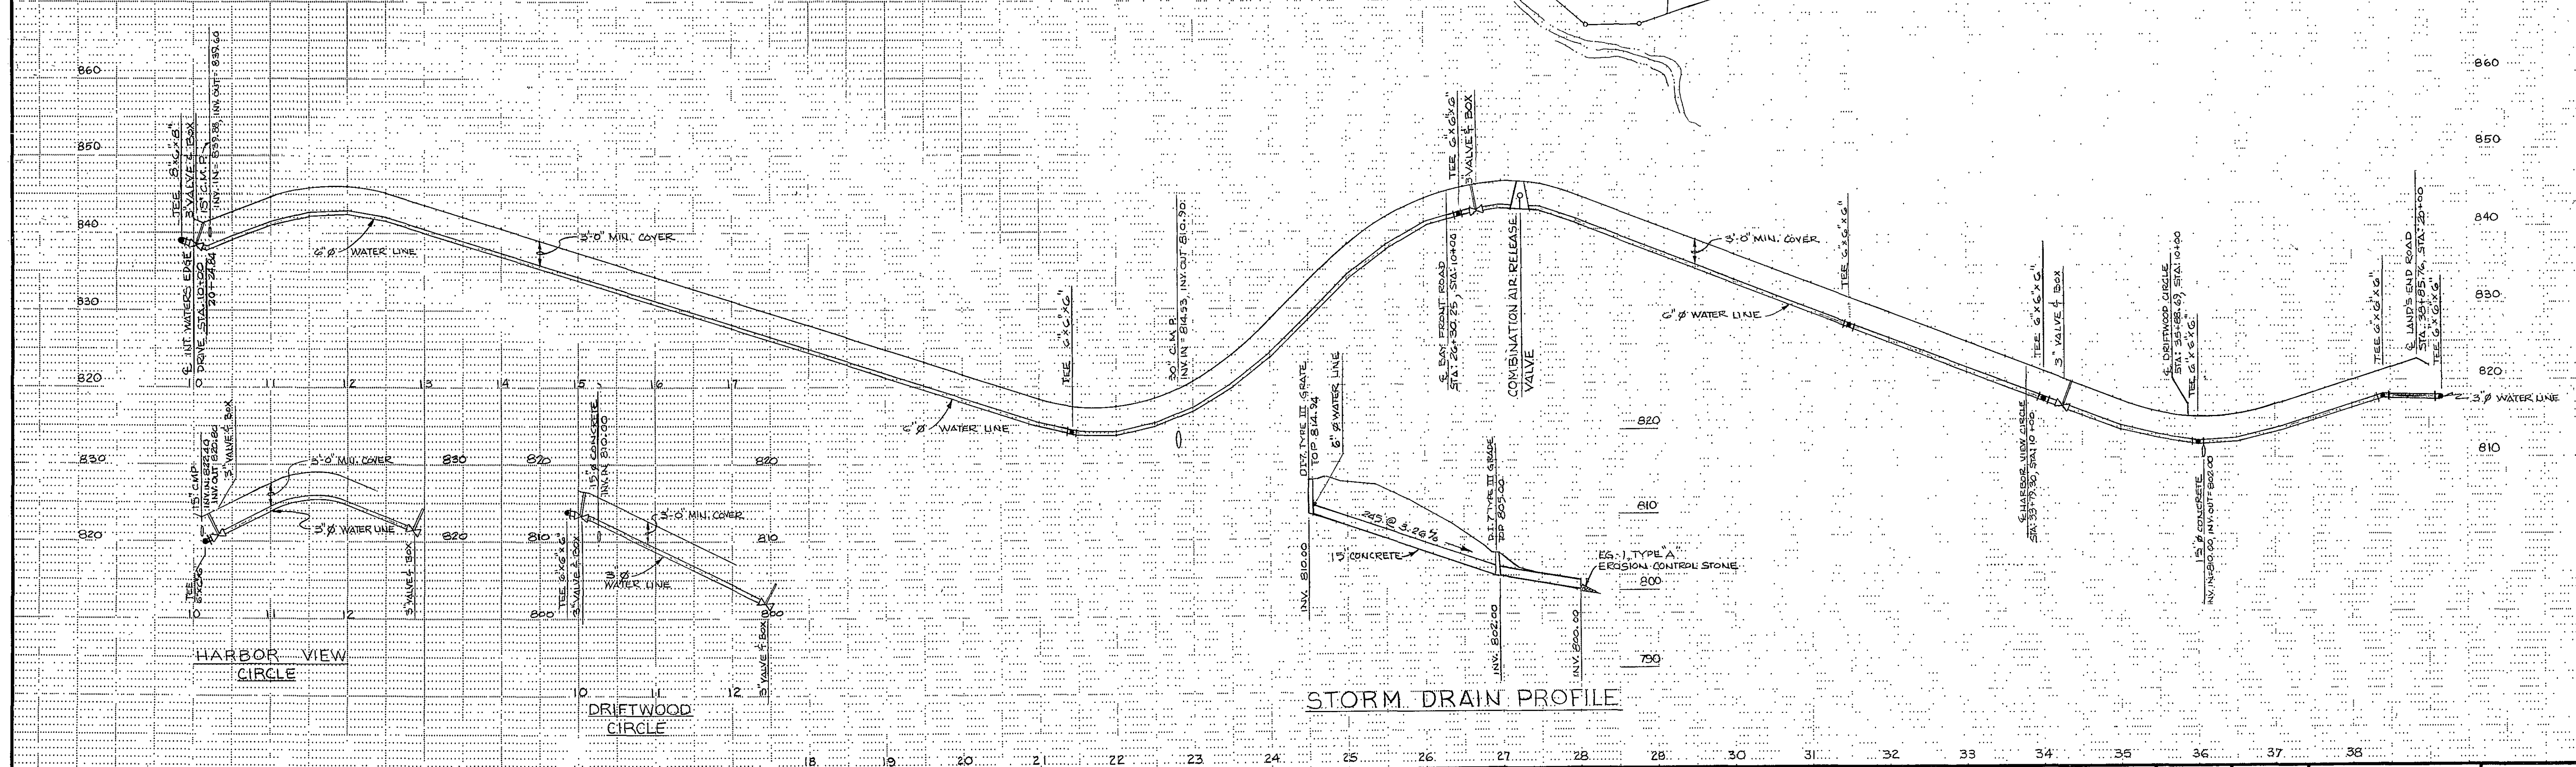


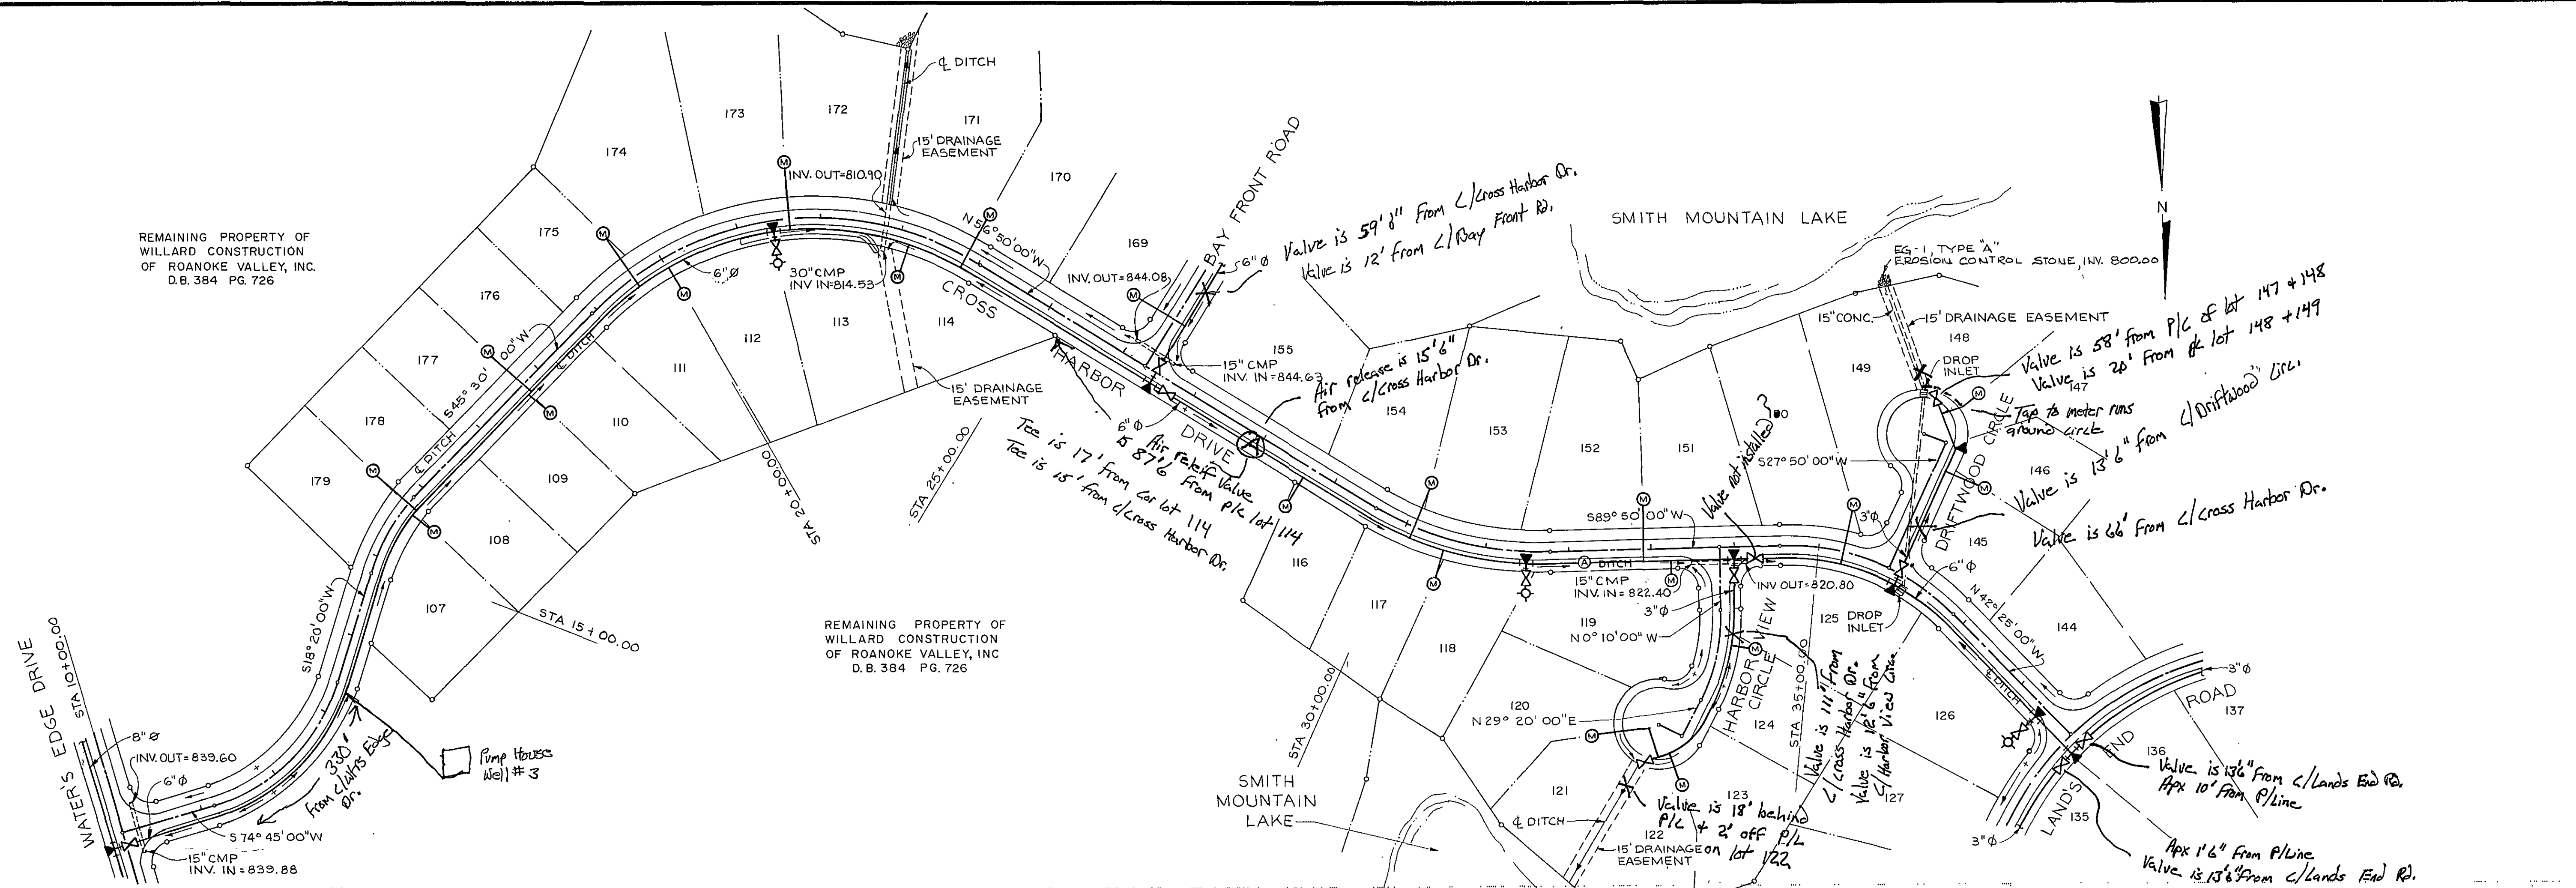

OLVER INCORPORATED
 Consulting Engineers • Environmental Laboratories
 1531 NORTH MAIN STREET
 BLACKSBURG, VIRGINIA 24060
 (703) 552-5548

Designed WCK
 Drawn WFT
 Checked KEM

1" = 10' - 0" VERT.
 Scale 1" = 100' - 0" HORIZ.
 Job No. 10645
 Date JULY 23, 1985

THE WATER'S EDGE
WATER DISTRIBUTION SYSTEM
PLAN AND PROFILES

Rev.	Description	Date	By
2	VDH SUBMITTAL	8/27/86	WCK
1	VDH SUBMITTAL	6/20/86	WCK
0	DESIGN ISSUE	7/23/85	WCK

Sheet No.
203
 File No.