
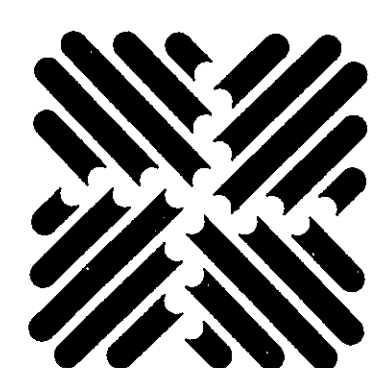
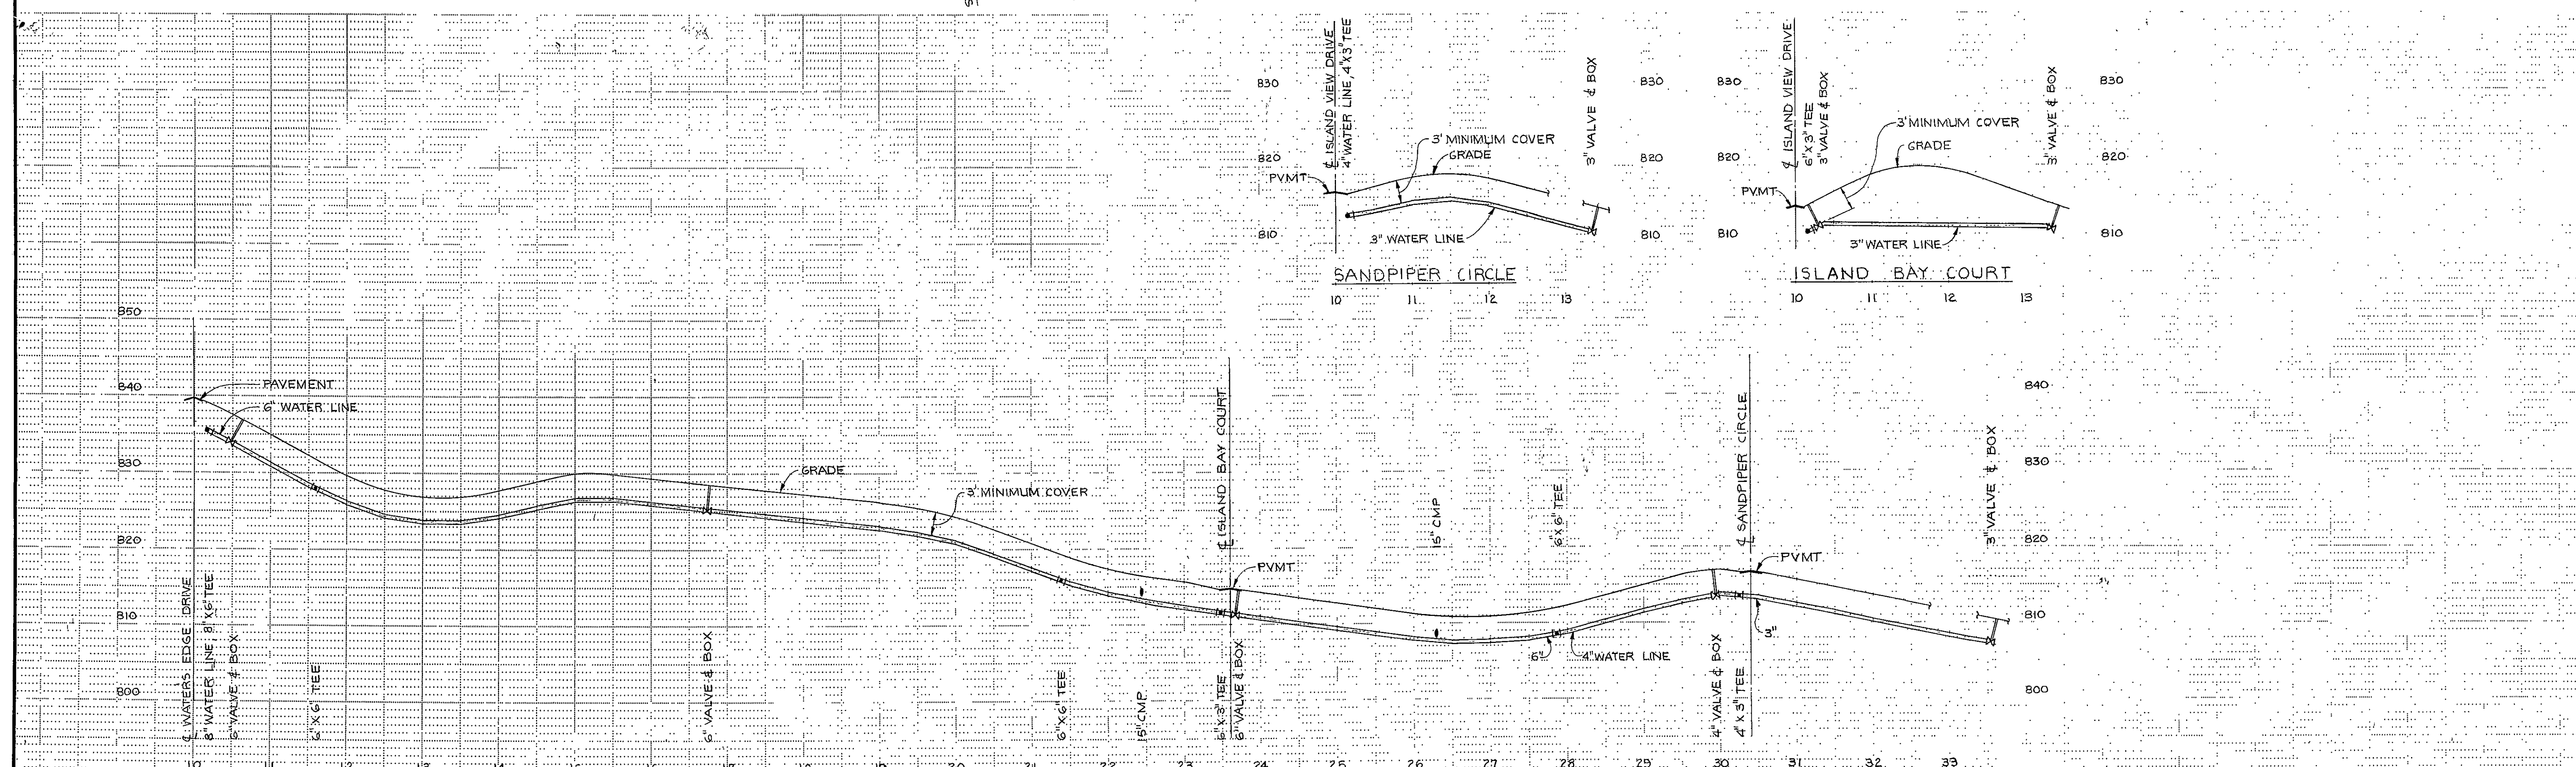


REMAINING PROPERTY OF
WILLARD CONSTRUCTION
OF ROANOKE VALLEY, INC.
D.B. 384 PG. 726

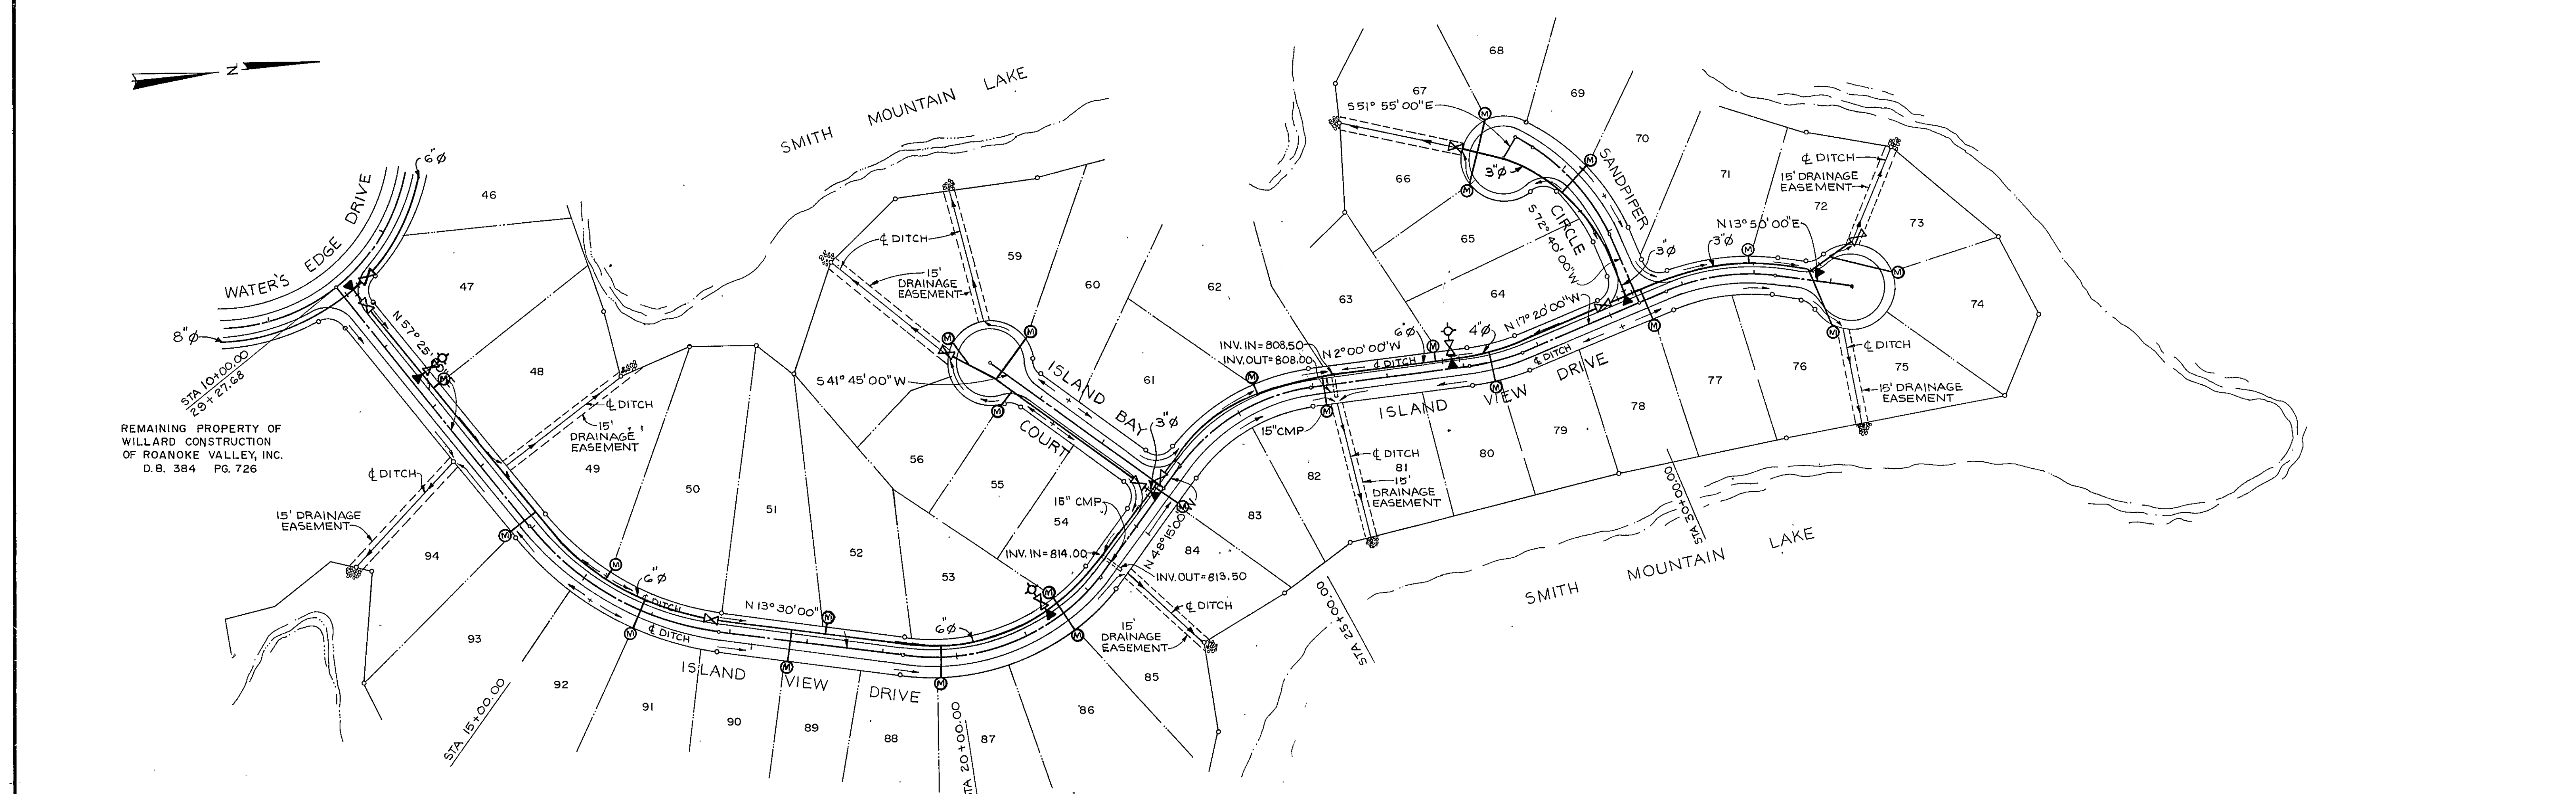

OLVER INCORPORATED
Consulting Engineers • Environmental Laboratories

1531 NORTH MAIN STREET
BLACKSBURG, VIRGINIA 24060 (703) 552-5548

Designed WCK
Drawn WFT
Checked KEM

1" = 10'-0" VERT.
Scale 1" = 100'-0" HORIZ.
Job No. 10645
Date JULY 23, 1985

THE WATER'S EDGE
WATER DISTRIBUTION SYSTEM
PLAN AND PROFILES

Rev.	Description	Date	By
2	VDH SUBMITTAL	8/27/86	WCK
1	VDH SUBMITTAL	6/20/86	WCK
0	DESIGN ISSUE	7/23/85	WCK

Sheet No.
205
File No.