
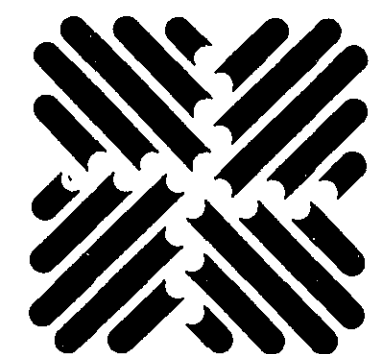
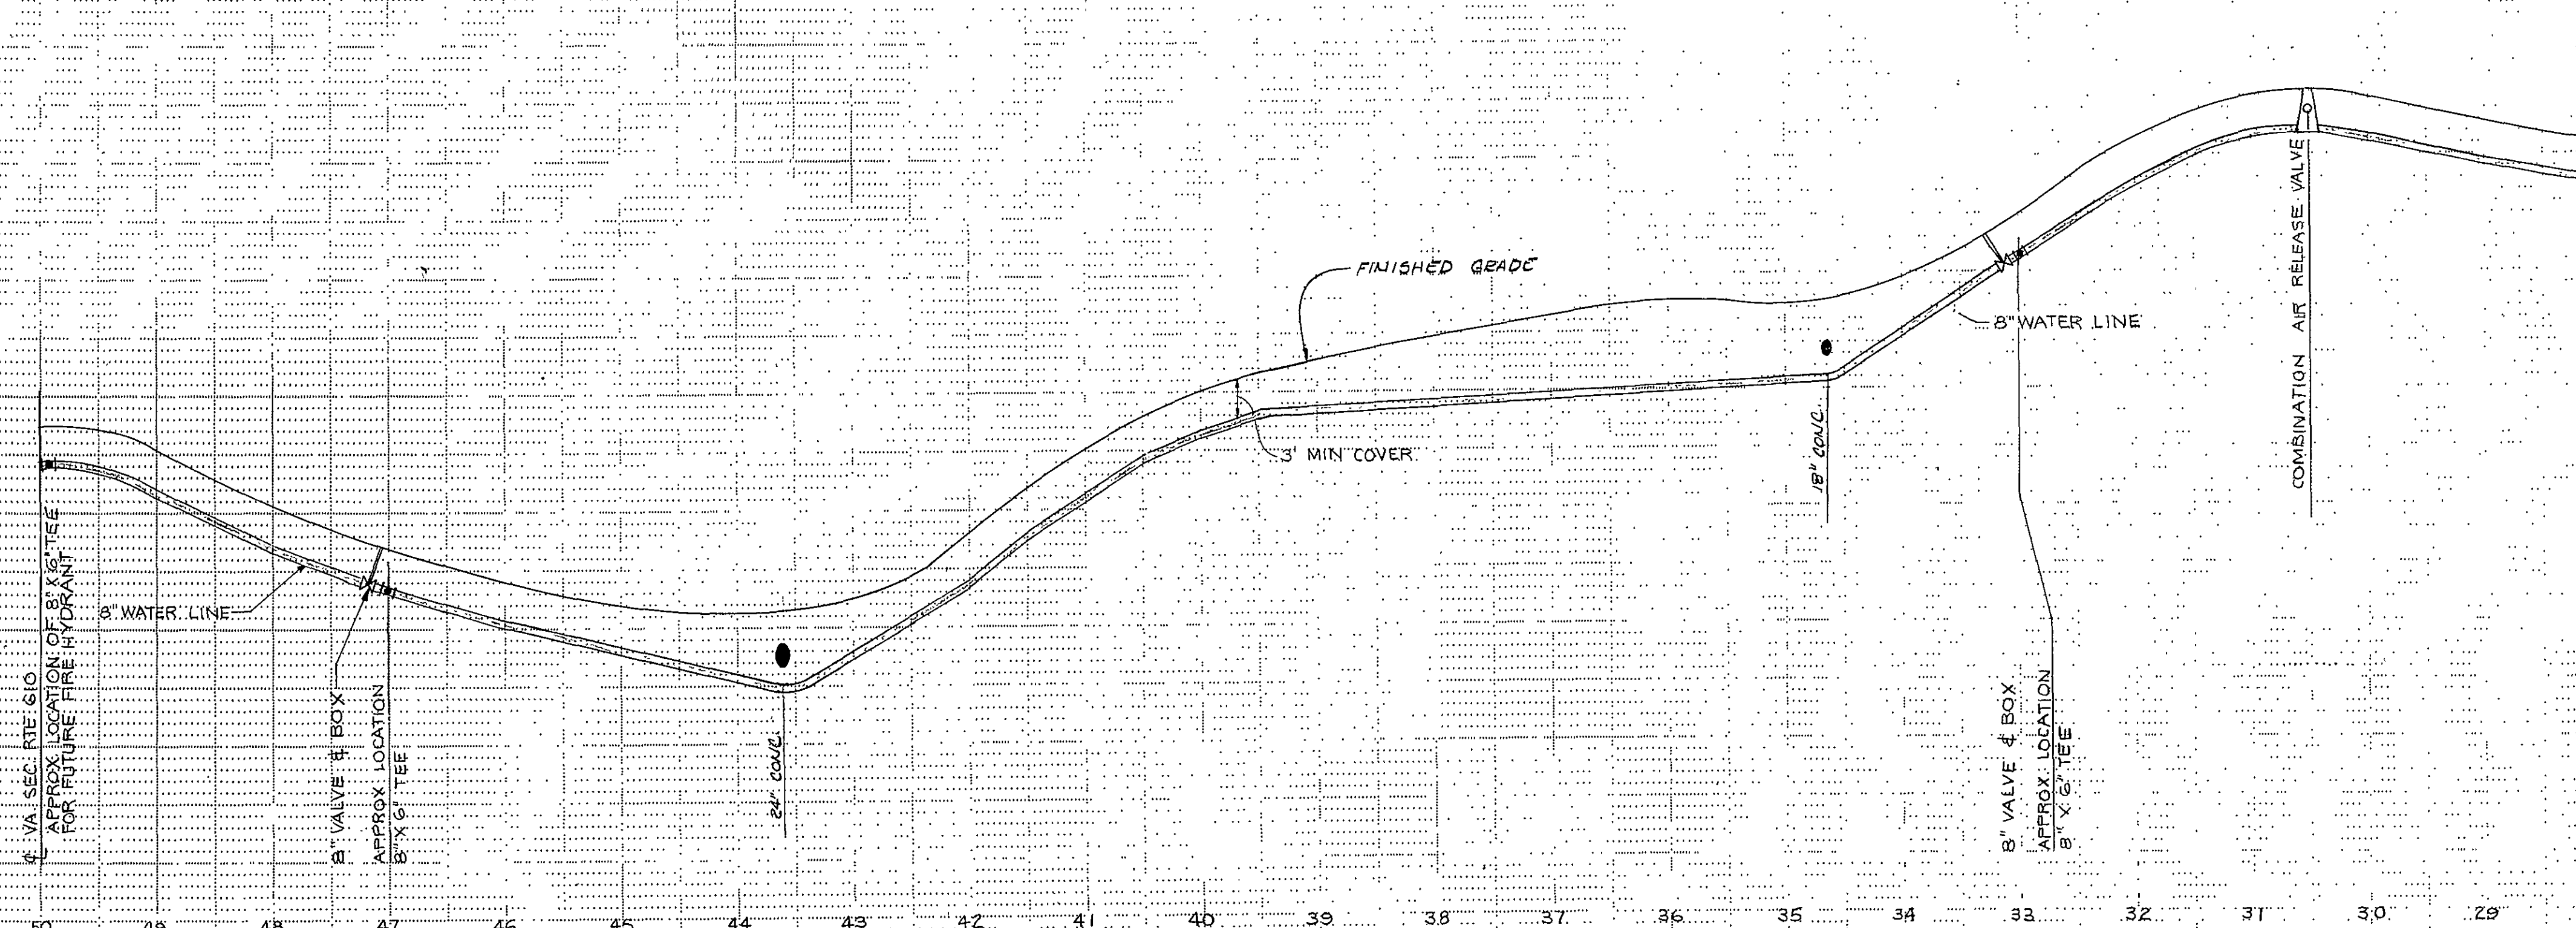


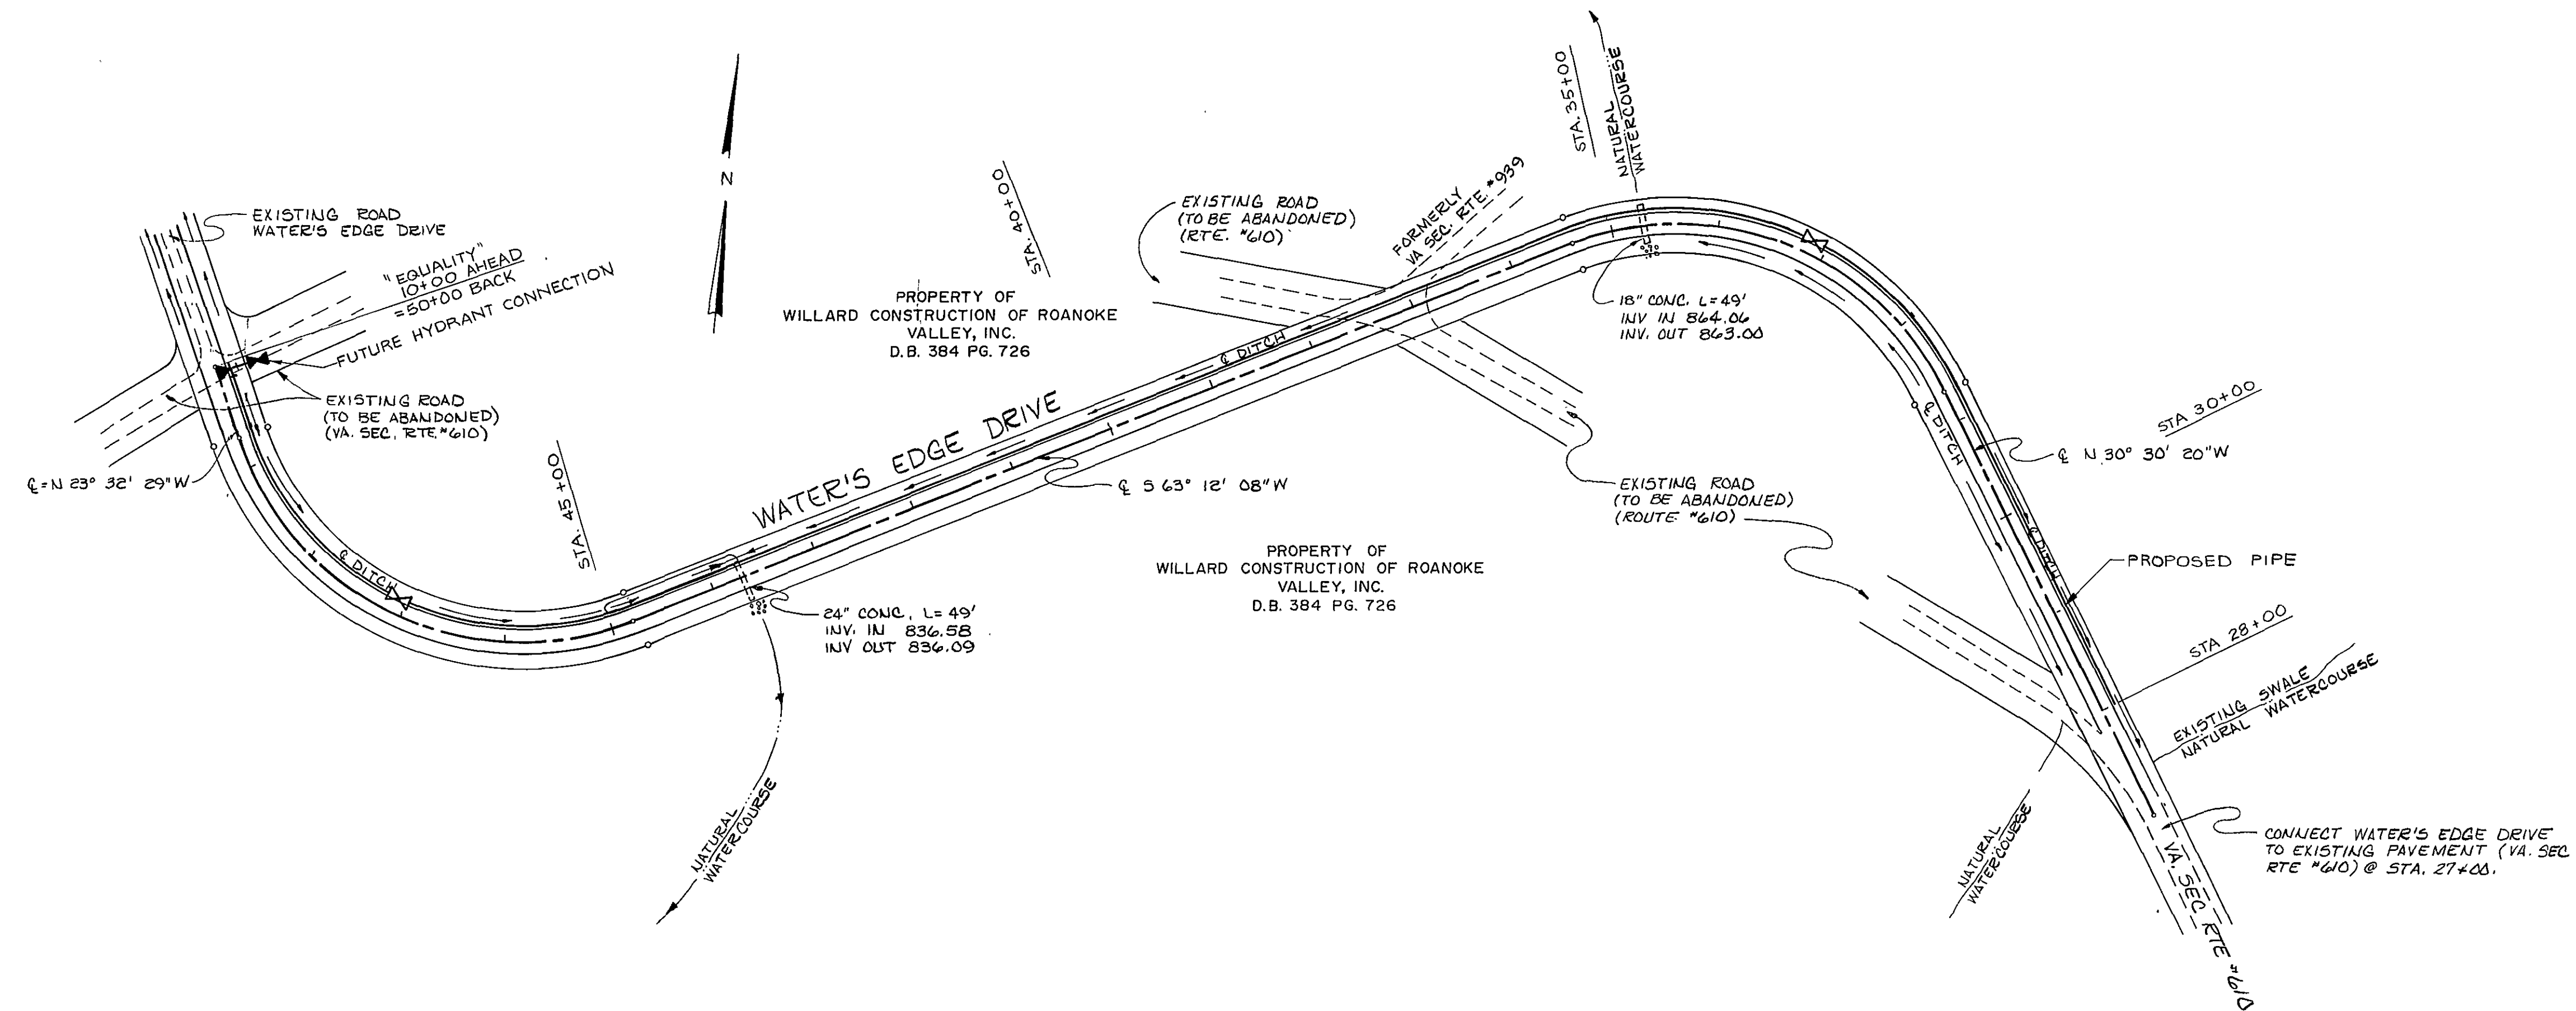

OLVER INCORPORATED
Consulting Engineers • Environmental Laboratories

1531 NORTH MAIN STREET
BLACKSBURG, VIRGINIA 24060

(703) 552-5548

Designed WCK

Drawn SLH

Checked KEM

1"=10'-0" VERT.
Scale 1"=100'-0" HORIZ.

Job No. 10645

Date JUNE 16, 1986

THE WATER'S EDGE

WATER DISTRIBUTION SYSTEM PLAN AND PROFILE

Rev.	Description	Date	By
2	VDH SUBMITTAL	8/27/86	WCK
1	VDH SUBMITTAL	6/20/86	WCK

Sheet No.

206

File No.