
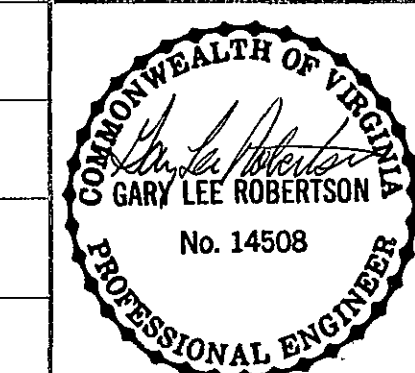
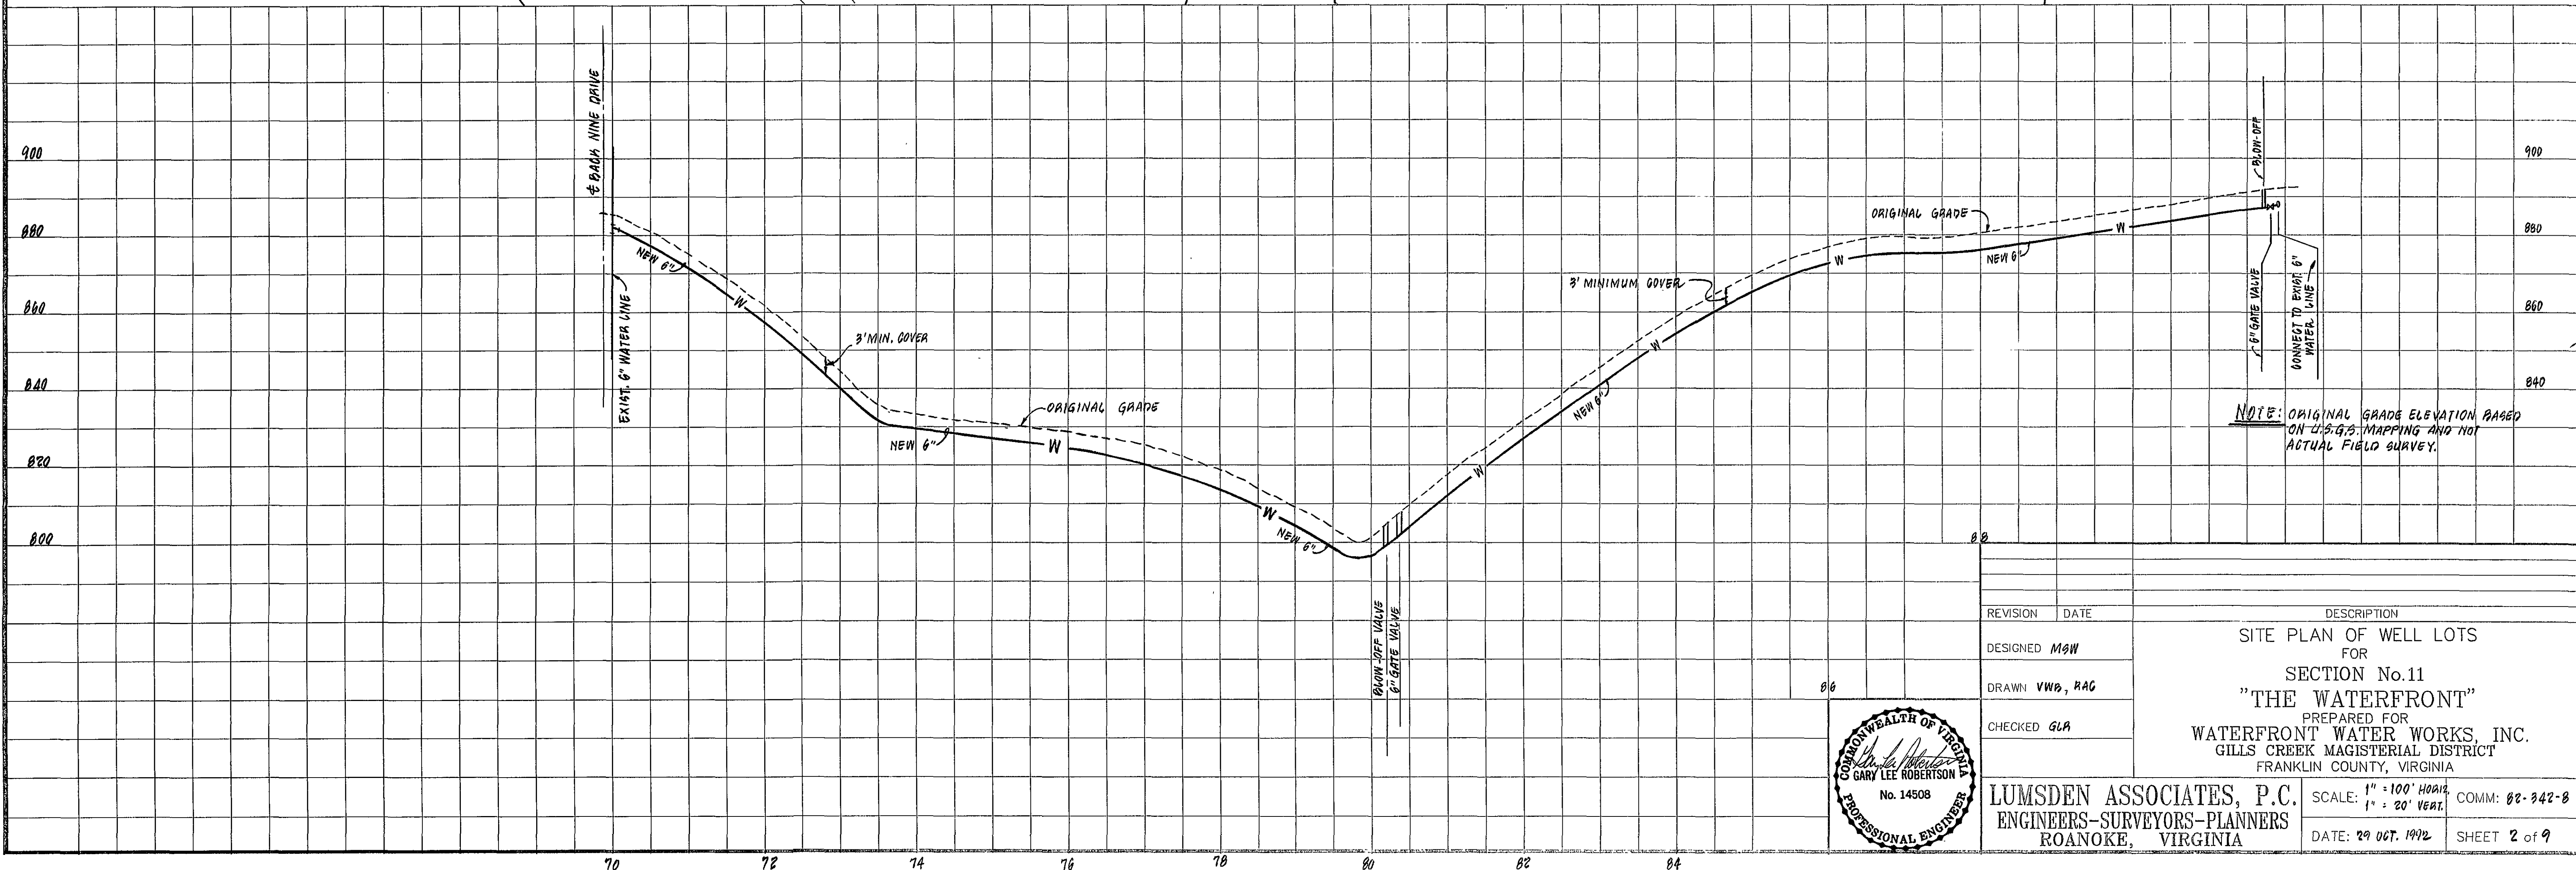


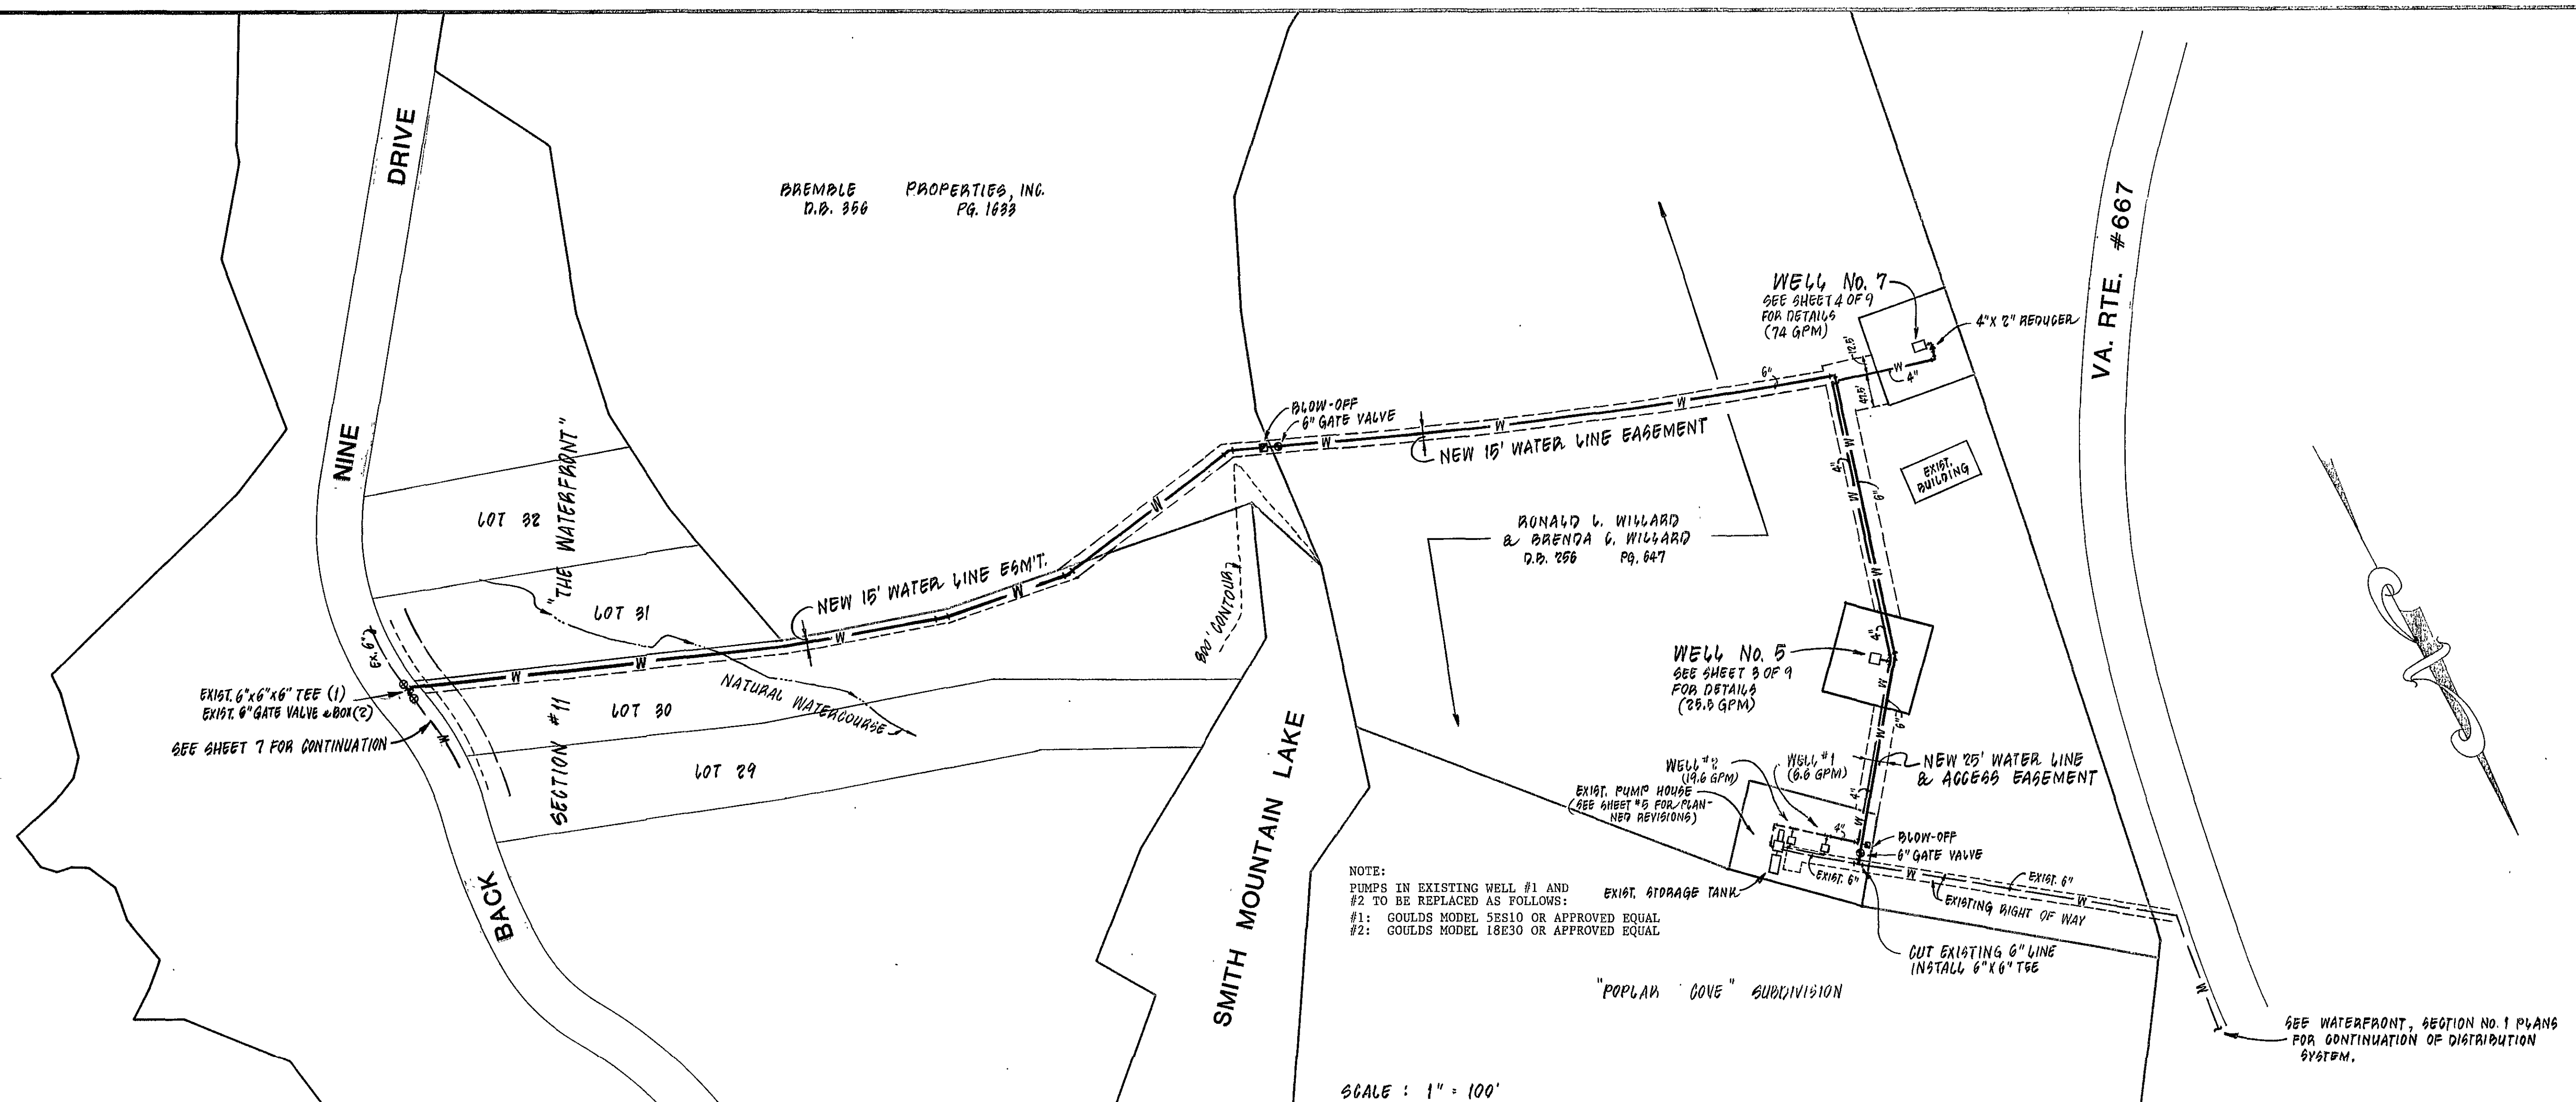

REVISION	DATE	DESCRIPTION
DESIGNED	MGW	SITE PLAN OF WELL LOTS FOR SECTION No. 11 "THE WATERFRONT"
DRAWN	VWB, RAG	PREPARED FOR WATERFRONT WATER WORKS, INC. GILLS CREEK MAGISTERIAL DISTRICT FRANKLIN COUNTY, VIRGINIA
CHECKED	GLA	

LUMSDEN ASSOCIATES, P.C. ENGINEERS-SURVEYORS-PLANNERS ROANOKE, VIRGINIA	SCALE: 1" = 100' HORIZ. 1" = 20' VERT.	COMM: 88-342-8
	DATE: 29 OCT. 1992	SHEET 2 of 9