


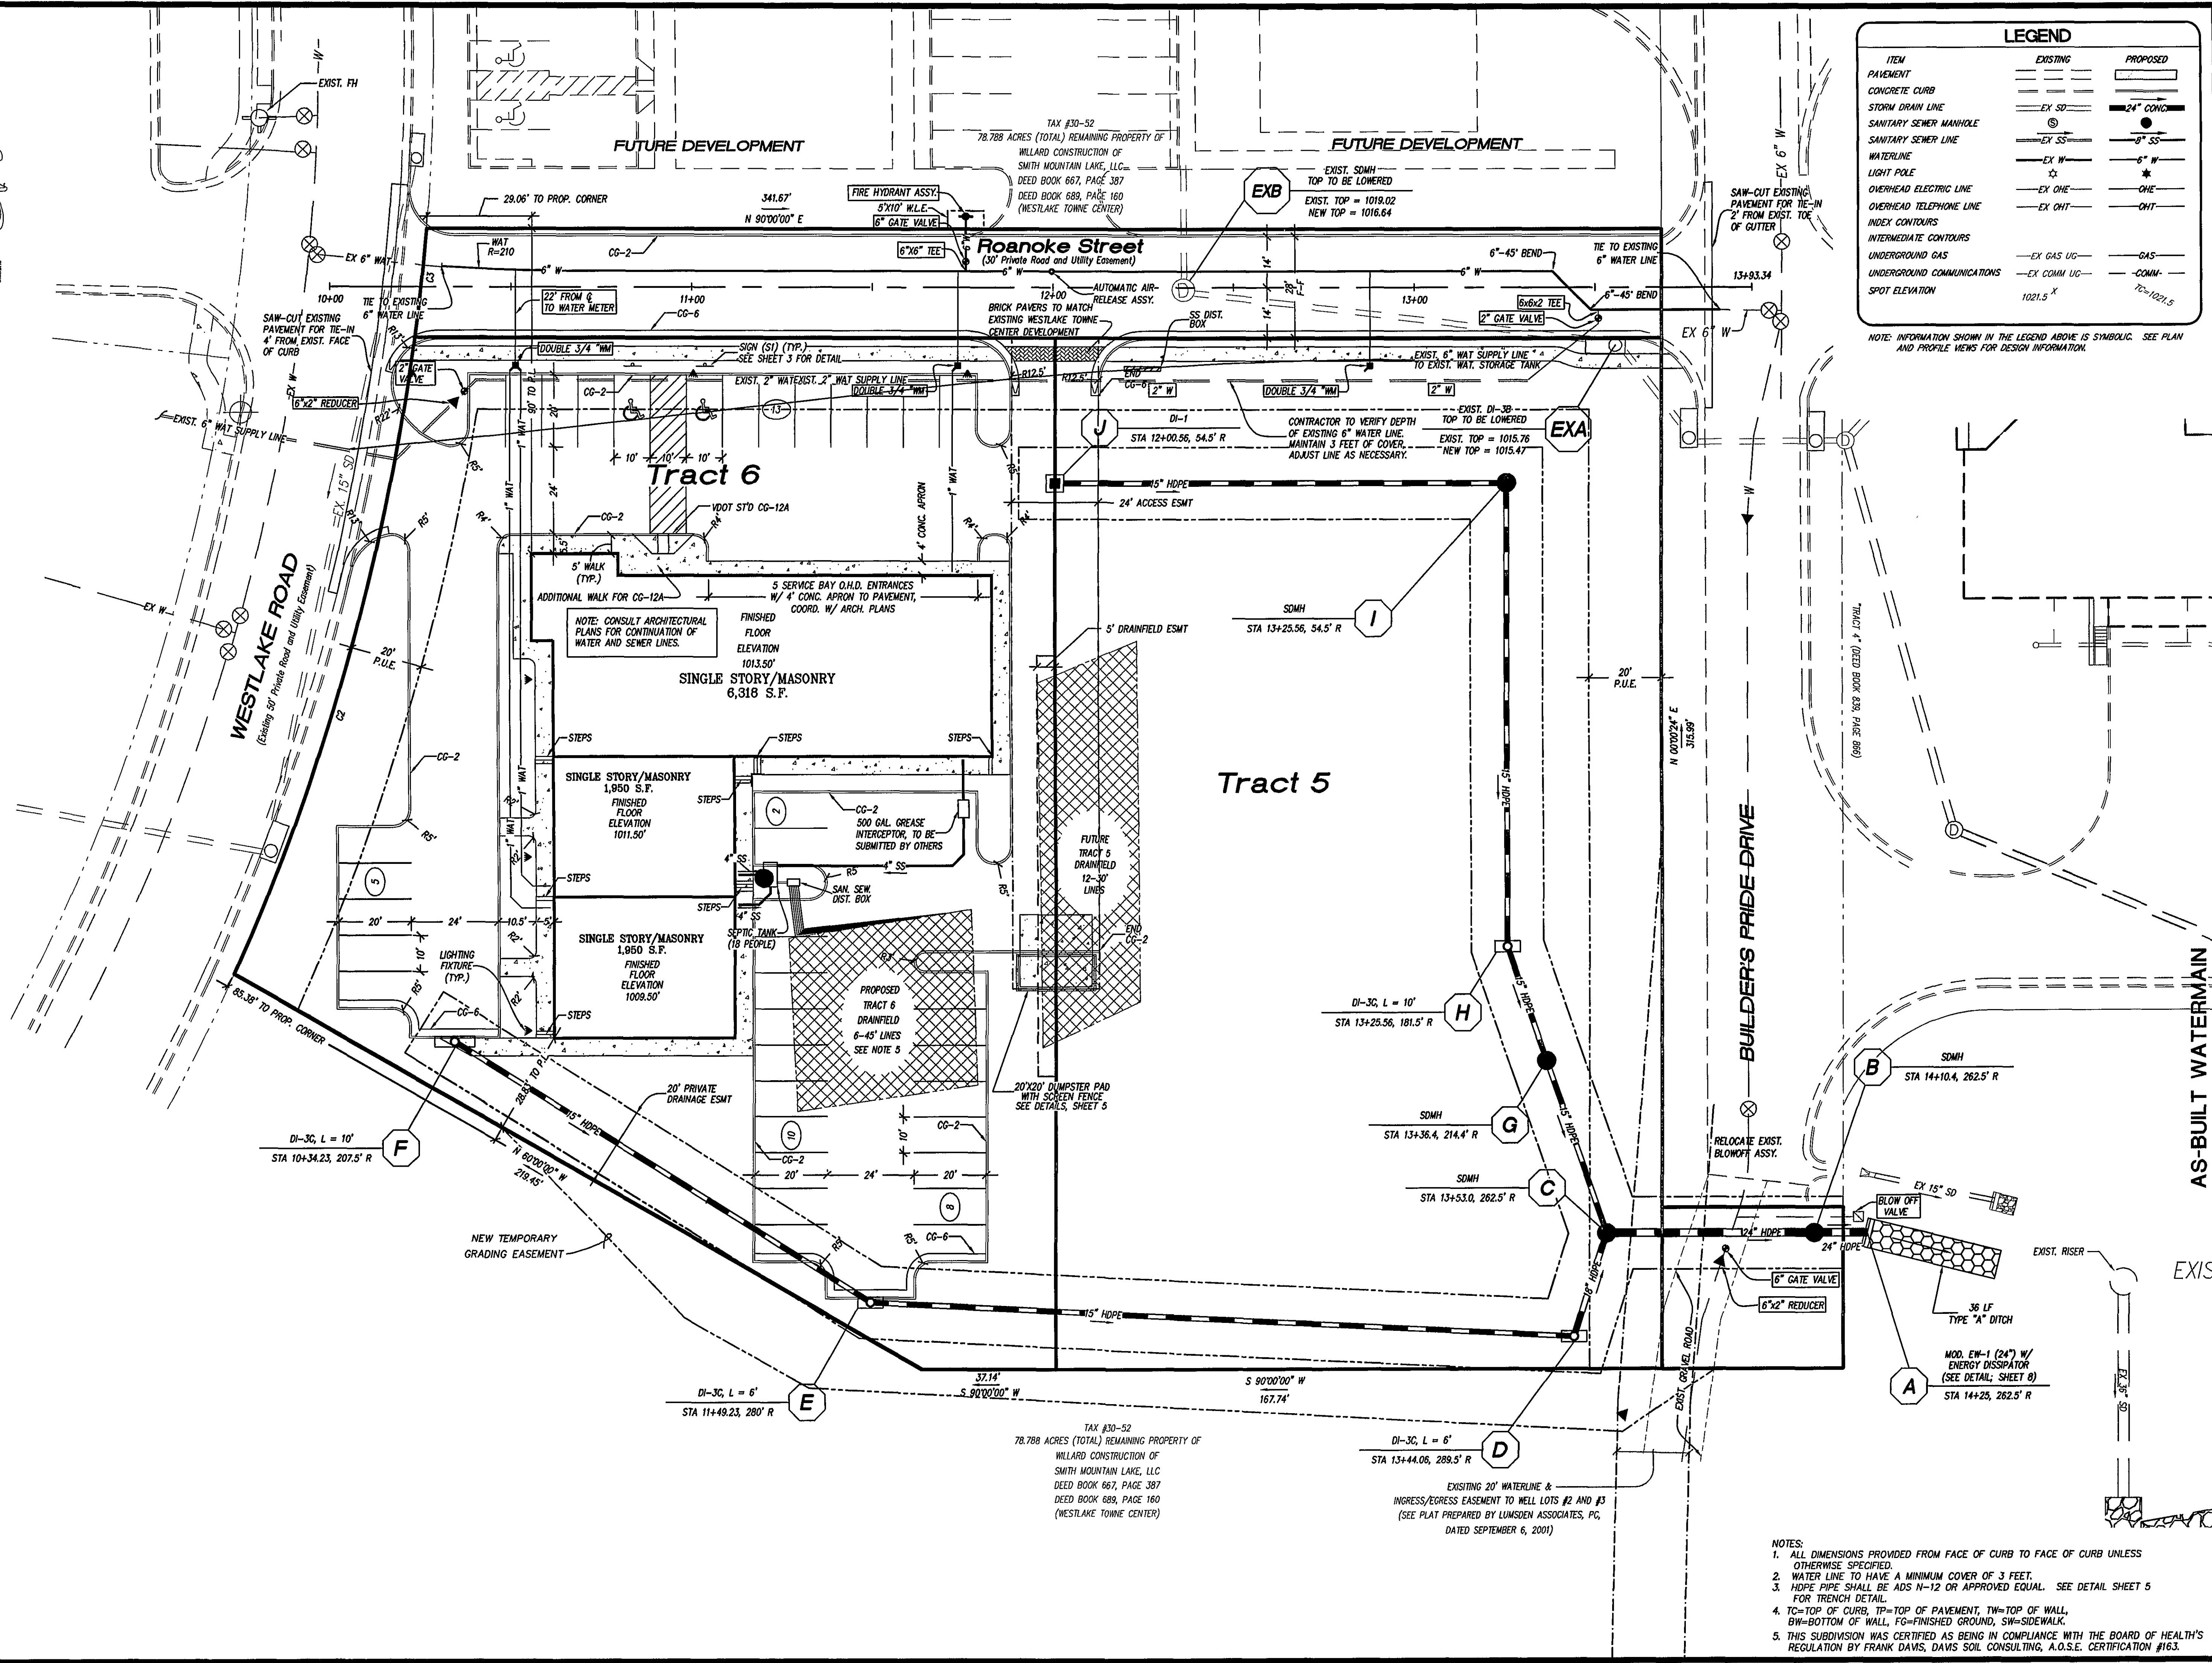

LEGEND		
ITEM	EXISTING	PROPOSED
PAVEMENT	---	---
CONCRETE CURB	---	---
STORM DRAIN LINE	---	---
SANITARY SEWER MANHOLE	---	---
SANITARY SEWER LINE	---	---
WATERLINE	---	---
LIGHT POLE	---	---
OVERHEAD ELECTRIC LINE	---	---
OVERHEAD TELEPHONE LINE	---	---
INDEX CONTOURS	---	---
INTERMEDIATE CONTOURS	---	---
UNDERGROUND GAS	---	---
UNDERGROUND COMMUNICATIONS	---	---
SPOT ELEVATION	---	---

NOTE: INFORMATION SHOWN IN THE LEGEND ABOVE IS SYMBOLIC. SEE PLAN AND PROFILE VIEWS FOR DESIGN INFORMATION.

LUMSDEN ASSOCIATES, P.C.
ENGINEERS-SURVEYORS-PLANNERS
ROANOKE, VIRGINIA

4664 BRAMBLETON AVENUE
P.O. BOX 20689
ROANOKE, VIRGINIA 24018

PHONE: (540) 774-4411
FAX: (540) 772-9445
E-MAIL: MAIL@LUMSDENPC.COM

COMMONWEALTH OF VIRGINIA
THOMAS C. DALE
No. 033002
PROFESSIONAL ENGINEER

DIMENSIONAL LAYOUT

AS-BUILT WATERMAIN

TRACTS 5 & 6 OF WESTLAKE TOWNE CENTER

PREPARED FOR WILLARD CONSTRUCTION OF SMITH MOUNTAIN LAKE, LLC

GILLS CREEK MAGISTERIAL DISTRICT
FRANKLIN COUNTY, VIRGINIA

NO.	DATE	DESCRIPTION
1	02/19/06	AS-BUILT WATERMAIN
2		
3		
4		
5		

DATE: February 2, 2006

SCALE: 1" = 20'

COMMISSION NO. 05-064

SHEET 7 OF 9

NOTES:

- ALL DIMENSIONS PROVIDED FROM FACE OF CURB TO FACE OF CURB UNLESS OTHERWISE SPECIFIED.
- WATER LINE TO HAVE A MINIMUM COVER OF 3 FEET.
- HOPE PIPE SHALL BE ADS N-12 OR APPROVED EQUAL. SEE DETAIL SHEET 5 FOR TRENCH DETAIL.
- TC=TOP OF CURB; TP=TOP OF PAVEMENT; TW=TOP OF WALL, BW=BOTTOM OF WALL, FG=FINISHED GROUND, SW=SIDEWALK.
- THIS SUBDIVISION WAS CERTIFIED AS BEING IN COMPLIANCE WITH THE BOARD OF HEALTH'S REGULATION BY FRANK DAVIS, DAVIS SOIL CONSULTING, A.O.S.E. CERTIFICATION #163.