


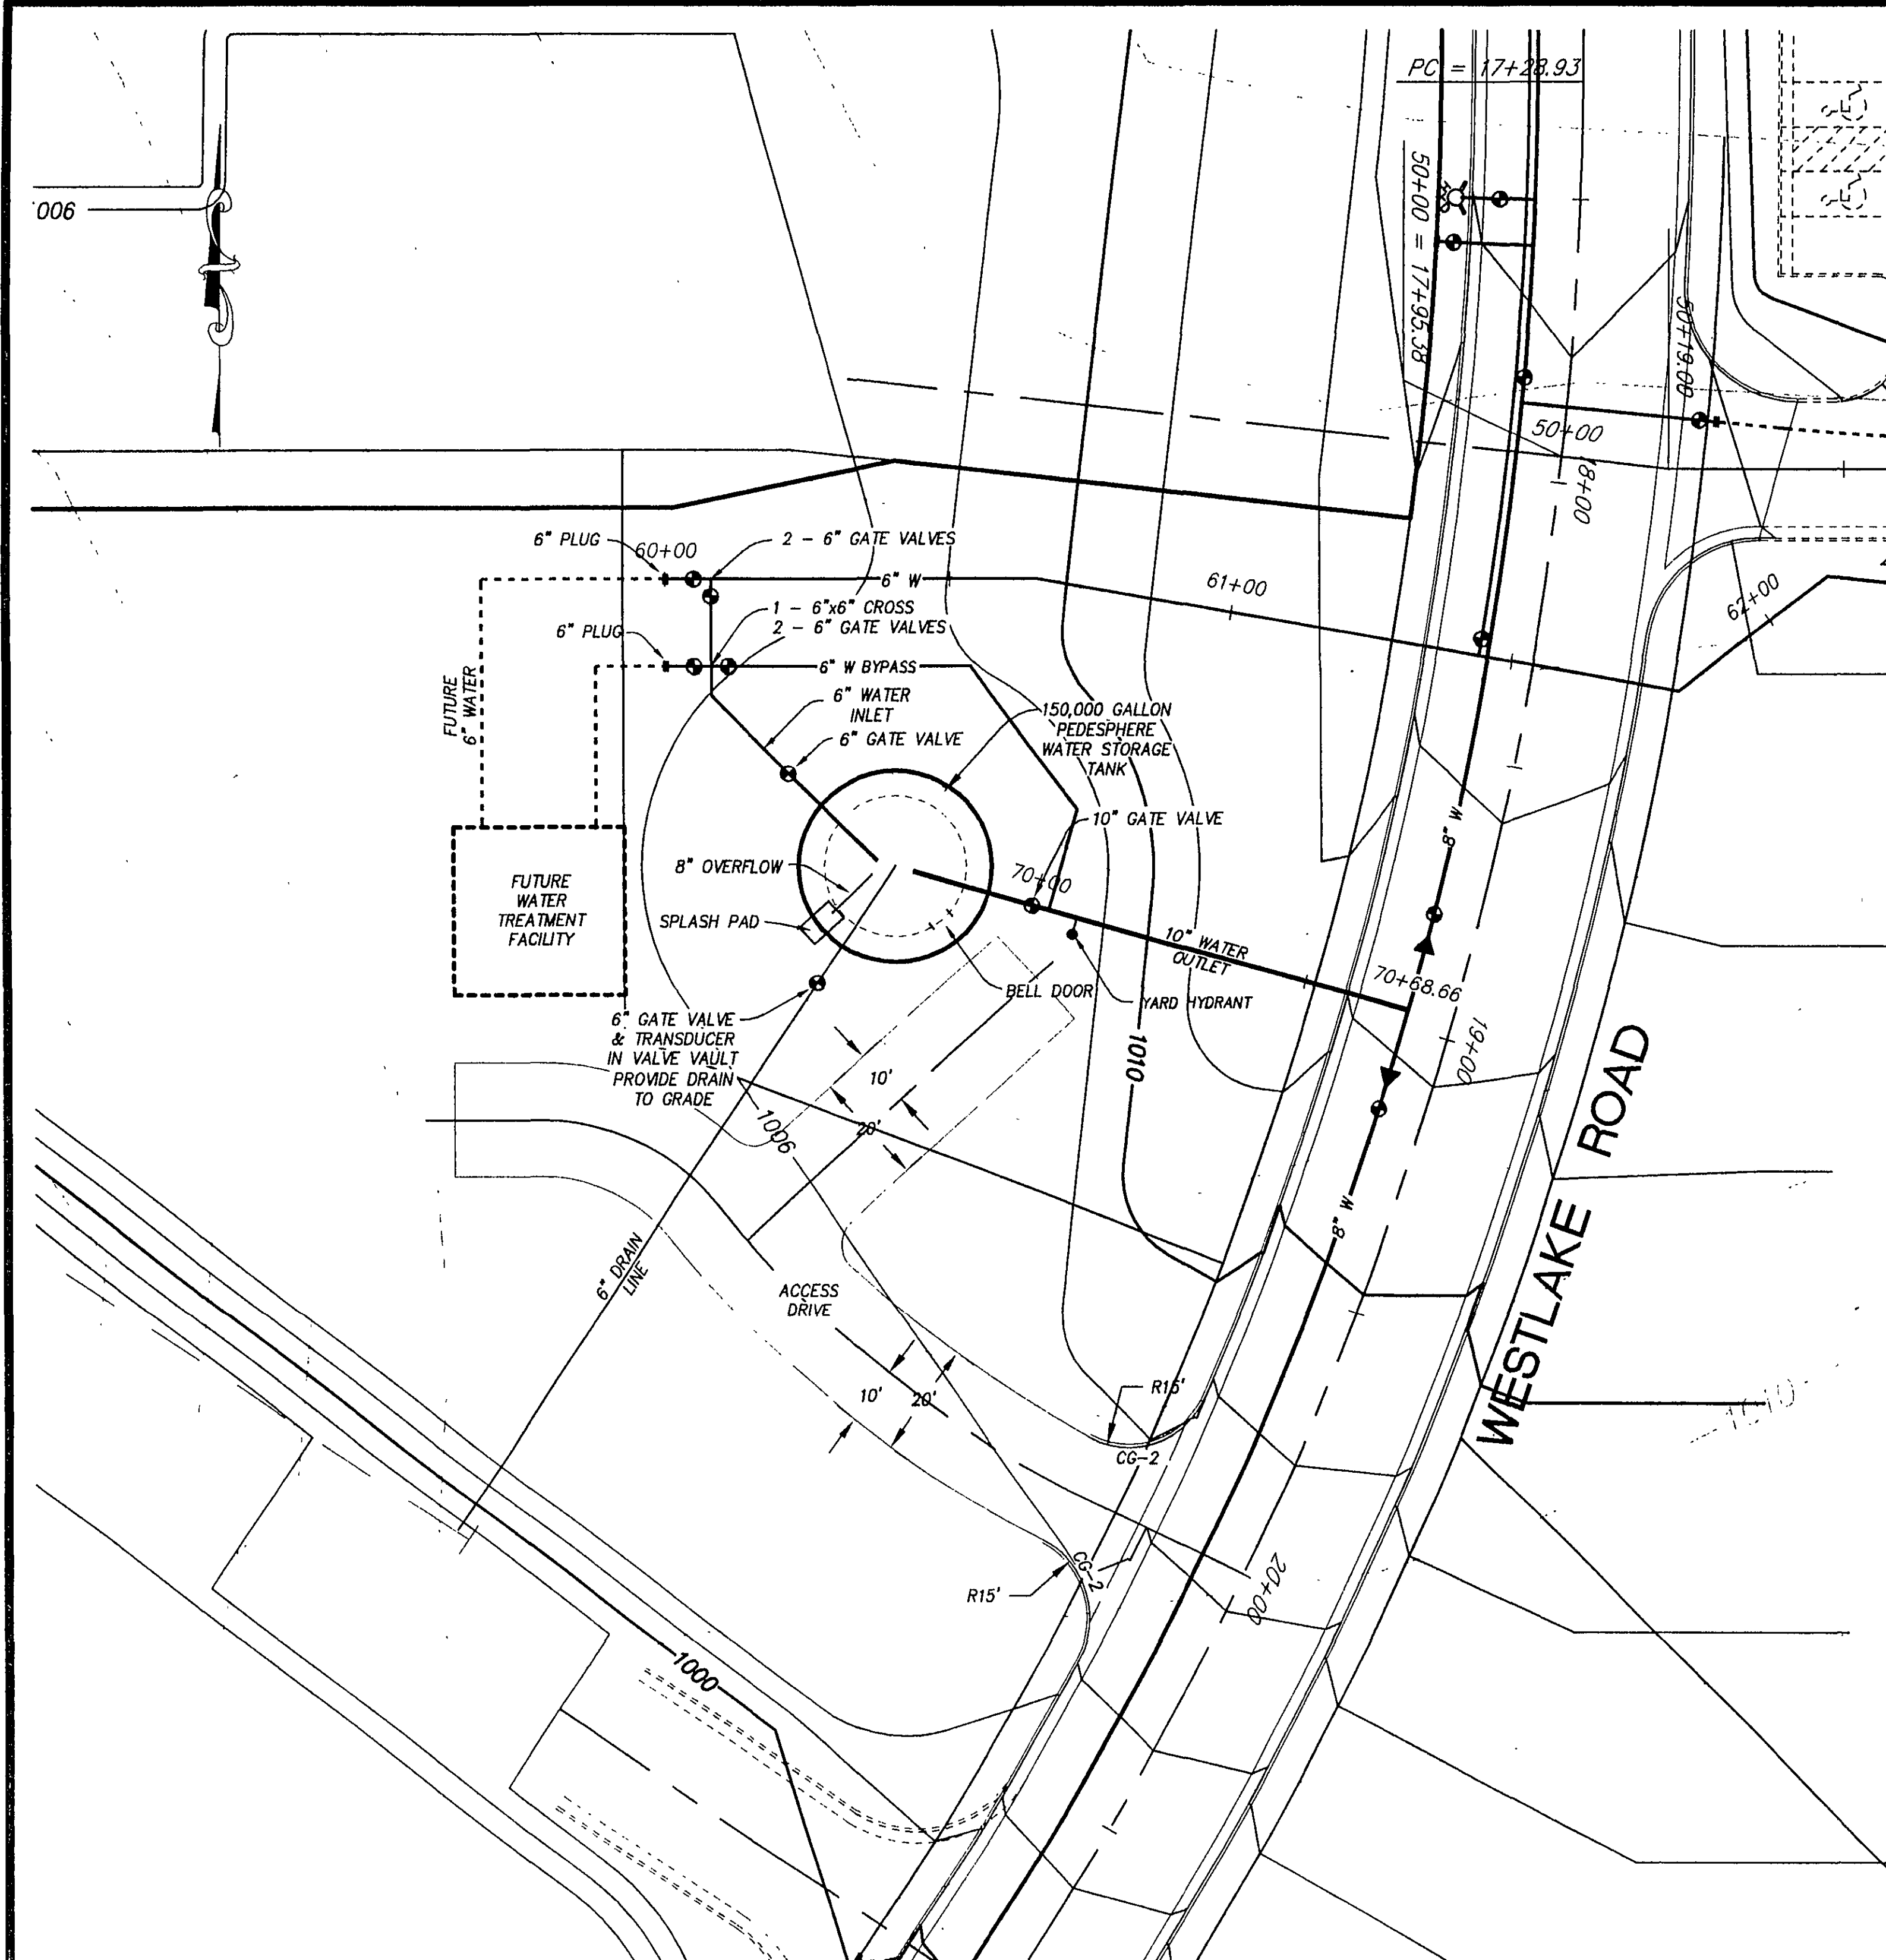


# TANK SITE PLAN

SCALE: 1" = 20'


## GENERAL NOTES:

1. A HIGH PERFORMANCE PRESSURE TRANSDUCER LOCATED ON THE TANK DRAIN LINE WILL BE CONNECTED TO A CONTROLLER WHICH WHICH WILL MONITOR WATER LEVELS IN THE STORAGE TANK. THE CONTROLLER WILL ACTIVATE AND DEACTIVATE WELL NUMBER 3 USING A REMOTE DIALER.

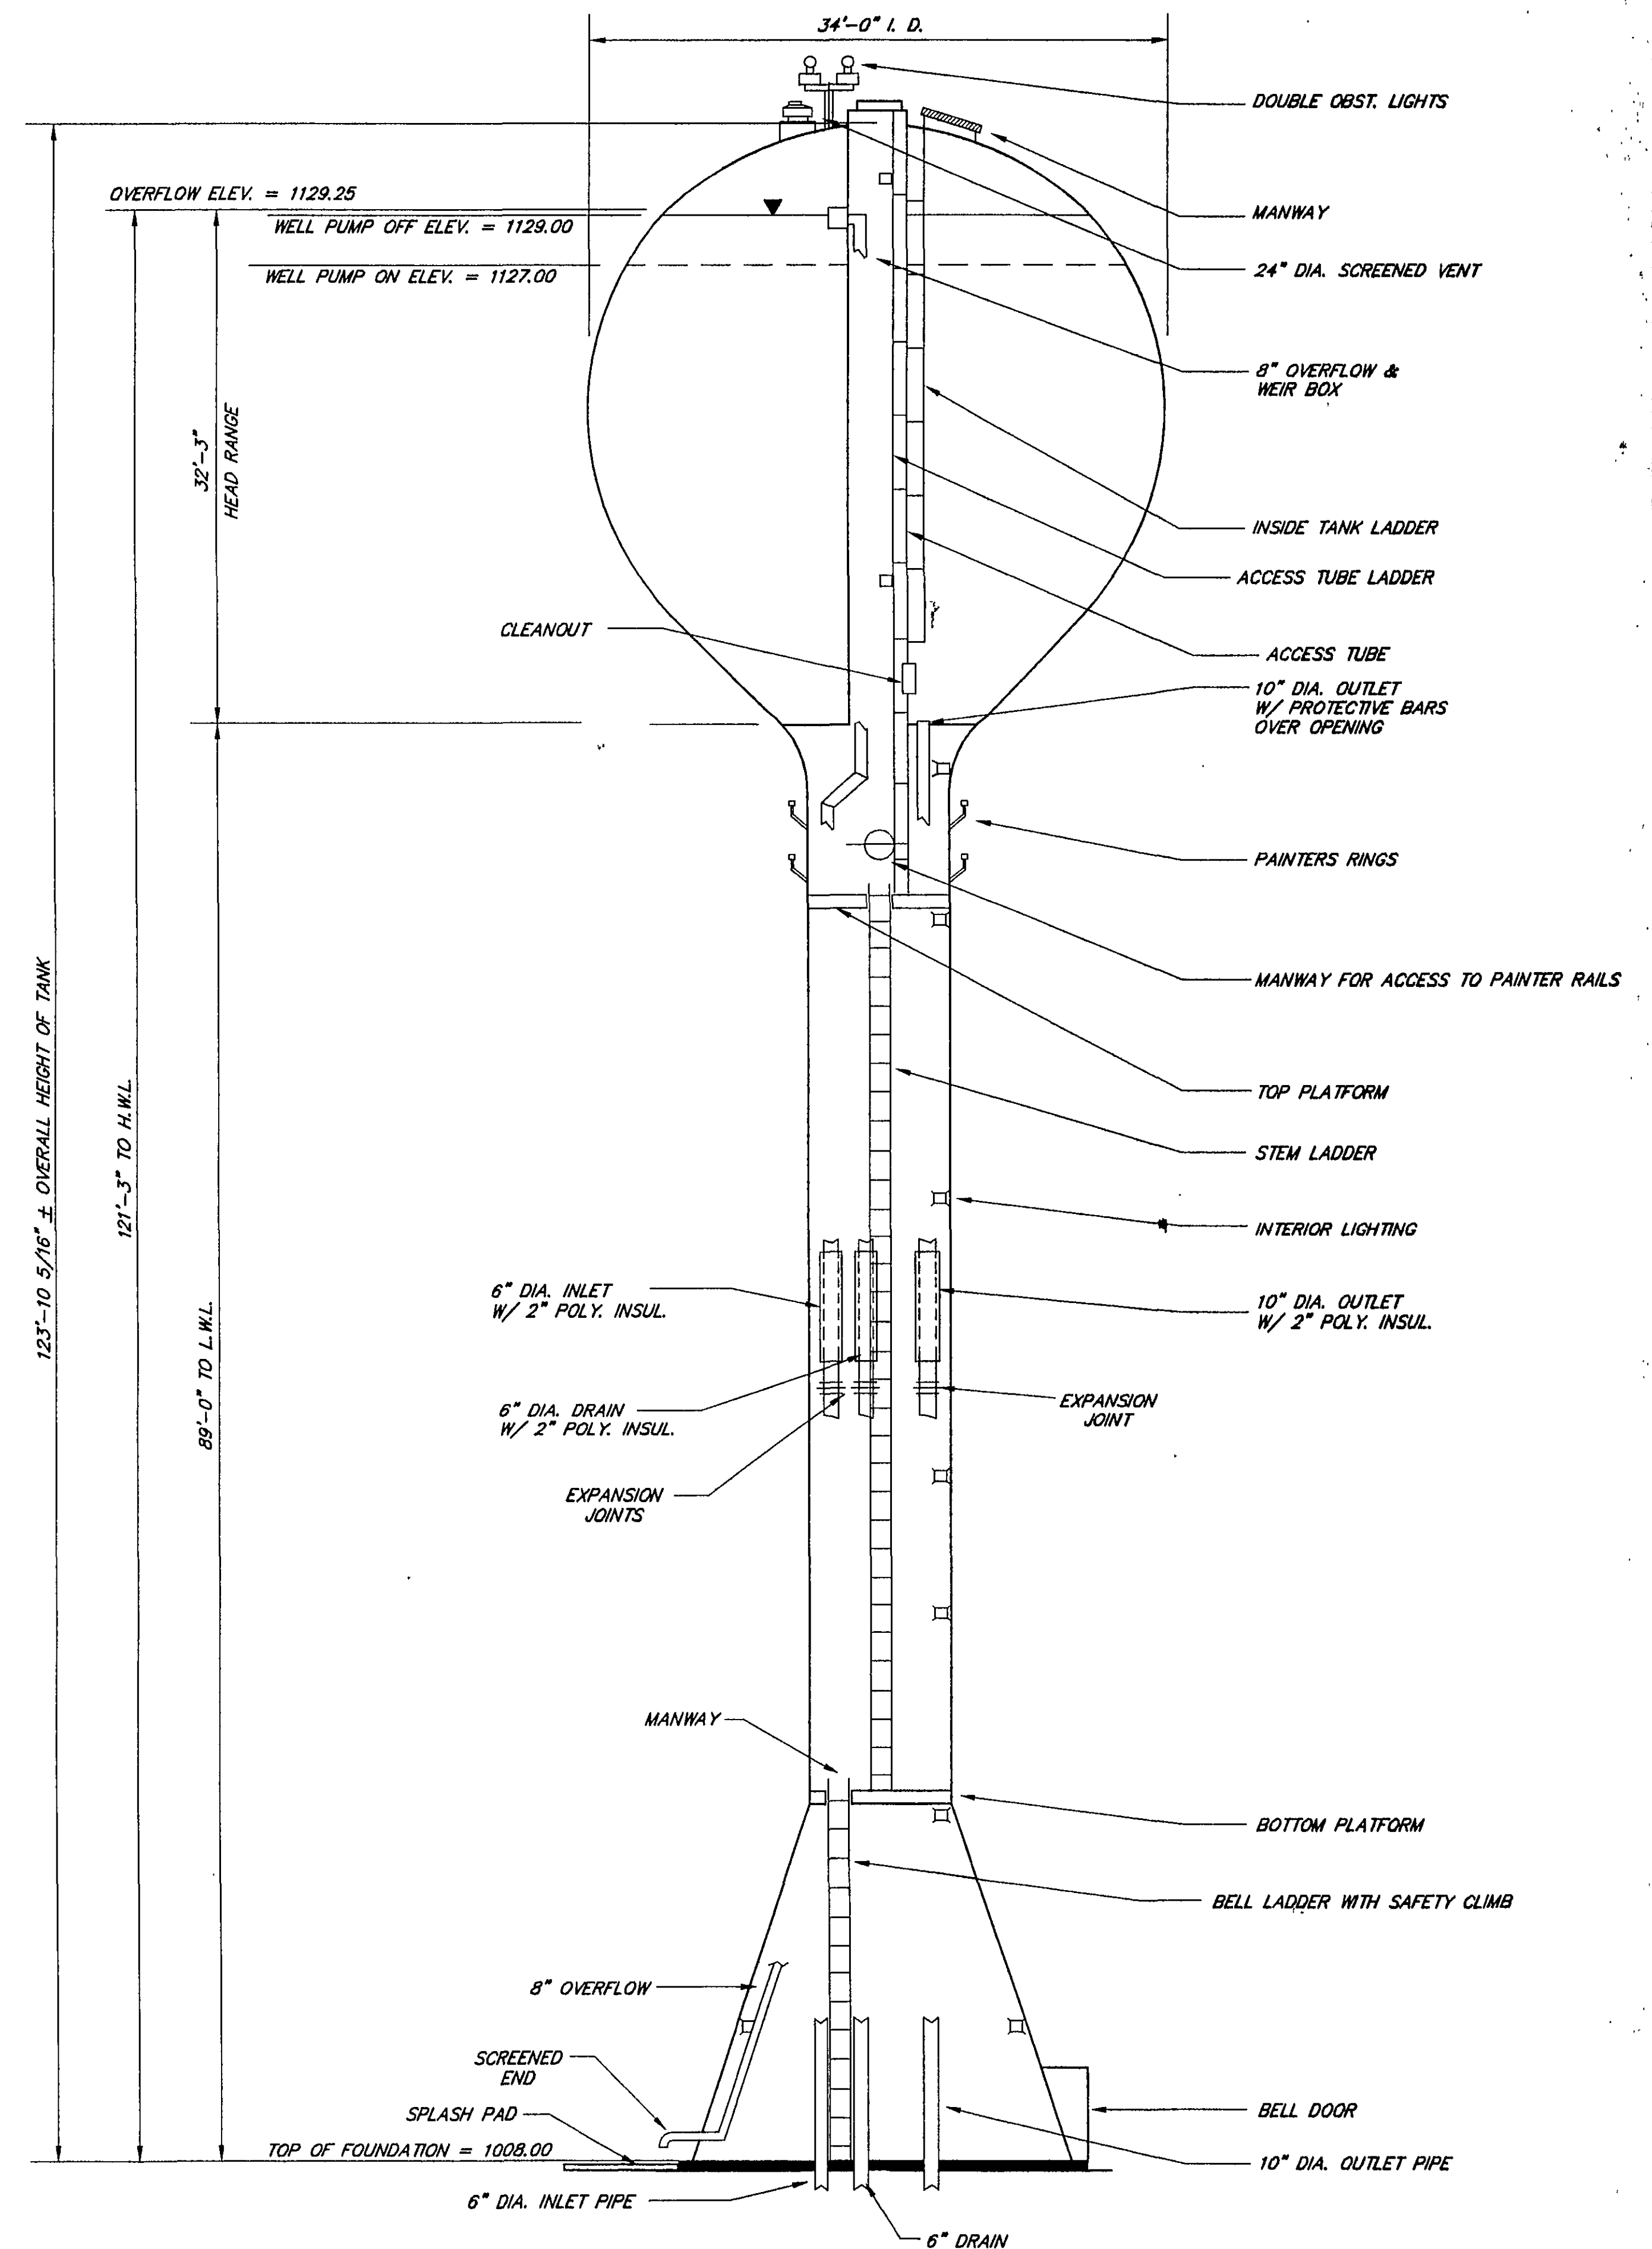

# SECTIONAL ELEVATION

NO SCALE

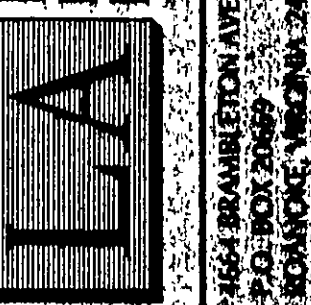

## WATER STORAGE TANK

PHASE 2 WATER LINE PLANS FOR  
WESTLAKE TOWNE CENTER  
PREPARED FOR  
WILLARD CONSTRUCTION OF, LLC  
SMITH MOUNTAIN LAKE, LLC  
CELLS CREEK INDUSTRIAL DISTRICT  
FRANKLIN COUNTY, VIRGINIA

| REVISIONS | DESCRIPTION | DATE |
|-----------|-------------|------|
| NO.       |             |      |
| 1         |             |      |
| 2         |             |      |
| 3         |             |      |
| 4         |             |      |
| 5         |             |      |

DATE: JANUARY 10, 2002  
SCALE: AS SHOWN  
COMMISSION NO: 00-050  
CARD FILE: ENG WATER/WESTLAKE/00-050  
SHEET 8 OF 10

