
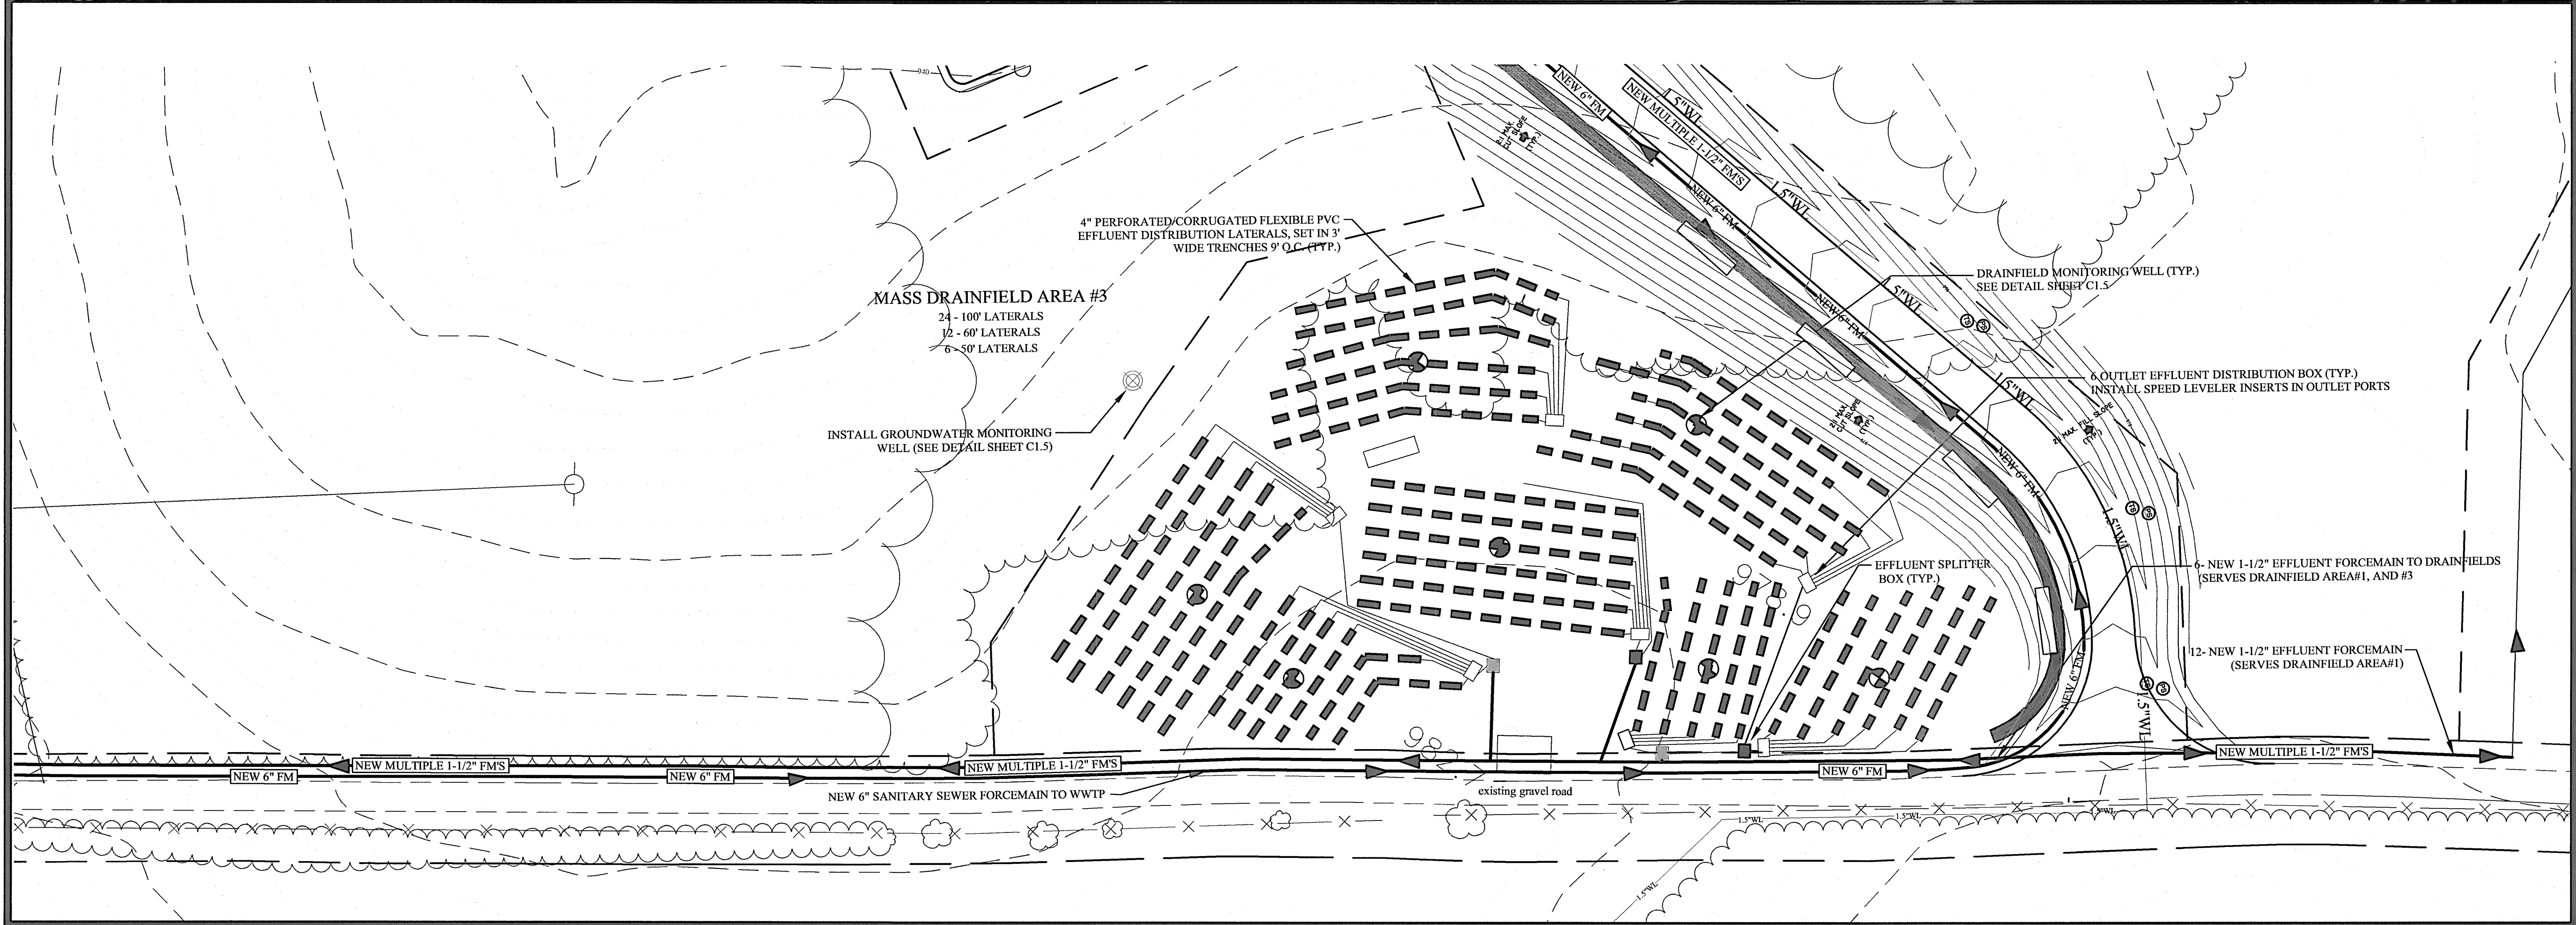


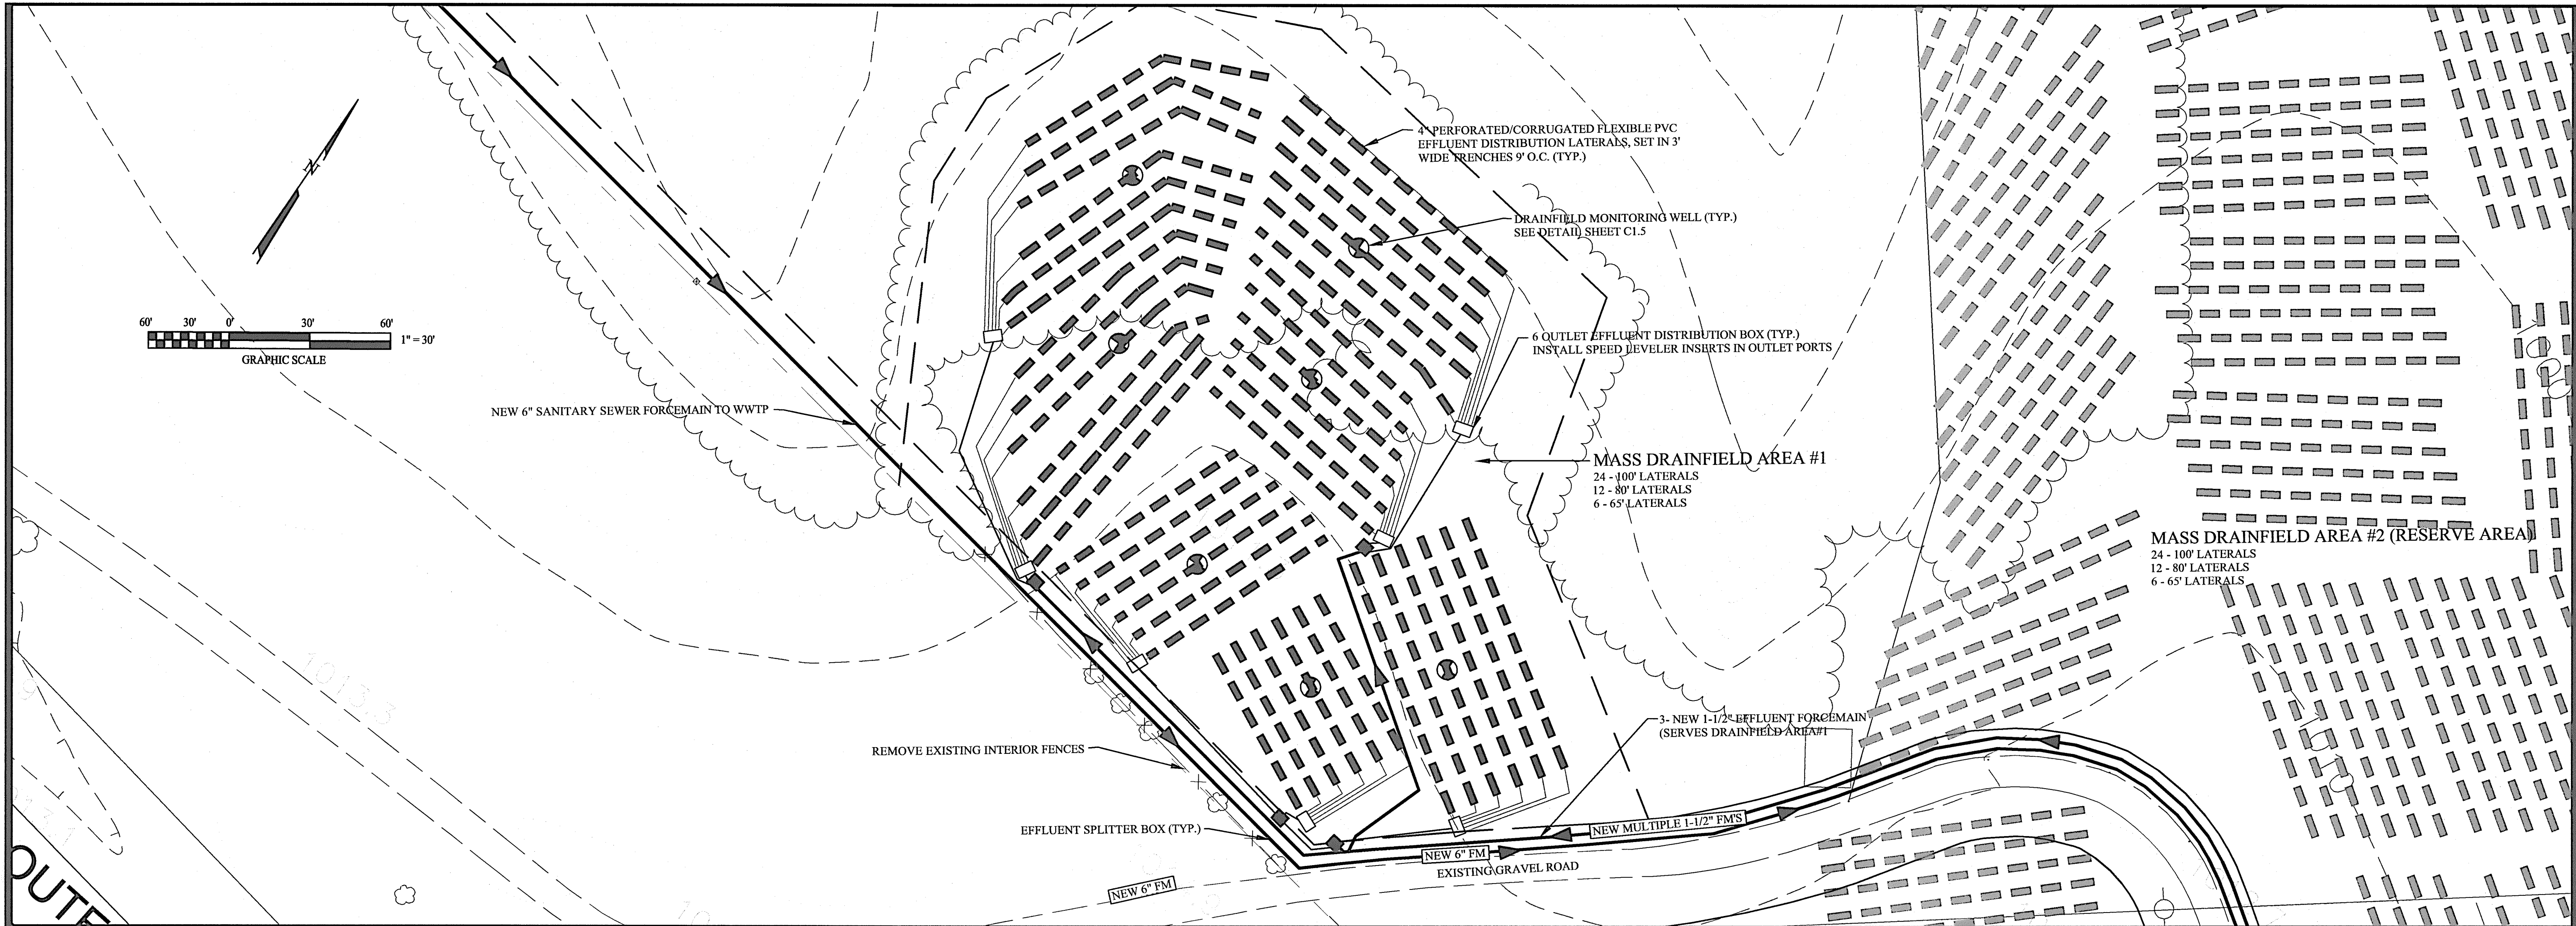

COMMONWEALTH OF VIRGINIA

DANIEL M. EARLY
No. 031787
PROFESSIONAL ENGINEER

ACS
DESIGN

ENGINEERING • SURVEYING
LANDSCAPE ARCHITECTURE
CONSTRUCTION MANAGEMENT

2203 PETERS CREEK ROAD
ROANOKE, VIRGINIA 24017
P 540.562.2345 F 562.2344
INFO@ACSDSIGNLLC.COM
WWW.ACSDSIGNLLC.COM

WESTLAKE VILLAGE
CENTRAL SEWER SYSTEM
FRANKLIN COUNTY, VIRGINIA

DRAWN BY:	JJD
DESIGNED BY:	DME
CHECKED BY:	JJD
DATE:	15 JUNE 2007
JOB NUMBER:	06145

REVISIONS:
No. 1
No. 2
No. 3
No. 4

SHEET NO.:
C1.3

MASS DRAINFIELD
AREAS 1-3
SITE PLAN