




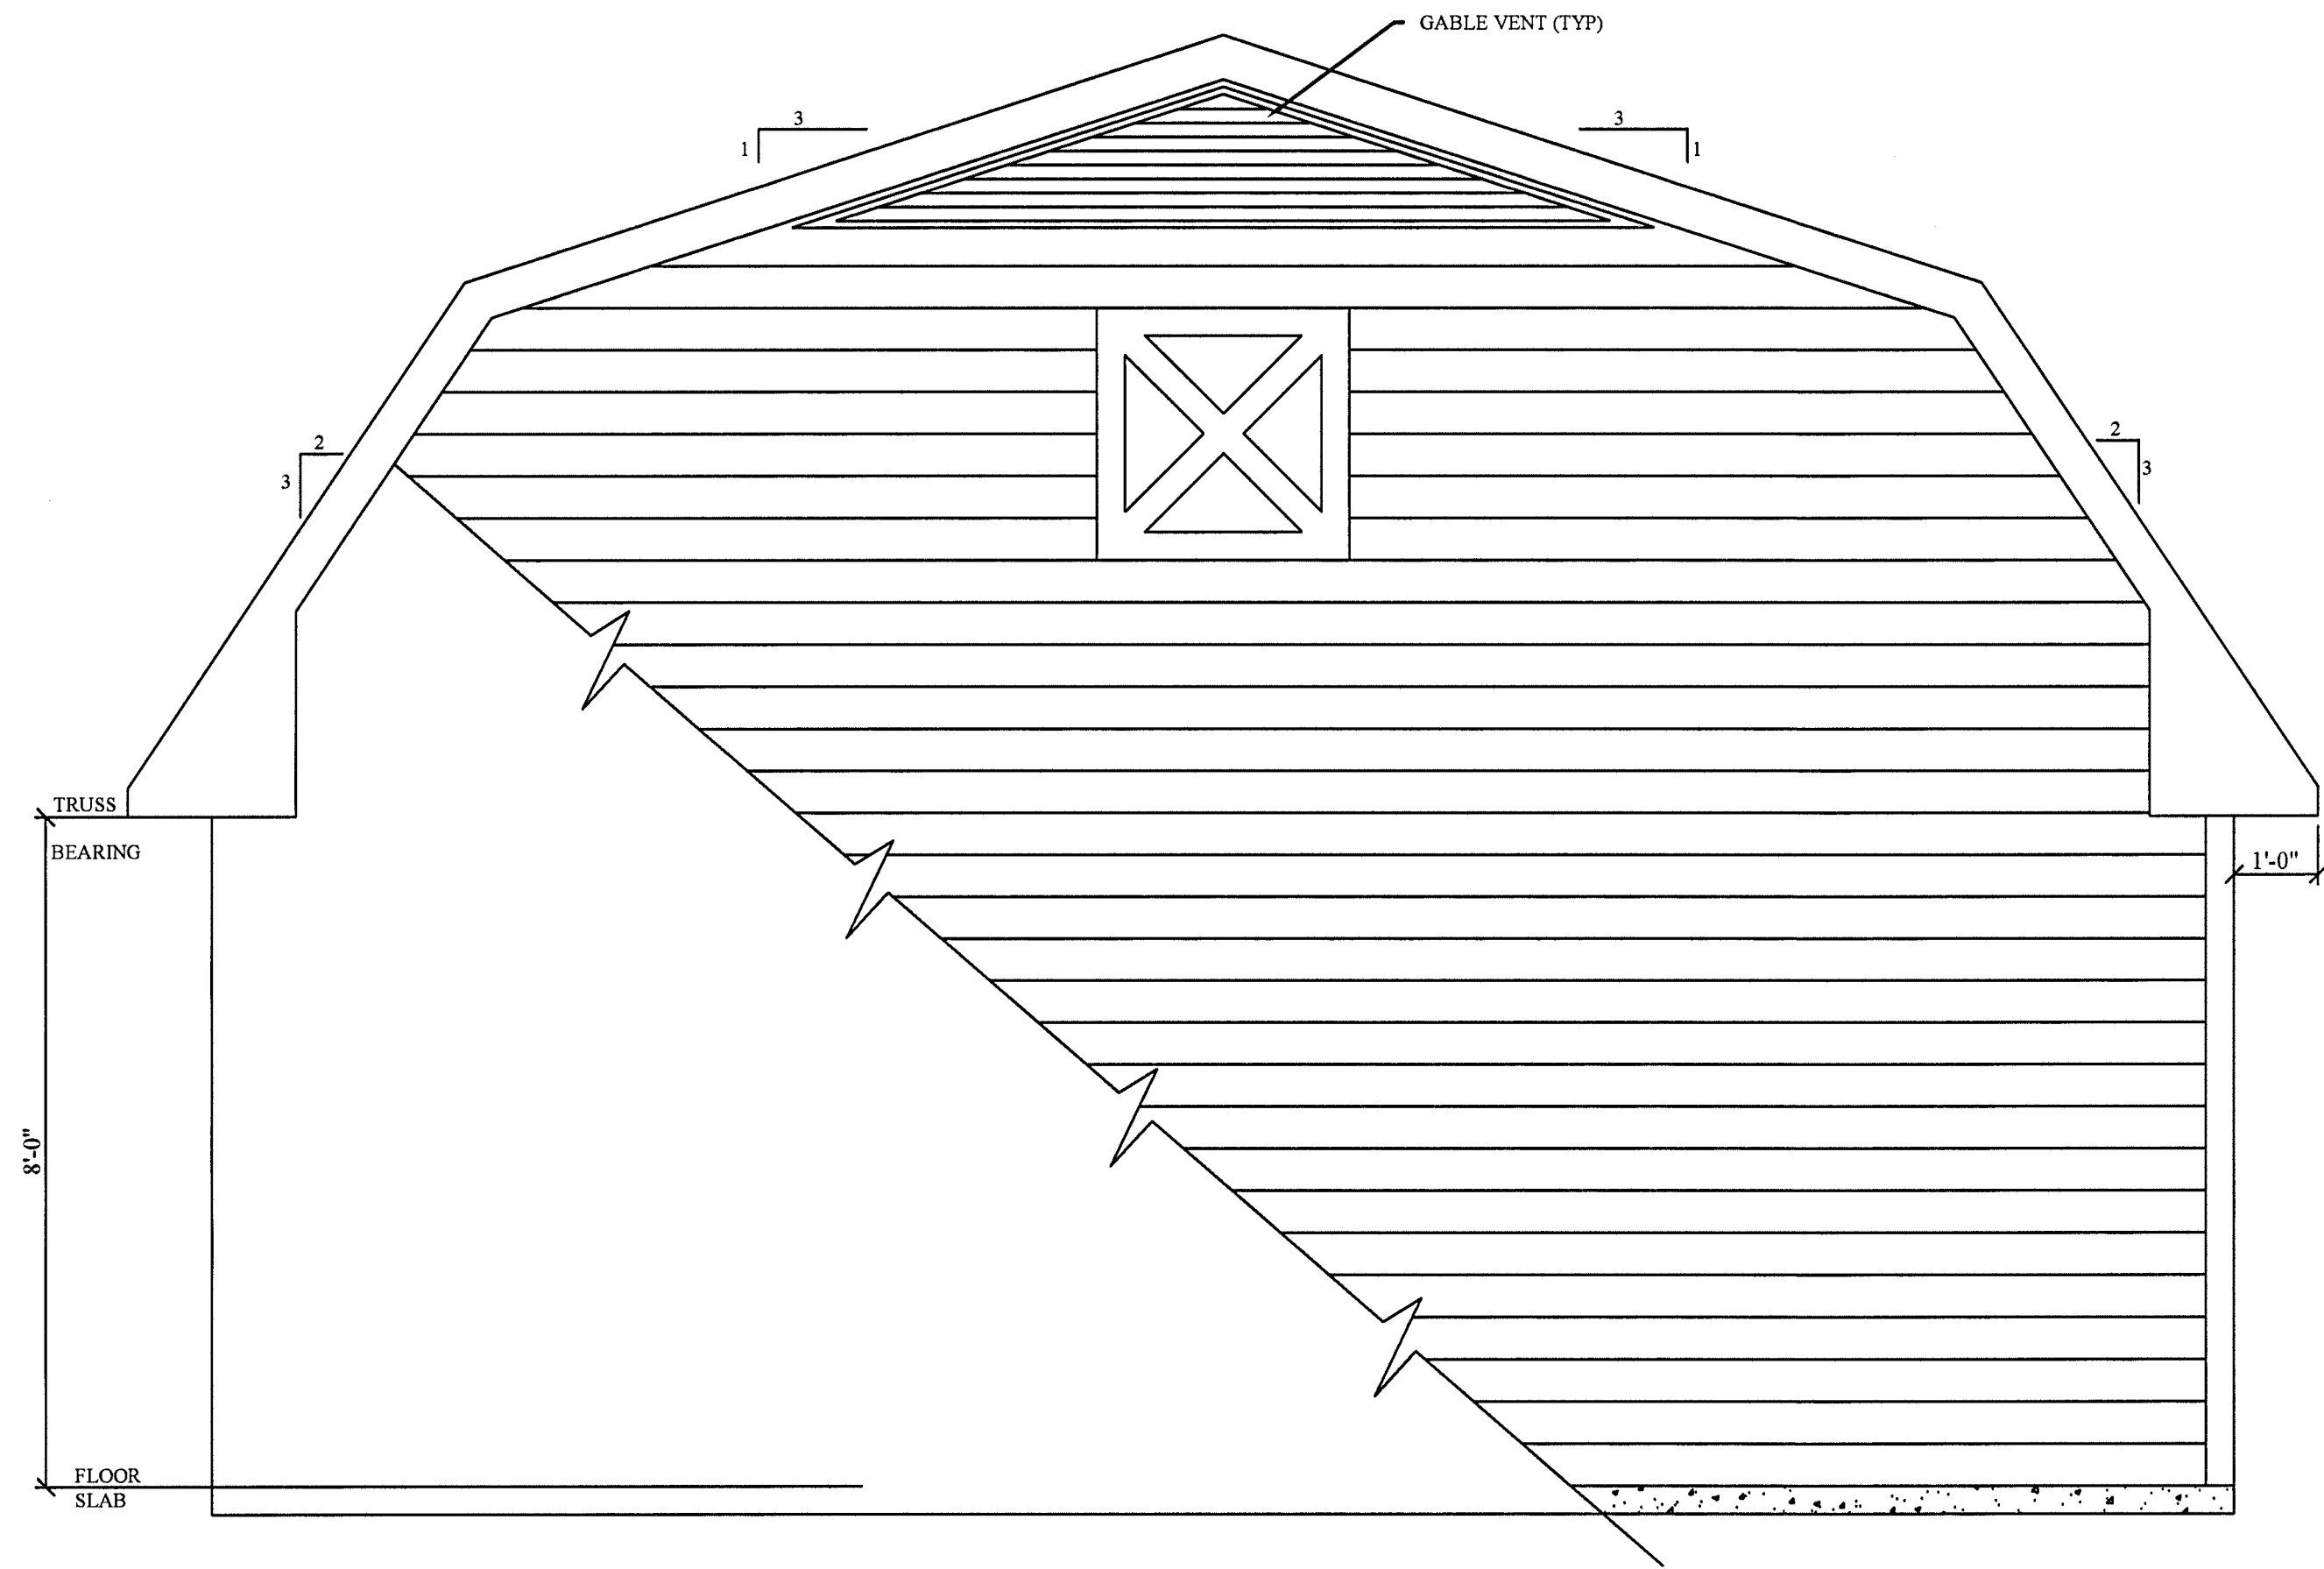


SOUTH ELEVATION
SCALE: 1/2" = 1'-0"

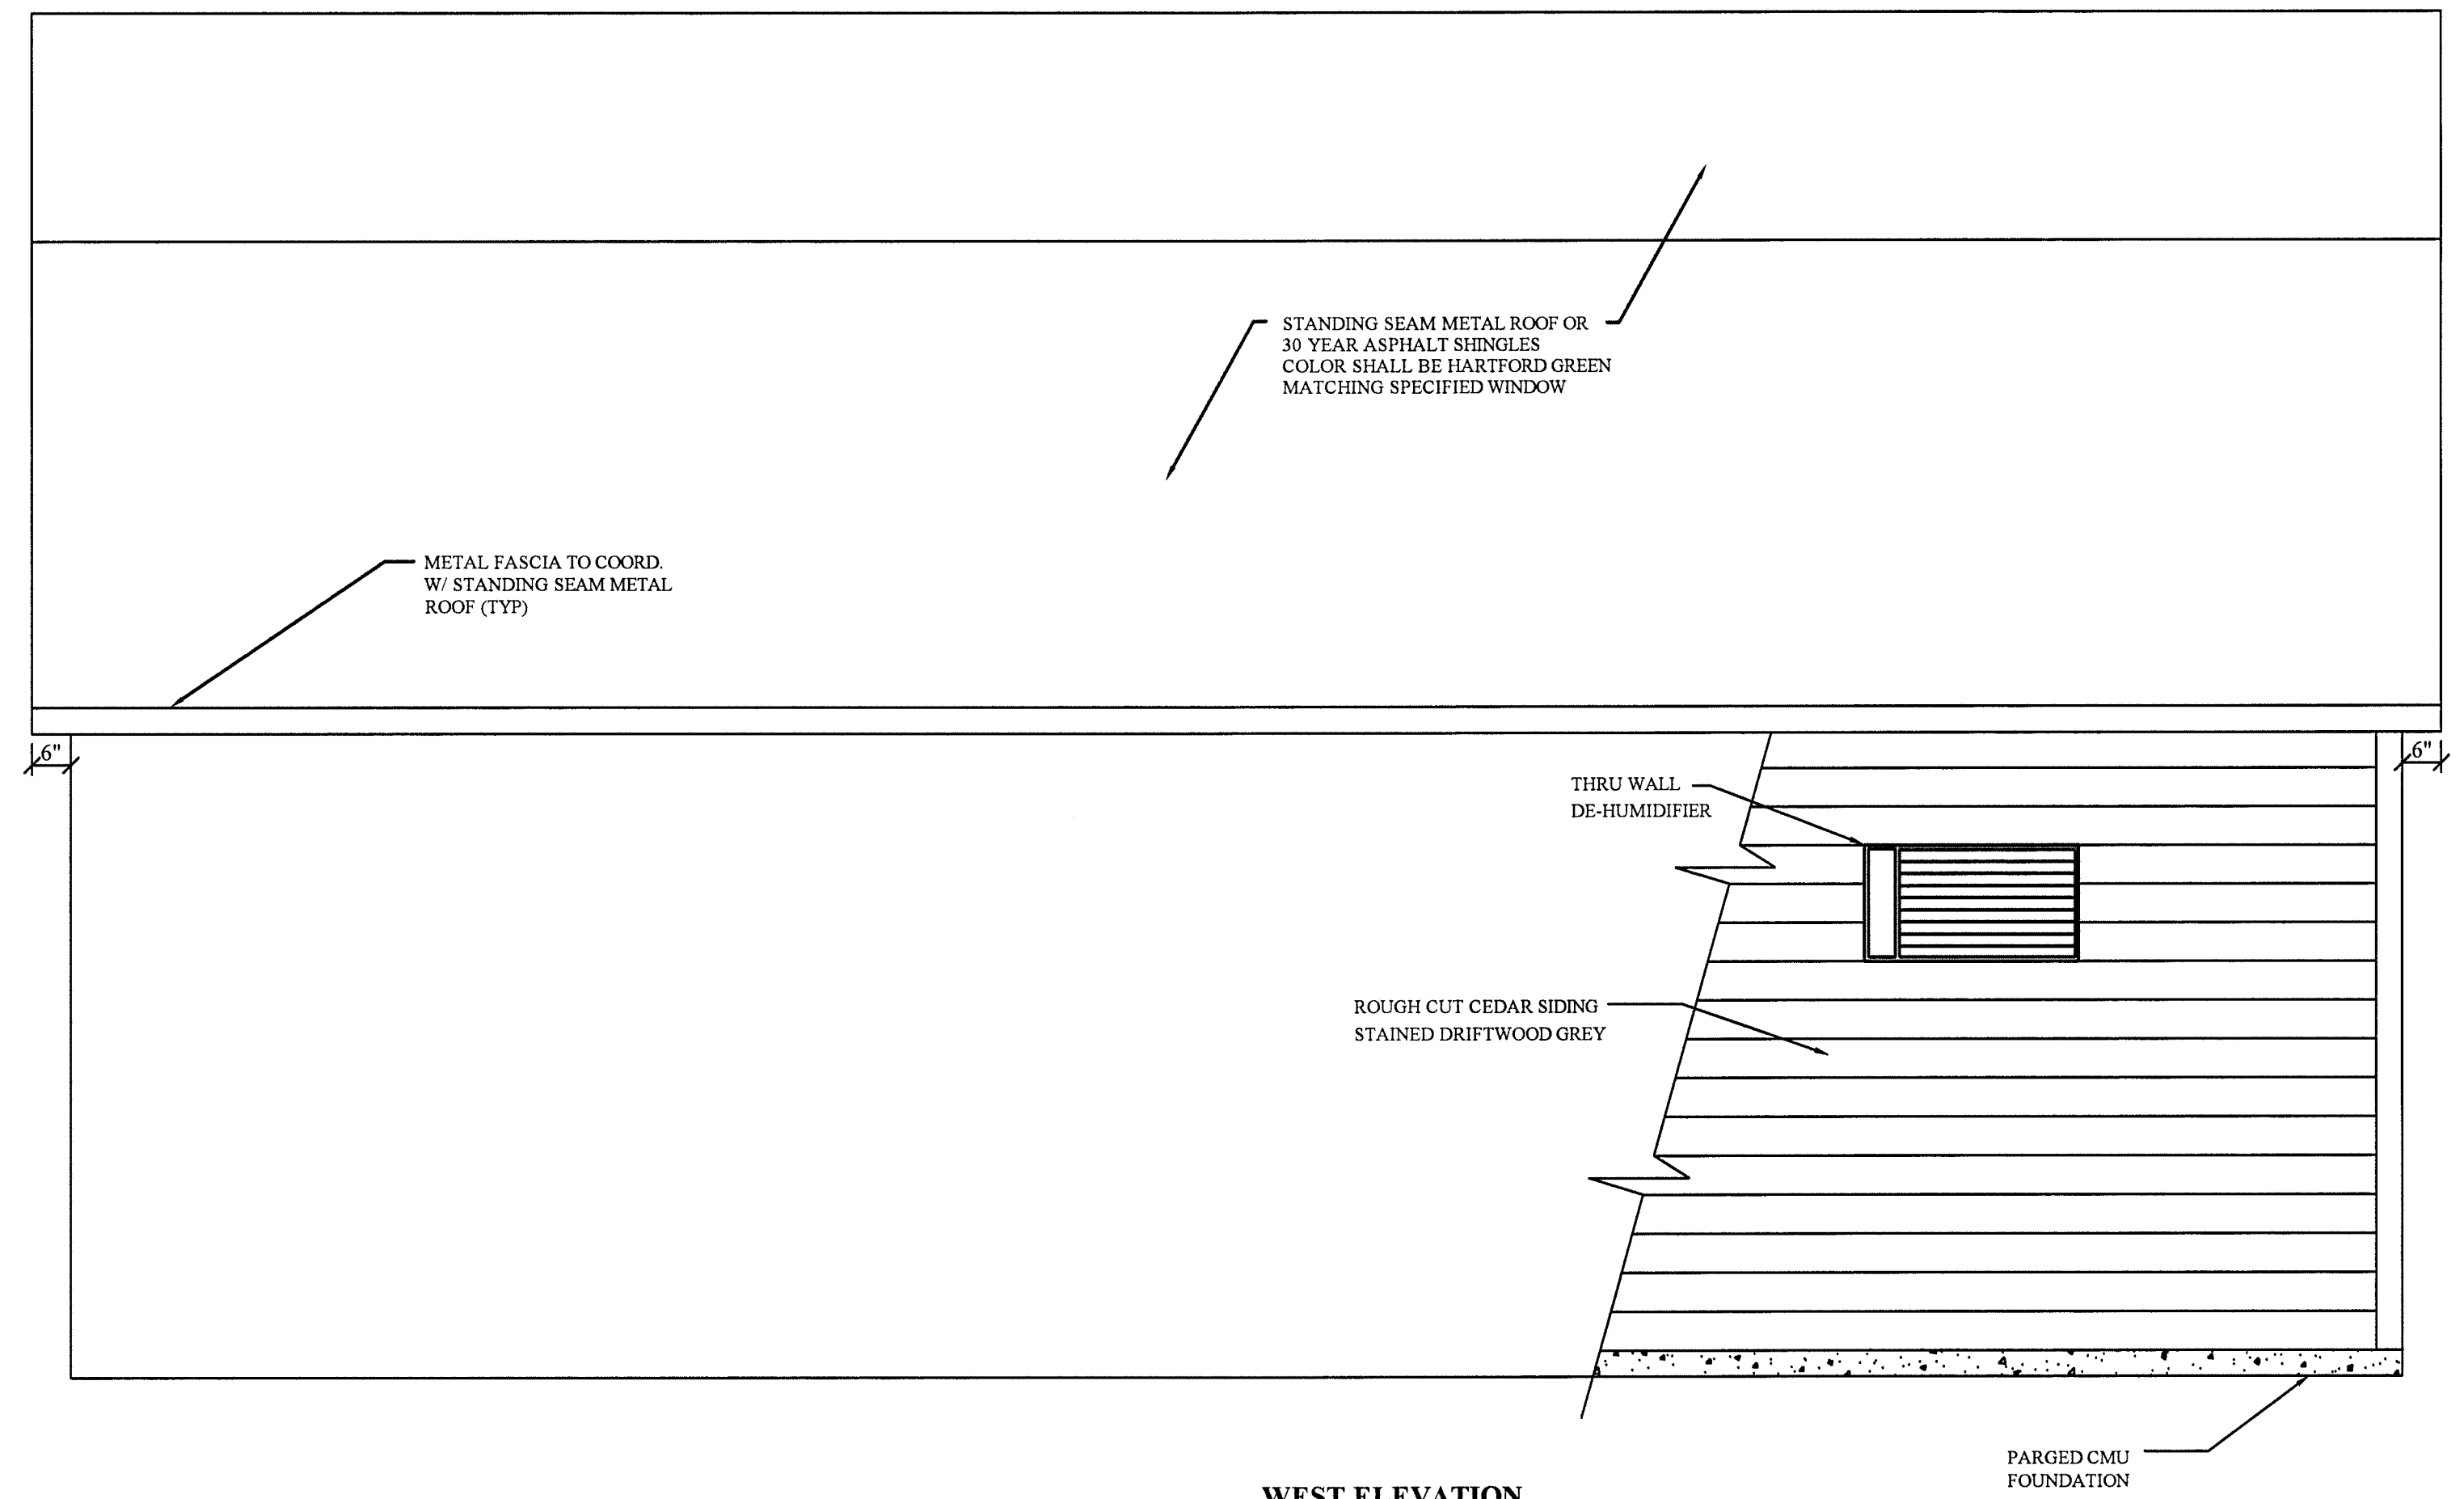


WEST ELEVATION
SCALE: 1/2" = 1'-0"

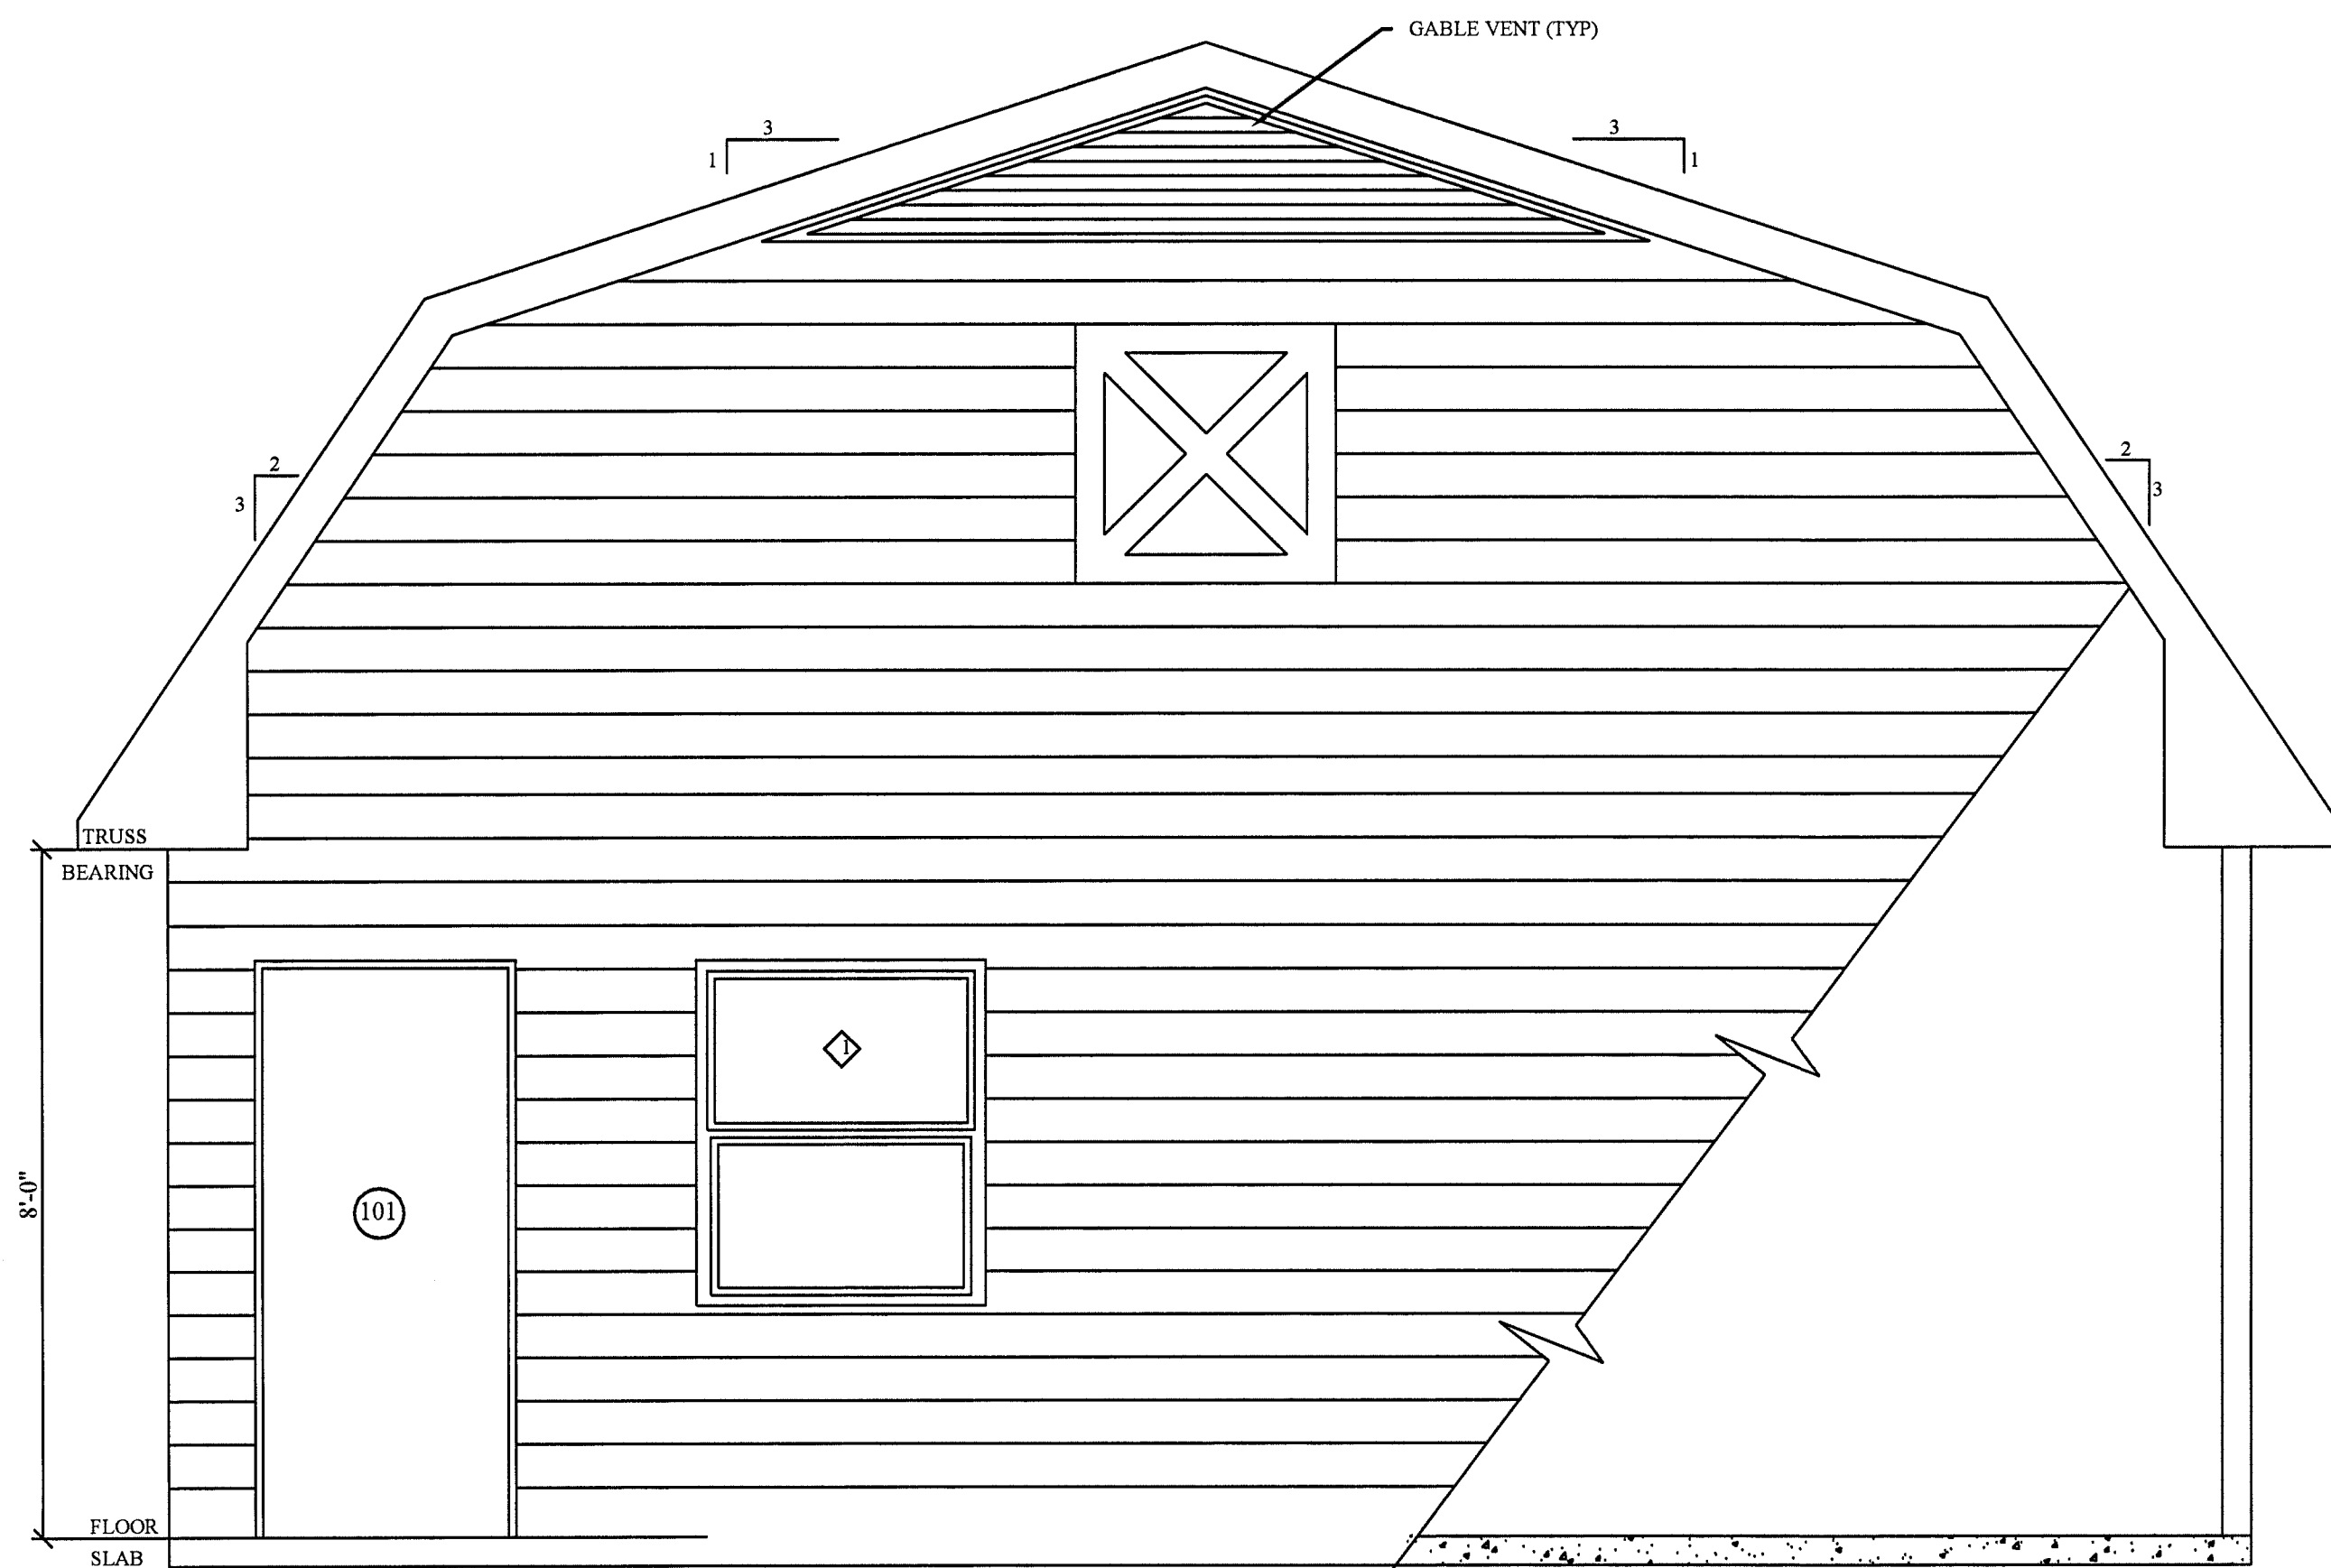

NORTH ELEVATION
SCALE: 1/2" = 1'-0"

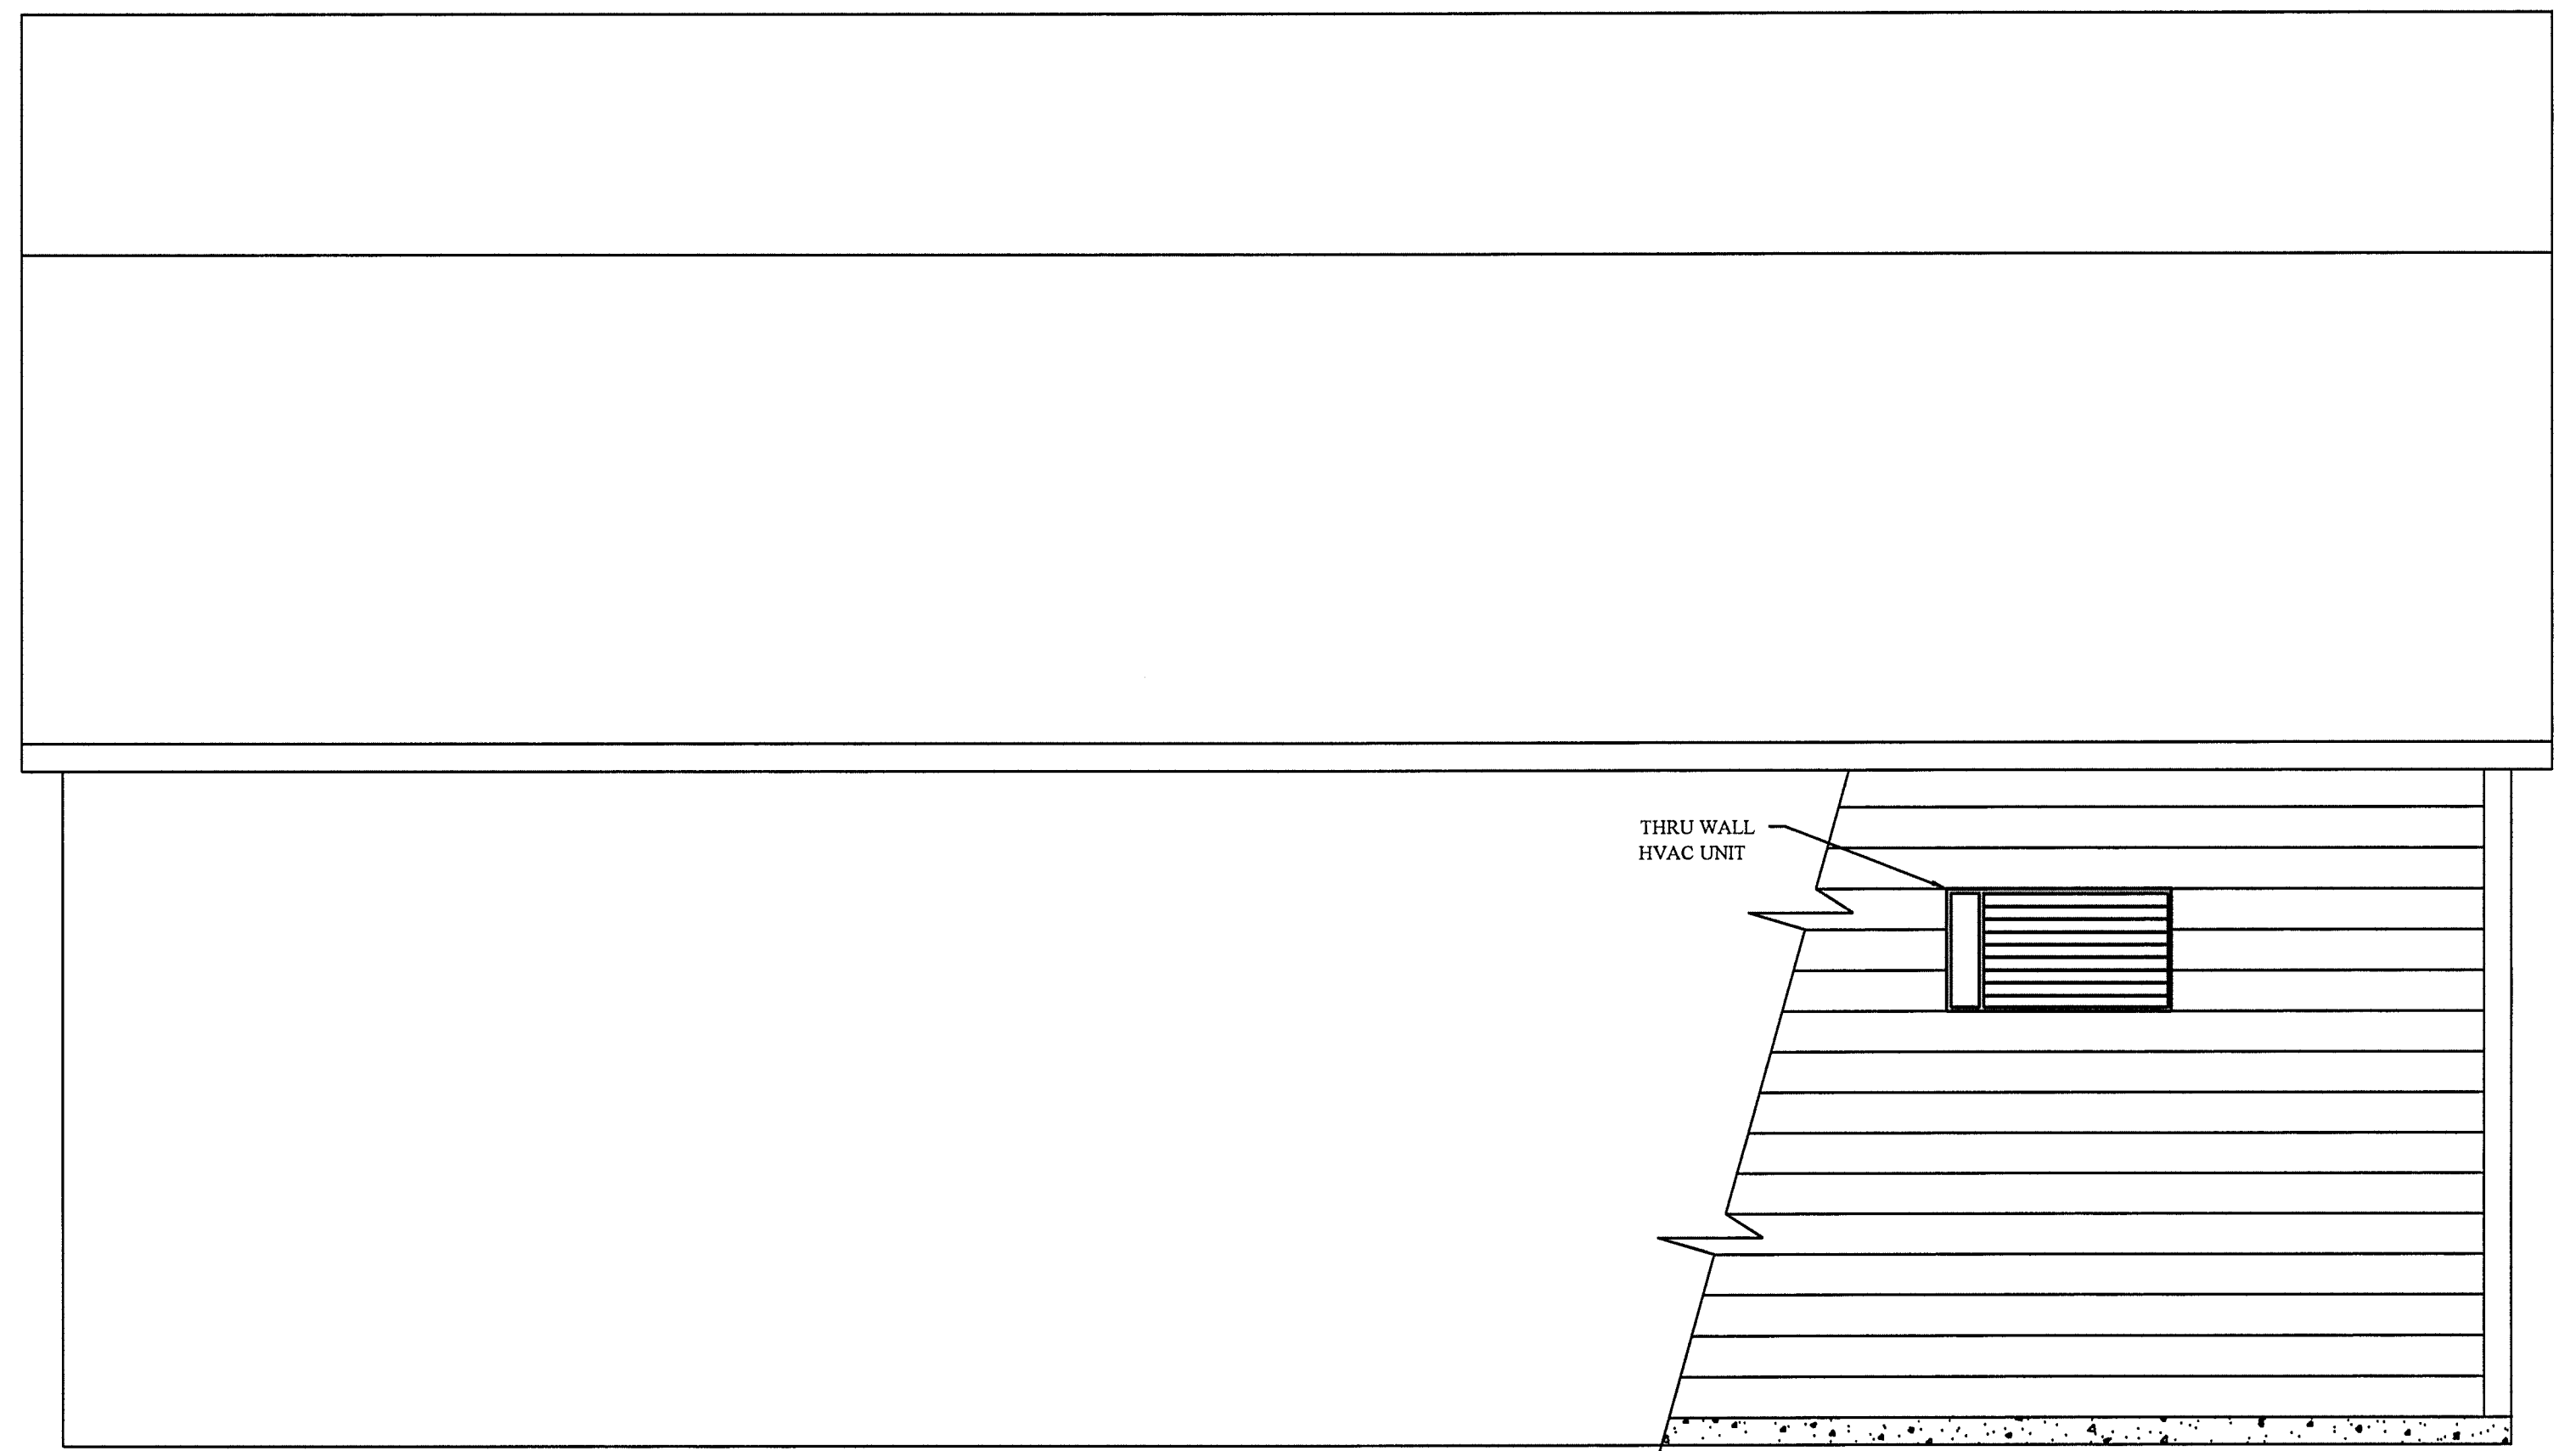

EAST ELEVATION
SCALE: 1/2" = 1'-0"

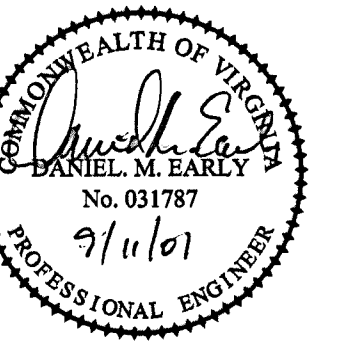

**ACS
DESIGN**

ENGINEERING • SURVEYING
LANDSCAPE ARCHITECTURE
CONSTRUCTION MANAGEMENT

2203 PETERS CREEK ROAD
ROANOKE, VIRGINIA 24017
P 540.562.2345 F 562.2344
INFO@ACSDSIGNLLC.COM
WWW.ACSDESIGNLLC.COM

**WESTLAKE VILLAGE
CENTRAL SEWER SYSTEM
FRANKLIN COUNTY, VIRGINIA**

DRAWN BY: JJD
DESIGNED BY: DME
CHECKED BY: JJD
DATE: 15 JUNE 2007
JOB NUMBER: 06145

REVISIONS:
No. 1
No. 2
No. 3
No. 4

SHEET NO.:
C5.2

WWTP LAB
BUILDING
ELEVATIONS