



BOOKER T. WASHINGTON NATIONAL MONUMENT
VISITOR CENTER

DESIGN AND CONSTRUCTION
DOCUMENTS FOR
VISITOR CENTER REHABILITATION

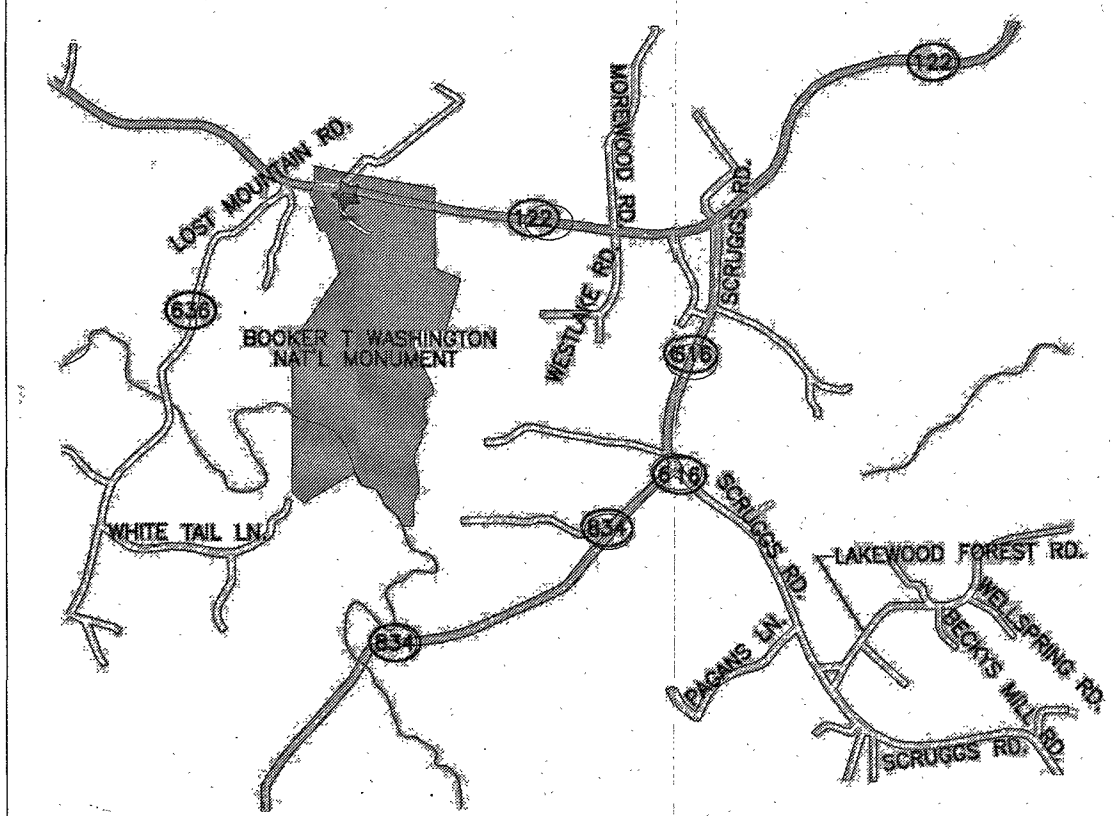

BOOKER T. WASHINGTON NATIONAL MONUMENT
VIRGINIA

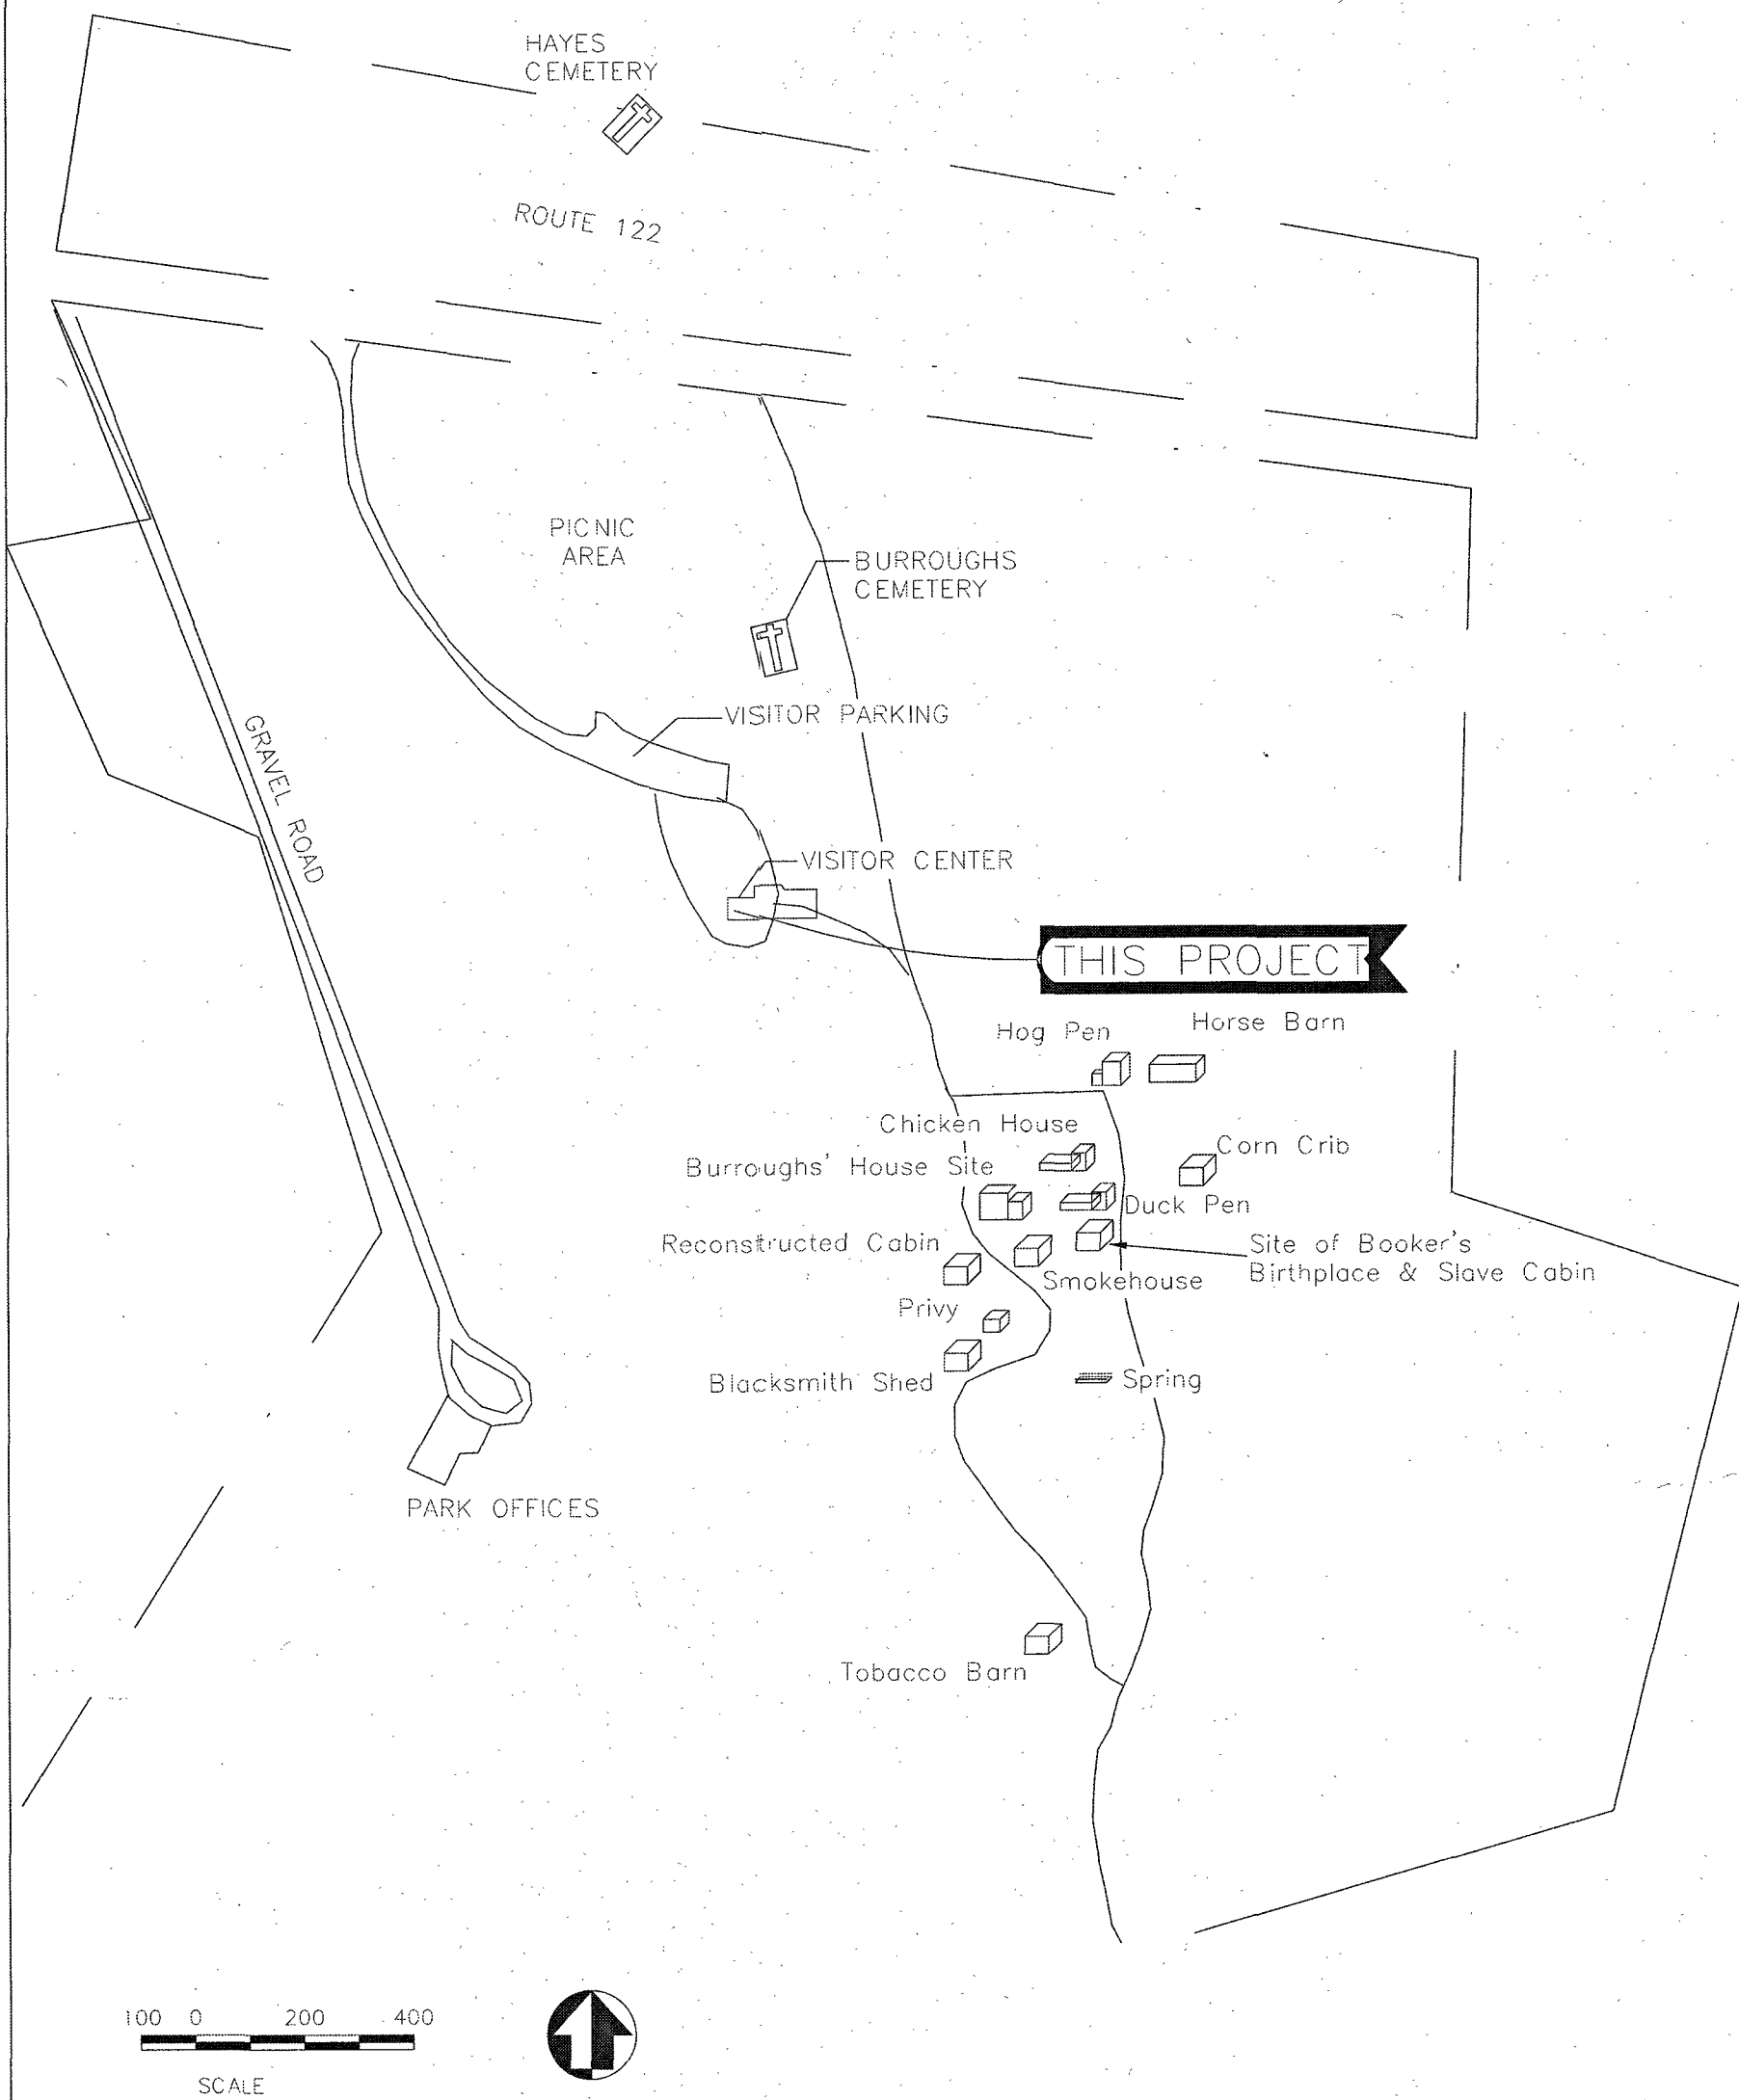

Drawing List - Master 2				
Sheet Number	Sheet Name	75% CDs	100% CDs	Final CDs
G101	Cover	X	X	X
C0	CIVIL GENERAL NOTES, LEGEND, ABBREVIATIONS AND INDEX SHEET	X		X
C1	EXISTING CONDITIONS	X		X
C2	ACCESS AND STAGING PLAN	X		X
C3	OVERALL SITE PLAN	X		X
C4	ENLARGED SITE PLAN NORTH	X		X
C5	ENLARGED SITE PLAN SOUTH	X		X
C6	PROFILES			X
C7	PROFILES			X
C8	CIVIL DETAILS			X
A1	SITE PLAN	X	X	X

Drawing List - Master 2				
Sheet Number	Sheet Name	75% CDs	100% CDs	Final CDs
P1	PLUMBING FLOOR PLAN, LEGENDS, SYMBOLS AND GENERAL NOTES			X
F1	GENERAL NOTES	X	X	X
F2	FIRE PROTECTION BASEMENT LEVEL SPRINKLER LAYOUT	X	X	X
F3	FIRE PROTECTION LEVEL ONE SPRINKLER LAYOUT	X	X	X
F4	FIRE PROTECTION ATTIC SYSTEM SPRINKLER LAYOUT	X	X	X
F5	FIRE PROTECTION DETAILS	X	X	X
F6	FIRE ALARM RISER AND RISER NOTES	X	X	X
F7	FIRE ALARM BASEMENT LEVEL	X	X	X

PMIS NO. 163551/ 211607

12/10/15 17:58 S:\CALLEY R20 W\DC P-DRIVE\2015\2015060\USO EXISTING CONDITIONS\633 DRAWINGS\PDF\2010 SET\PDF-10-9-2015\USO\USO VICINITY PLAN.JPG

EYP Inc. 1000 POTOMAC STREET NW, WASHINGTON, DC 20007	Mark	Sheet	REVISION	Date	Initial	QUALITY DESIGN CERTIFICATION ☐ Prepared in Accordance with Preliminary Design (Title I) OR ☐ Variance from Preliminary Design (Title I) Approved by Superintendent on _____ Date _____ OR ☐ Construction Drawing Not Preceded by Preliminary Design (Title I) Project Manager _____ Date _____		UNITED STATES DEPARTMENT OF THE INTERIOR NATIONAL PARK SERVICE DENVER SERVICE CENTER	TITLE OF PROJECT DESIGN AND CONSTRUCTION DOCUMENTS FOR VISITOR CENTER REHABILITATION LOCATION WITHIN PARK BOOKER T. WASHINGTON NATIONAL MONUMENT VISITOR CENTER NAME OF PARK BOOKER T. WASHINGTON NATIONAL MONUMENT			DRAWING NO. 404 80032
	REGION NORTHEAST	COUNTY FRANKLIN	STATE VIRGINIA	PKG. NO.	SHEET							
					1							
					OF 19							