


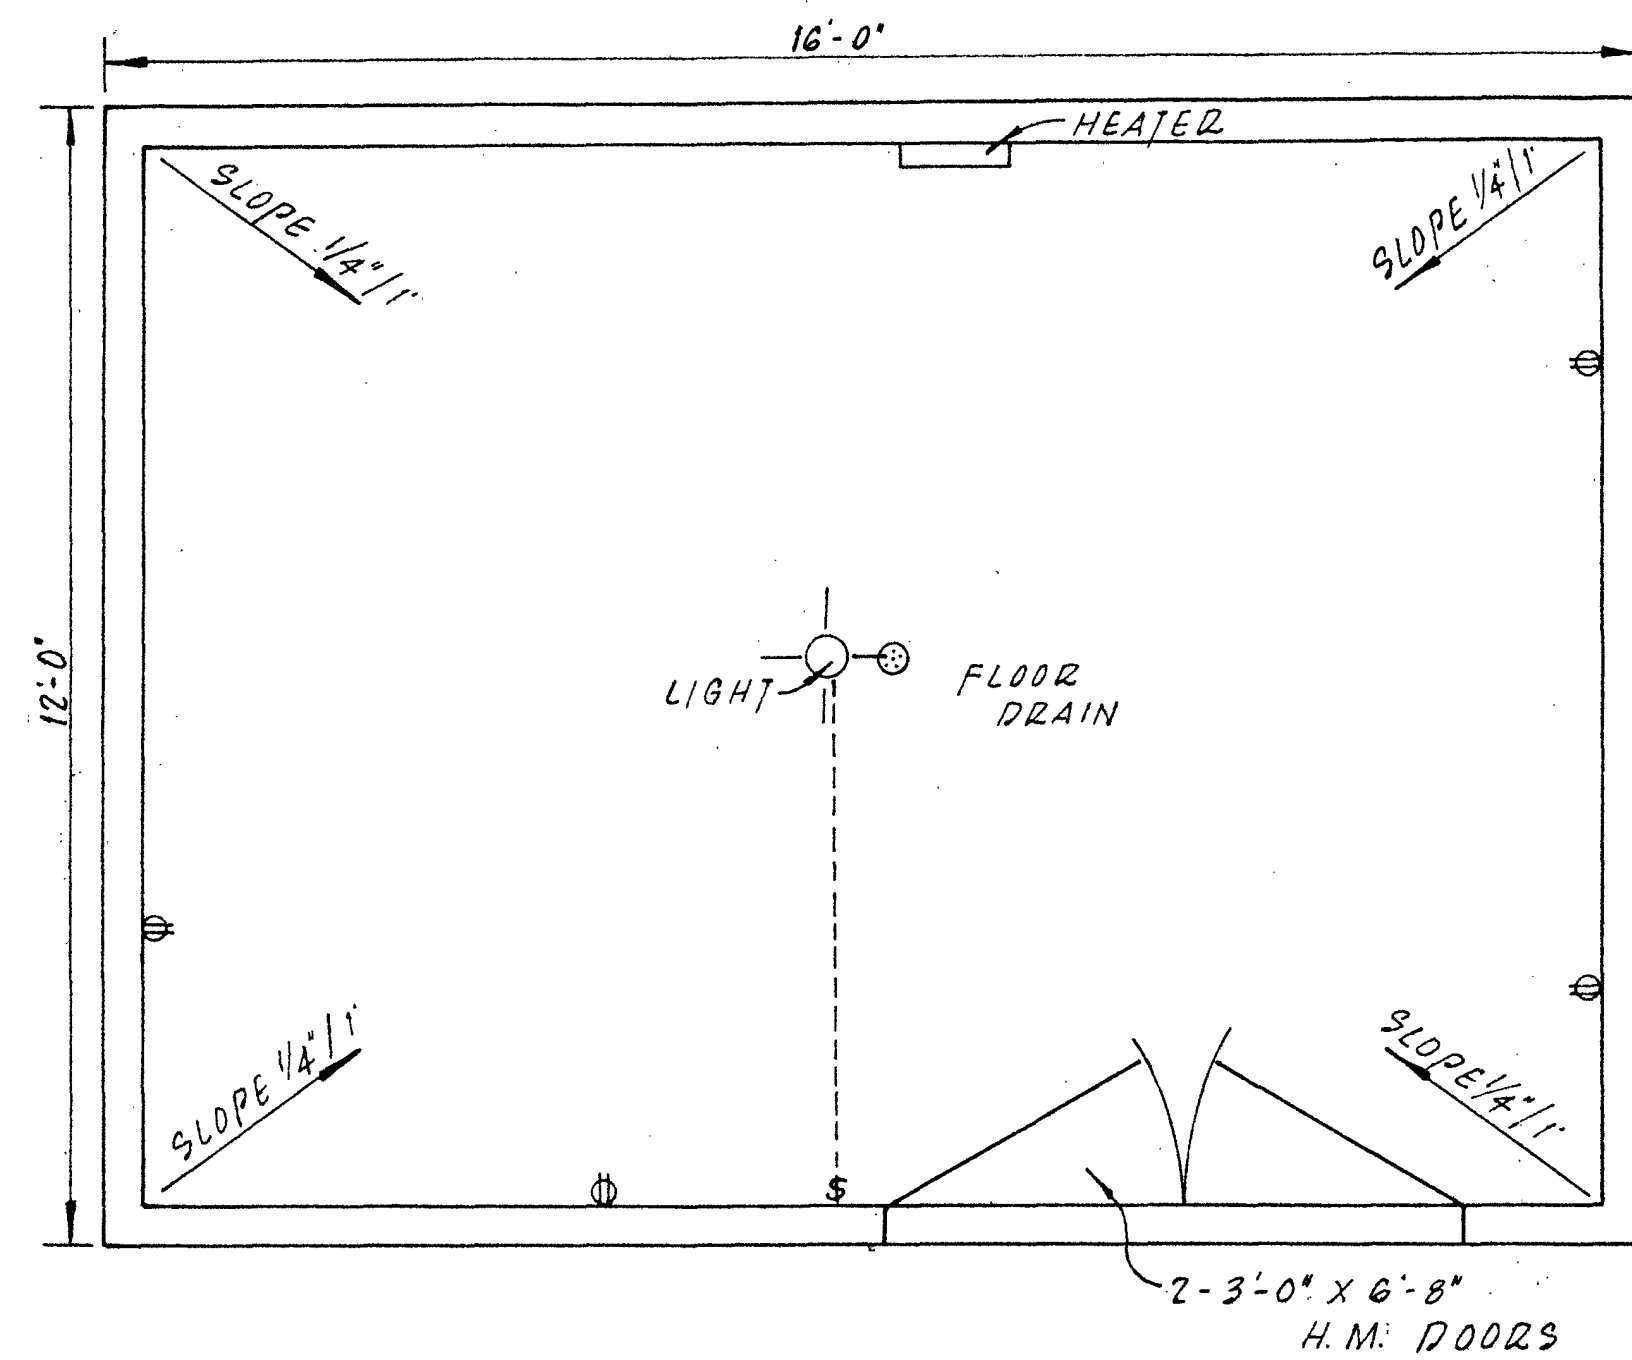


PUMP HOUSE PLAN


ITEM	DESCRIPTION
PUMP	GOULDS MODEL 18E 50412 - 5 HP-1/-230V 27 GPM @ 412' THD.
RISER PIPE	2" GALV.
REDUCER	1 1/2" X 2" (REQ'D)
TEES	2" X 2" GAL. (REQ'D)
CHECK VALVES	2" MUELLER, WATTS OR EQUAL (REQ'D)
GATE VALVES	2" MUELLER, WATTS OR EQUAL (REQ'D)
METER	BADGER MODEL 25L W/IDLER (REQ'D)
DISCHARGE PIPING	2" PVC TO DISTRIBUTION
SPACE HEATER	230V 500W SINGER
AIR RELEASE VALVE	HOFFMAN MODEL 79 OR EQUAL

WELL HEAD SPECIFICATIONS


ITEM	DESCRIPTION
PUMP	GOULDS MODEL 18E 50412 - 5 HP-1/-230V 27 GPM @ 412' THD.
RISER PIPE	2" GALV.
REDUCER	1 1/2" X 2" (REQ'D)
TEES	2" X 2" GAL. (REQ'D)
CHECK VALVES	2" MUELLER, WATTS OR EQUAL (REQ'D)
GATE VALVES	2" MUELLER, WATTS OR EQUAL (REQ'D)
METER	BADGER MODEL 25L W/IDLER (REQ'D)
DISCHARGE PIPING	2" PVC TO DISTRIBUTION
SPACE HEATER	230V 500W SINGER
AIR RELEASE VALVE	HOFFMAN MODEL 79 OR EQUAL

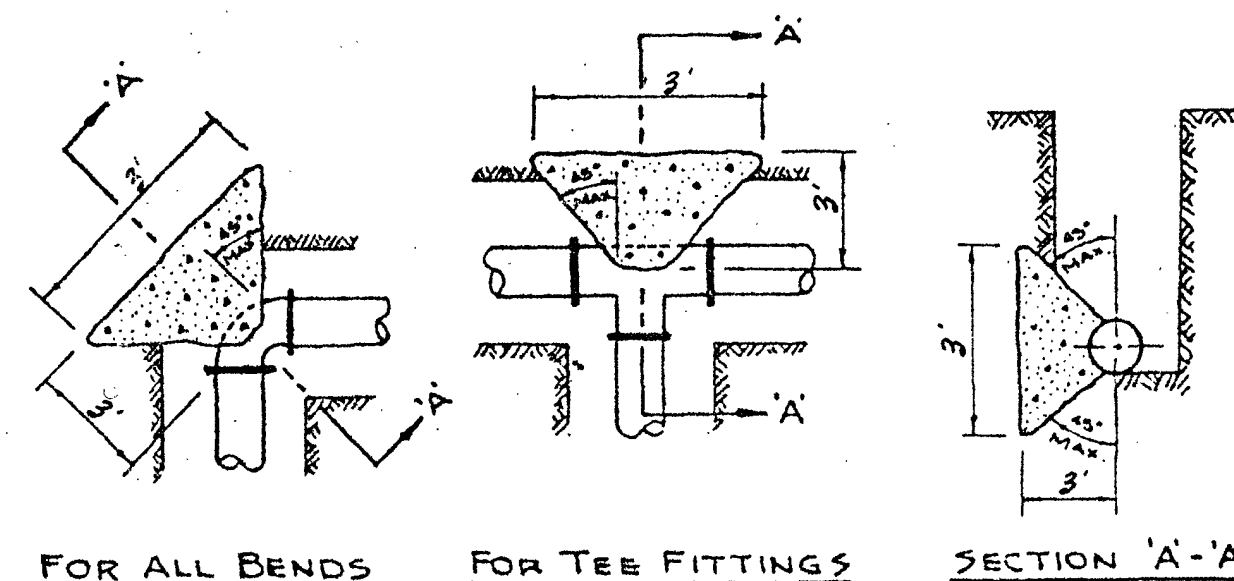


TYPE 'F' ANCHOR

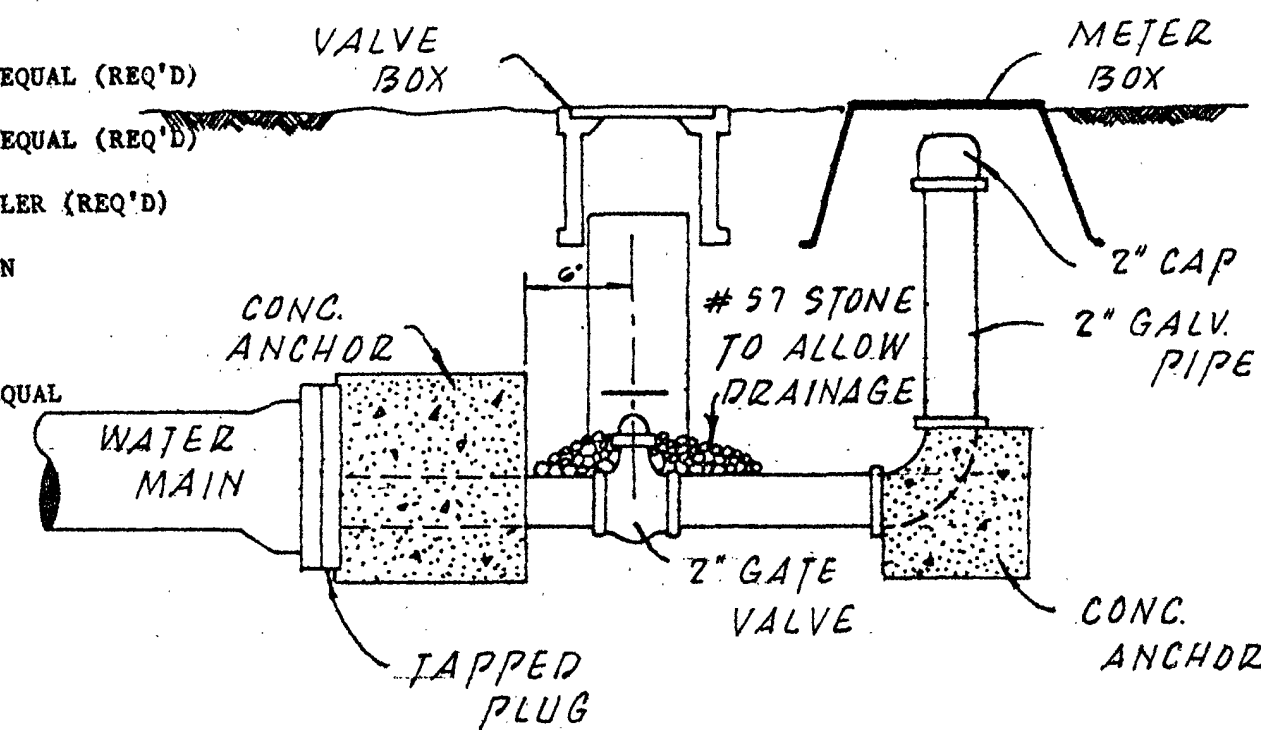


2" BLOW-OFF ASSEMBLY

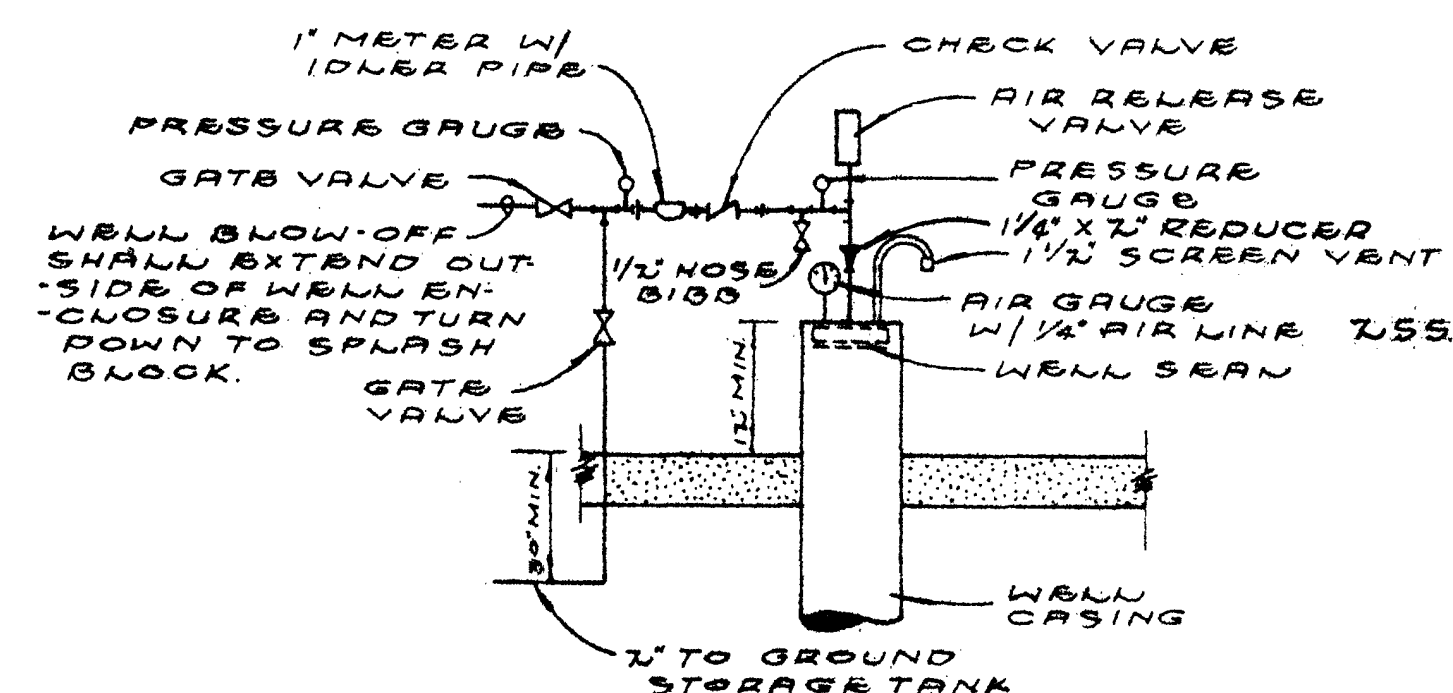


WELL DETAIL

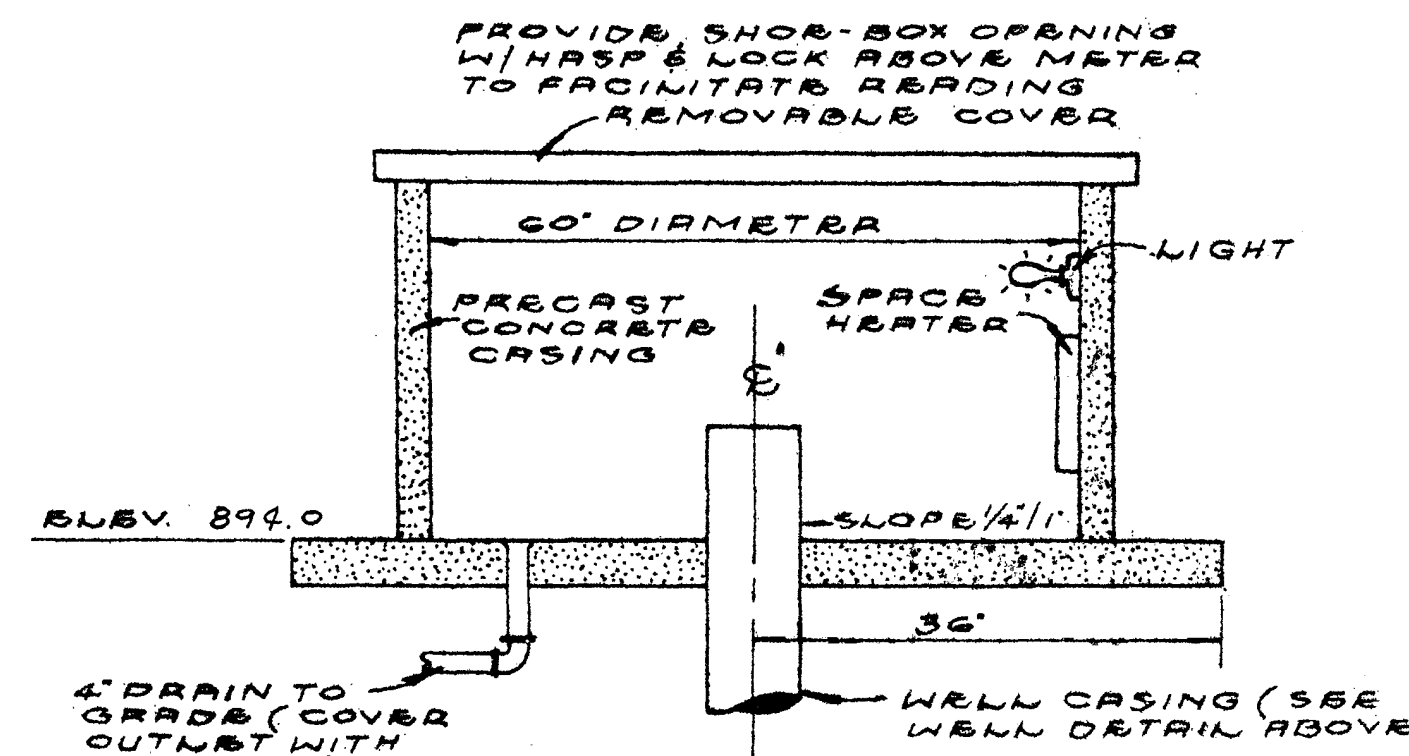

WELL HOUSING DETAIL

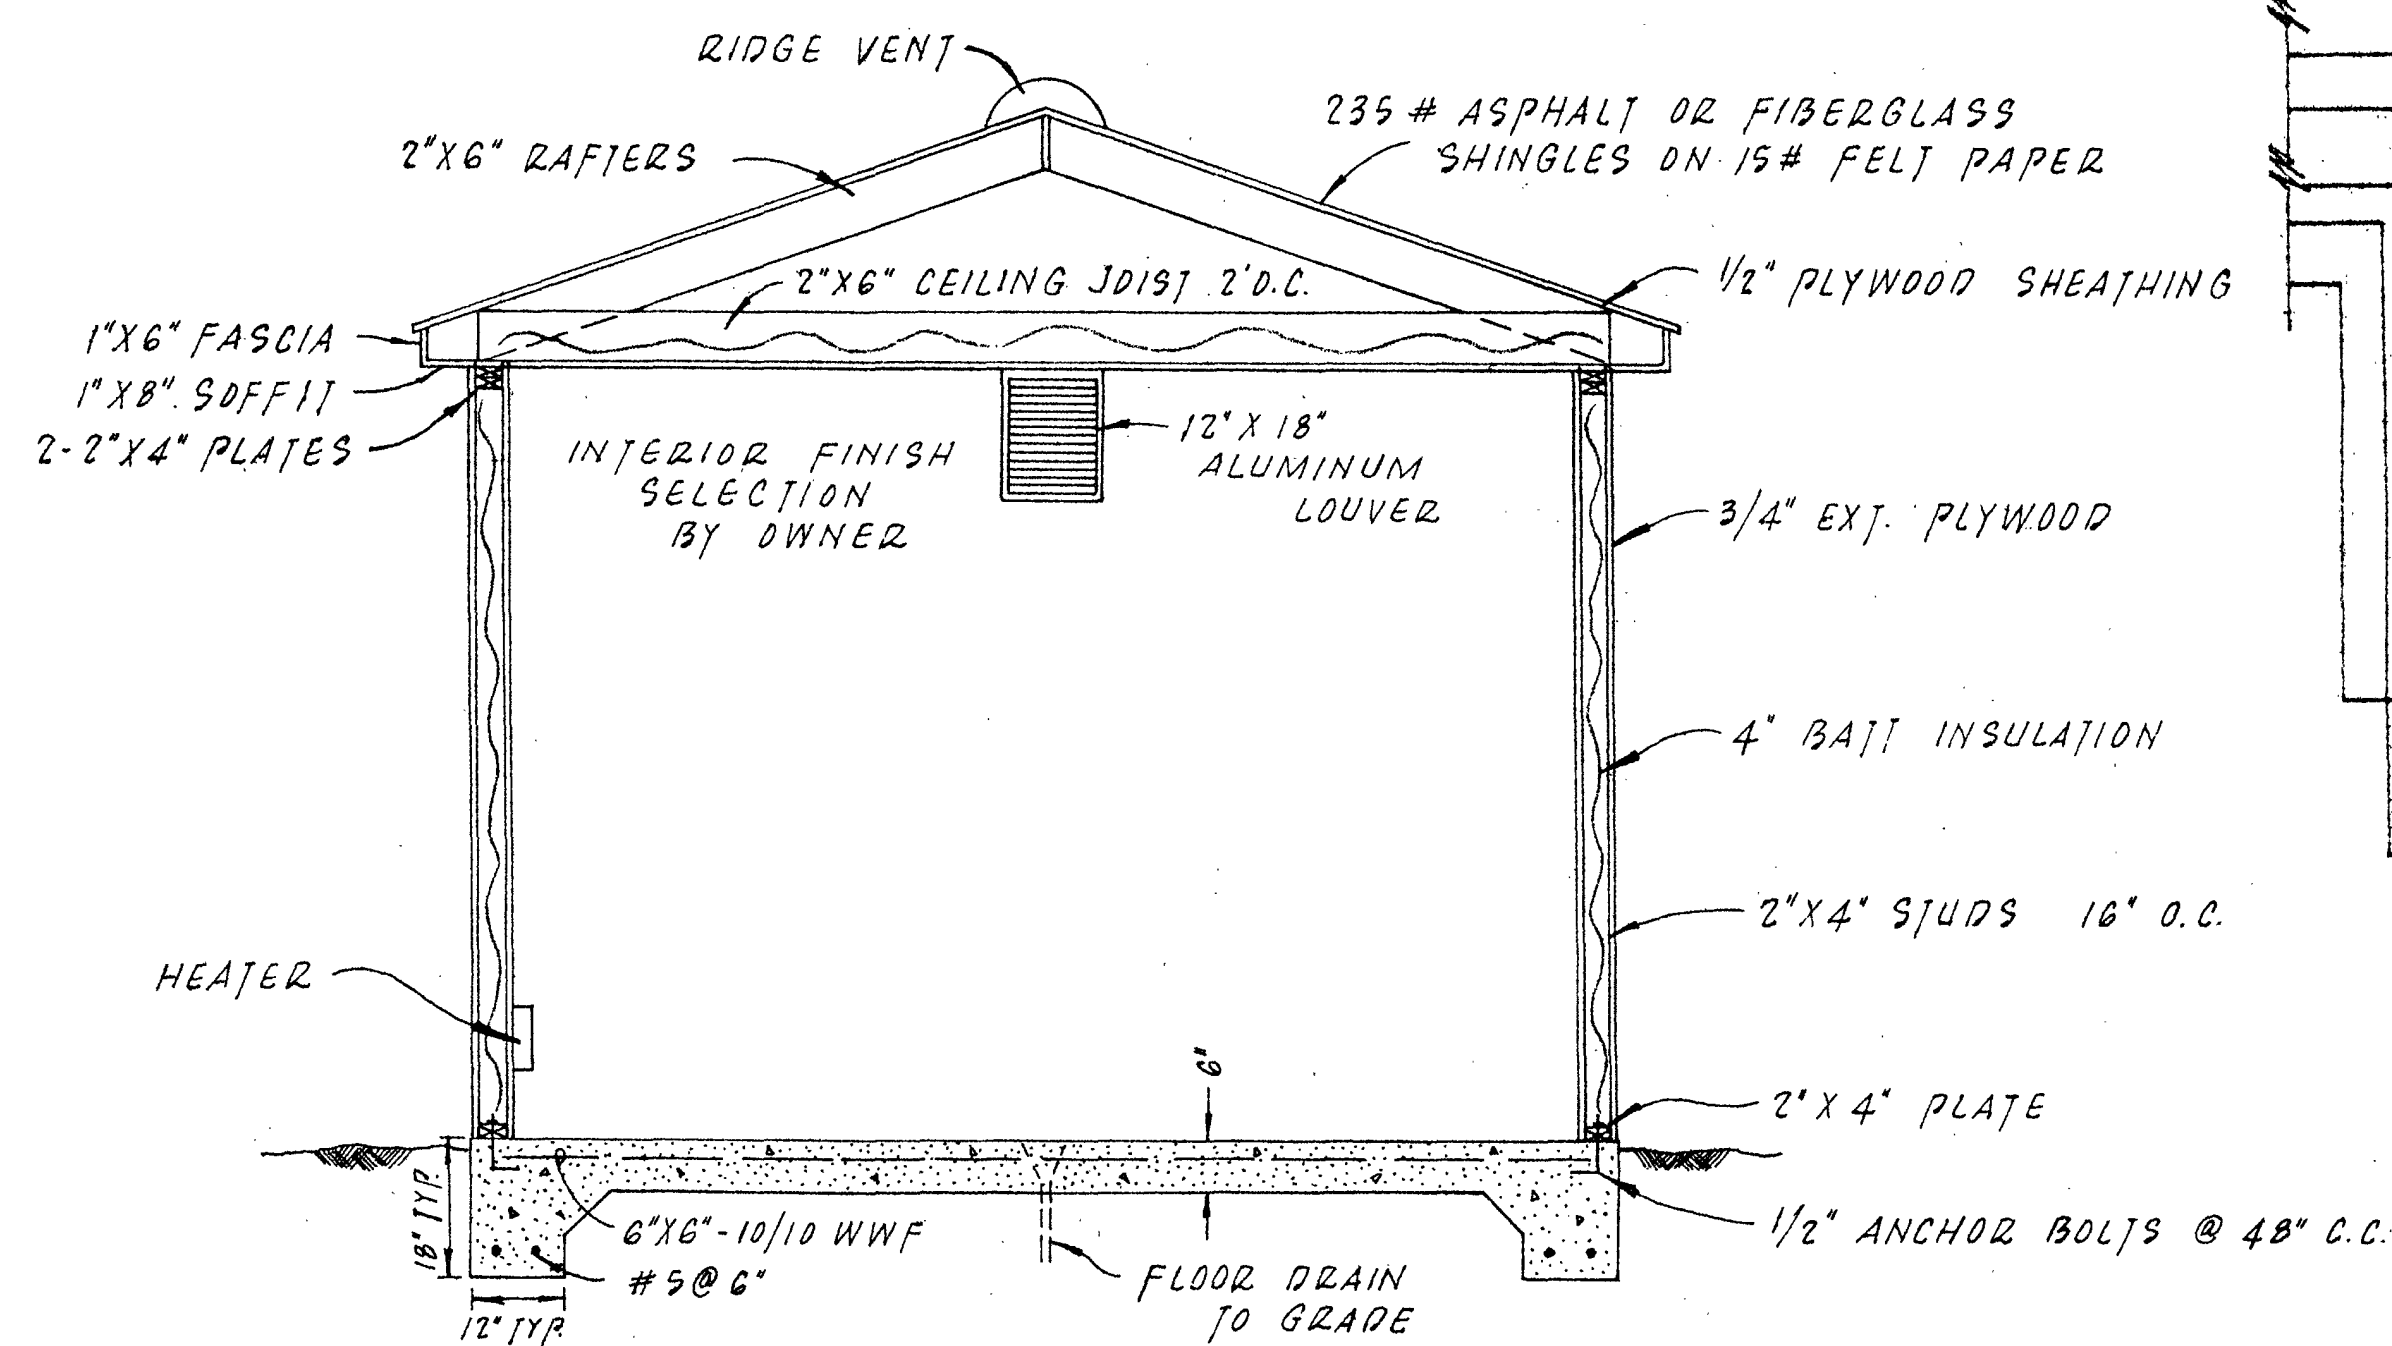


SECTION A-A


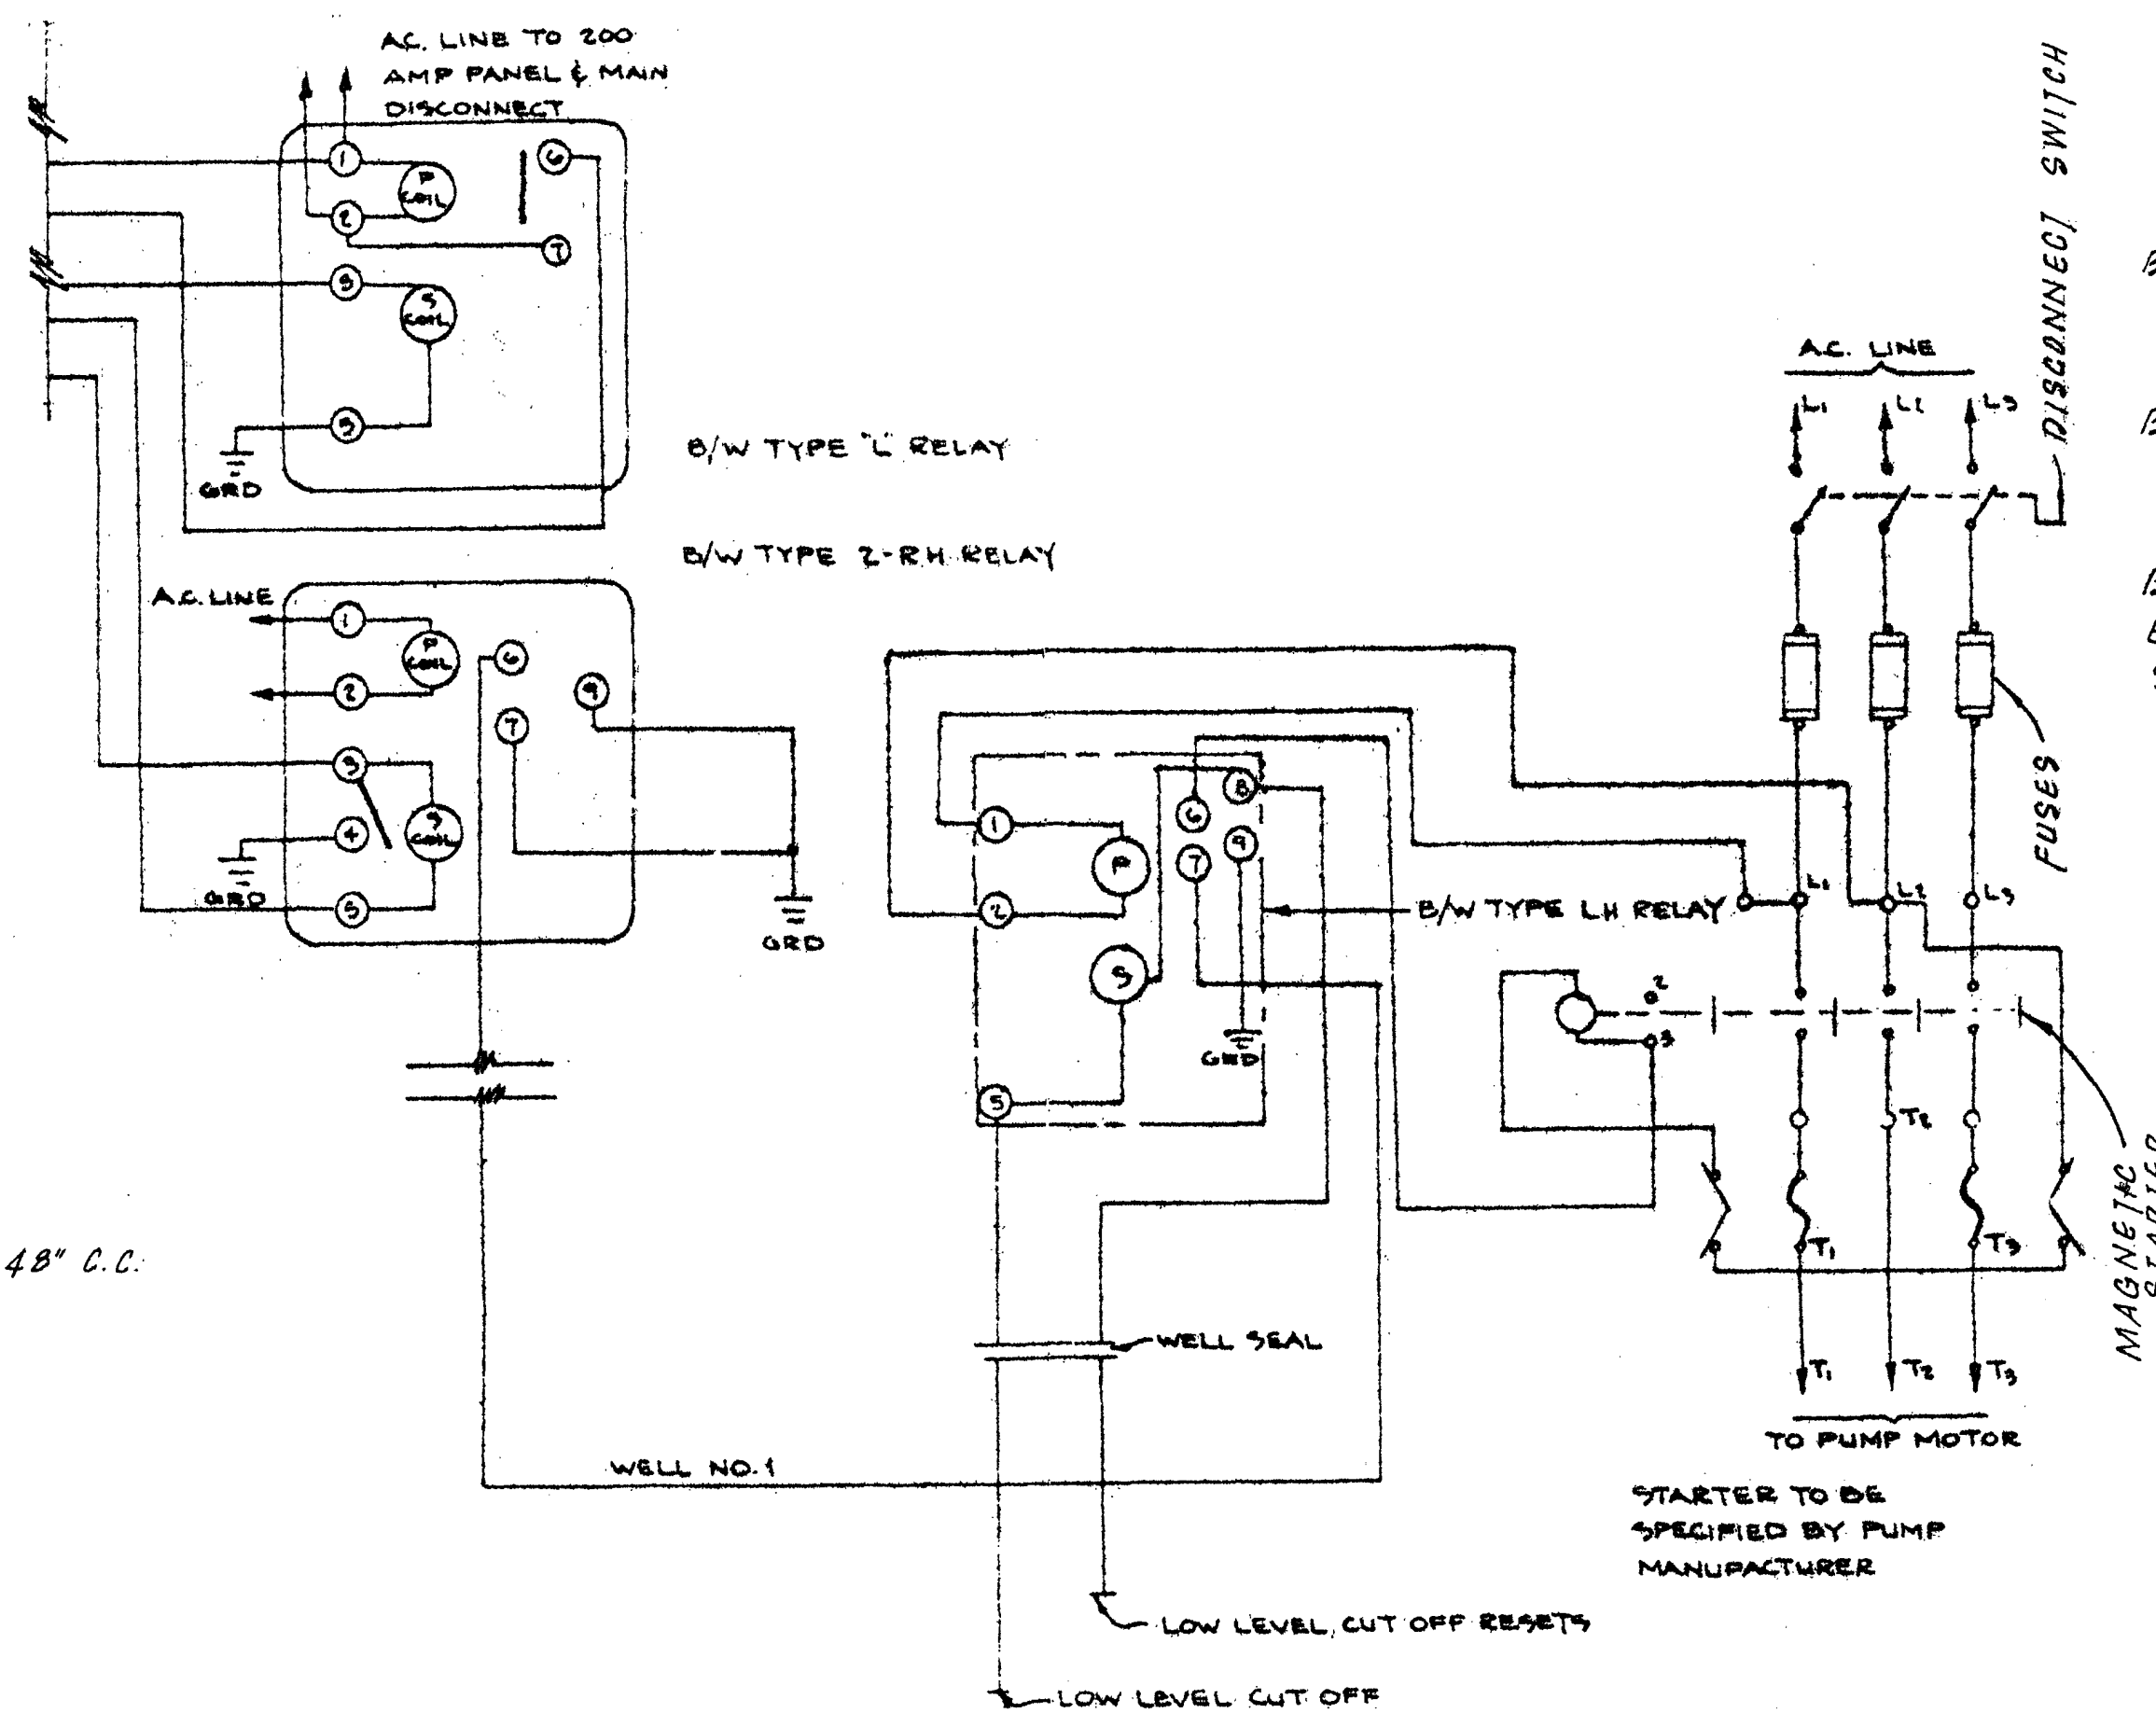


TYPICAL CONTROLS AT WELL

- B-W CORD GRIP ELECTRODE HOLDER
- B-W TYPE S-W SUSPENSION LINE
- B-W TYPE E-15 SHIELDED ELECTRODES (#316 STAINLESS STEEL) 2 REQ'D/WELL

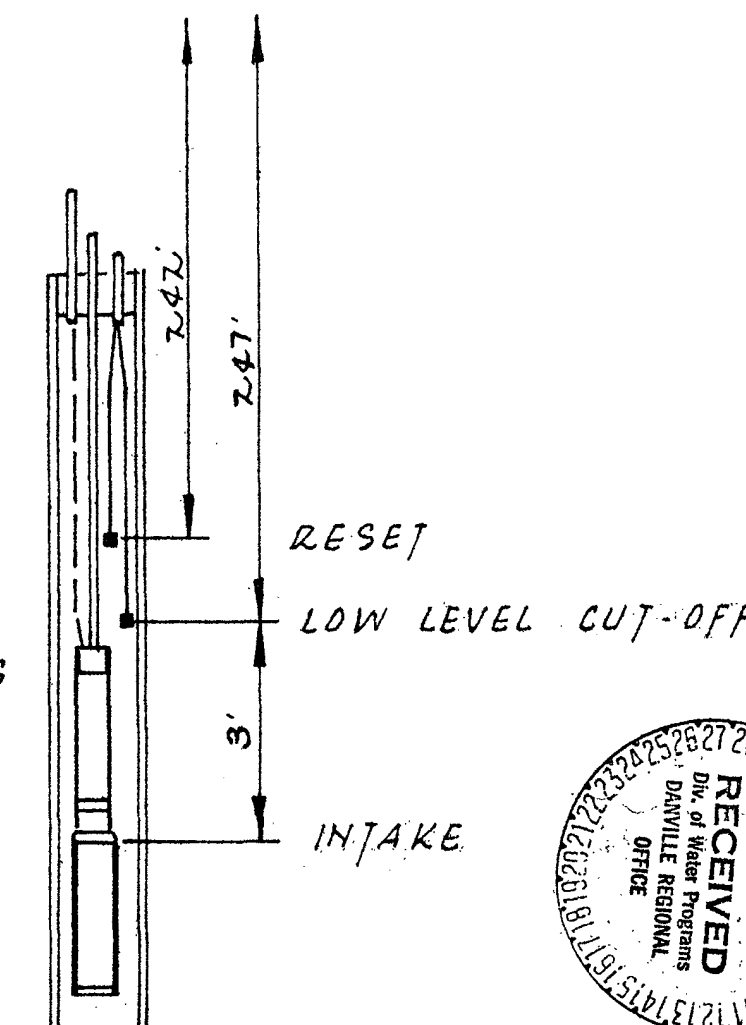

PUMP CONTROLS SCHEMATIC

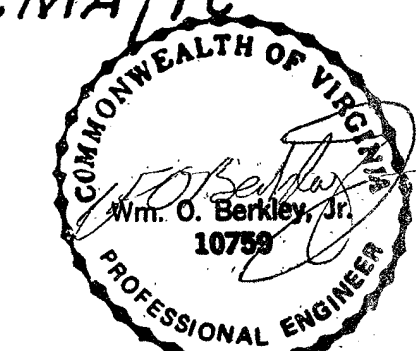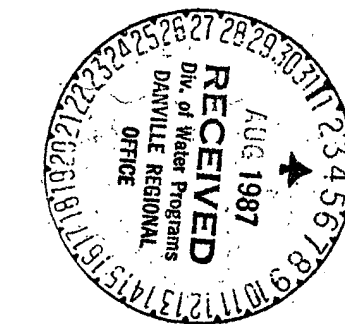

Berkley Howell & Assoc.			
ENGINEERS • SURVEYORS • PLANNERS			
SCALE:	APPROVED BY:	DRAWN BY:	
DATE: 6-15-67		REVISED 7-23-67	
CEDAR RIDGE SUBDIVISION			
CENTRAL WATER SYSTEM			
MISC. DETAILS			DRAWING NUMBER
			7 OF 7