




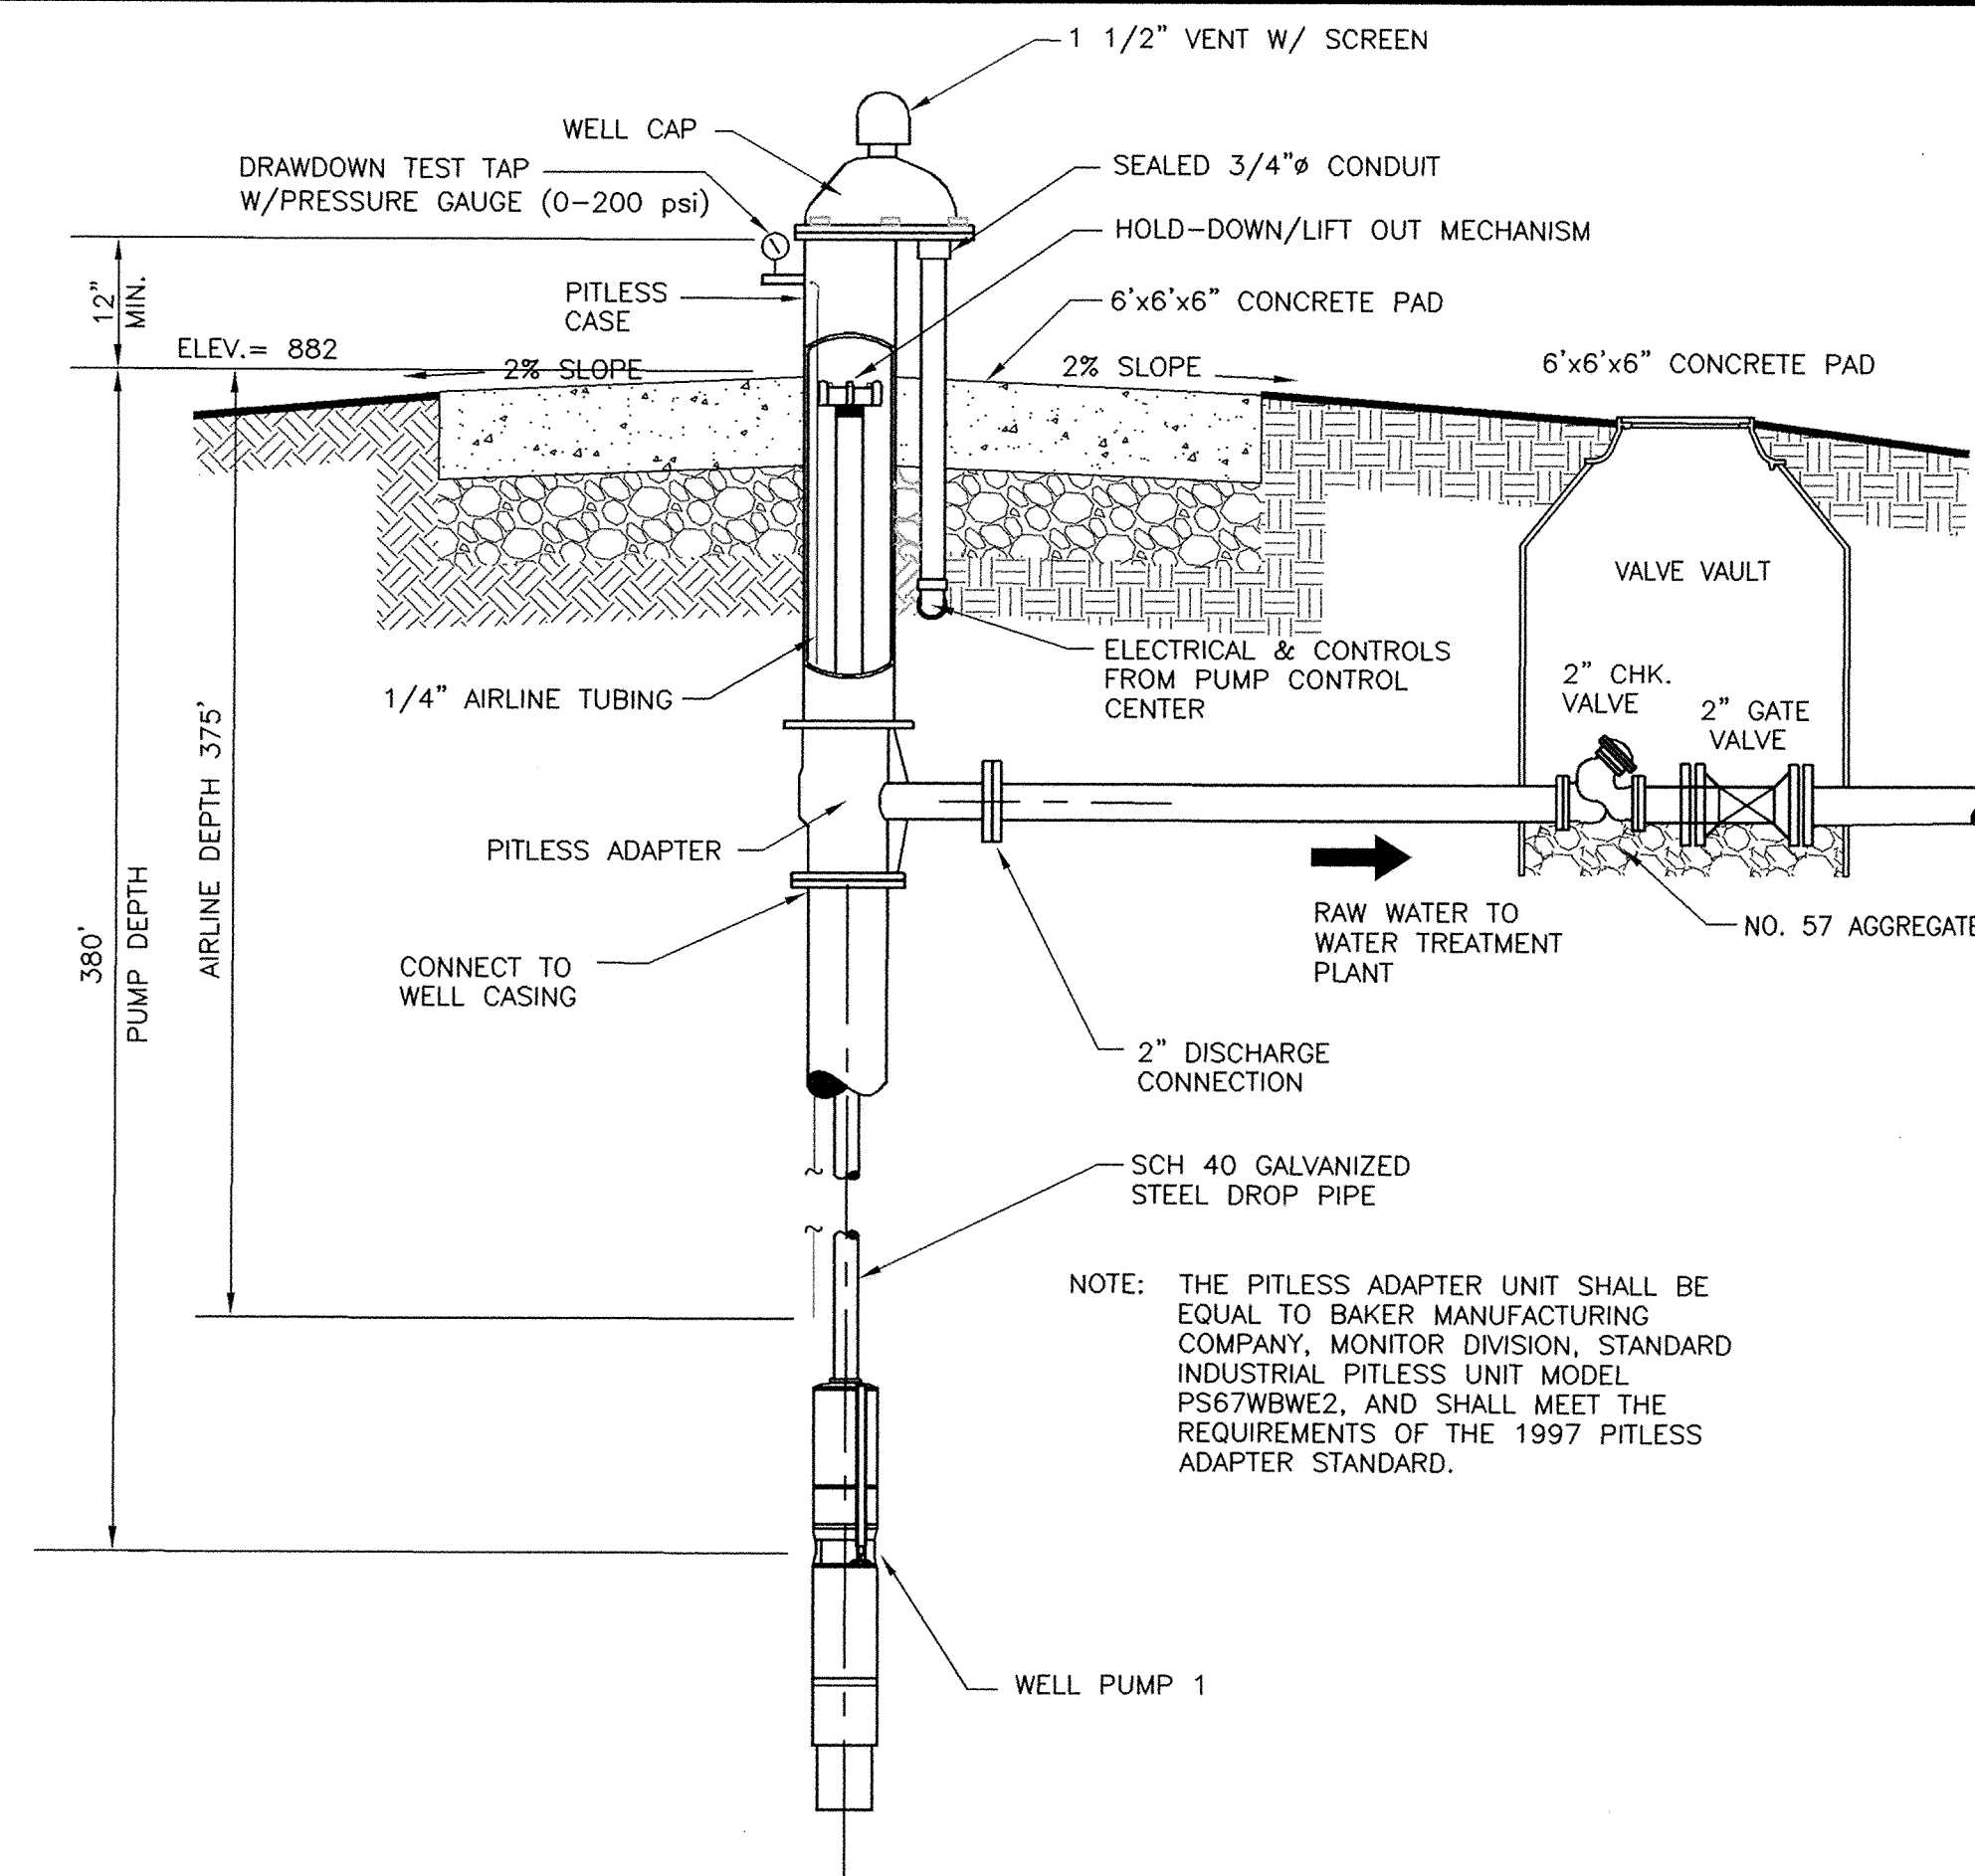

SECTION - WELL 1
NOT TO SCALE

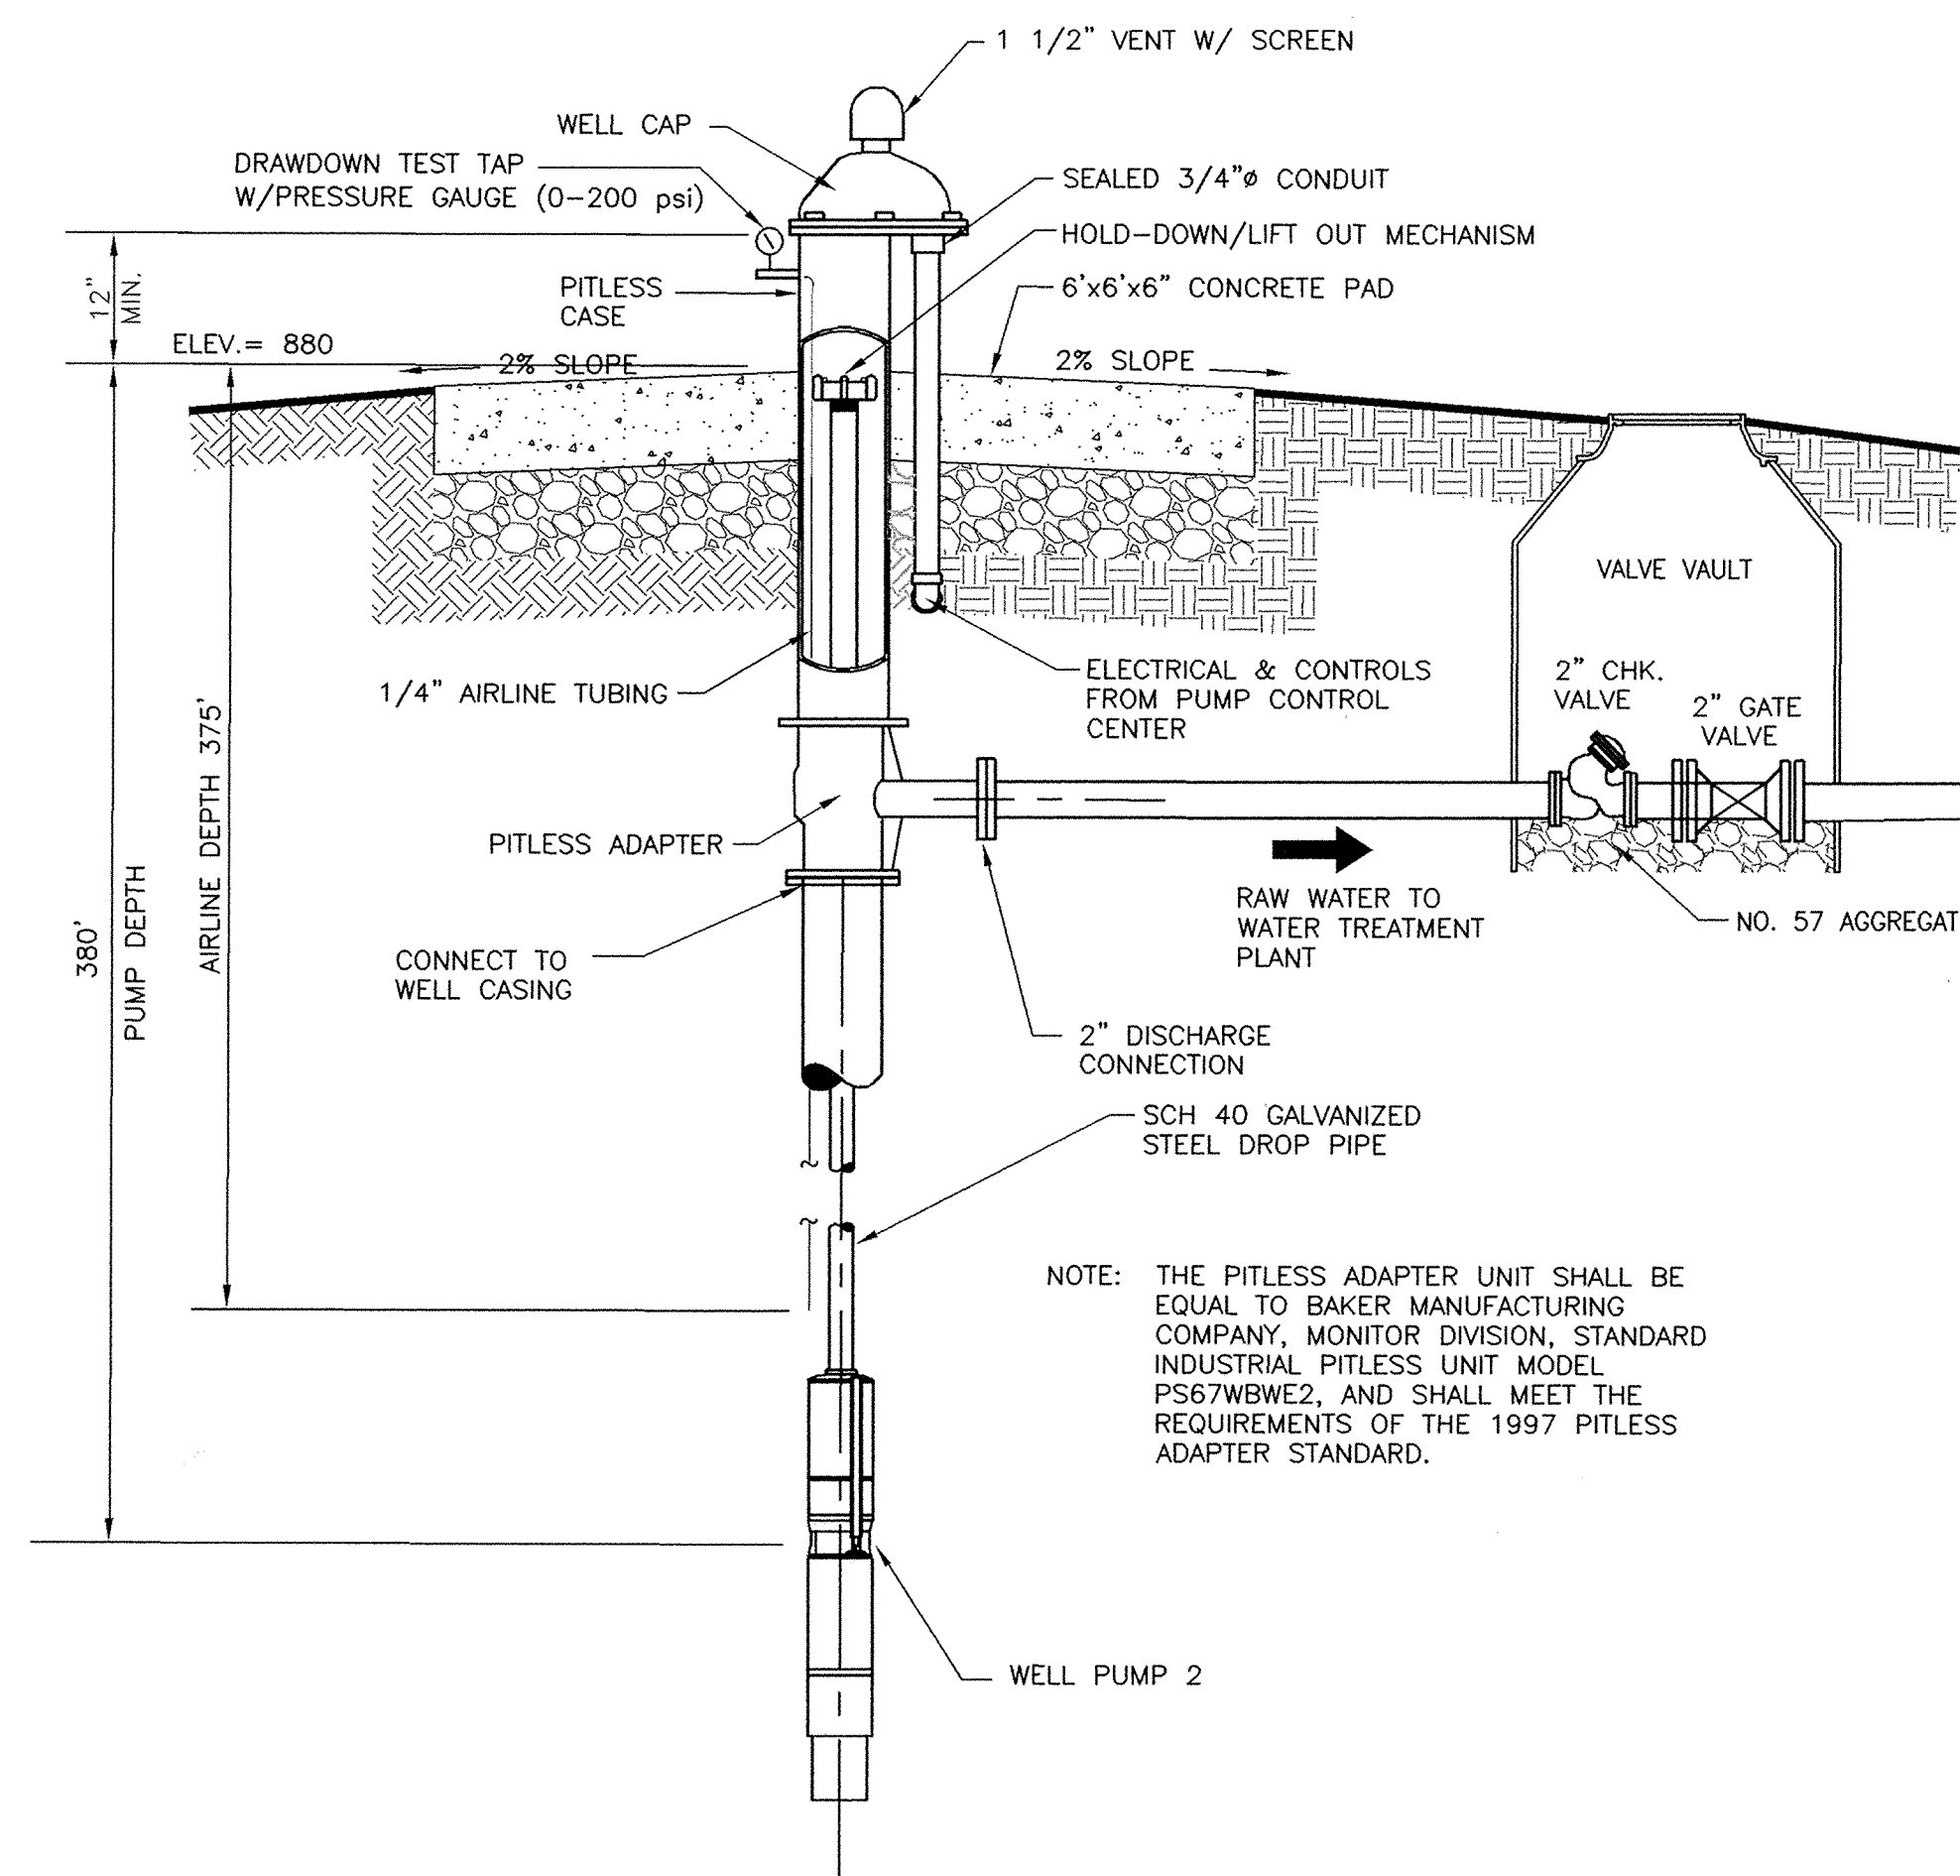


SECTION - WELL 2
NOT TO SCALE

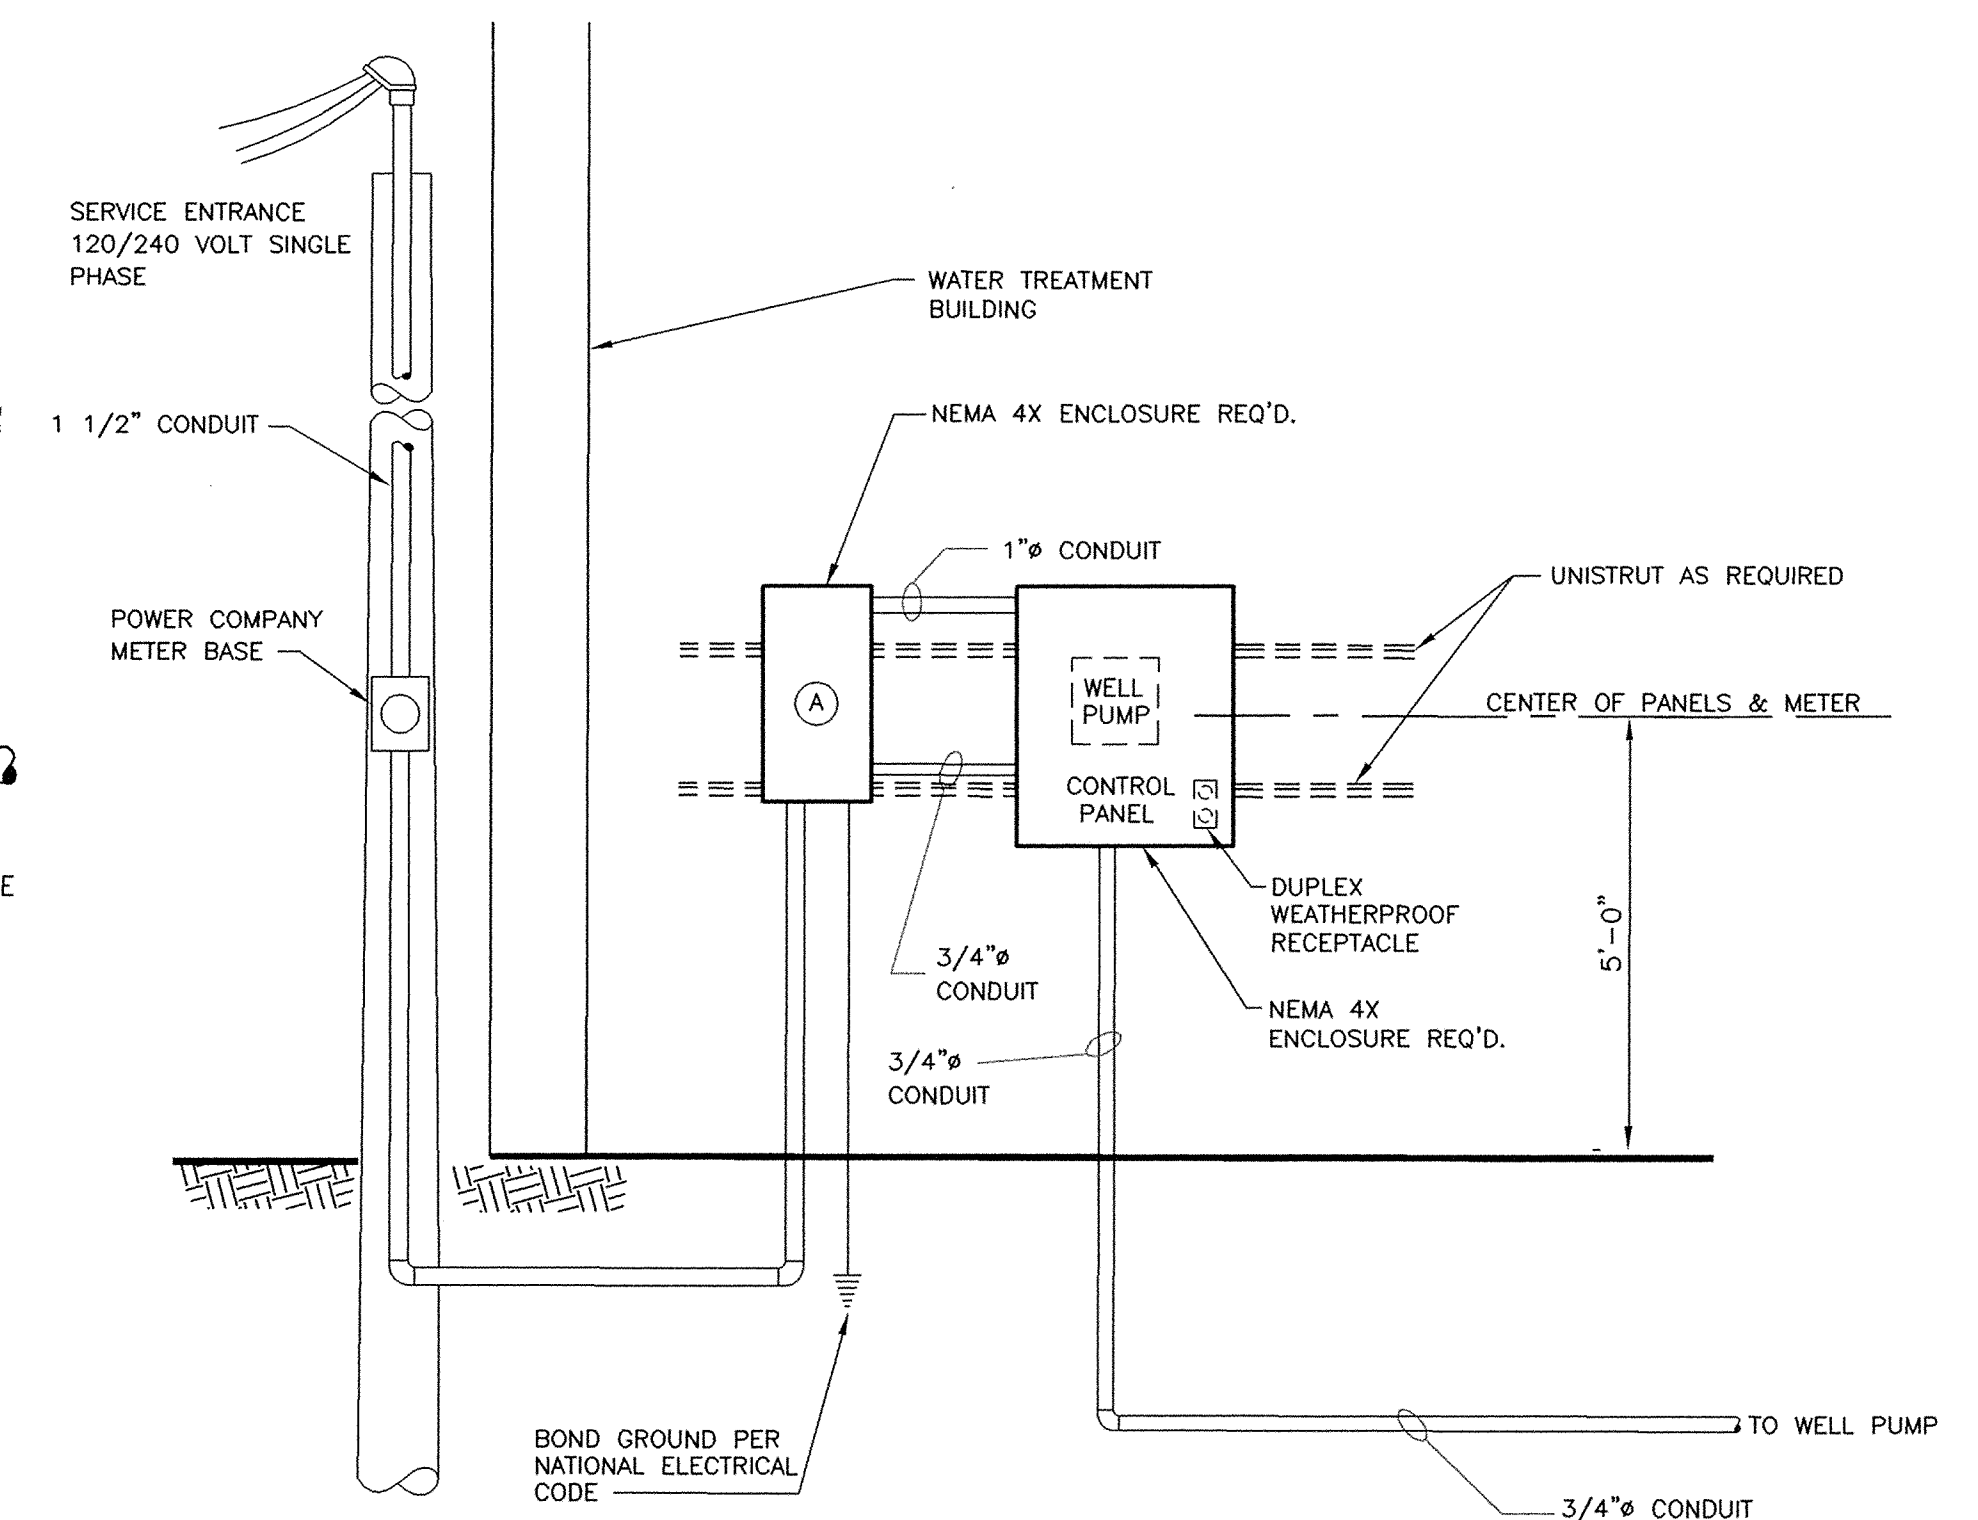


④ ELECTRICAL/STRUCTURAL PUMP CONTROL CENTER
NOT TO SCALE

WELL PUMP SCHEDULE

NUMBER	TYPE	FLOW 1	TDH 1	FLOW 2	TDH 2	STAGES	VOLTS/PHASE	H.P.	R.P.M.
WELL PUMP 1	SUBMERSIBLE	28	454	33	274	25	240/1	5	3500
WELL PUMP 2	SUBMERSIBLE	27	465	33	280	25	240/1	5	3500

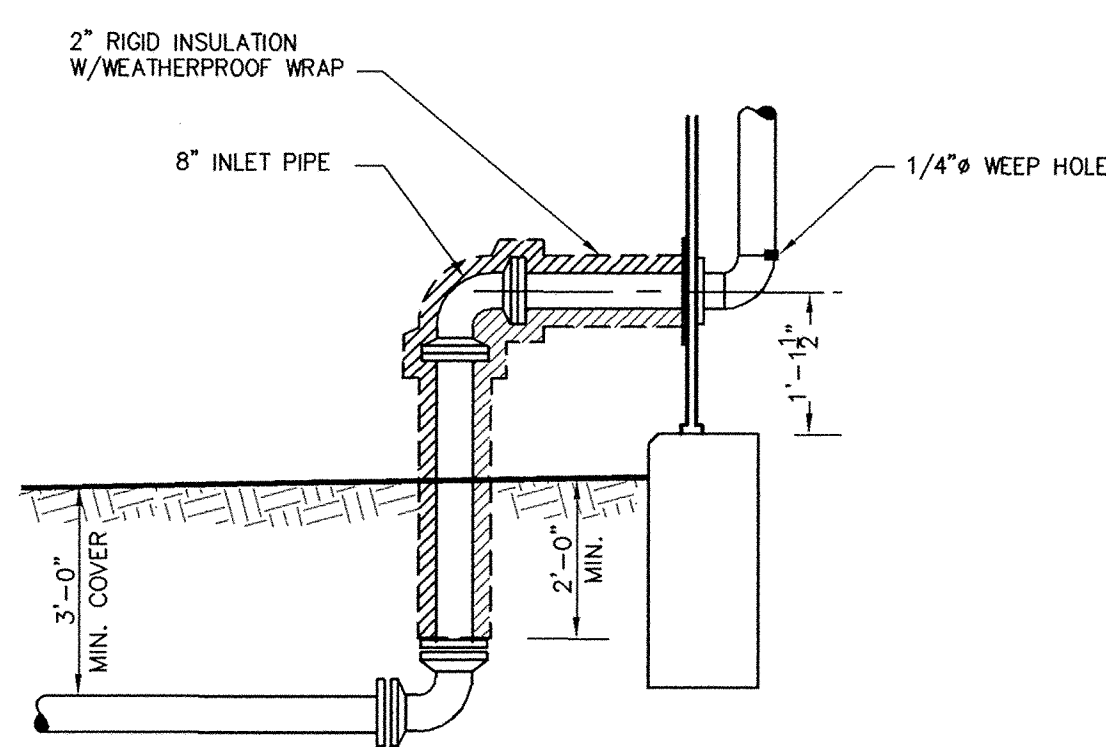


② DETAIL - INLET PIPE
NOT TO SCALE

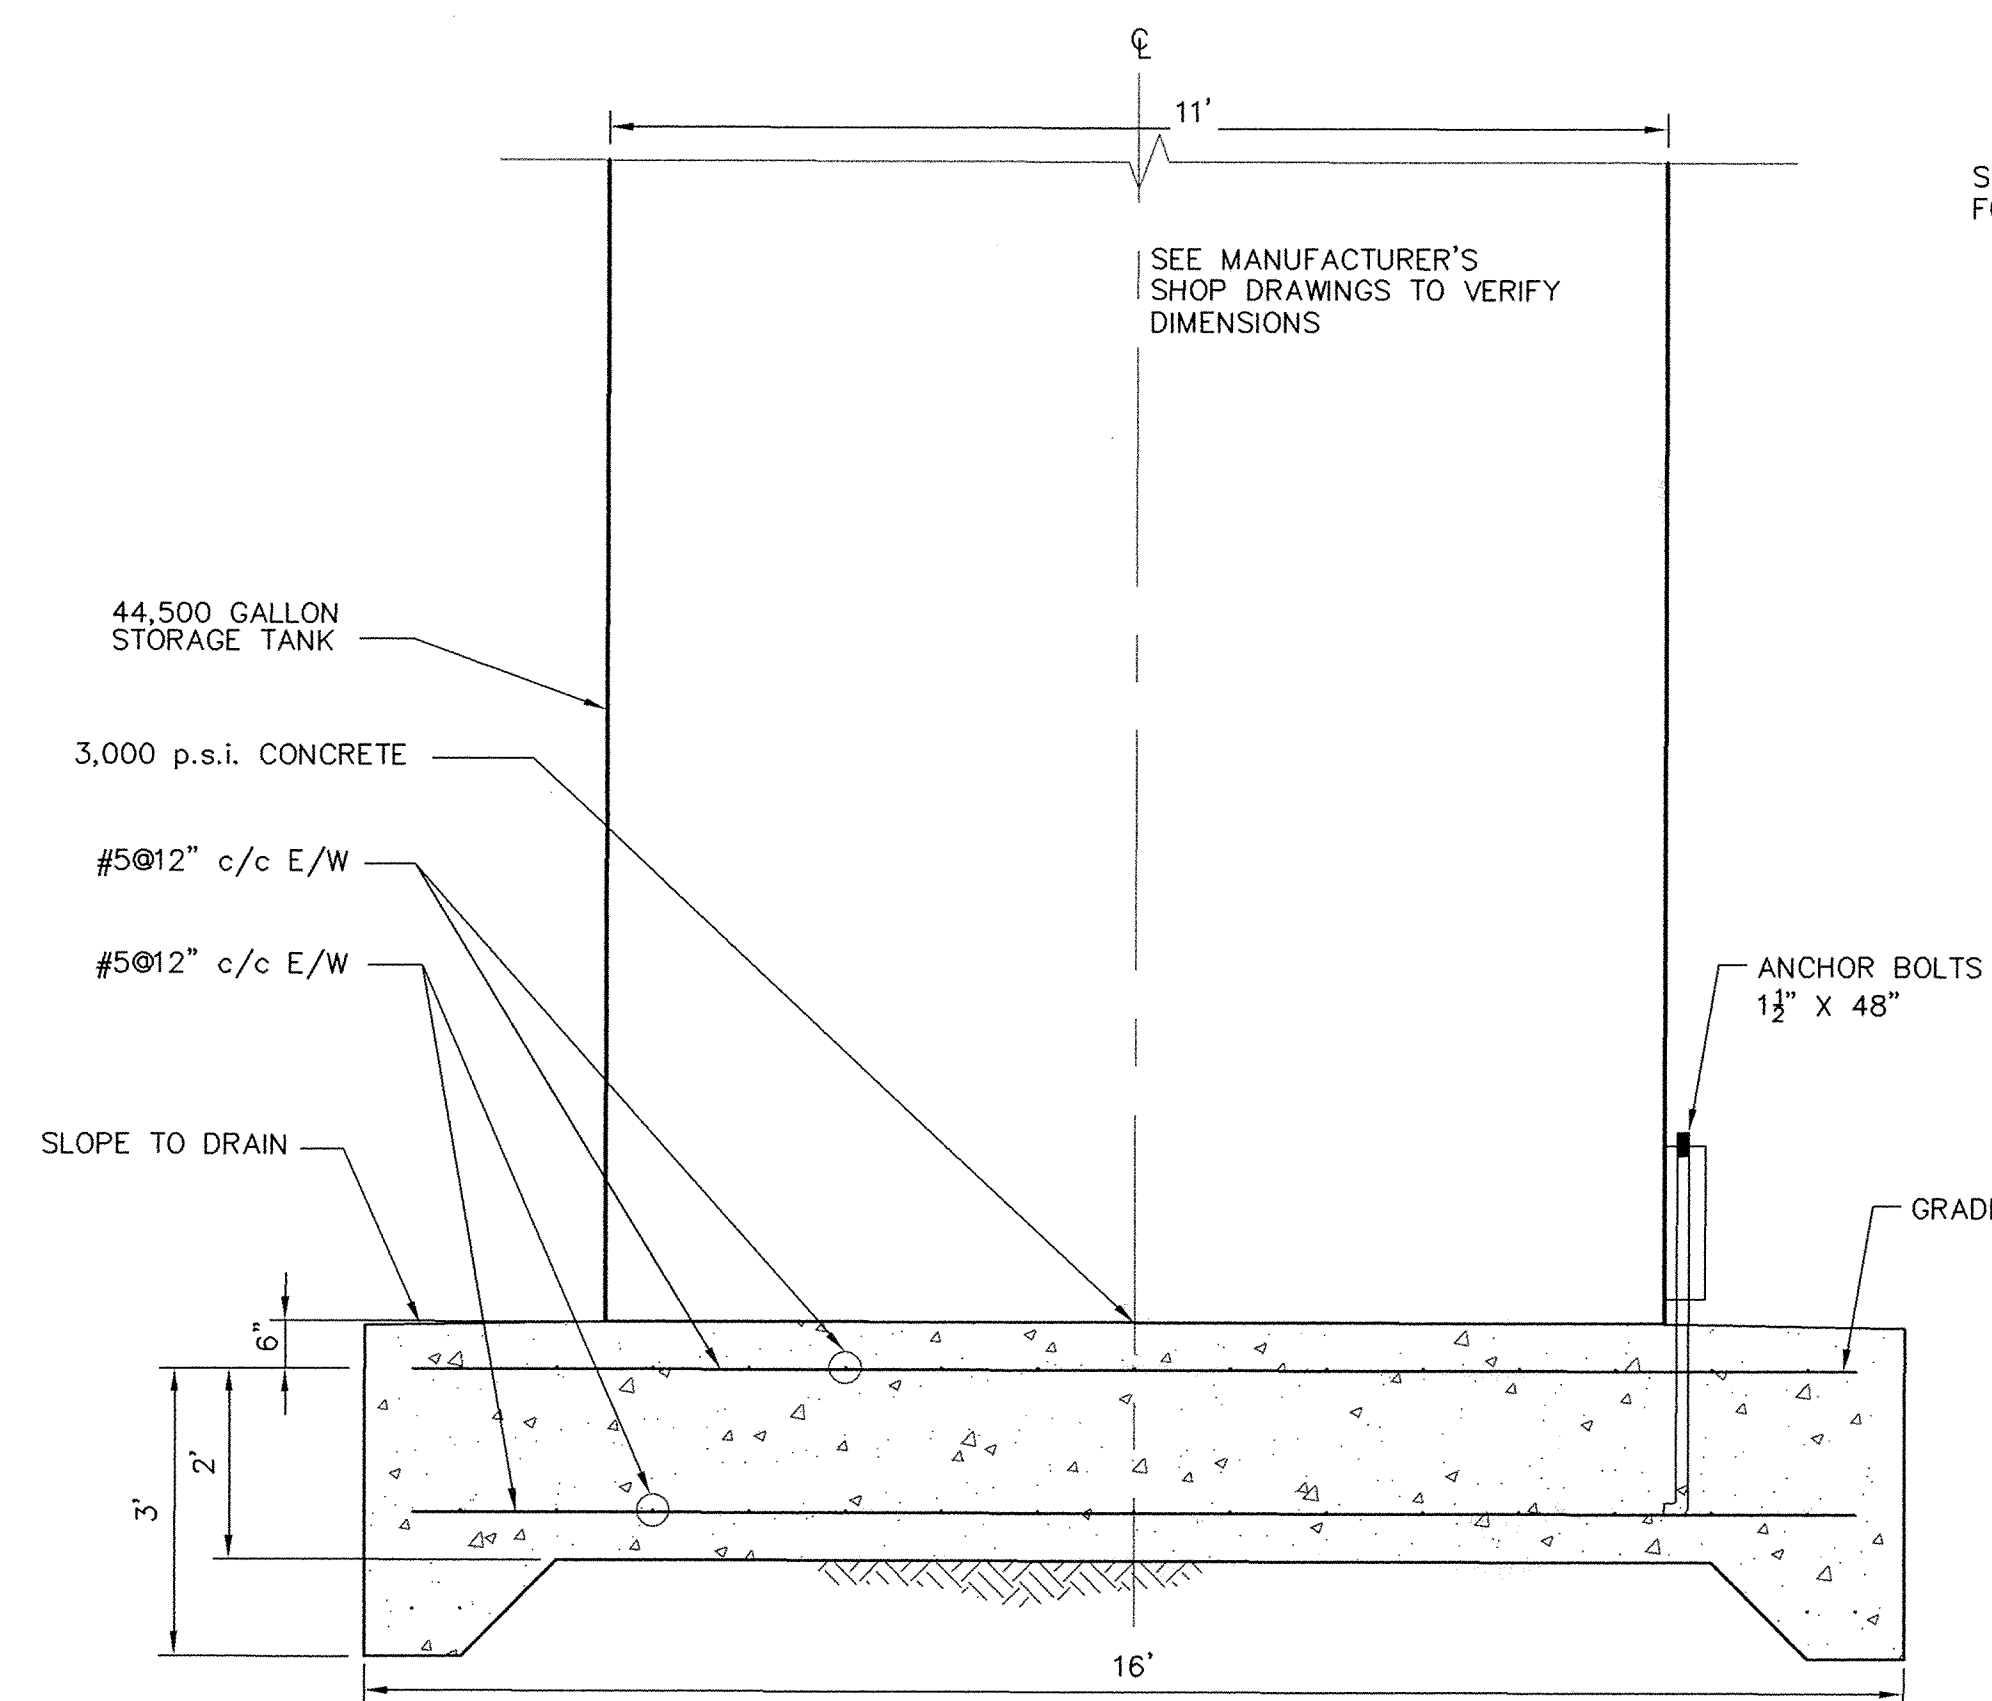


STORAGE TANK FOUNDATION

STORAGE TANK
FOUNDATION REINFORCING

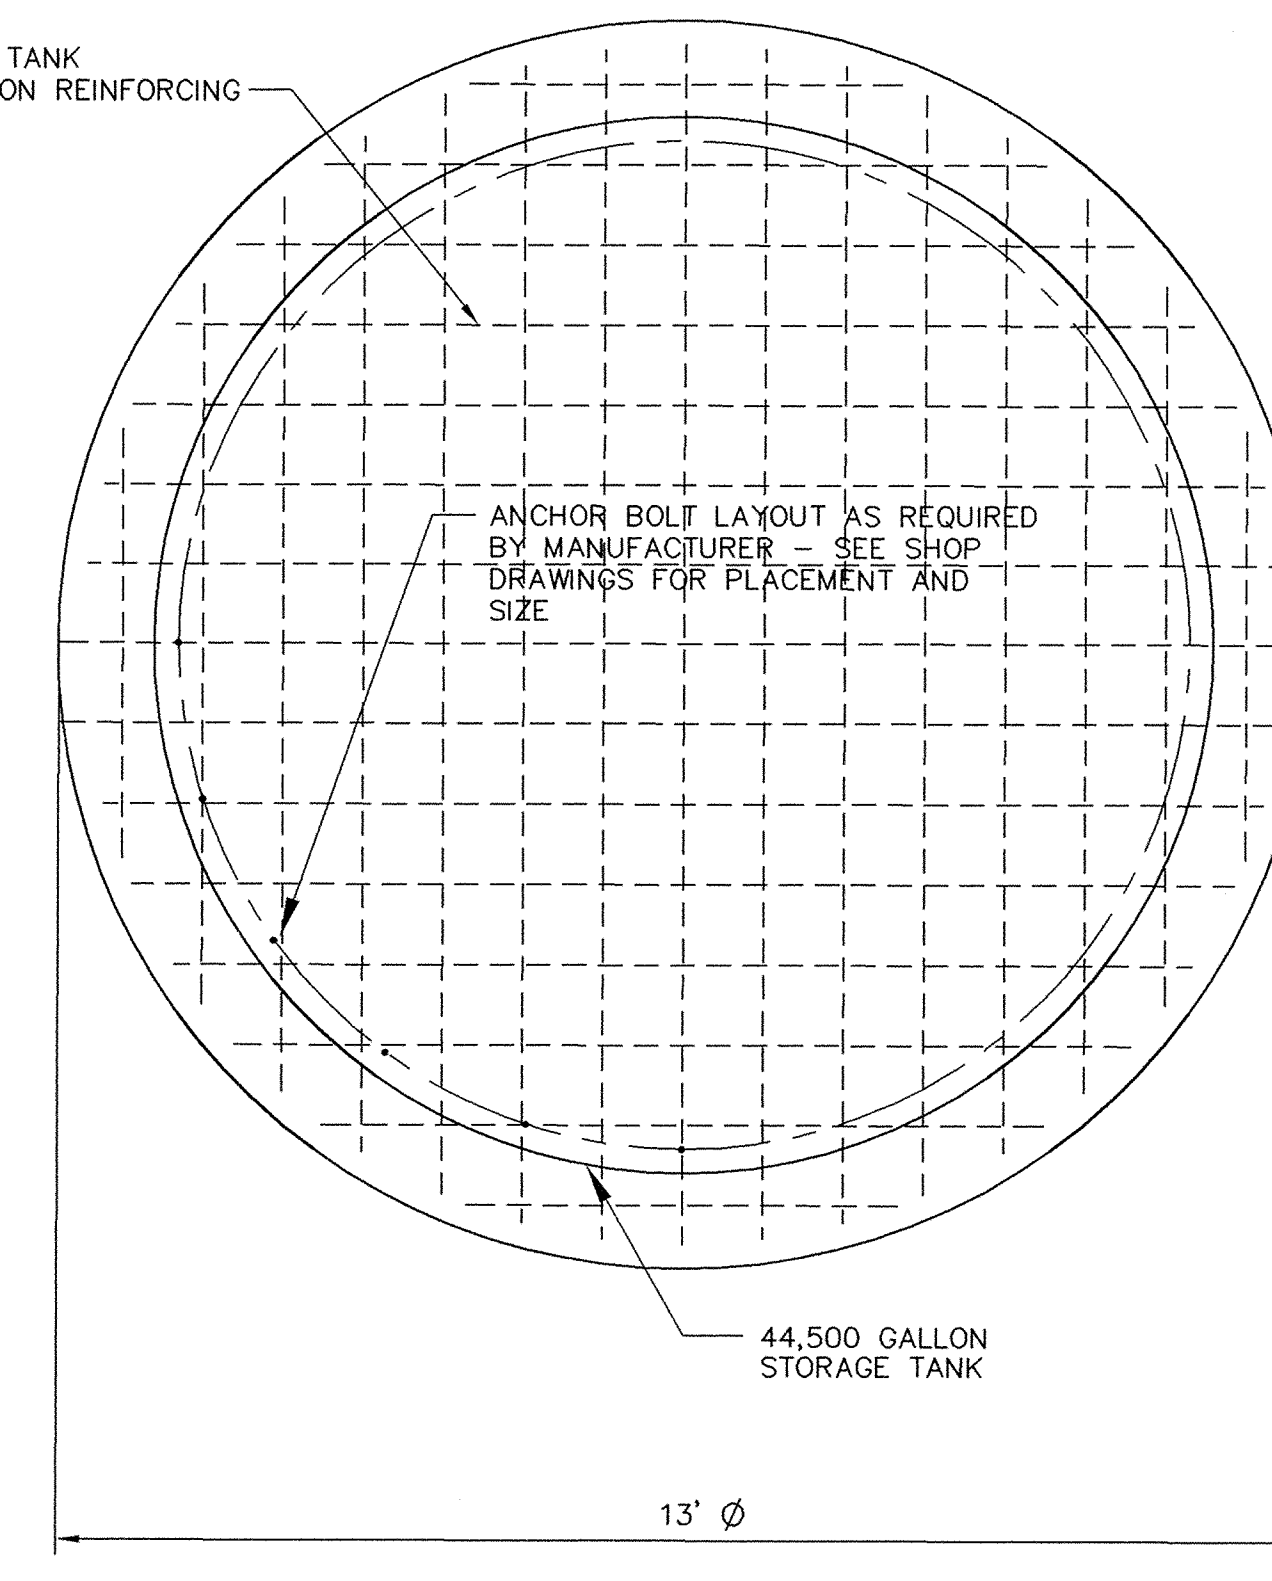

PLAN

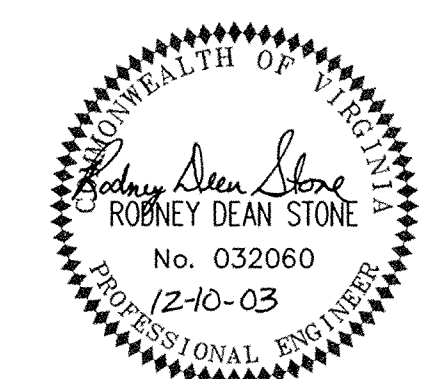

STORAGE TANK AND WELLS
DETAILS
COMPASS COVE
WATER DISTRIBUTION SYSTEM
DEVELOPED BY: WINDSTAR PROPERTIES, L.L.C.
GILLS CREEK MAGISTERIAL DISTRICT
FRANKLIN COUNTY, VIRGINIA
JULY 15, 2003
REVISED: DECEMBER 10, 2003
SHEET 12 OF 15

1/2" = 1'-0"